


1 PLAN
P0002 1:20

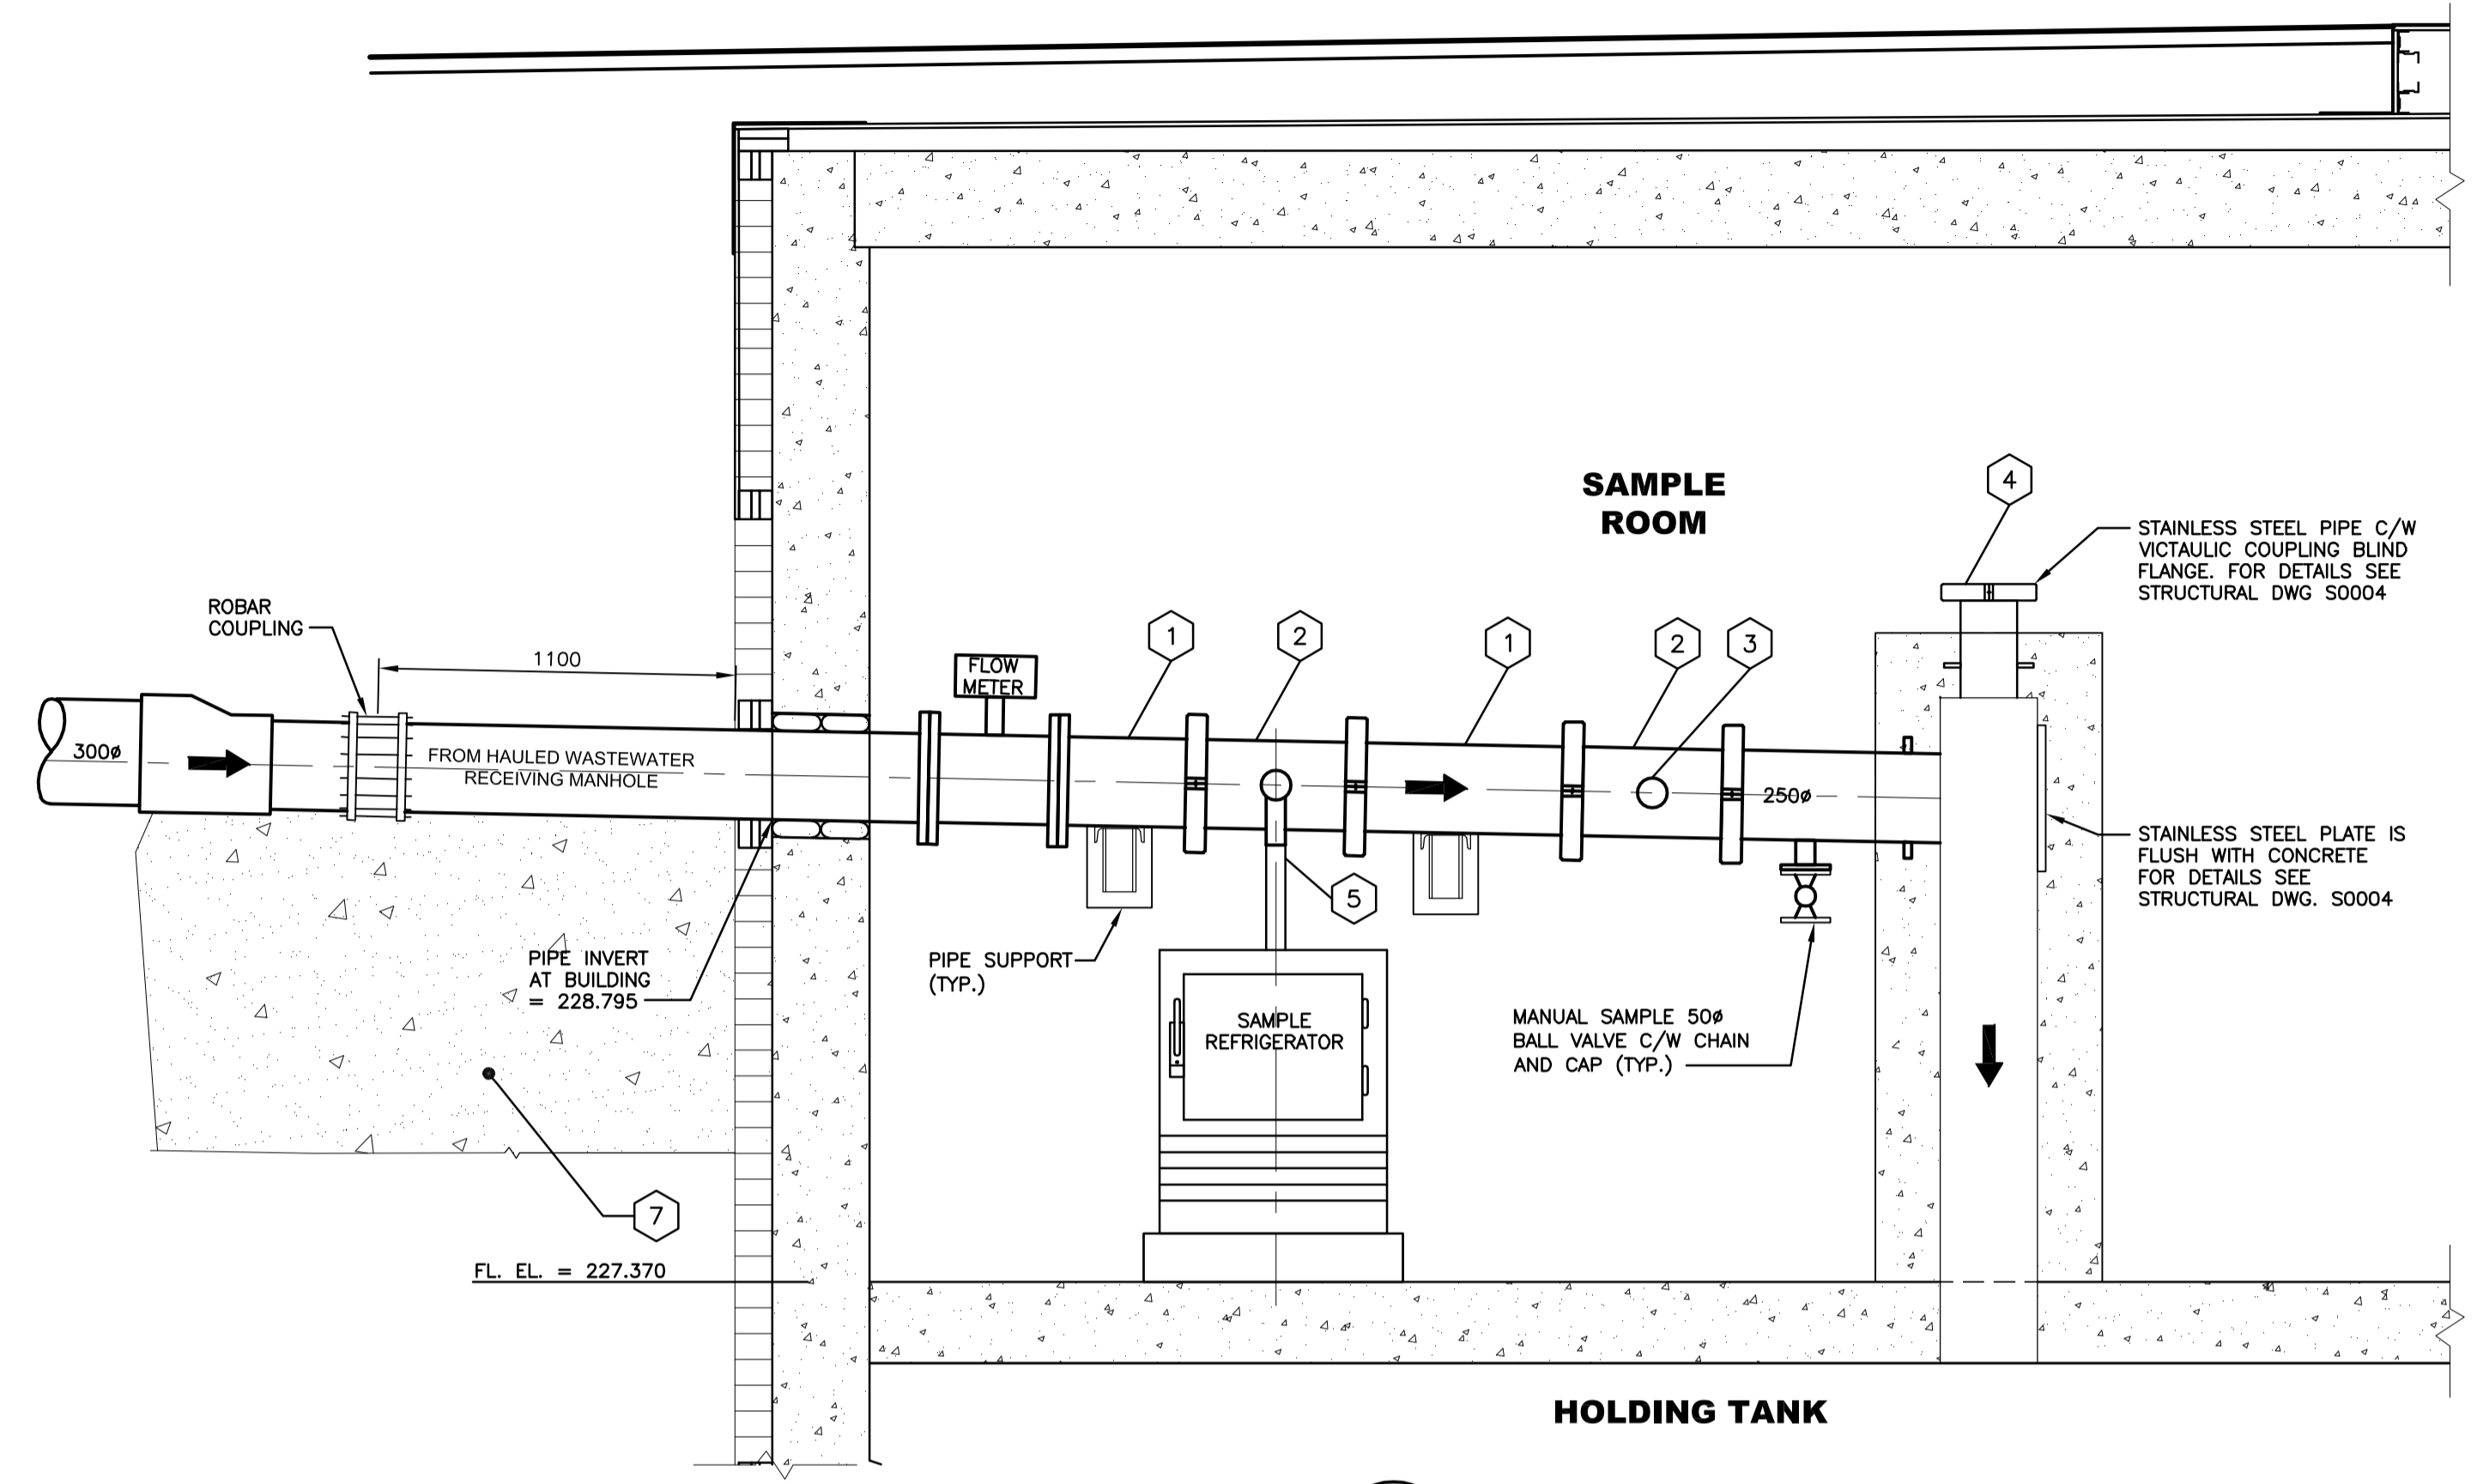

A SECTION
P0002 1:20

- NOTE:**
- 1 ALL PIPE TO BE IPS TYPE 316L STAINLESS STEEL --SCHEDULE 10S AS PER ASTM A778
 - 2 MANUFACTURED IPS TYPE 316L STAINLESS STEEL SPOOL PIECE WITH ADAPTER SADDLE FOR ISOLOK SAMPLING INSTRUMENT
 - 3 PROVIDE GASKETED CAP FOR SPOOL PIECE
 - 4 VICTAULIC STYLE 489 STAINLESS STEEL RIGID COUPLING
 - 5 CLEAR POLYVINYL TUBING
 - 6 50mm ϕ INSULATED IPS TYPE 316L STAINLESS STEEL
 - 7 LEAN MIX CONCRETE FILL REFER TO STRUCTURAL DRAWING S0007

METRIC
WHOLE NUMBERS INDICATE MILLIMETRES
DECIMALIZED NUMBERS INDICATE METRES

APEGM
Certificate of Authorization
Stantec Consulting Ltd.
No. 1301 Date: _____

LOCATION APPROVED UNDERGROUND STRUCTURES		B.M. ELEV.
SUPV. U/G STRUCTURES COMMITTEE	DATE	
NOTE: LOCATION OF UNDERGROUND STRUCTURES AS SHOWN ARE BASED ON THE BEST INFORMATION AVAILABLE BUT NO GUARANTEE IS GIVEN THAT ALL EXISTING UTILITIES ARE SHOWN OR THAT THE GIVEN LOCATIONS ARE EXACT. CONFIRMATION OF EXISTENCE AND EXACT LOCATION OF ALL SERVICES MUST BE OBTAINED FROM THE INDIVIDUAL UTILITIES BEFORE PROCEEDING WITH CONSTRUCTION.		
A	ISSUED FOR TENDER	10.02.16 A.H.B.
NO.	REVISIONS	DATE BY

Stantec Consulting Ltd.
905 Waverley Street, Winnipeg, Manitoba
Tel 204-489-5900 Fax 204-453-9012

DESIGNED BY	A.H.B.	CHECKED BY	E.W.
DRAWN BY	K.R.	APPROVED BY	A.H.B.
HOR. SCALE:	AS NOTED	RELEASED FOR CONSTRUCTION:	
VERTICAL:		DATE	09.11.10

THE CITY OF WINNIPEG
WATER AND WASTE DEPARTMENT

Winnipeg

SOUTH END WATER POLLUTION CONTROL CENTRE
HAULED WASTEWATER RECEIVING FACILITIES
HAULED WASTEWATER RECEIVING BUILDING
SAMPLE ROOM FLOOR PLAN AND SECTION

TENDER NO.	822-2009	CITY DRAWING NUMBER	I-0102A-P0002-001	SHEET OF	2 OF 3
------------	----------	---------------------	-------------------	----------	--------

W:\1170\winnipeg\117018302\winnipeg\117018302\working\sheet_files\process\winnipeg\117018302-102-wm-fp.dwg
 2010-02-16 08:48:44 By: j.mohr