



D SIZE 22" x 34" (559mm x 864mm)

PLOT: 10/02/10 8:27:37 AM

AECOM REVIEW DRFT CHK KMB  
AECOM FILE NAME: D265-250-00\_01-C-1002\_RX.dwg Saved By: [unreadable]

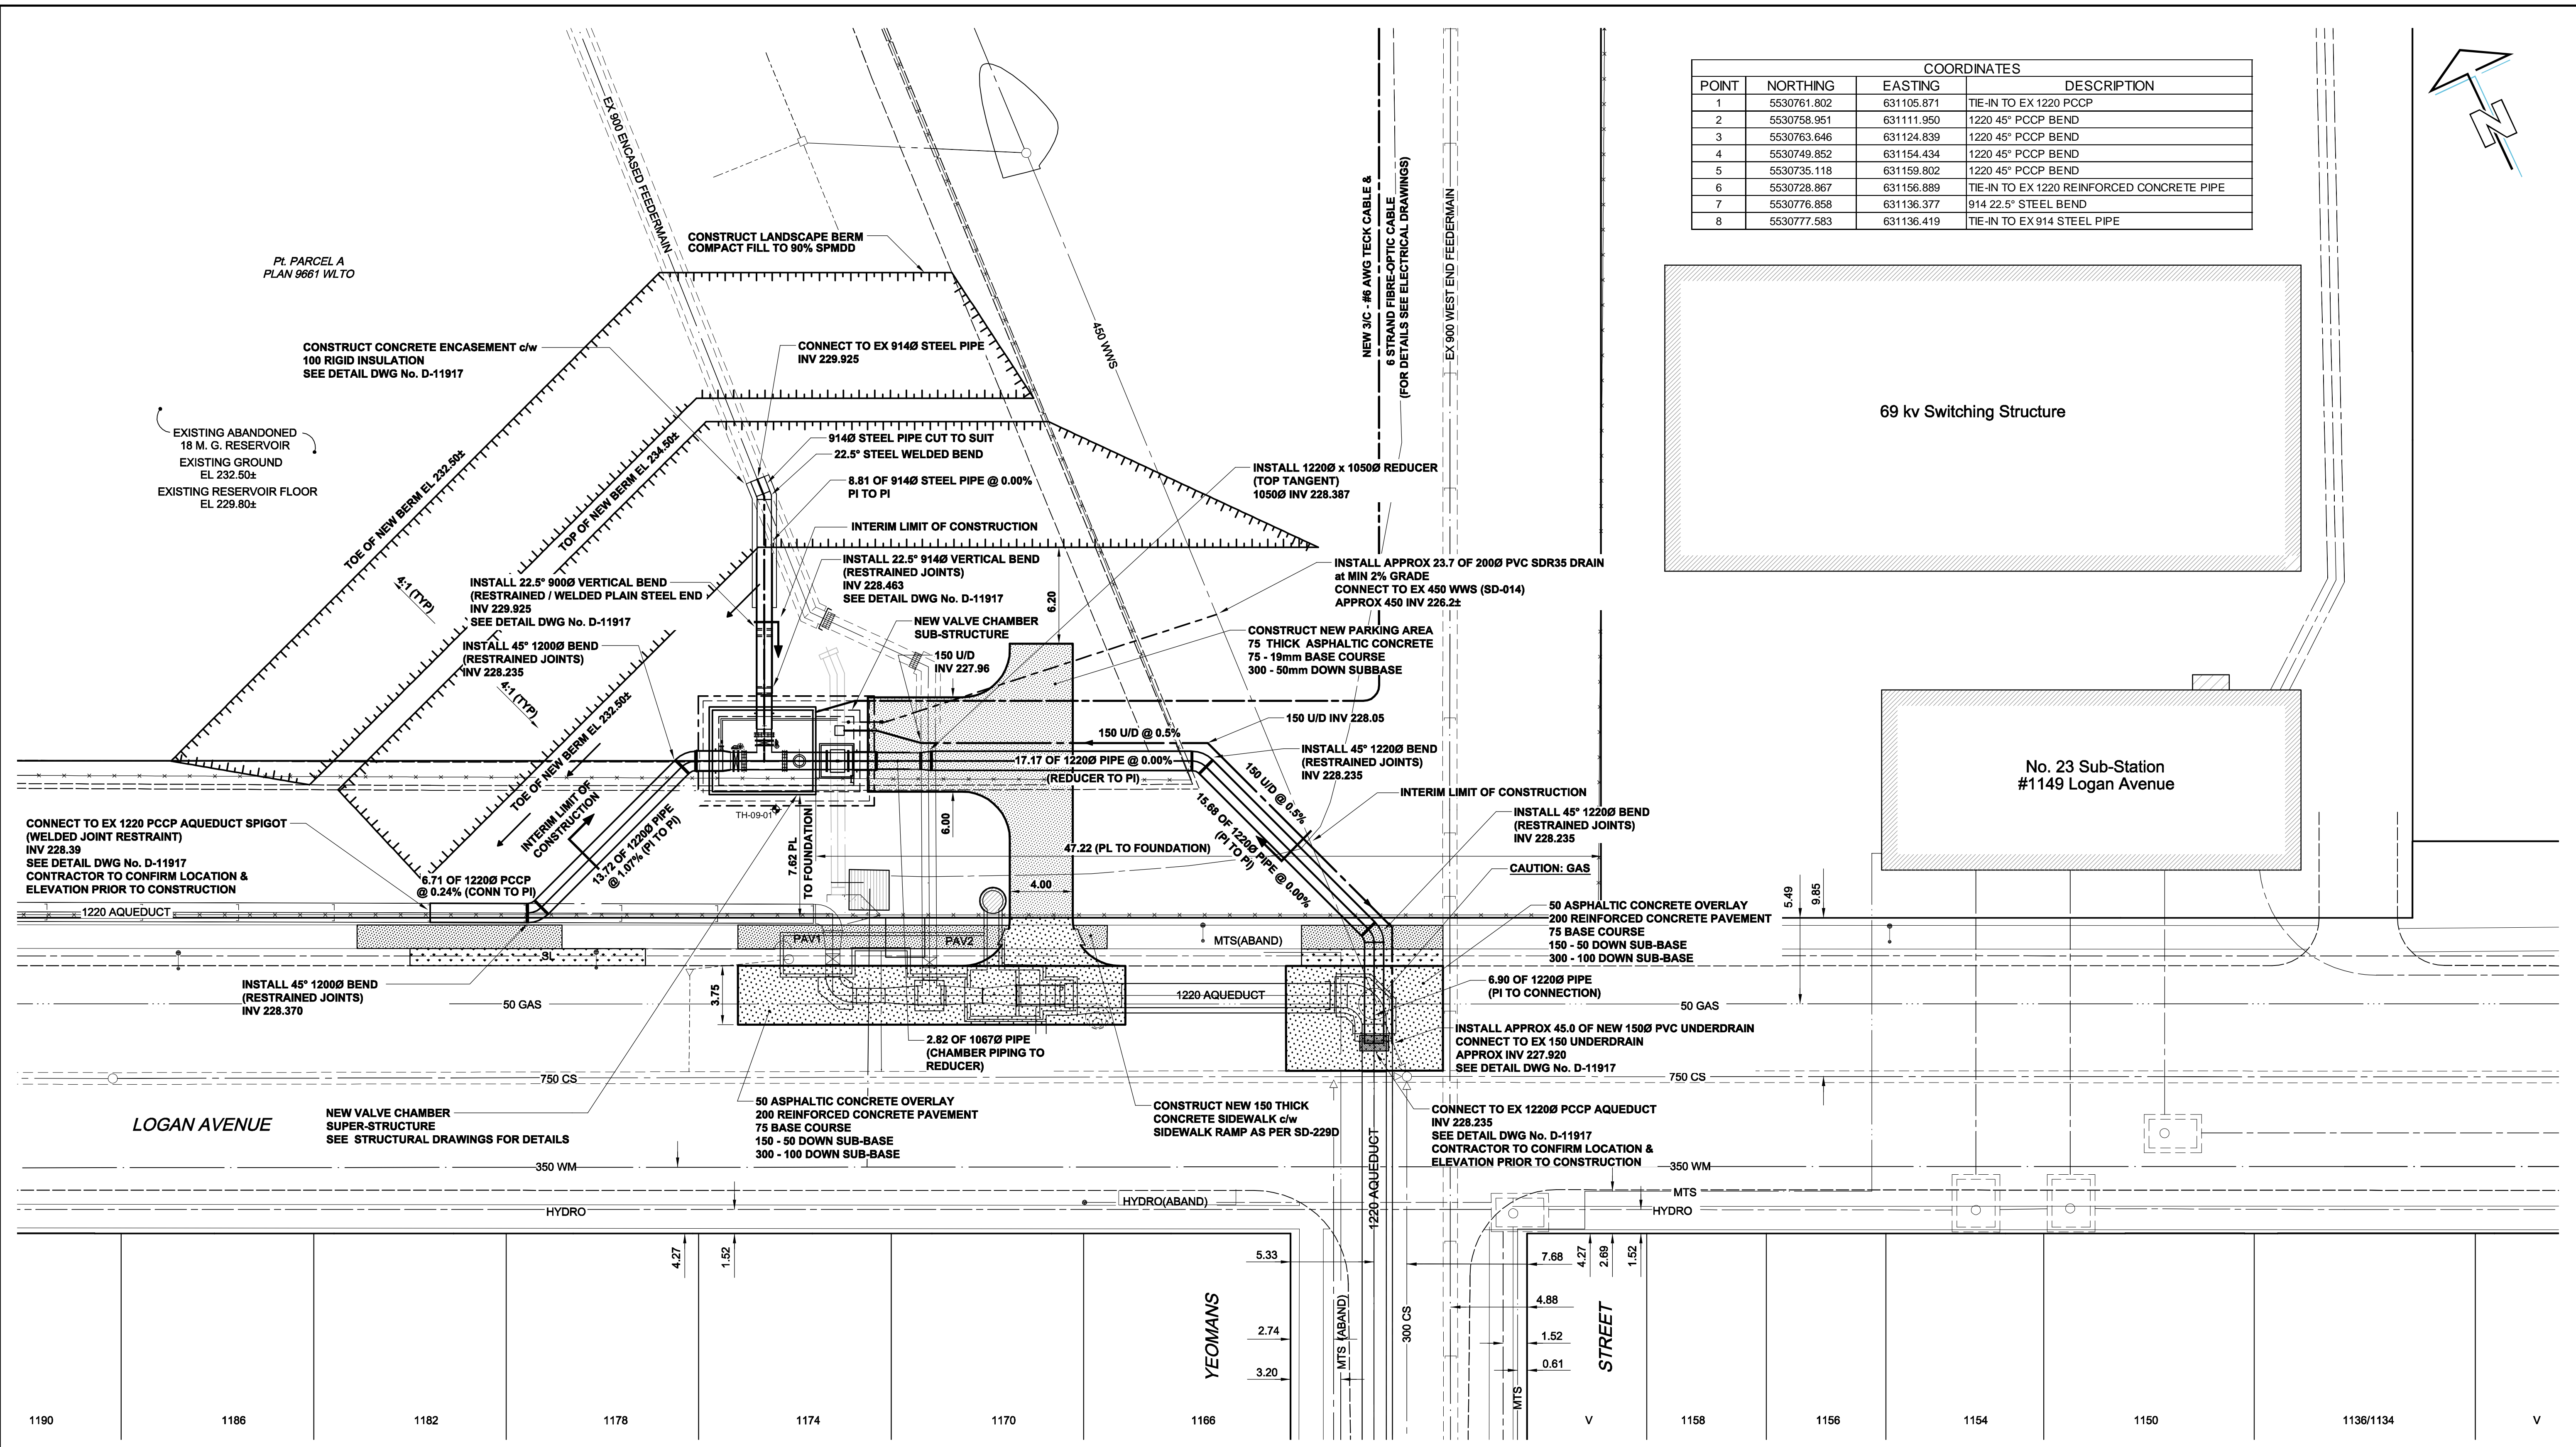

COORDINATES			
POINT	NORTHING	EASTING	DESCRIPTION
1	5530761.802	631105.871	TIE-IN TO EX 1220 PCCP
2	5530758.951	631111.950	1220 45° PCCP BEND
3	5530763.646	631124.839	1220 45° PCCP BEND
4	5530749.852	631154.434	1220 45° PCCP BEND
5	5530735.118	631159.802	1220 45° PCCP BEND
6	5530728.867	631156.889	TIE-IN TO EX 1220 REINFORCED CONCRETE PIPE
7	5530776.858	631136.377	914 22.5° STEEL BEND
8	5530777.583	631136.419	TIE-IN TO EX 914 STEEL PIPE

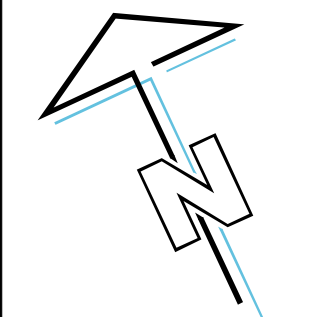

**LOCATION APPROVED UNDERGROUND STRUCTURES**

SUPR. U/G STRUCTURES DATE COMMITTEE  
NOTE: LOCATION OF UNDERGROUND STRUCTURES AS SHOWN ARE BASED ON THE BEST INFORMATION AVAILABLE. BUT NO GUARANTEE IS GIVEN THAT ALL EXISTING UTILITIES ARE SHOWN OR THAT THE GIVEN LOCATIONS ARE EXACT. CONFIRMATION OF EXISTENCE AND EXACT LOCATION OF ALL SERVICES MUST BE OBTAINED FROM THE INDIVIDUAL UTILITIES BEFORE PROCEEDING WITH CONSTRUCTION.



DESIGNED BY: MGM/ADB  
CHECKED BY: M. McDonald  
DRAWN BY: WJd/ADL  
APPROVED BY: Bryan Weber  
HOR. SCALE: 1:200  
VERT. SCALE: -  
DATE: 10/02/09  
RELEASED FOR CONSTRUCTION: K. Zurek  
DATE: Feb 9/10

PROFESSIONAL'S SEAL  
Revision '0'  
Issued for Construction  
WAS SEALED BY  
C. C. MACEY  
AND DATED  
08 Feb 2010  
CONSULTANT DRAWING NO.  
D265-250-00\_01-C-1002\_RX.dwg

**THE CITY OF WINNIPEG WATER AND WASTE DEPARTMENT**  
Branch 1 Aqueduct Valve Chamber at McPhillips Street Pumping Station  
CIVIL DETAILED SITE PLAN  
SHEET 4 OF 28  
CITY DRAWING NUMBER  
D-11914  
REV 0

BID OPPORTUNITY NO. 16-2010