



DETAIL 17
 D-11923
 SCALE 1:20


NOTE:
 * CONFIRM SIZE AND LOCATION OF PIPE & VALVE SUPPORTS & THRUST BLOCK WITH CONTRACT ADMINISTRATOR PRIOR TO CONSTRUCTION

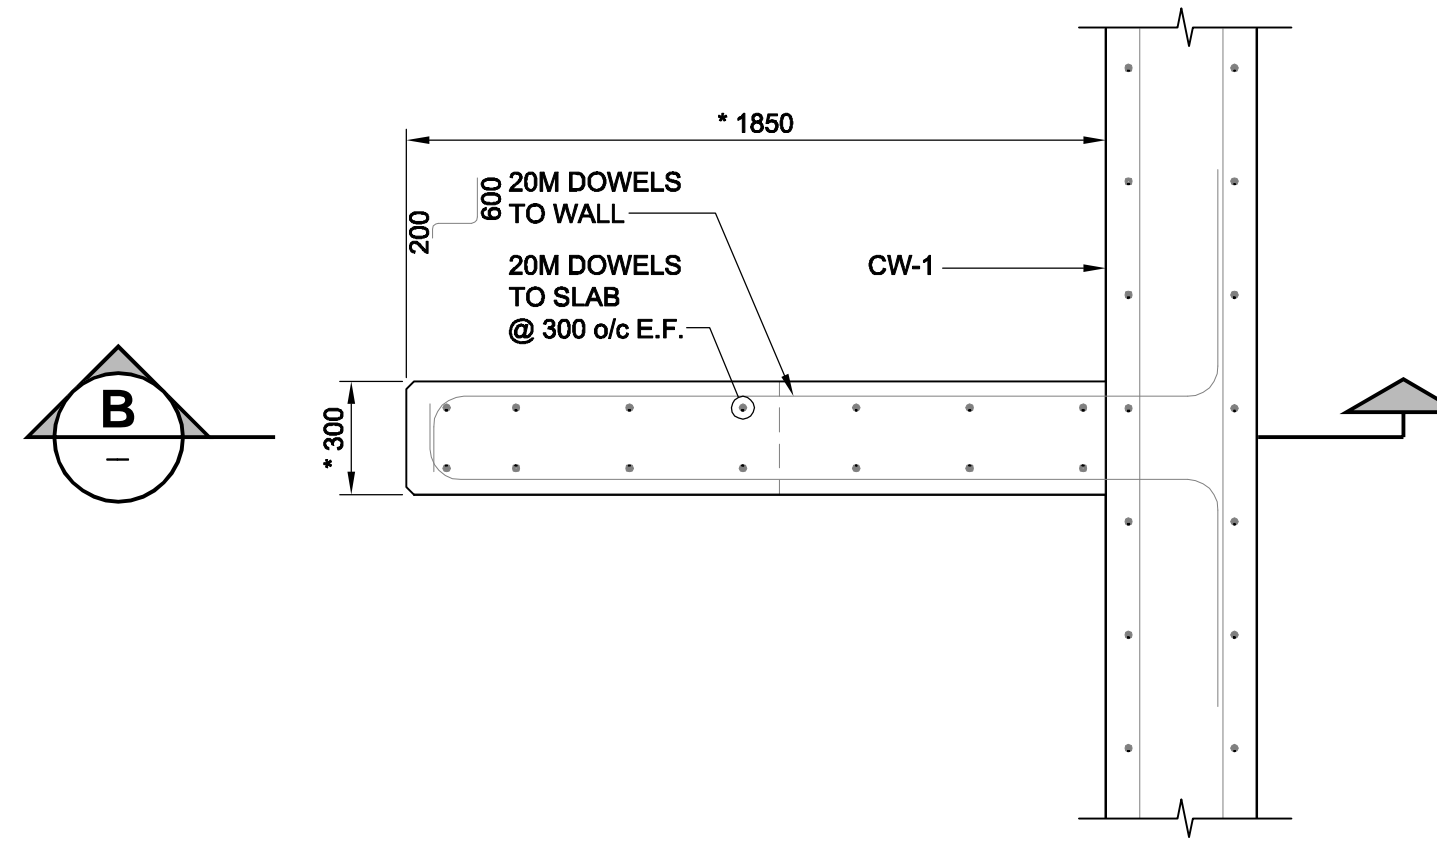


DETAIL 18
 D-11923
 SCALE 1:20

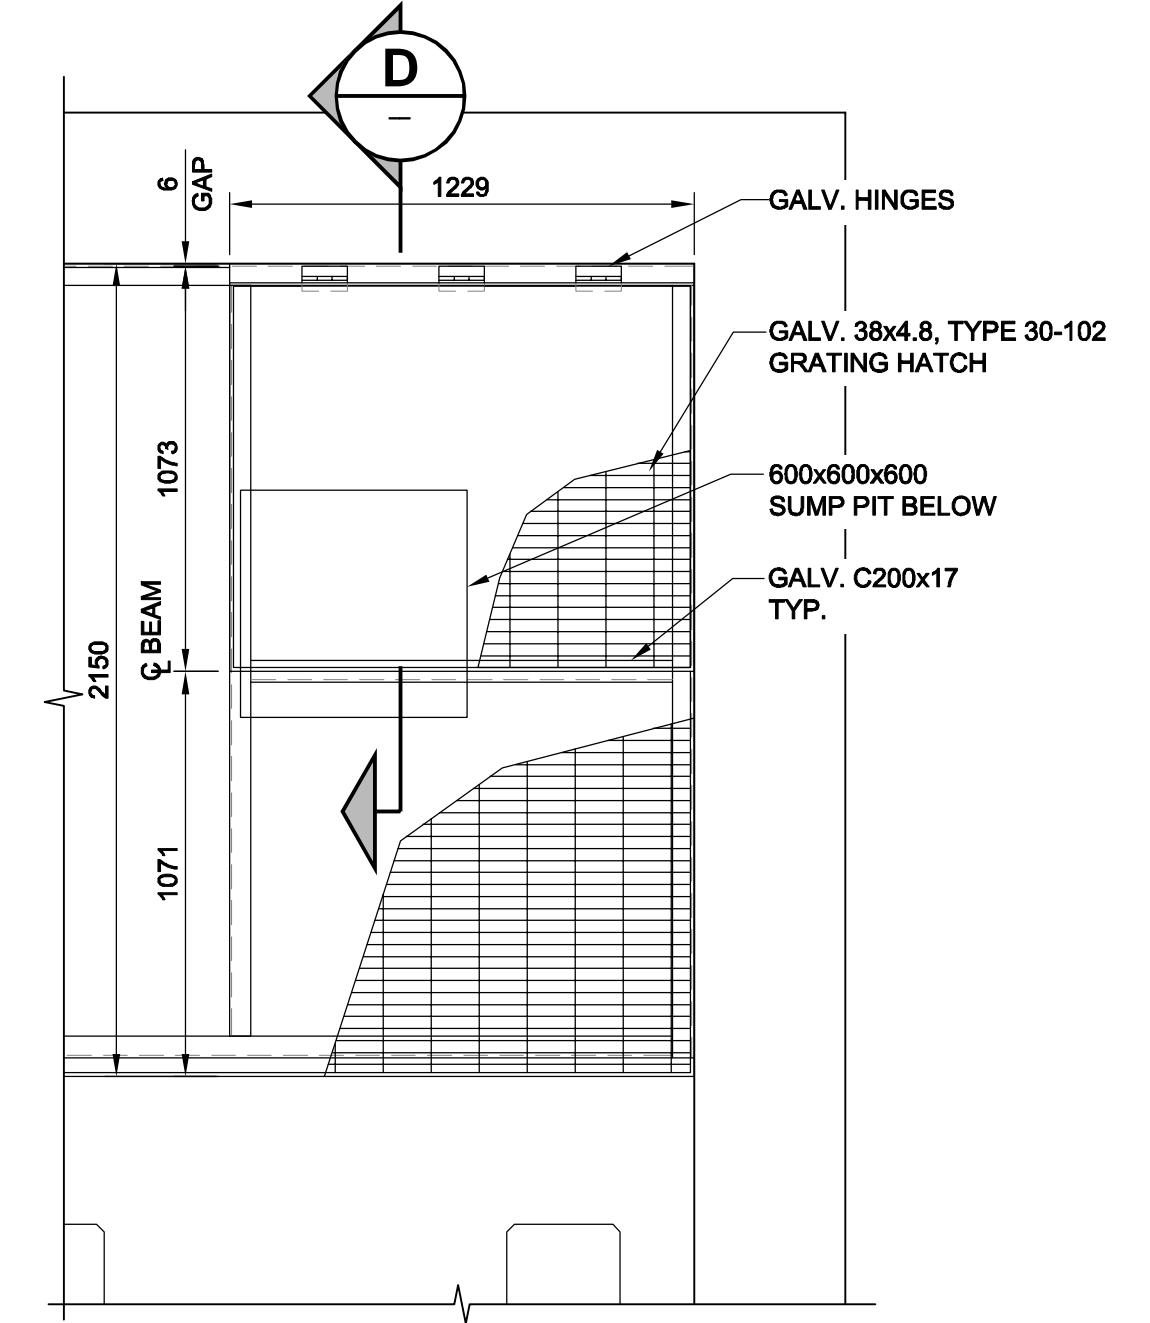


DETAIL 19
 D-11923
 SCALE 1:20

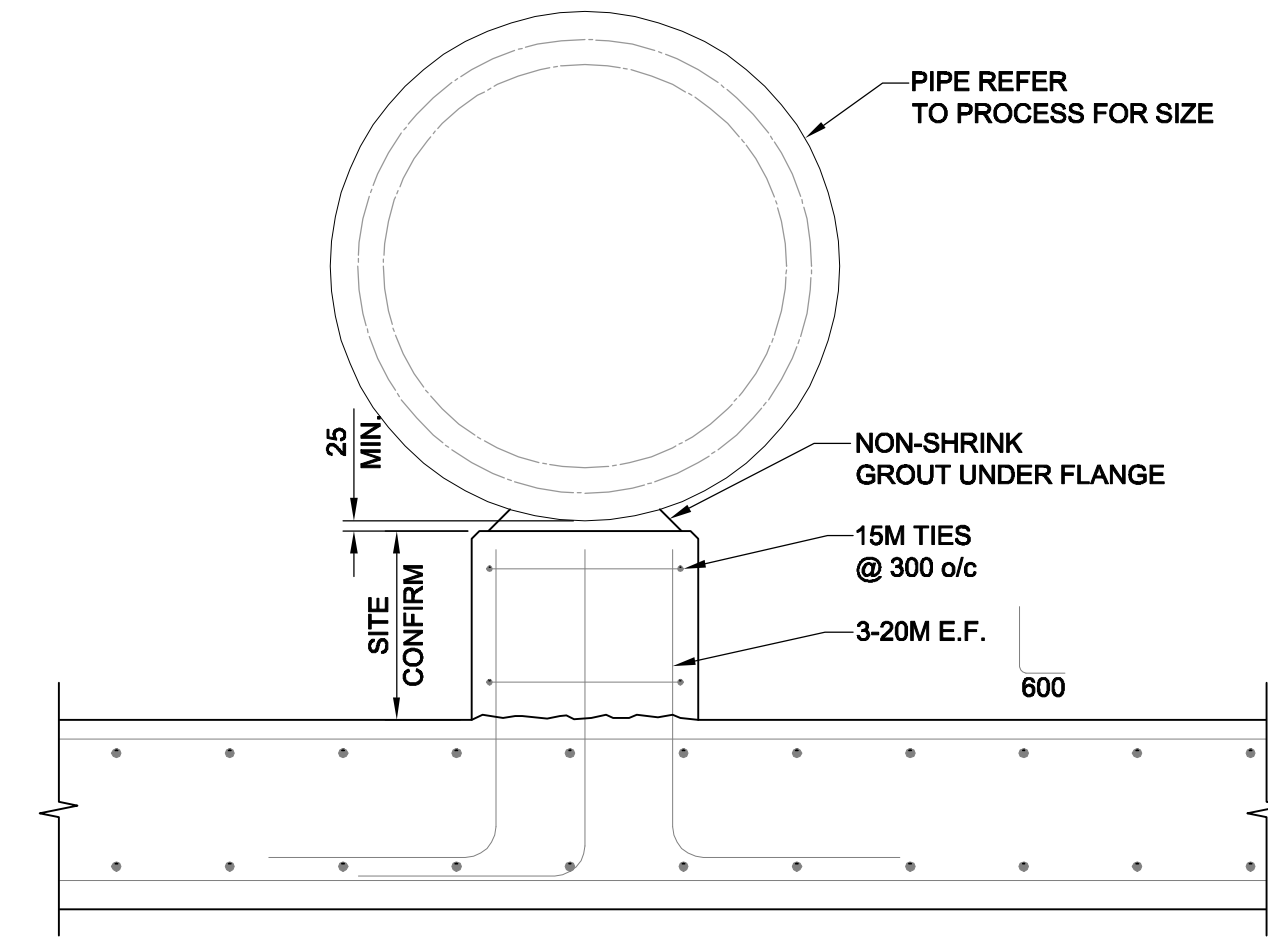

SECTION A
 SCALE 1:20

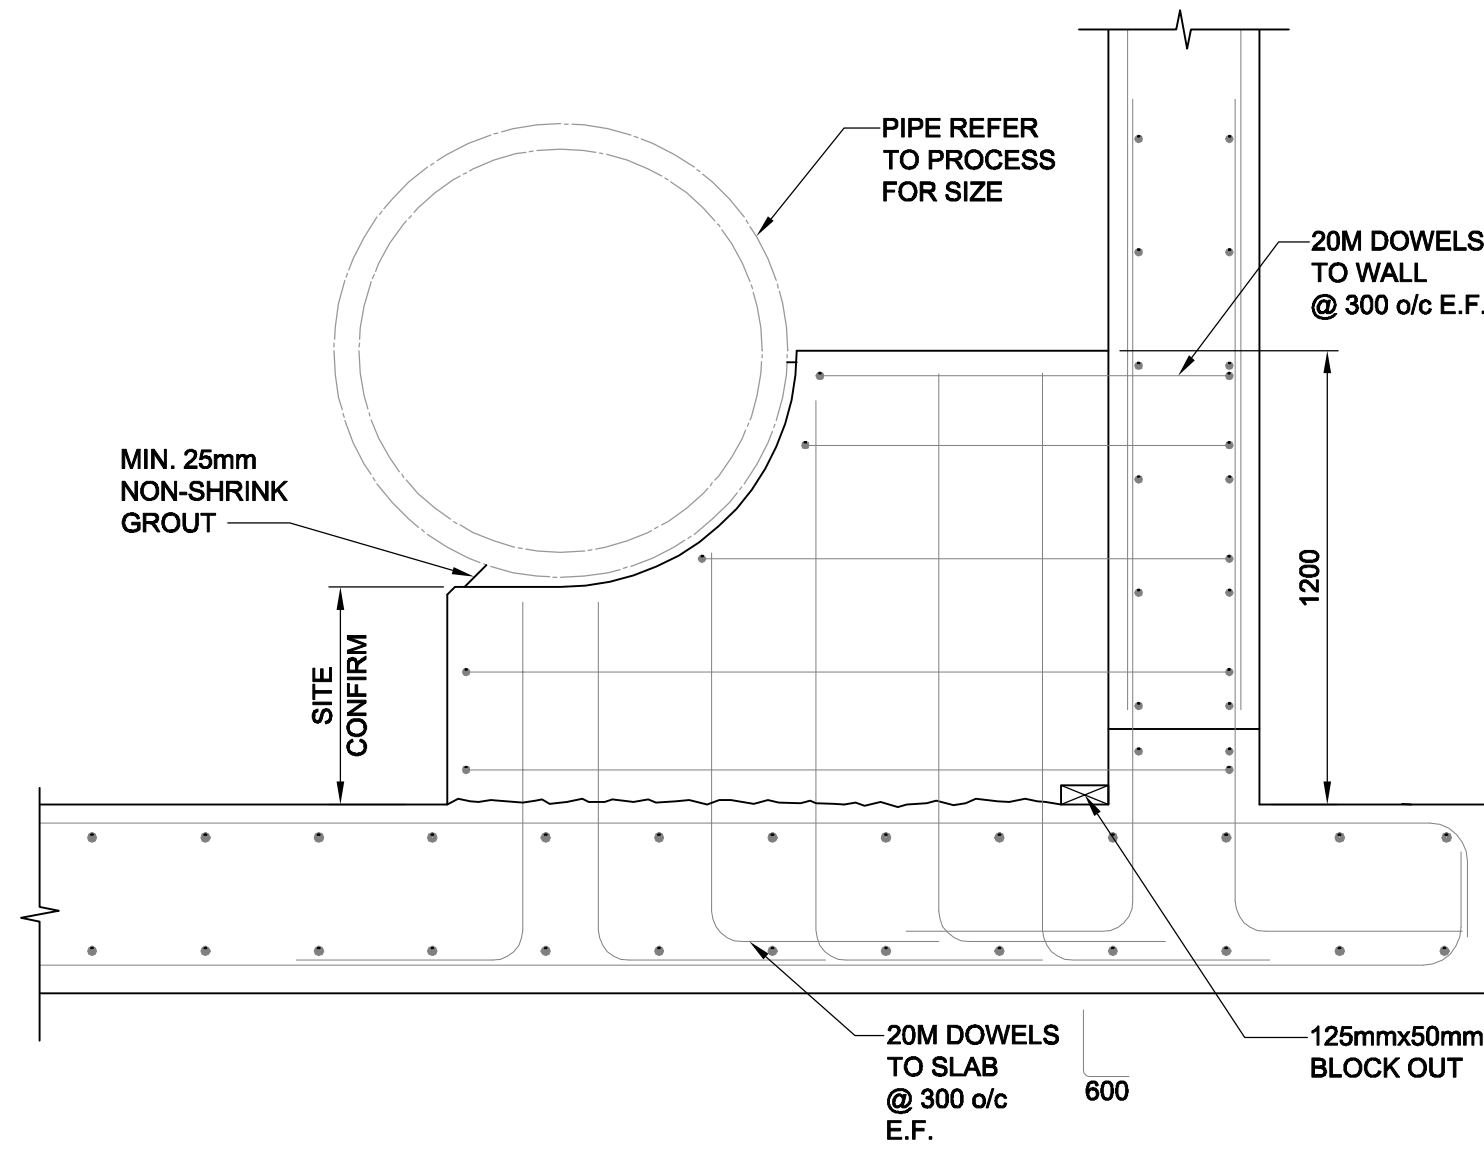

SECTION B
 SCALE 1:20

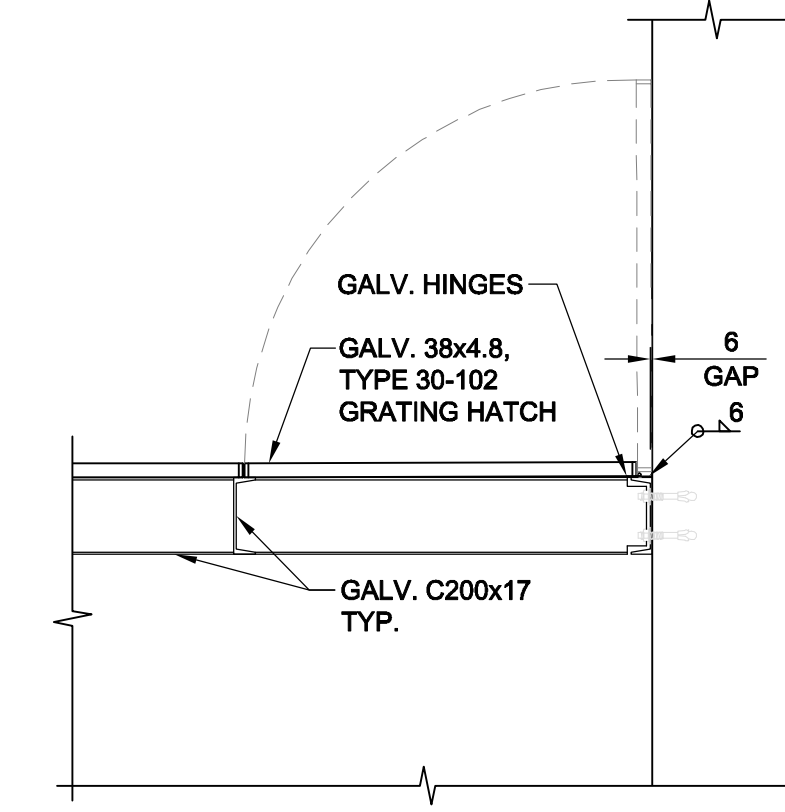

SECTION C
 SCALE 1:20

LOCATION APPROVED UNDERGROUND STRUCTURES

SUPR. U/G STRUCTURES	DATE	COMMITTEE

NOTE:
 LOCATION OF UNDERGROUND STRUCTURES AS SHOWN ARE BASED ON THE BEST INFORMATION AVAILABLE. BUT NO GUARANTEE IS GIVEN THAT ALL EXISTING UTILITIES ARE SHOWN OR THAT THE GIVEN LOCATIONS ARE EXACT. CONFIRMATION OF EXISTENCE AND EXACT LOCATION OF ALL SERVICES MUST BE OBTAINED FROM THE INDIVIDUAL UTILITIES BEFORE PROCEEDING WITH CONSTRUCTION.



AECOM

This drawing has been prepared for the use of AECOM's client and may not be used, reproduced or relied upon by third parties, except as agreed by AECOM and its client, as required by law or for use by governmental reviewing agencies. AECOM accepts no responsibility, and denies any liability whatsoever, to any party that modifies this drawing without AECOM's express written consent. Do not scale this document. All measurements must be obtained from stated dimensions.

DESIGNED BY	KK/GGP	CHECKED BY	GGP
DRAWN BY	KK	APPROVED BY	Bryan Weber
HOR. SCALE	1:40	RELEASED FOR CONSTRUCTION	KZ
VERT. SCALE	-	DATE	FEB. 9/10
DATE	10/02/09		

PROFESSIONAL'S SEAL
 ORIGINAL SIGNED BY
 B.F. ABDUL WAHID
 2010/02/08
 CONSULTANT DRAWING NO.
 D265-250-00_01-S-4003_RX.dwg

THE CITY OF WINNIPEG WATER AND WASTE DEPARTMENT

BRANCH I AQUEDUCT VALVE CHAMBER AT McPHILLIPS STREET PUMPING STATION

STRUCTURAL LOWER LEVEL & PLATFORM FRAMING PLANS

SHEET 21 OF 28	REV 0
CITY DRAWING NUMBER	D-11931

BID OPPORTUNITY NO. 16-2010