




SECTION E-E

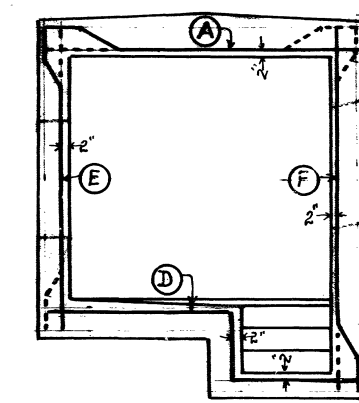


SECTION C-C

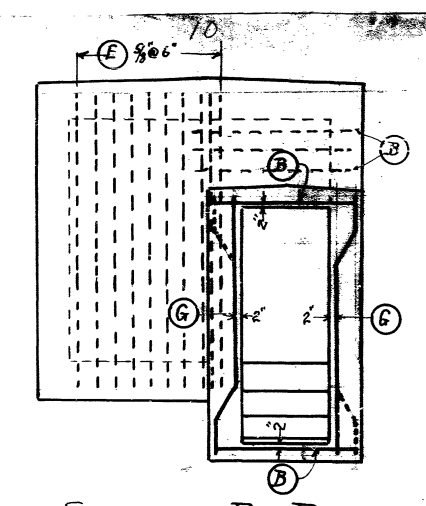



SECTION D-D

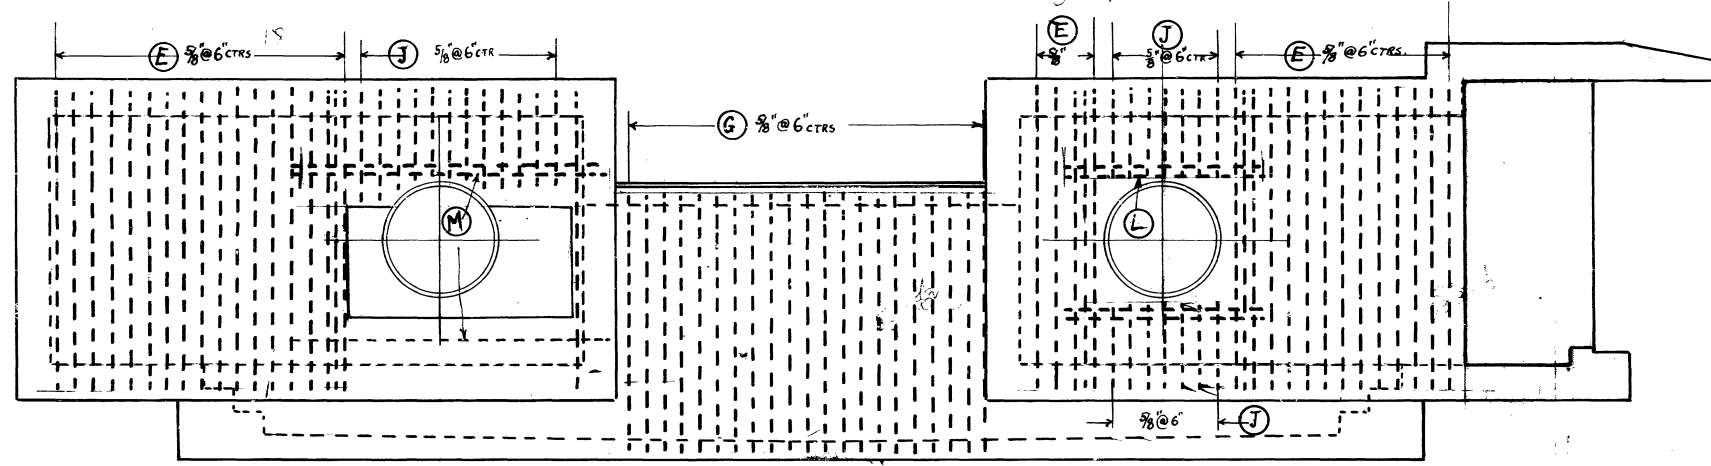


FRONT ELEVATION

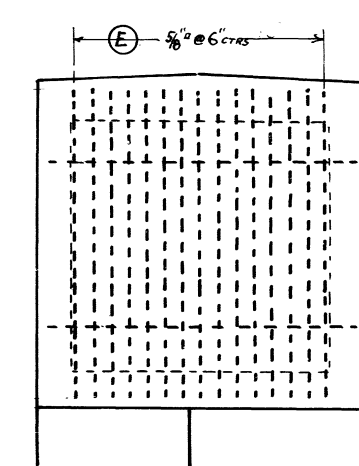

END ELEVATION

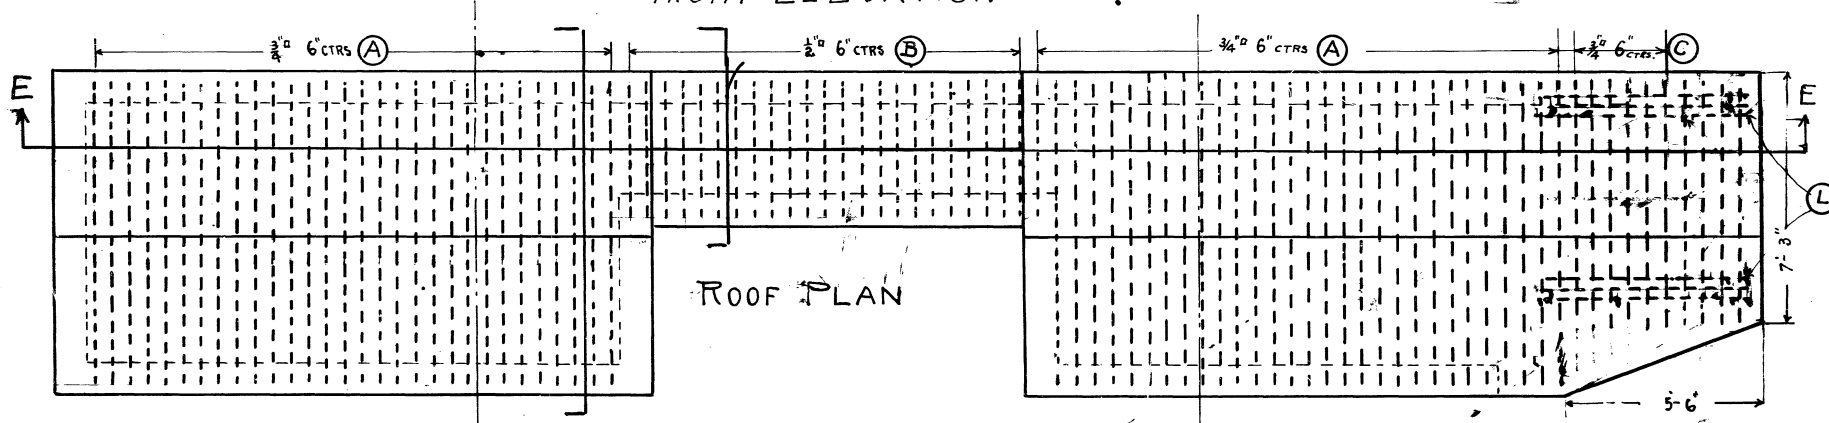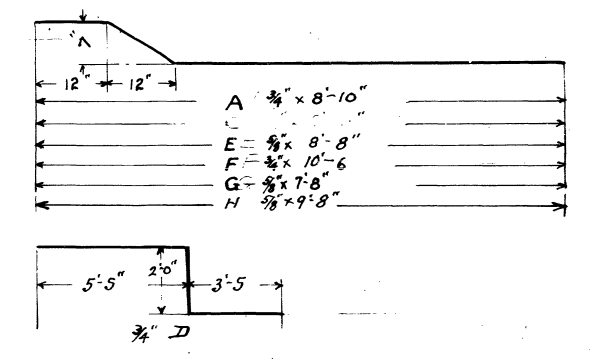

ROOF PLAN

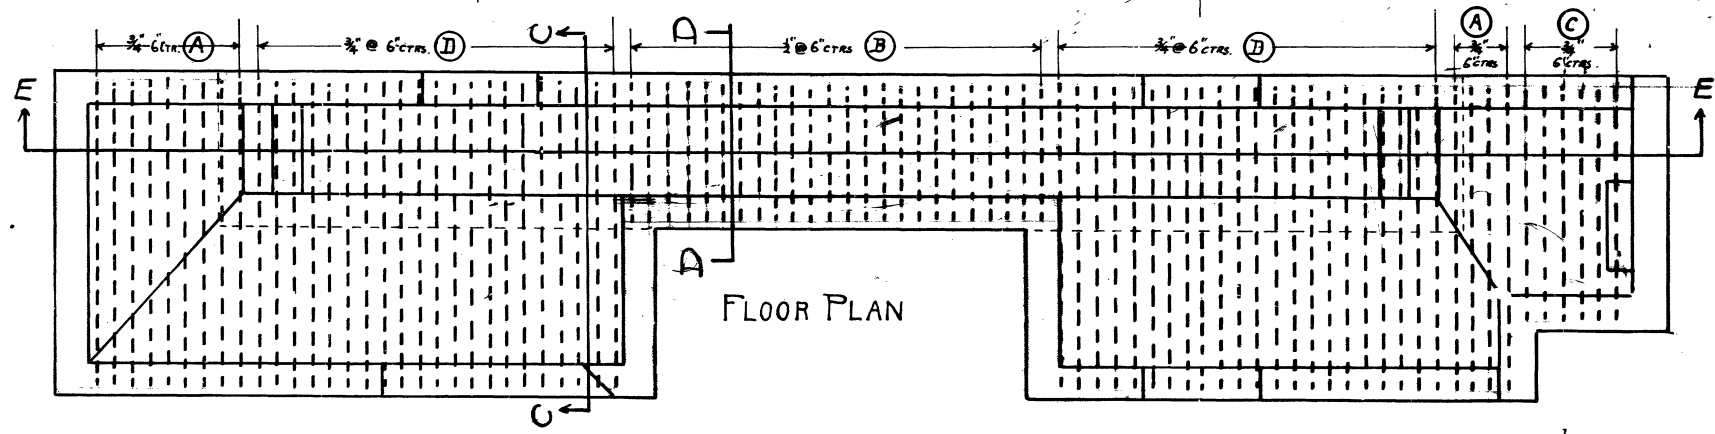

FLOOR PLAN

LETTER	Pcs	SIZE	LENGTH	REMARKS
A	72	3/4" D	8'-11"	BENT
B	54	5/8"	4'-0"	STRAIGHT
C	12	3/4"	7'-0"	"
D	43	3/4"	10'-0"	BENT
E	73	5/8"	8'-9"	BENT
F	40	3/4"	10'-7"	BENT
G	48	5/8"	7'-9"	BENT
H	7	5/8"	9'-9"	BENT
J	40	5/8"	2'-7"	STRAIGHT
K	12	3/8"	4'-4"	"
L	12	3/4"	6'-0"	"
M	3	3/4"	9'-0"	"

CONTRACT NO 92

D 568

DRAWN BY
TRACED BY
CHECKED BY
APPROVED

CHIEF ENGINEER

GREATER WINNIPEG WATER DISTRICT
REINFORCING STEEL FOR VALVE CHAMBER
M^CPHILLIPS ST RESERVOIR
MAY 26-1920