


PLOTTED ON 2010-03-31 BY RUFINO SANTOS  
 DOCUMENT SAVED IN H:\5800\5878\ELEC\5878-EL2.1.1\_M.DWG

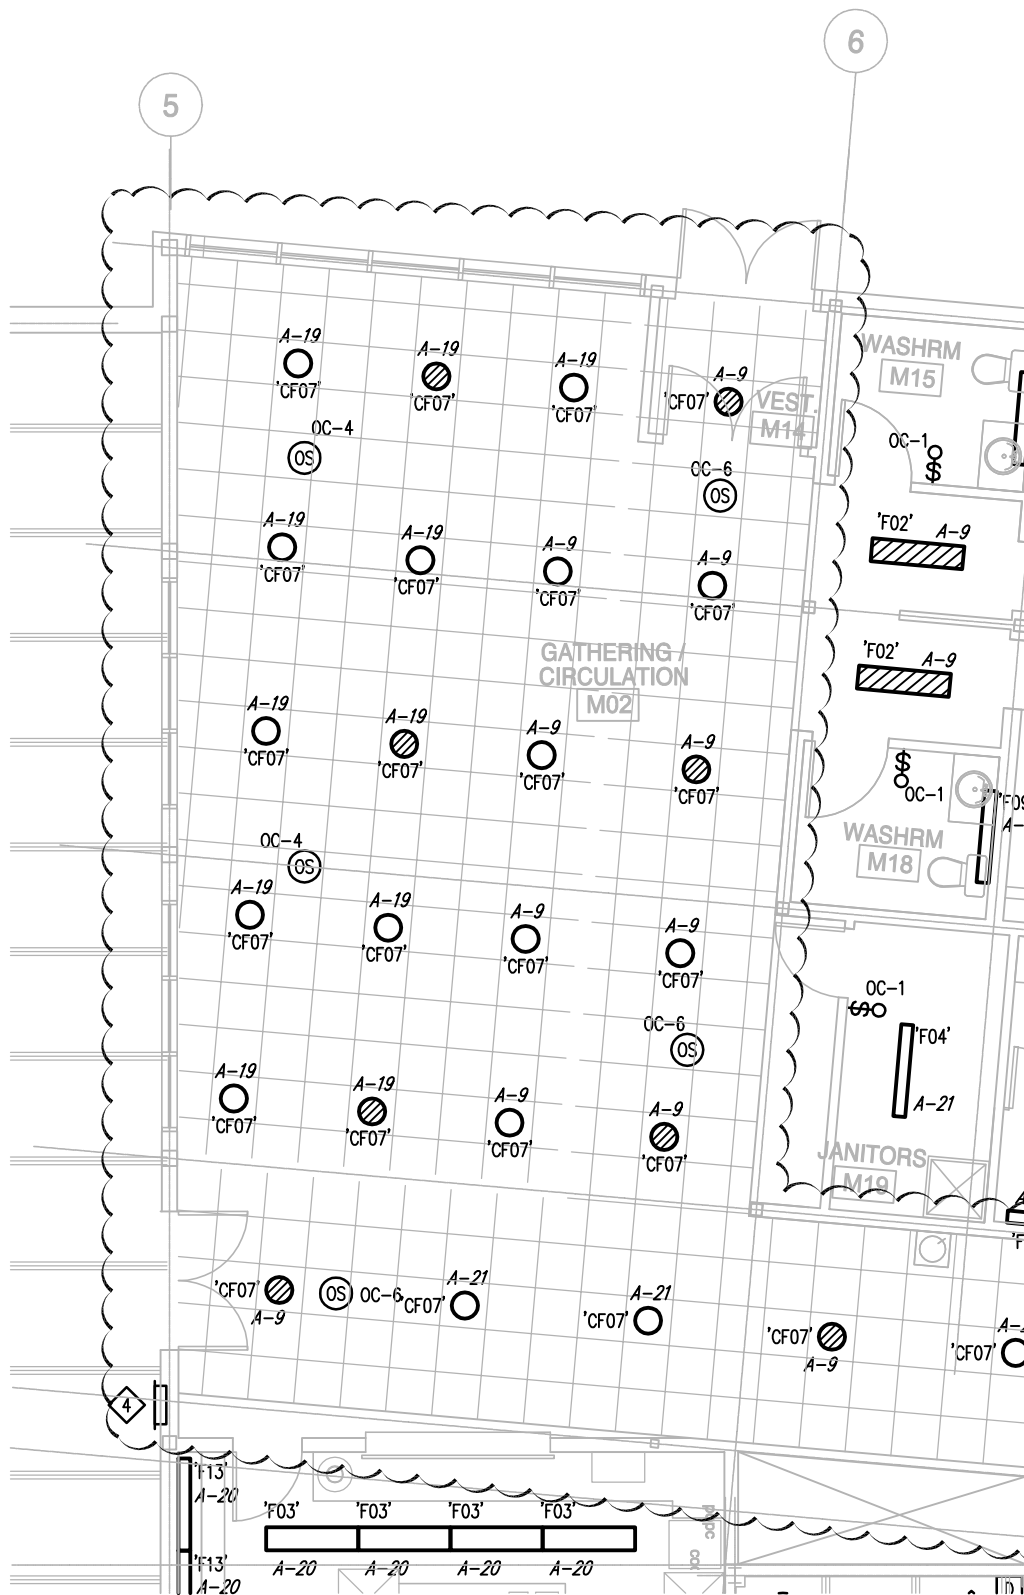

5878



**MCW / AGE**

Consulting Professional Engineers  
 210-1821 Wellington Avenue  
 Winnipeg, Manitoba, R3H 0G4  
 Phone - (204) 779-7900 Fax - (204) 779-1119  
 E-Mail: mcw\_wpg@mcw.com

PROJECT:

**SINCLAIR COMMUNITY CENTRE  
 ADDITION & RENOVATIONS**

REF. DWG. NO.

**EL2.1**

DESCRIPTION:

**LIGHTING LAYOUT**

DWG. NO.

**RE-3**

DATE:

**2010-03-31**

DRAWN BY:

**PCS**

SCALE:

**1:100**

ISSUED WITH:

**ADD#01E**