


PLOTTED ON 2010-4-5 BY MARIO GICANA  
 DOCUMENT SAVED IN H:\5800\5878\MILESTONE\2010-03-31\_ISSUED FOR ADD 02  
 MCW\5878\5878-BASEMENT PLUMBING AND GAS PIPING.DWG

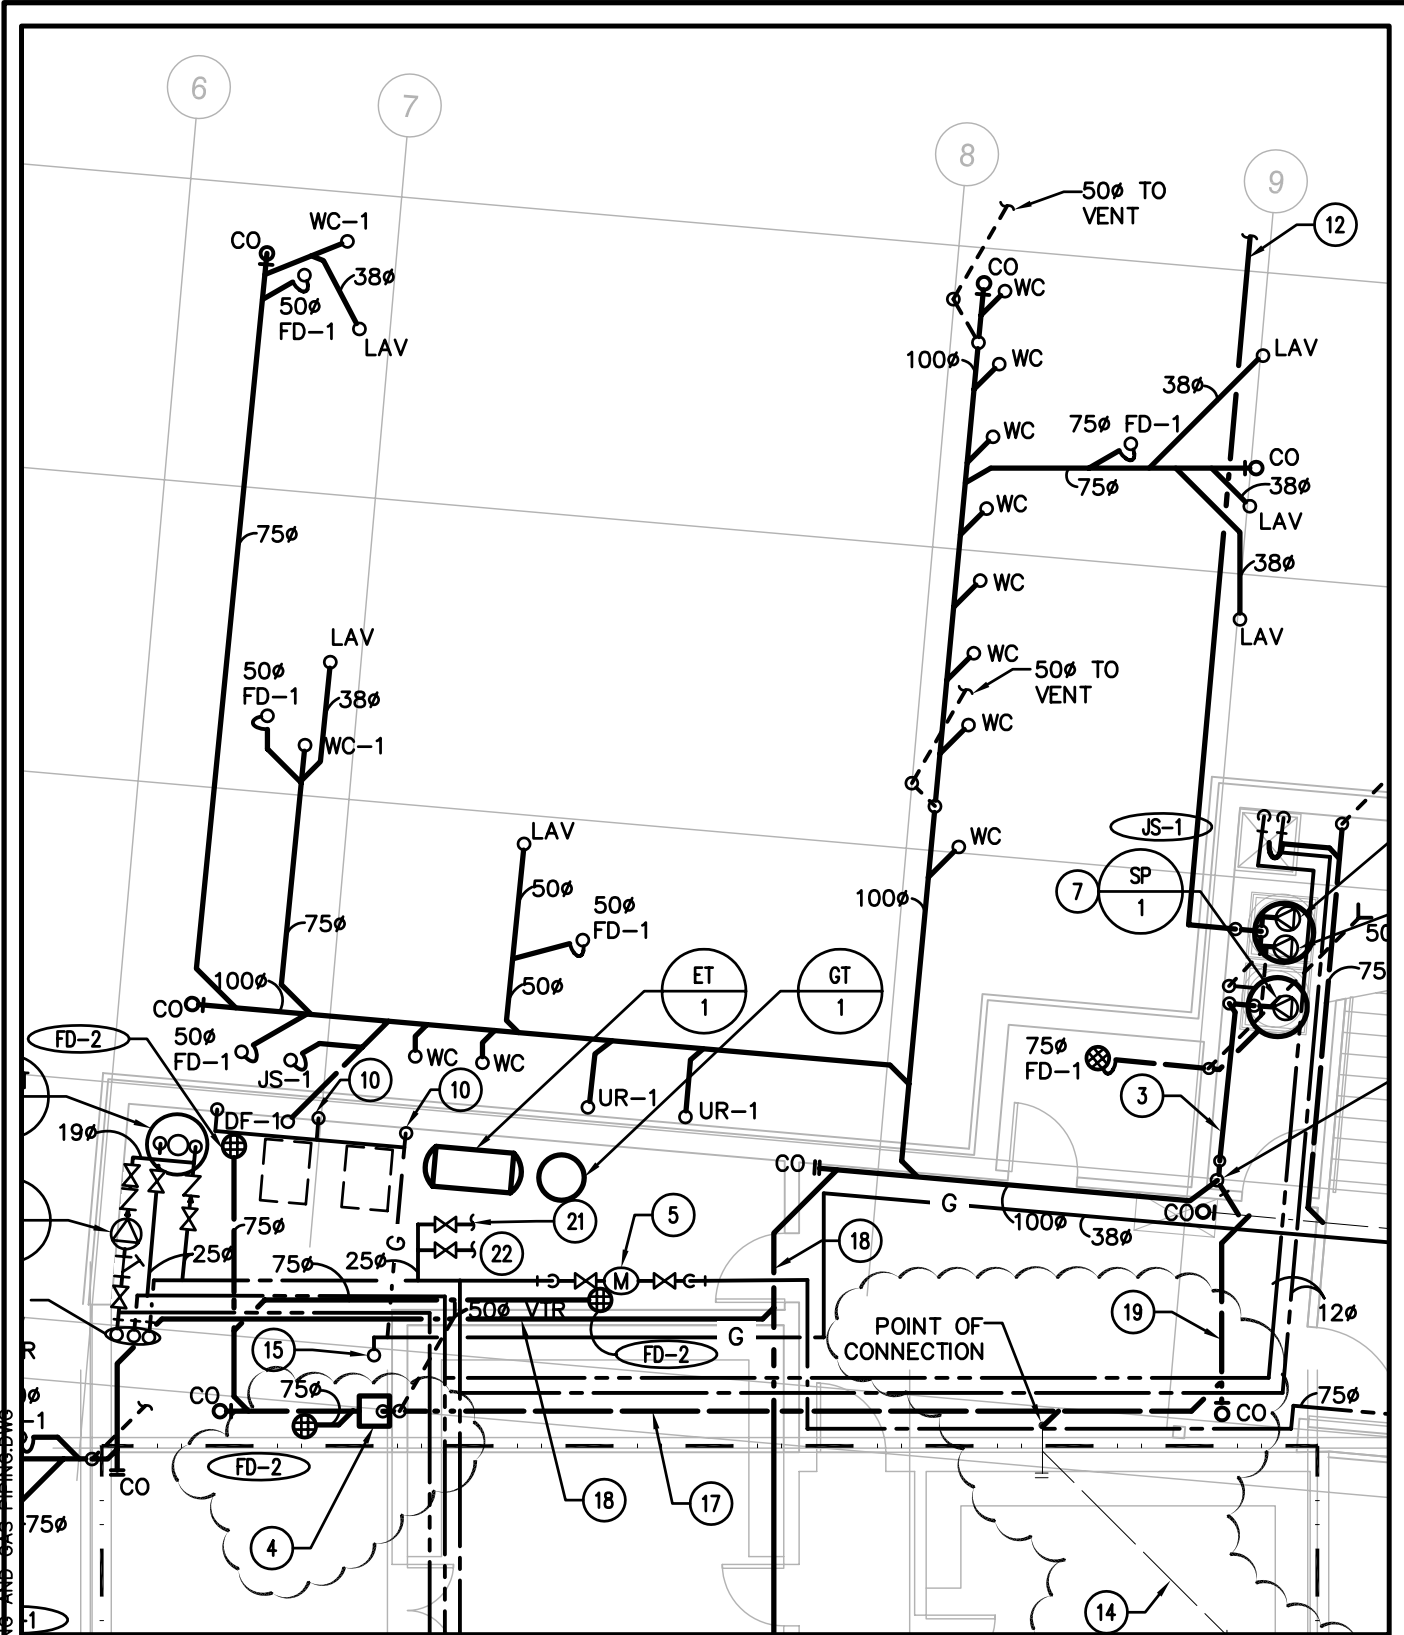

5878



**MCW / AGE**

Consulting Professional Engineers

210-1821 Wellington Avenue

Winnipeg, Manitoba, R3H 0G4

Phone - (204) 779-7900 Fax - (204) 779-1119

E-Mail: mcw\_wpg@mcw.com

PROJECT:

SINCLAIR PARK COMMUNITY CENTER

REF. DWG. NO.

M3.1

DESCRIPTION:

BASEMENT PLAN- PLUMBING AND GAS  
PIPING LAYOUT

DWG. NO.

RM-03

DATE:

2010-31-03

DRAWN BY:

MG

SCALE:

1:100

ISSUED WITH:

02-ME