

GENERAL NOTE:


- MECHANICAL CONTRACTOR SHALL VERIFY EXACT LOCATIONS, SIZES, INVERTS, ETC. PRIOR TO TENDER CLOSE. VERIFY ALL CONNECTION POINTS ON SITE. PROVIDE FOR ALL NECESSARY REVISIONS TO ACCOMMODATE INTENT OF DESIGN AND INCLUDE ALL WORK IN TENDER BID. NO EXTRAS WILL BE ALLOWED FOR WORK THAT COULD BE REASONABLY ASCERTAINED FROM PROPER SITE VISIT INSPECTIONS.
- PAY CLOSE ATTENTION TO WALL CONSTRUCTION TYPES. REFER ARCHITECTURAL DRAWINGS.
- ALL INSTALLATIONS TO BE PERFORMED AS PER ALL CODES, REGULATIONS AND AUTHORITIES HAVING JURISDICTION. THIS SHALL BE INVESTIGATED PRIOR TO TENDER CLOSE AND SHALL BE INCORPORATED INTO TENDER BID.
- MECHANICAL CONTRACTOR SHALL REFER TO ARCHITECTURAL, SITE SERVICE DRAWINGS, STRUCTURAL, ELECTRICAL DRAWINGS, EQUIPMENT SUPPLIER SHOP DRAWINGS, ETC FOR EXACT LOCATIONS OF ALL FIXTURES, EQUIPMENTS, ETC.
- PROVIDE TRAP PRIMER, (MIFAB OR EQUAL) FOR EACH FLOOR DRAIN.
- PROVIDE PLUMBING TRAPS TO ALL PLUMBING FIXTURES.
- AT START OF SANITARY LINE, CENTRE LINE OF PIPE SHALL START AT 152MM BELOW THE BOTTOM OF SLAB.
- PROVIDE A NEW BUILDING CLEANOUT.

LEGEND:

— SAN — SANITARY LINE

DRAWING NOTES:

- TIE INTO EXISTING SANITARY DRAIN IN MECH/ELEC ROOM 138
- TIE SANITARY LINE OF NEW SLOP SINK INTO EXISTING FLOOR DRAIN'S SANITARY LINE.
- REFER TO SUMP PUMP PIPING DETAIL.
- INSTALL CLEANOUT 915mm FORM SOUTH AND EAST WALLS OF STORAGE 115.
- PROVIDE SANITARY ROUGH-IN FOR FUTURE.

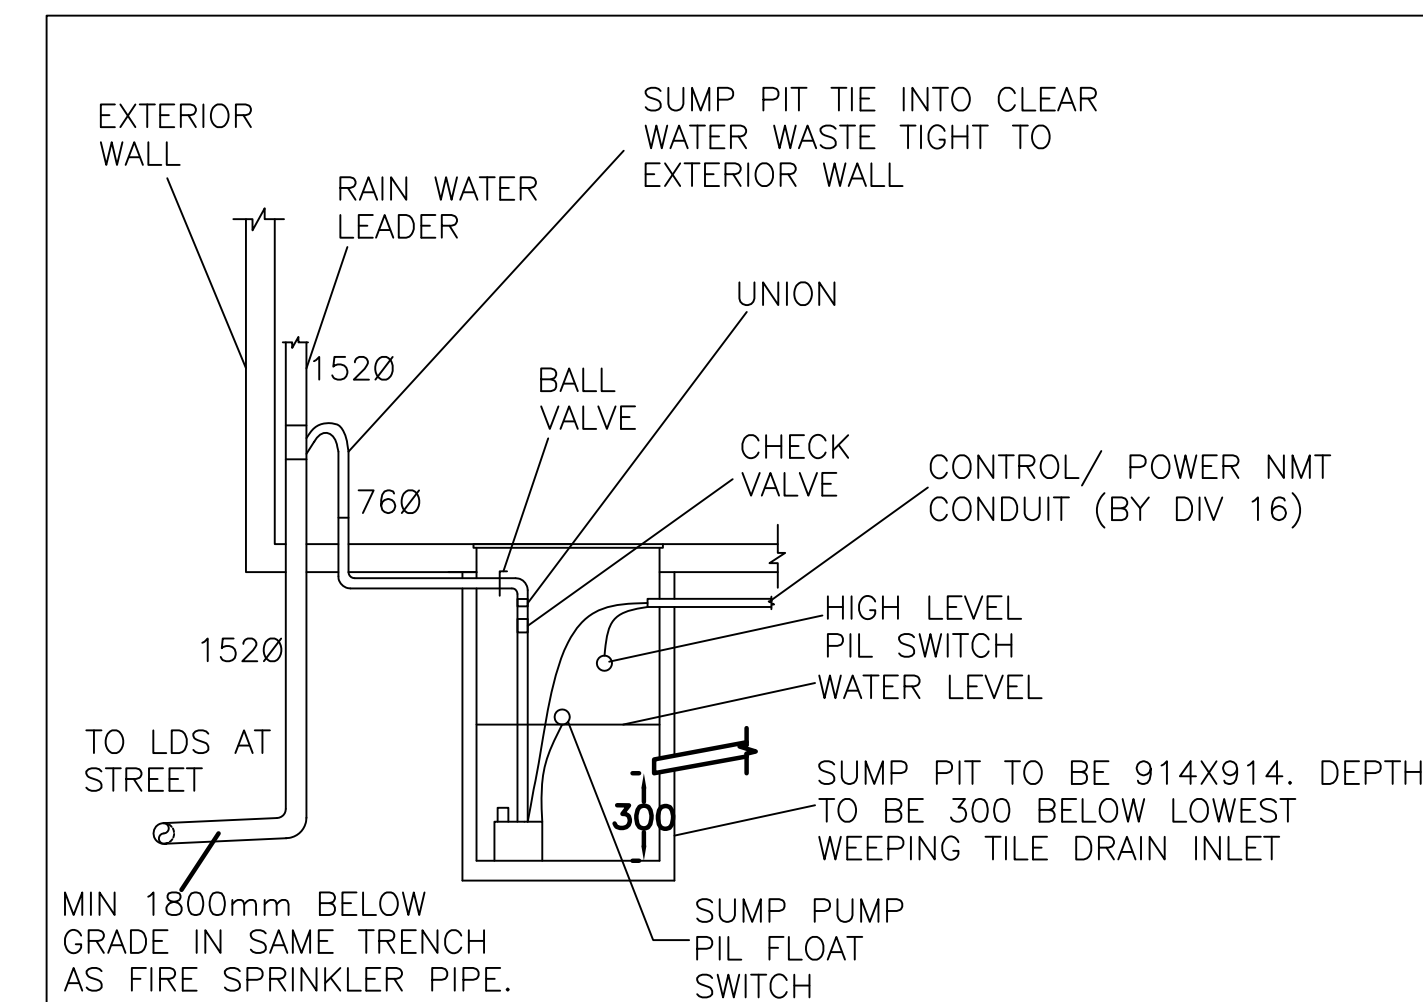

2 SUMP PUMP PIPING DETAIL
M-3.1 SCALE: 1:100

1 SANITARY PIPING SCHEMATIC MAIN FLOOR
M-3.1 SCALE: 1:100




CALNITSKY ASSOCIATES ARCHITECTS INC

ARCHITECTURE | INTERIOR DESIGN
124 Hazenau Street North Winnipeg, Manitoba R2L 2H1
Tel: (204) 453-4441 Fax: (204) 453-3392
E-mail: caa@escape.ca

This drawing is not intended to be an as-built or record drawing. The contractor is responsible for verifying the accuracy of the information on-site. If there is any information that is in error, the contractor shall record the discrepancy and contact the Engineer immediately with his findings.

DATE	NO.	DESCRIPTION	DRAWN BY
2010MAY13	0	ISSUE FOR TENDER	JC

REVISIONS

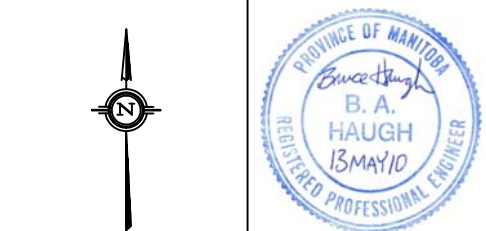

PE PharmEng Technology
A Division of PE Pharma Inc.

JOB TITLE:
ADDITION & RENOVATION OF WINAKWA COMMUNITY CENTRE
980 WINAKWA ROAD WINNIPEG, MB

DRAWING TITLE:
SANITARY PIPING SCHEMATIC MAIN FLOOR

SCALE:	DATE:	DRAWING NO.:
1:100	2010 MAY 13	M-3.1
DRAWN BY:	DESIGN BY:	CHECKED BY:
JC	JC	BN
FILE NO.:	PROJECT NO.:	
N/A	339-2010	