


 

 

 

 
 


 




sheet size - Super A1 24" x 36" plot scale - 1:1 (metric) CAD file name - XX

LEGEND

-  UNDERGROUND PIPING (Approximate)
-  PROPERTY LINE
-  LIMIT OF WORK
-  MANITOBA HYDRO UNDERGROUND HIGH VOLTAGE LINE
-  COMBINED SEWER
-  WATERMAIN
-  CONSTRUCTION ACCESS LOCATION
-  PICNIC TABLES - RELOCATE EXISTING
-  BOULDER RETAINING EDGE
-  PROPOSED PLANTING BED
-  SOD
-  CONCRETE SURFACING
-  CRUSHED LIMESTONE SURFACING
-  WOOD FIBRE SURFACING N.I.C.

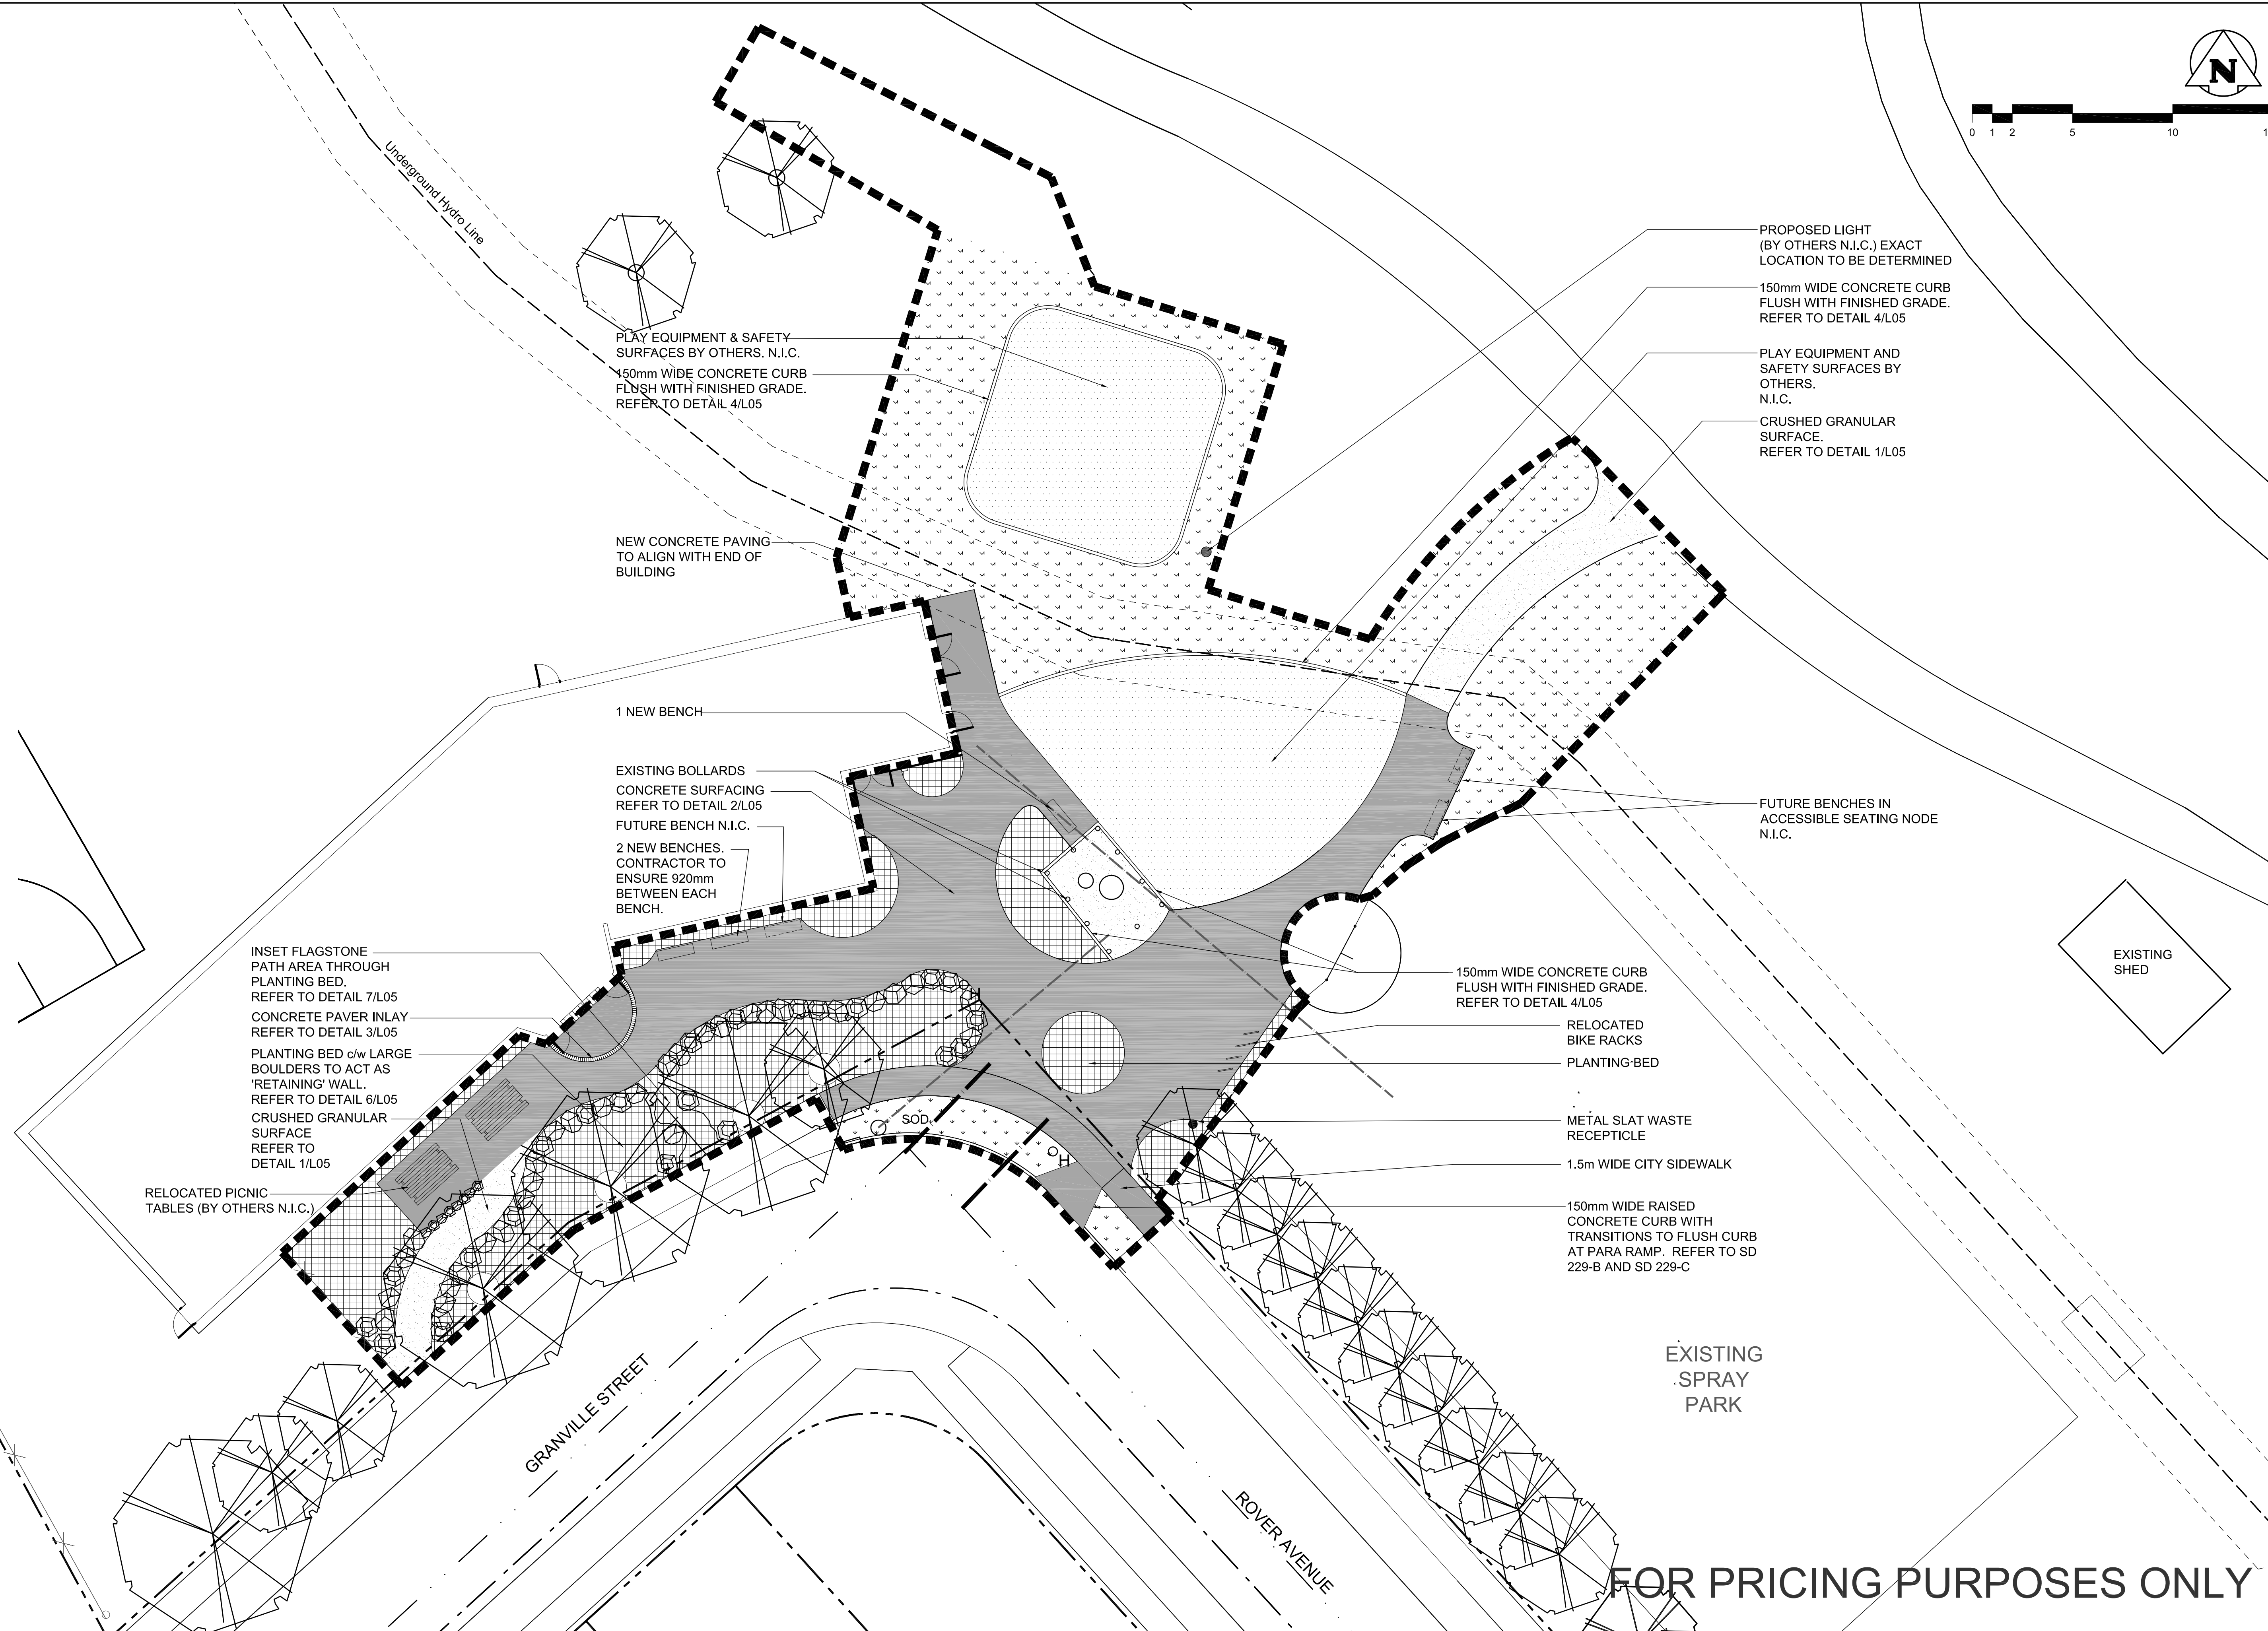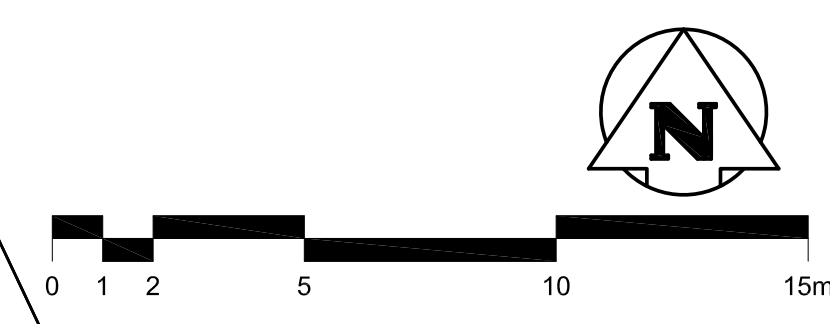

NOTES:

1. CONTRACTOR TO VERIFY THE LOCATION OF ALL UNDERGROUND UTILITIES PRIOR TO EXCAVATION.
2. ALL LAYOUT TO BE APPROVED BY CONTRACT ADMINISTRATOR PRIOR TO CONSTRUCTION.
3. NO INSTALLATION OF ANY SUBSURFACE FEATURES (INCLUDING FURNITURE, PLAY EQUIPMENT, TREES) WITHIN 4M OF EXISTING UNDERGROUND HYDRO LINE
4. ALL EXCAVATION WITHIN 2m SAFETY ZONE TO BE DONE BY HAND UNDER SUPERVISION OF MANITOBA HYDRO.

NO.	13/05/10	ISSUED FOR TENDER	JW
NO.	D / M / Y	REVISIONS	BY



A. SECTION LETTER OR DETAIL NUMBER, IS DRAWN.
 B. DRAWING WHERE SECTION OR DETAIL IS INDICATED.
 OR
 DRAWING WHERE SECTION OR DETAIL IS INDICATED.
 --- SECTION OR DETAIL SHOWN ON SAME DRAWING.

CLIENT	City of Winnipeg	DESIGN BY	JW	DRAWN BY	AR	SCALE	PLAN - 1:150
PROJECT TITLE	Norquay CC Playground Development - Site Works	CHECKED BY	JW	APPROVED BY	JW	DATE	MAY 13, 2010
DRAWING TITLE	General Site Plan Phase I	FILE NO.	7052		SHEET NO.	L01	

FOR PRICING PURPOSES ONLY