


sheet size - Super A1 24" x 36" plot scale - 1:1 (metric)

### LEGEND

- UNDERGROUND PIPING (Approximate)
- PROPERTY LINE
- LIMIT OF WORK
- MANITOBA HYDRO UNDERGROUND HIGH VOLTAGE LINE
- COMBINED SEWER
- WATERMAIN
- CONSTRUCTION ACCESS LOCATION
- HYDRO POLE

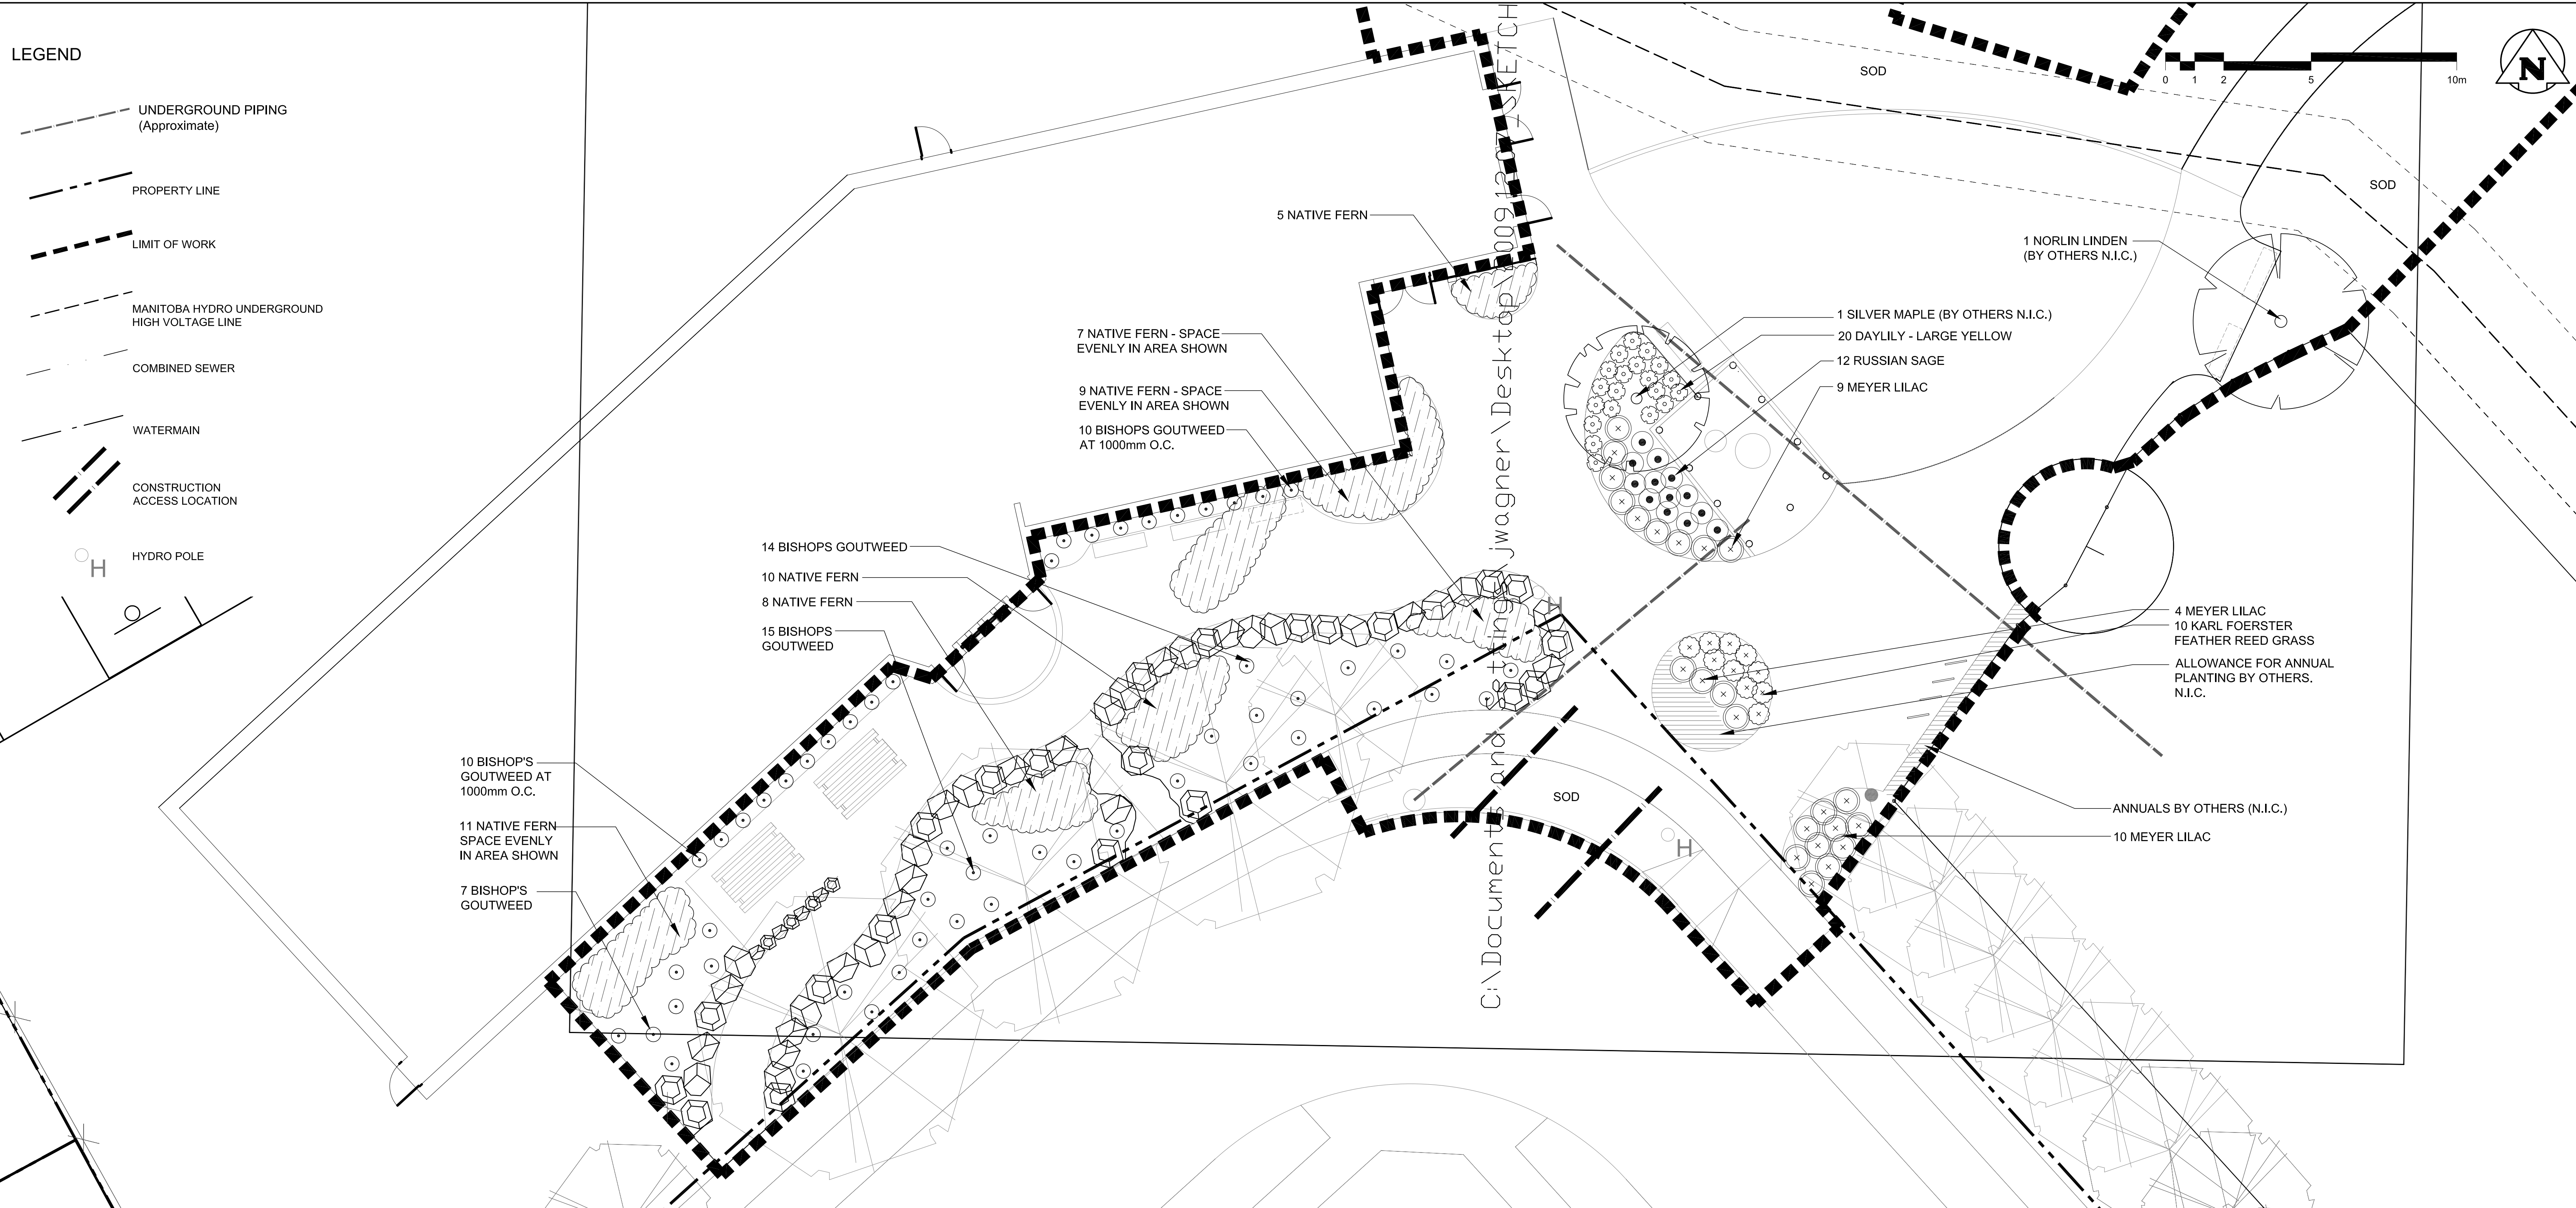

### PLANT SCHEDULE

SHRUBS AND PERENNIALS

Qty	Scientific Name	Common Name	Supply Size	Spacing
57	<i>Aegopodium podagraria</i> 'Variegata'	Bishop's Goutweed	#1 Container, well-developed root system	1200mm <small>or otherwise noted</small>
10	<i>Calamagrostis acutiflora</i> 'Karl Foerster'	Karl Foerster Feather Grass	#1 Container, well-developed root system	750mm
20	<i>Hemerocallis sp.</i>	Daylily - Large Yellow	#1 Container, well-developed root system	600mm
50	<i>Matteuccia struthiopteris</i>	Native Fern	#1 Container, well-developed root system	900mm
12	<i>Perovskia atriplicifolia</i>	Russian Sage	#1 Container, well-developed root system	600mm
23	<i>Syringa meyeri</i> 'Palibin'	Meyer Lilac	350-400 mm Height. Min. 4 Basal Stems. Container Stock	900mm

- NOTES:
- REFER TO L02 - 'GENERAL SITE PLAN' - FOR LAYOUT OF SOD AREAS.
  - TOPSOIL AND SOD AS PER CS 3510-R9
  - TREES TO BE PLANTED IN ACCORDANCE WITH CITY OF WINNIPEG STANDARD GUIDELINES FOR THE PLANTING OF TREES - REFER TO 8/L05.

NO.	DATE	DESCRIPTION	BY
RO	13/05/10	ISSUED FOR TENDER	JW
		REVISIONS	



A. SECTION LETTER OR DETAIL NUMBER, IS DRAWN.  
 B. DRAWING WHERE SECTION OR DETAIL IS DRAWN.  
 OR  
 DRAWING WHERE SECTION OR DETAIL IS INDICATED.  
 --- SECTION OR DETAIL SHOWN ON SAME DRAWING.

SEAL

CLIENT	City of Winnipeg	DESIGN BY	JW	DRAWN BY	AR	SCALE	1:100 on 24x36
PROJECT TITLE	Norquay CC Playground Development - Site Works	CHECKED BY	JW	APPROVED BY	JW	DATE	May 13, 2010
DRAWING TITLE	Planting Plan	FILE NO.	7052		SHEET NO.	L04	

**FOR PRICING PURPOSES ONLY**

CAD file name - XX