


NOTES :  
SEE NOTES & LEGENDS ON SHEET M1.

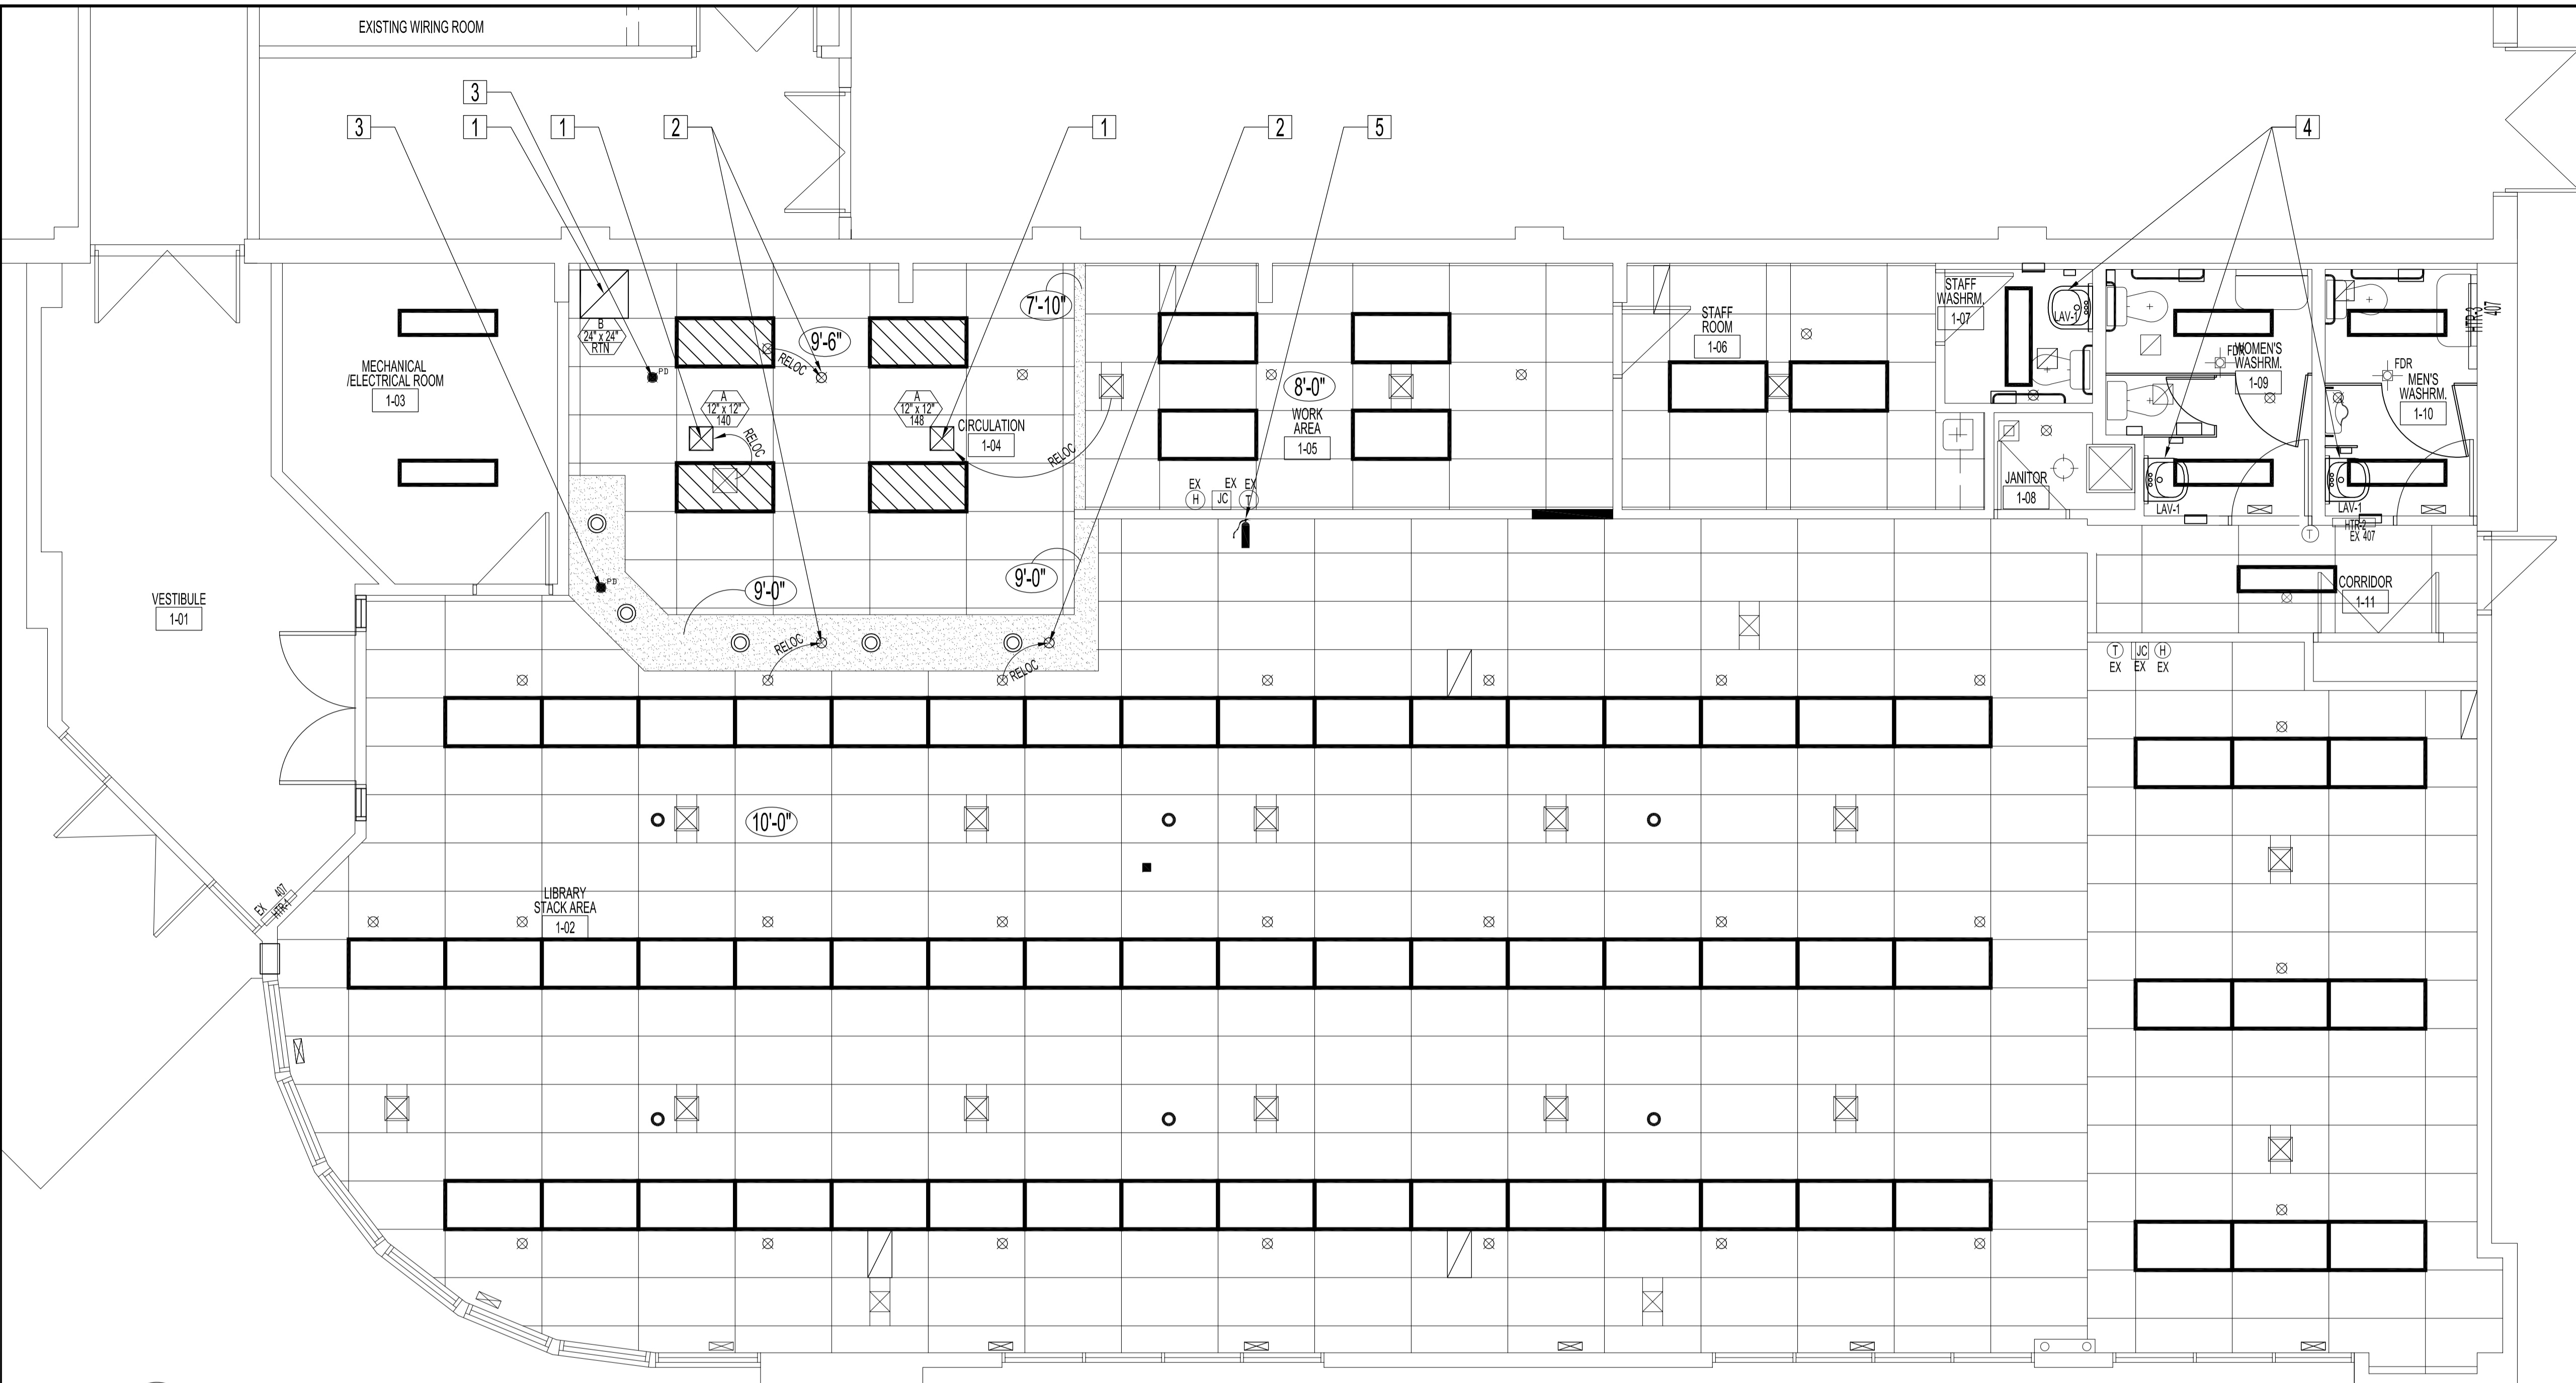

**REFLECTED MAIN FLOOR PLAN - REFLECTED CEILING  
MECHANICAL & PLUMBING RENOVATION**  
DOORS, FIXTURES & CONTROLS SHOWN FOR CLARITY  
SCALE: 1/4"=1'-0"

**MECHANICAL & PLUMBING RENOVATION NOTES:**  
ALSO SEE NOTES & SPECIFICATIONS.

- 1 RELOCATE SUPPLY DUCTS TO NEW LOCATIONS SHOWN. SUPPLY & INSTALL NEW DIFFUSERS OR RETURN GRILLE, AS SHOWN.
- 2 RELOCATE EXISTING SPRINKLER HEADS TO NEW LOCATIONS. NOTE FINISHED CEILING HEIGHTS. REPLACE EXISTING SPRINKLER HEADS, IF REQUIRED.
- 3 SUPPLY & INSTALL NEW SPRINKLER LINES & SPRINKLER HEADS: QUICK RESPONSE SEMI-RECESSED PENDENT SPRINKLER 155°F (68°C), 3" ORIFICE, K=5.6. CONTRACTOR IS RESPONSIBLE FOR INSTALLING POKE-UPS, SWING JOINTS AND DEEP CUP ESCUTCHEONS AS REQUIRED.
- 4 SUPPLY & INSTALL NEW FIXTURES, EXCEPT TOILETS & URINAL IN MEN'S, WOMEN'S & STAFF WASHROOMS, AS SHOWN IN PLUMBING SCHEDULE.  
**NOTE:** LAVATORY WATER SUPPLIES & DRAIN SHALL BE TOTALLY ENCLOSED IN NEW SHROUD/KNEE CONTACT GUARD. RELOCATE WATER SUPPLIES & DRAINS IF REQUIRED TO ACCOMMODATE.
- 5 RELOCATED FIRE EXTINGUISHER & SIGN. REMOUNT FIRE EXTINGUISHER SECURELY TO STUD FRAMING. HEIGHT TO BE THE SAME AS EXISTING.

HVAC SCHEDULE (SUPPLY & INSTALL, SEE MECHANICAL SPECS)	
SYMBOL	DESCRIPTION
	TYPE "A" DENOTES TYPE OF GRILLE OR DIFFUSER "7X7" DENOTES SIZE OF GRILLE OR DIFFUSER (INCHES) "EXH" DENOTES EXHAUST OR AIR VOLUME IN CFM
A	SQUARE 3-CONE DIFFUSER W/24" x 24" PANEL, FIXED AIR PATTERN, PRICE 6"1/2x12"SCD3P3C/B12 SITE VERIFY INLET DIAMETER
B	EGG CRATE FACE RETURN, 1/2" x 1/2" PLASTIC GRID CORE, WHITE
	RETURN AIR GRILLE

PLUMBING SCHEDULE (SUPPLY & INSTALL)			
TAG	TYPE	DESCRIPTION	REMARK
LAV-1		AMERICAN STANDARD UNIVERSAL DESIGN WALL HUNG SINK MODEL 0964 MURRO WITH OPTIONAL SHROUD/KNEE CONTACT GUARD 0059 020. ALL PLUMBING MUST BE CONCEALED INSIDE SHROUD/KNEE CONTACT GUARD. 4" CENTERS, 22" X 21-1/4" X 5" DEEP, VITREOUS CHINA, REAR OVERFLOW. SYMMONS SYMMETRIX LAVATORY FAUCET S-20-4-BH. SINGLE LEVER FAUCET WITH RED & BLUE INDICATORS ON HANDLE, 4" CENTERS, HANDLE LIMIT STOPS, AERATOR (8.3 L/MIN), QUARTER TURN CERAMIC CONTROL COMPONENTS. 20' BRAIDED SUPPLY HOSE, METAL CONSTRUCTION, POLISH CHROME. CAST WHEELCHAIR ADJUSTABLE LAVATORY WASTE DELTA 337280, 1-1/4" SIZE, POLISHED CHROME PLATED CAST BRASS BODY, ADJUSTABLE 1" TRAP WITH CLEANOUT PLUG DELTA 337311. LAVATORY SUPPLY DELTA 4772512SD LESS FLEXIBLE BRAIDED STAINLESS STEEL RISER.	

DESIGN LEAD HAS CHANGED.	DTA	2010	03.10
NO.	REVISION/DESCRIPTION	BY	DATE

DTA	CHECKED	DESIGNED	DTA	APPROVED
DATE	USER	APPROVAL		
2010.03.10				

THE CITY OF WINNIPEG  
PLANNING, PROPERTY AND  
DEVELOPMENT DEPARTMENT  
MUNICIPAL ACCOMMODATIONS DIVISION  
3-65 GARRY STREET, R3C 4K4

PROJECT  
FORT ROUGE LIBRARY  
INTERIOR UPGRADING  
NEW CIRCULATION DESK  
625 OSBORNE STREET

SHEET TITLE  
PARTIAL MAIN FLOOR PLAN-REFLECTED CEILING  
RENOVATION  
MECHANICAL AND PLUMBING

SCALE	PROJECT NO.	SHEET NO.
AS SHOWN	2008-019-01	M2R1