




1 MEZZANINE PART PLAN - EXISTING DEMOLITION
E1.0 SCALE: 1/4"=1'-0"

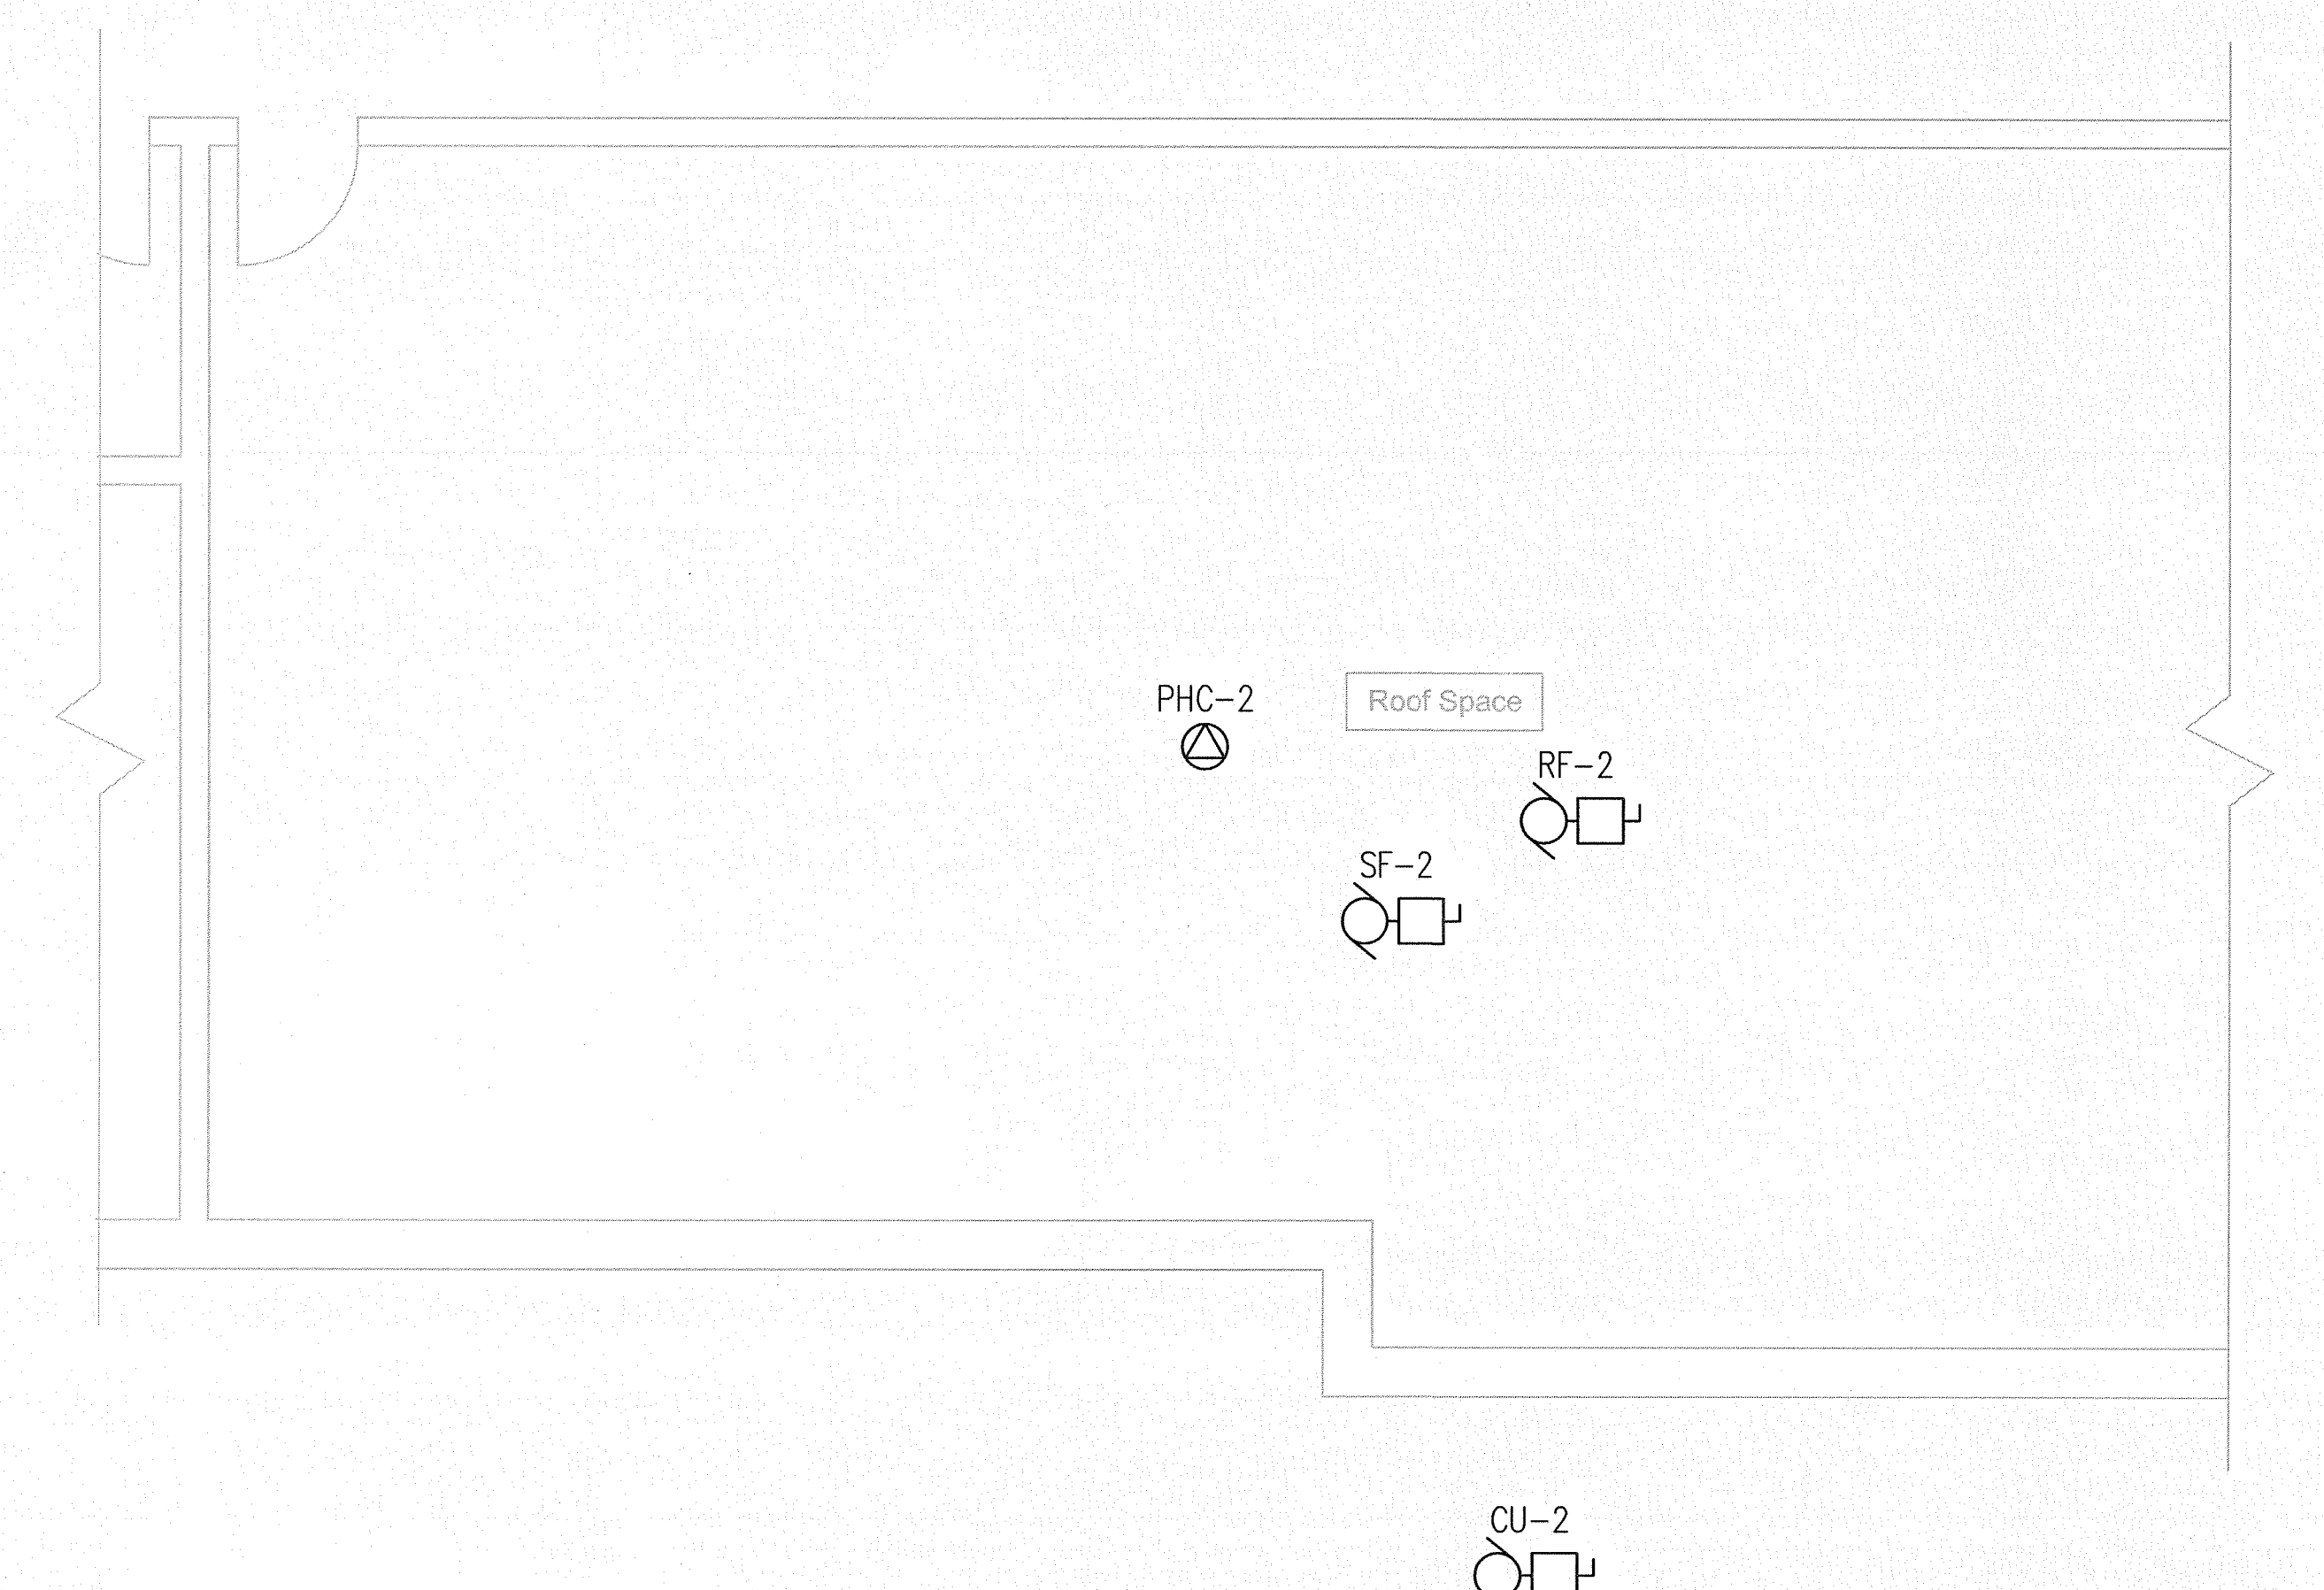

2 MEZZANINE PART PLAN - NEW WORK
E1.0 SCALE: 1/4"=1'-0"

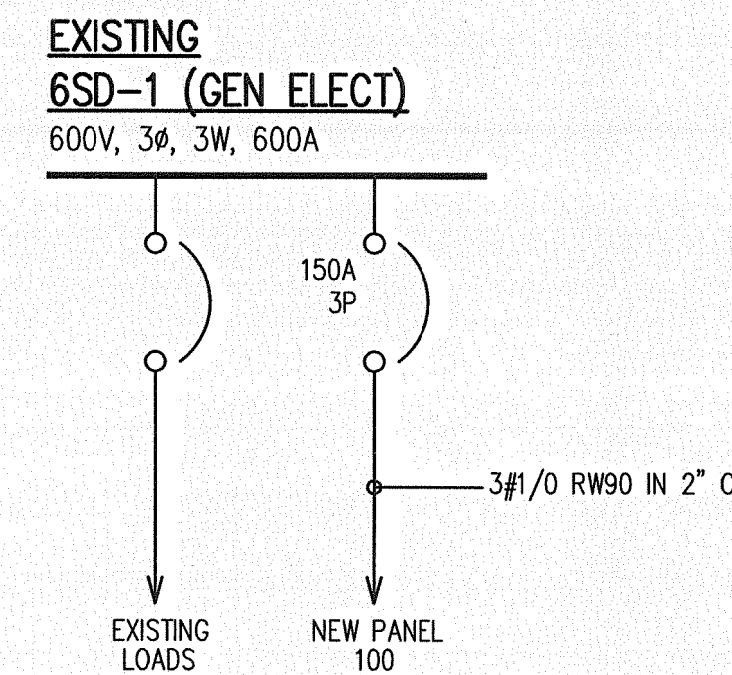

3 SINGLE LINE
E1.0 SCALE: NTS

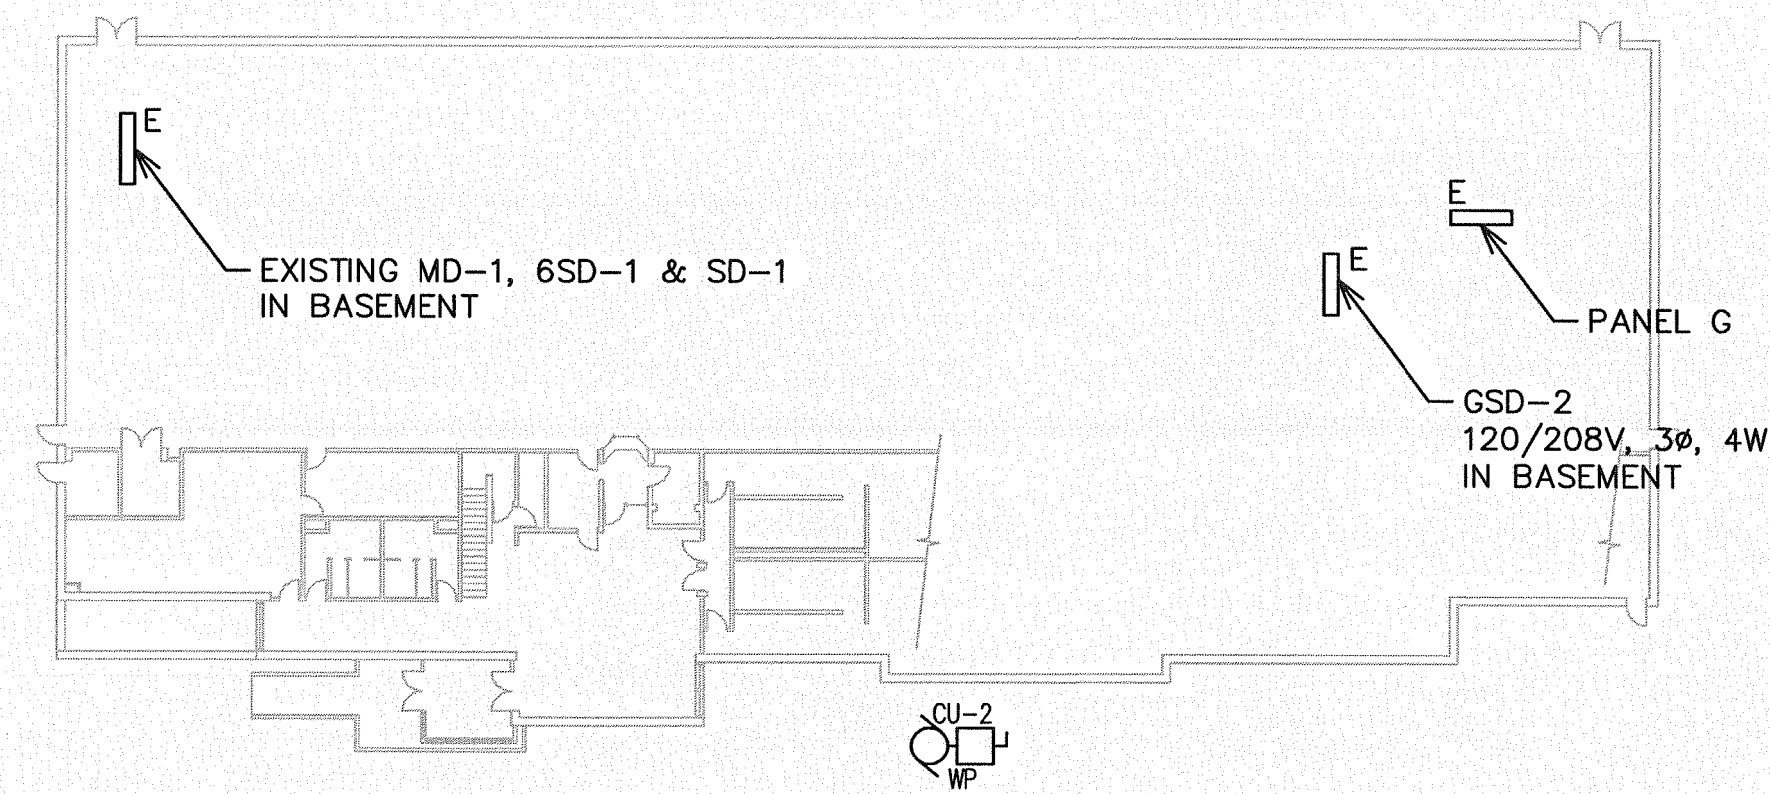

4 KEY PLAN
E1.0 SCALE: NTS

DRAWING NOTES:

1. DISCONNECT EXISTING ECU AND REMOVE EXISTING CONDUIT AND FEEDER. REFER TO NEW WORK.
2. DISCONNECT AND REMOVE EXISTING REHEAT UNITS C/W ASSOCIATED WIRING AND CONDUIT.
3. DISCONNECT AND REMOVE EXISTING EAHU C/W ASSOCIATED WIRING AND CONDUIT.

ELECTRICAL SYMBOL LEGEND

- ⊙ DIRECT CONNECTION - 120 OR 208V AS SPECIFIED
- MOTOR CONNECTION AS SPECIFIED
- ⊞ MOTOR CONNECTION C/W UNFUSED DISCONNECT SWITCH
- UNFUSED DISCONNECT SWITCH
- ◇ (TYP.) ELECTRICAL DRAWING NOTES

ABBREVIATIONS

- AHU - AIR HANDLING UNIT
- CU - CONDENSING UNIT
- D - DELETE
- E - EXISTING
- ER - EXISTING RELOCATED
- R - RELOCATE
- RL - NEW LOCATION
- RF - RELIEF AIR
- RHC - REHEAT COIL
- SP - SUPPLY FAN
- WP - WEATHERPROOF
- UH - UNIT HEATER

ELECTRICAL DRAWING LIST

- E1.0 MEZZANINE PART PLANS - ELECTRICAL DEMOLITION AND NEW WORK LAYOUTS
- E1.1 ELECTRICAL SCHEDULES


MCW / AGE
Consulting Professional Engineers
210-1827 Wellington Avenue
Winnipeg, Manitoba, R3H 0G4
Phone - (204) 779-7800 Fax - (204) 779-1119
E-Mail: mcw_age@mcw.com

7469

unies Ltd. Consulting Engineers
TPR MECHANICAL CONSULTANTS LTD.
110-1655 ST. JAMES STREET WEST 100
PH: 622-4068 FAX: 622-4066

NO.	REVISION/DESCRIPTION	ISSUED FOR REVIEW	RE-ISSUED FOR TENDER	DATE	BY	DATE
2				08/24	DG	
1				07/28	DG	

SEALS

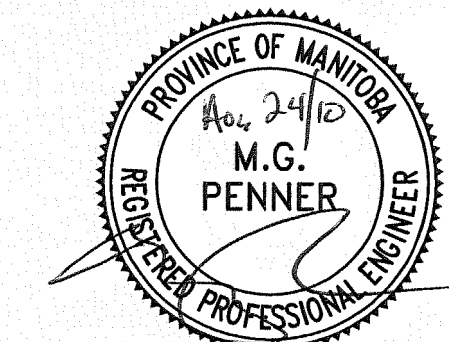

DRAWN BY: KP CHECKED BY: DG APPROVED: DG
DATE: AUG 24, 2010

THE CITY OF WINNIPEG
CIVIC BUILDINGS DEPARTMENT
4TH FLR.-185 KING ST. R3B 1J1

PROJECT
BID OPPORTUNITY 679-2010
Upgrade Air Conditioning Systems
- Lobby
909 CONCORDIA AVENUE
Winnipeg, Mb.

SHEET TITLE
MEZZANINE PART PLANS -
ELECTRICAL DEMOLITION &
NEW WORK LAYOUTS

APEGM
Certificate of Authorization
MCW/AGE Consulting
Professional Engineers
No. 589 Expiry: April 30, 2011

SCALE AS NOTED PROJECT NO. 679-2010 SHEET NO. E1.0