


WEST WING ← → EAST WING

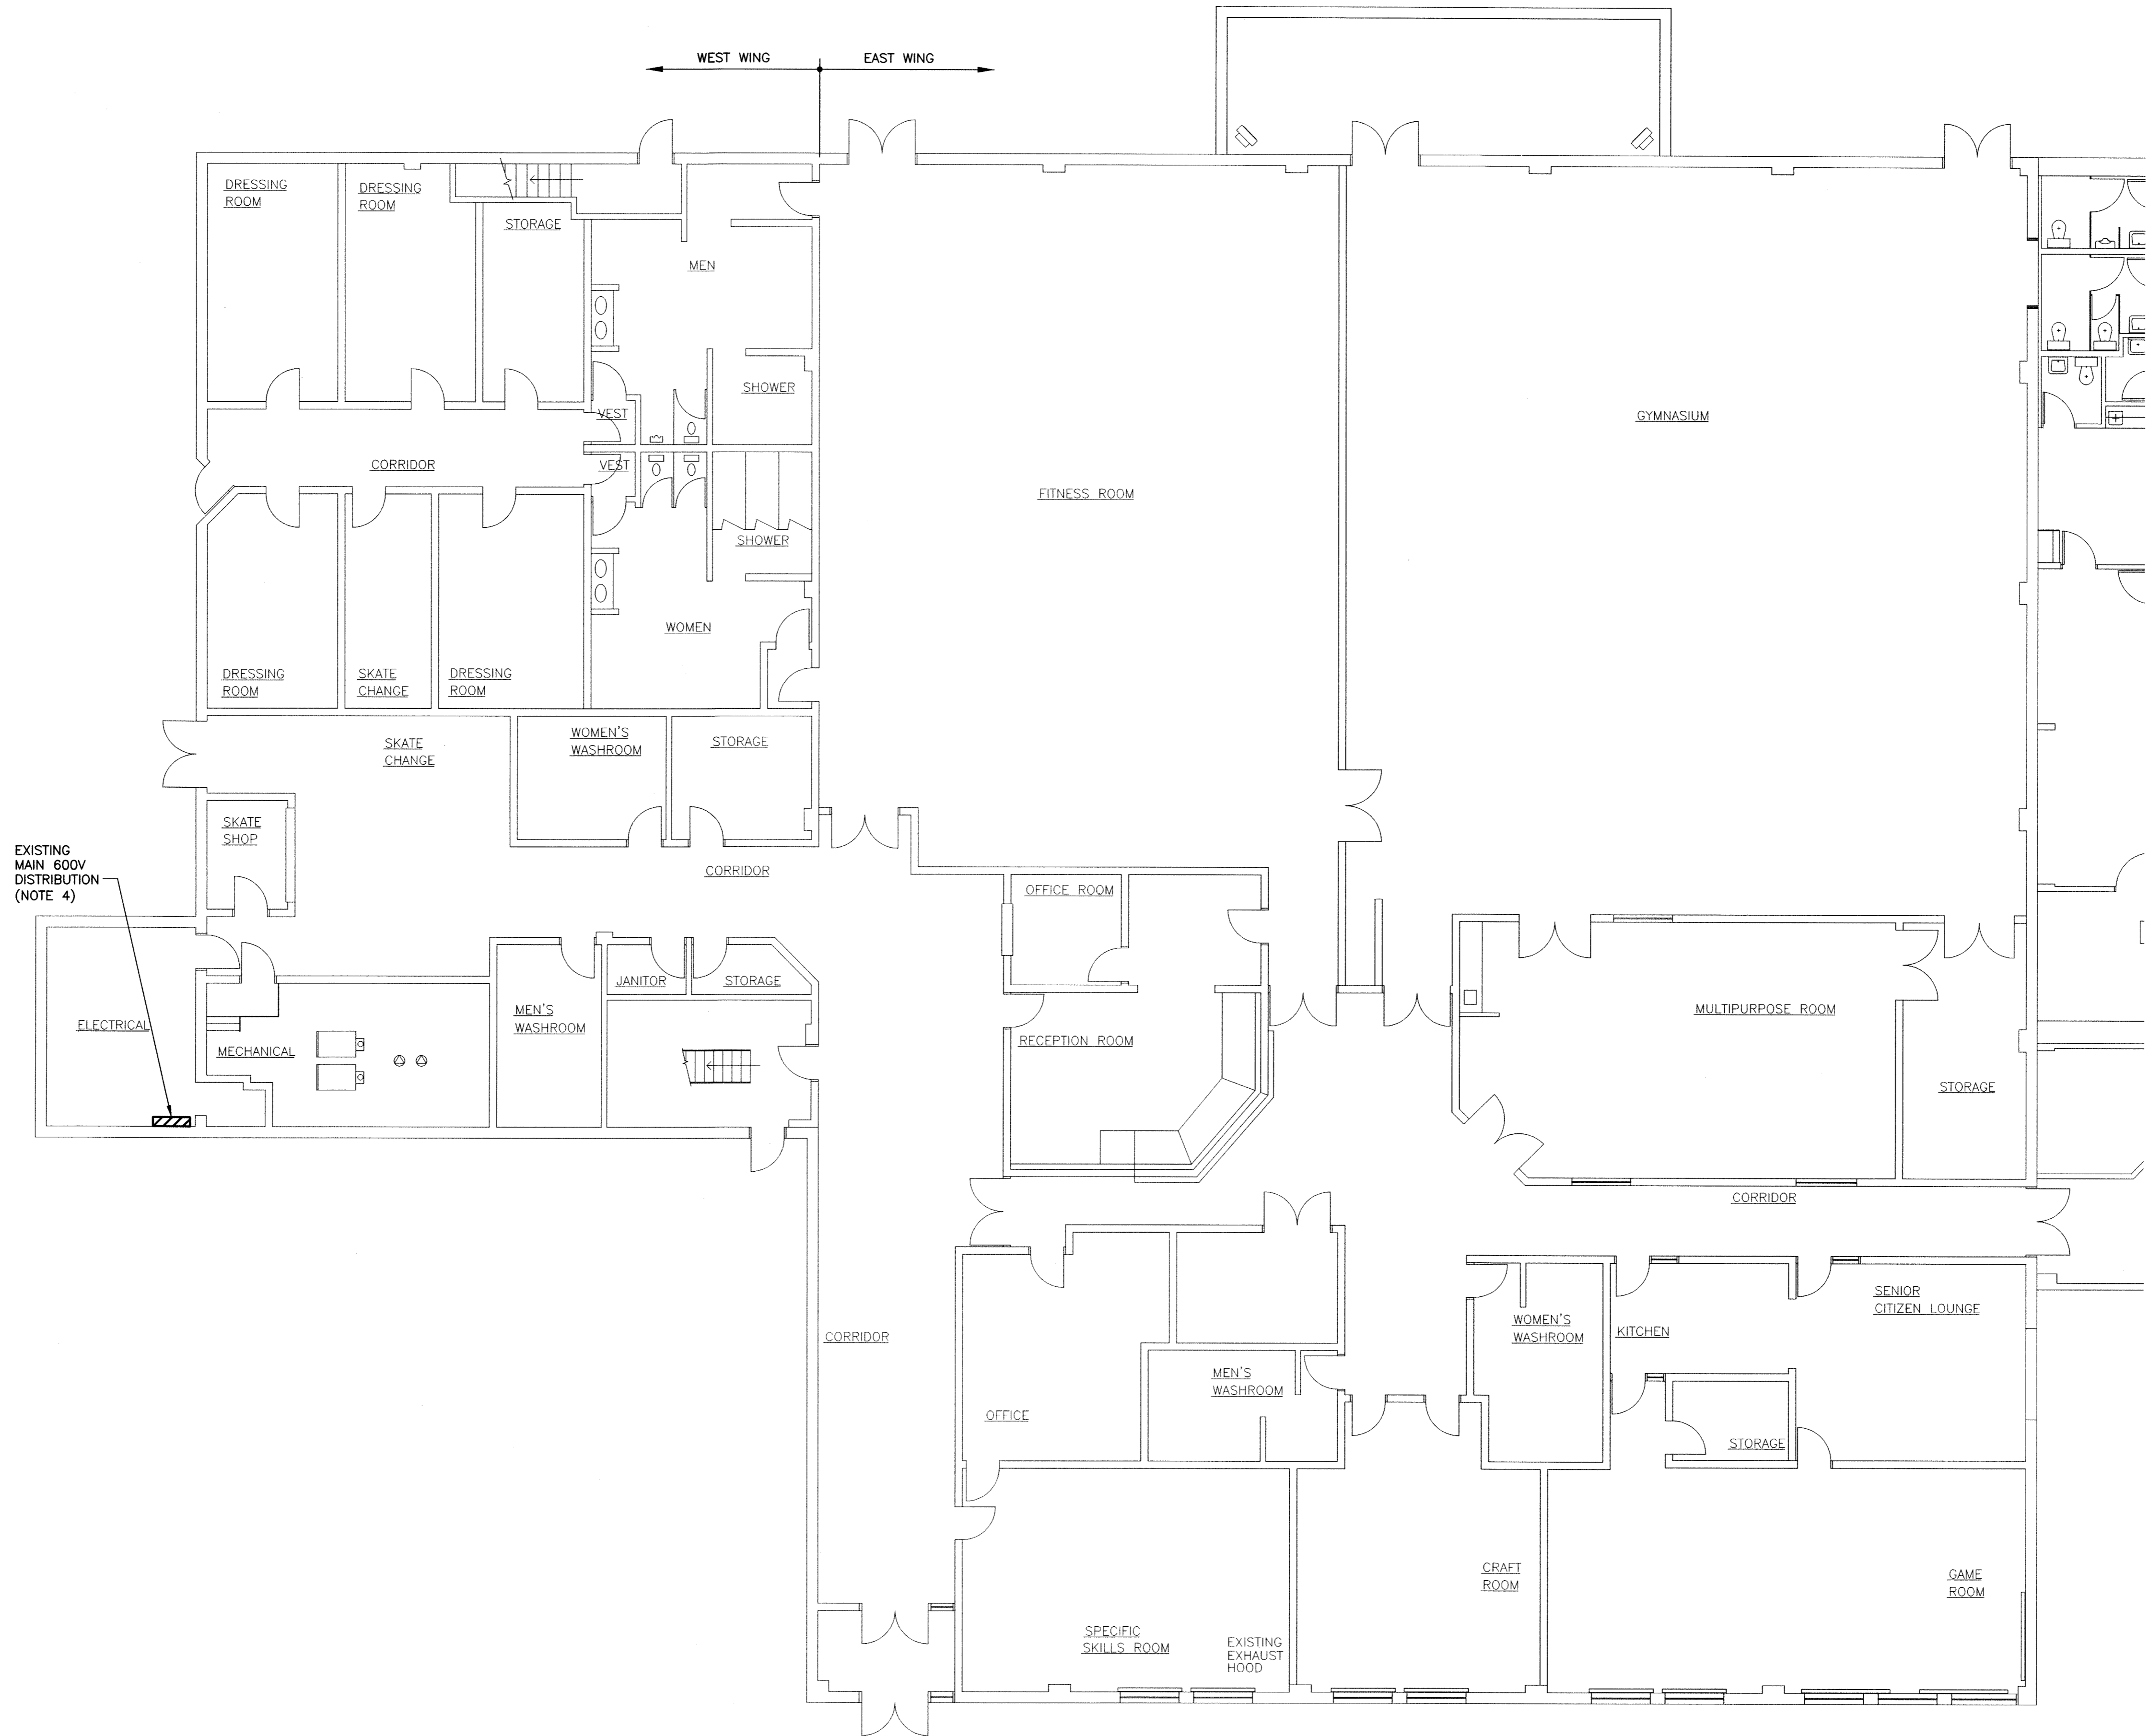

EXISTING MAIN 600V DISTRIBUTION (NOTE 4)


NOTES:

1. PROVIDE 120V POWER CONNECTIONS FOR THE NEW DDC AND ADDITIONAL REMOTE CONTROLLERS. CONTRACTOR TO COORDINATE WITH CONTROLS CONTRACTOR FOR THE QUANTITY AND LOCATION OF ALL REQUIRED CONNECTION POINTS.
2. PROVIDE CONDUIT FOR ALL CONTROL WIRING. CONTRACTOR SHALL COORDINATE CONDUIT REQUIREMENTS WITH CONTROLS CONTRACTOR AS REQUIRED.
3. PROVIDE ALL REQUIRED FIRESEALING FOR ALL NEW ELECTRICAL WALL PENETRATIONS AND ANY OPENING FROM REMOVED ELECTRICAL EQUIPMENT TO MAINTAIN EXISTING FIRE SEPARATION RATINGS.
4. PROVIDE A NEW 200A 3 POLE BREAKER TO FEED PANEL DP-600-M.

LEGEND:

- ⊙ 3ø MOTOR LOAD
- ⊖ 1ø LOAD

1 MAIN FLOOR PLAN

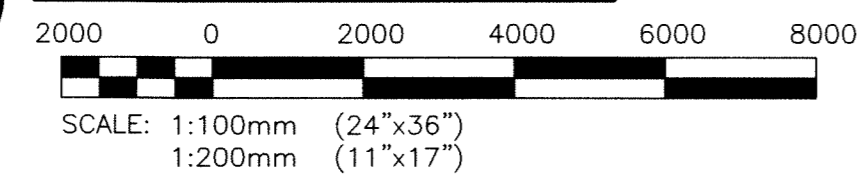

APEGM
Certificate of Authorization
KGS Group
No. 245 Date: 27/01/10

B.M.			
ELEV.			
DESIGNED BY	AP	CHECKED BY	
DRAWN BY	BGO	APPROVED BY	
HOR. SCALE:	AS SHOWN	RELEASED FOR CONSTRUCTION:	
VERTICAL:		DATE	
NO.	ISSUED FOR TENDER	DATE	BY
0		27/01/10	
	REVISIONS	DATE	BY

KGS GROUP
CONSULTING ENGINEERS & PROJECT MANAGERS
WINNIPEG (204) 896-1209
THUNDER BAY (807) 345-2233

DESIGNED BY: AP
DRAWN BY: BGO
HOR. SCALE: AS SHOWN
VERTICAL: .

ENGINEER'S SEAL
A.P.O. PAWLKIEWICZ
Member
23338
PROFESSIONAL ENGINEER

CONSULTANT DRAWING NO.
P1-E01

THE CITY OF WINNIPEG
PUBLIC WORKS DEPARTMENT

PROJECT TITLE
**FORT ROUGE LEISURE CENTRE
HVAC UPGRADES - PHASE 1**

MAIN FLOOR PLAN
POWER ARRANGEMENT

SHEET OF
001 001

COMPUTER FILE NAME
08-0107-09E01

CITY DRAWING NUMBER