


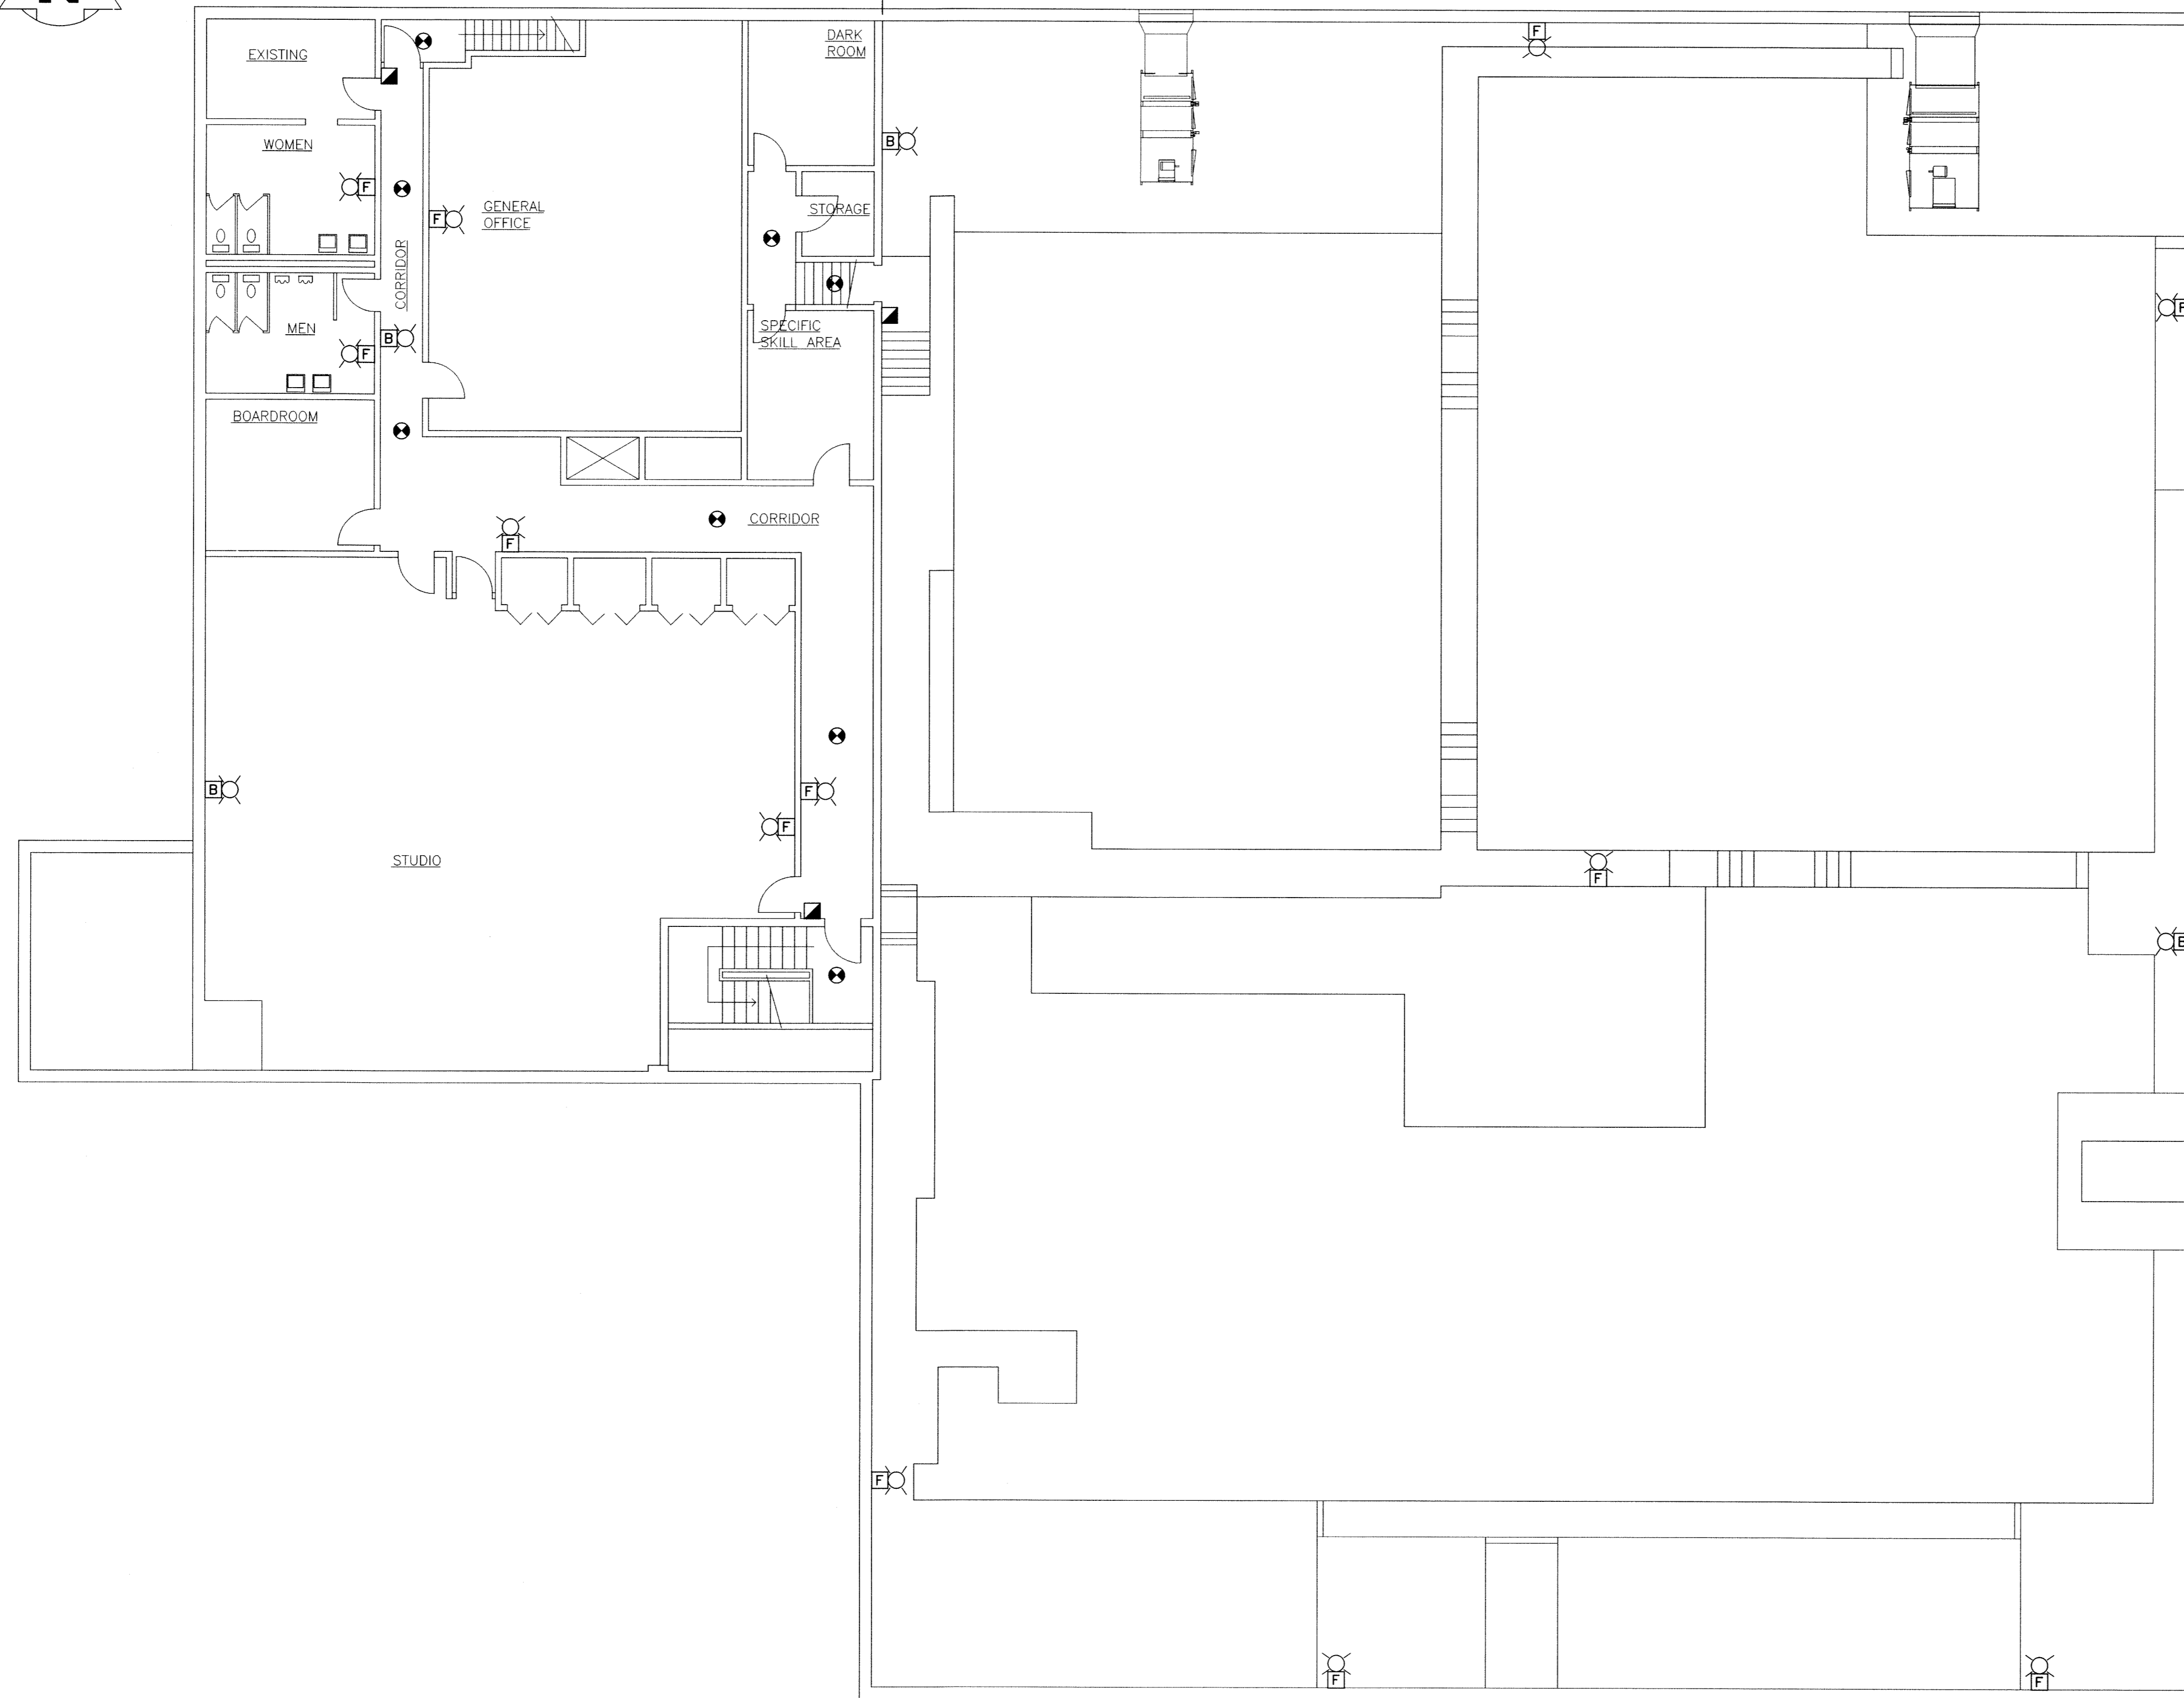






WEST WING EAST WING

NOTES:

1. -



  
 
LEGEND:

-  MAIN FIRE ALARM PANEL
-  SMOKE DETECTOR
-  HEAT DETECTOR
-  MANUAL PULLSTATION
-  FIRE ALARM STROBE LIGHT
-  FIRE ALARM BELL
-  FIRE ALARM BELL AND STROBE LIGHT

GENERAL NOTES:


ALL FIRE ALARM LOOPS SHALL BE RUN CLASS 'A' WITH ISOLATORS.


1 MEZZANINE/SECOND FLOOR PLAN

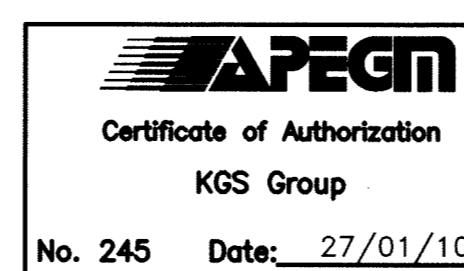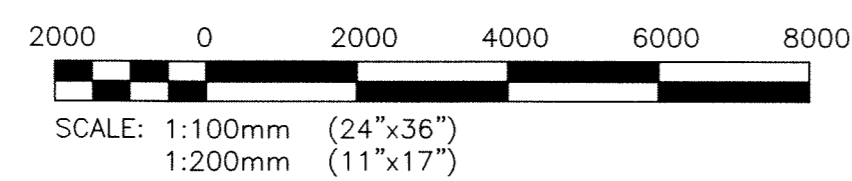

NO.	REVISIONS	DATE	BY
0	ISSUED FOR TENDER	27/01/10	

KGS GROUP		CONSULTING ENGINEERS & PROJECT MANAGERS	
WINNIPEG (204) 896-1209		THUNDER BAY (807) 345-2233	
DESIGNED BY: AP	CHECKED BY:	APPROVED BY:	RELEASED FOR CONSTRUCTION:
DRAWN BY: BGO			
HOR. SCALE: AS SHOWN			
VERTICAL:			

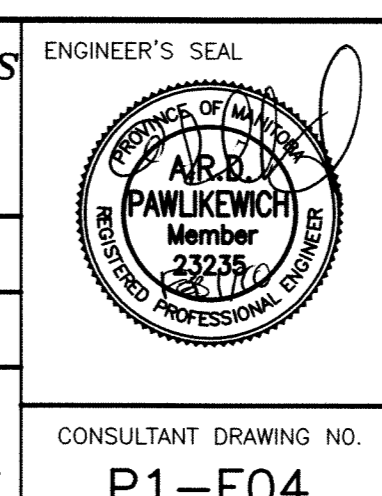

 THE CITY OF WINNIPEG PUBLIC WORKS DEPARTMENT		SHEET OF 001 001
PROJECT TITLE FORT ROUGE LEISURE CENTRE HVAC UPGRADES - PHASE 1		COMPUTER FILE NAME 08-0107-09E04
CONSULTANT DRAWING NO. P1-E04		CITY DRAWING NUMBER
SECOND/MEZZANINE FLOOR PLAN FIRE ALARM ARRANGEMENT		