


- SCOPE OF WORK NOTES: (CONTINUED)
- ⑤ NEW STAIR FROM CEILING SPACE - SEE PARTIAL PLAN AND DETAILS ON DRAWING S-3.
  - ⑥ INFILL WALL OPENING - SEE DRAWING M-1, NOTE 5.
  - ⑦ INFILL CEILING OPENINGS AFTER REMOVING DIFFUSERS - SEE DRAWING M-1, NOTE 8.
  - ⑧ PROVIDE NEW 2 HOUR FIRE RATED DOUBLE DOOR AND FRAME C/W PANIC HARDWARE TO SUIT 213x1830mm OPENING.

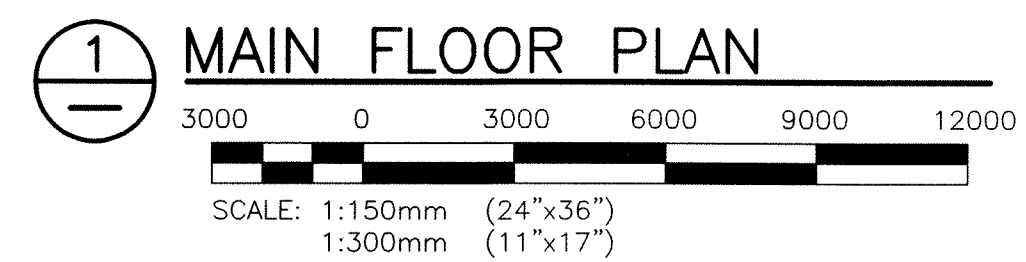

**APEGM**  
Certificate of Authorization  
KGS Group  
No. 245 Date: 10/01/28

B.M. ELEV. :  NO. REVISIONS : DATE : BY :	<b>KGS GROUP</b> CONSULTING ENGINEERS & PROJECT MANAGERS WINNIPEG (204) 896-1209 THUNDER BAY (807) 345-2233		ENGINEER'S SEAL 	<b>THE CITY OF WINNIPEG</b> PUBLIC WORKS DEPARTMENT PROJECT TITLE <b>FORT ROUGE LEISURE CENTRE</b> <b>HVAC UPGRADES - PHASE 1</b>	SHEET OF <b>002 003</b> COMPUTER FILE NAME <b>08-0107-09-P1-S2</b> CITY DRAWING NUMBER
	DESIGNED BY: RJL	CHECKED BY:	CONSULTANT DRAWING NO. <b>P1-S2</b>	<b>MAIN FLOOR PLAN</b>	
	DRAWN BY: MB	APPROVED BY:			
	HOR. SCALE: AS SHOWN	RELEASED FOR CONSTRUCTION:			
0 ISSUED FOR TENDER 10/01/28	DATE	DATE	DATE		