 



PLAN
SCALE: 1 : 10



FRONT ELEVATION
SCALE: 1 : 10

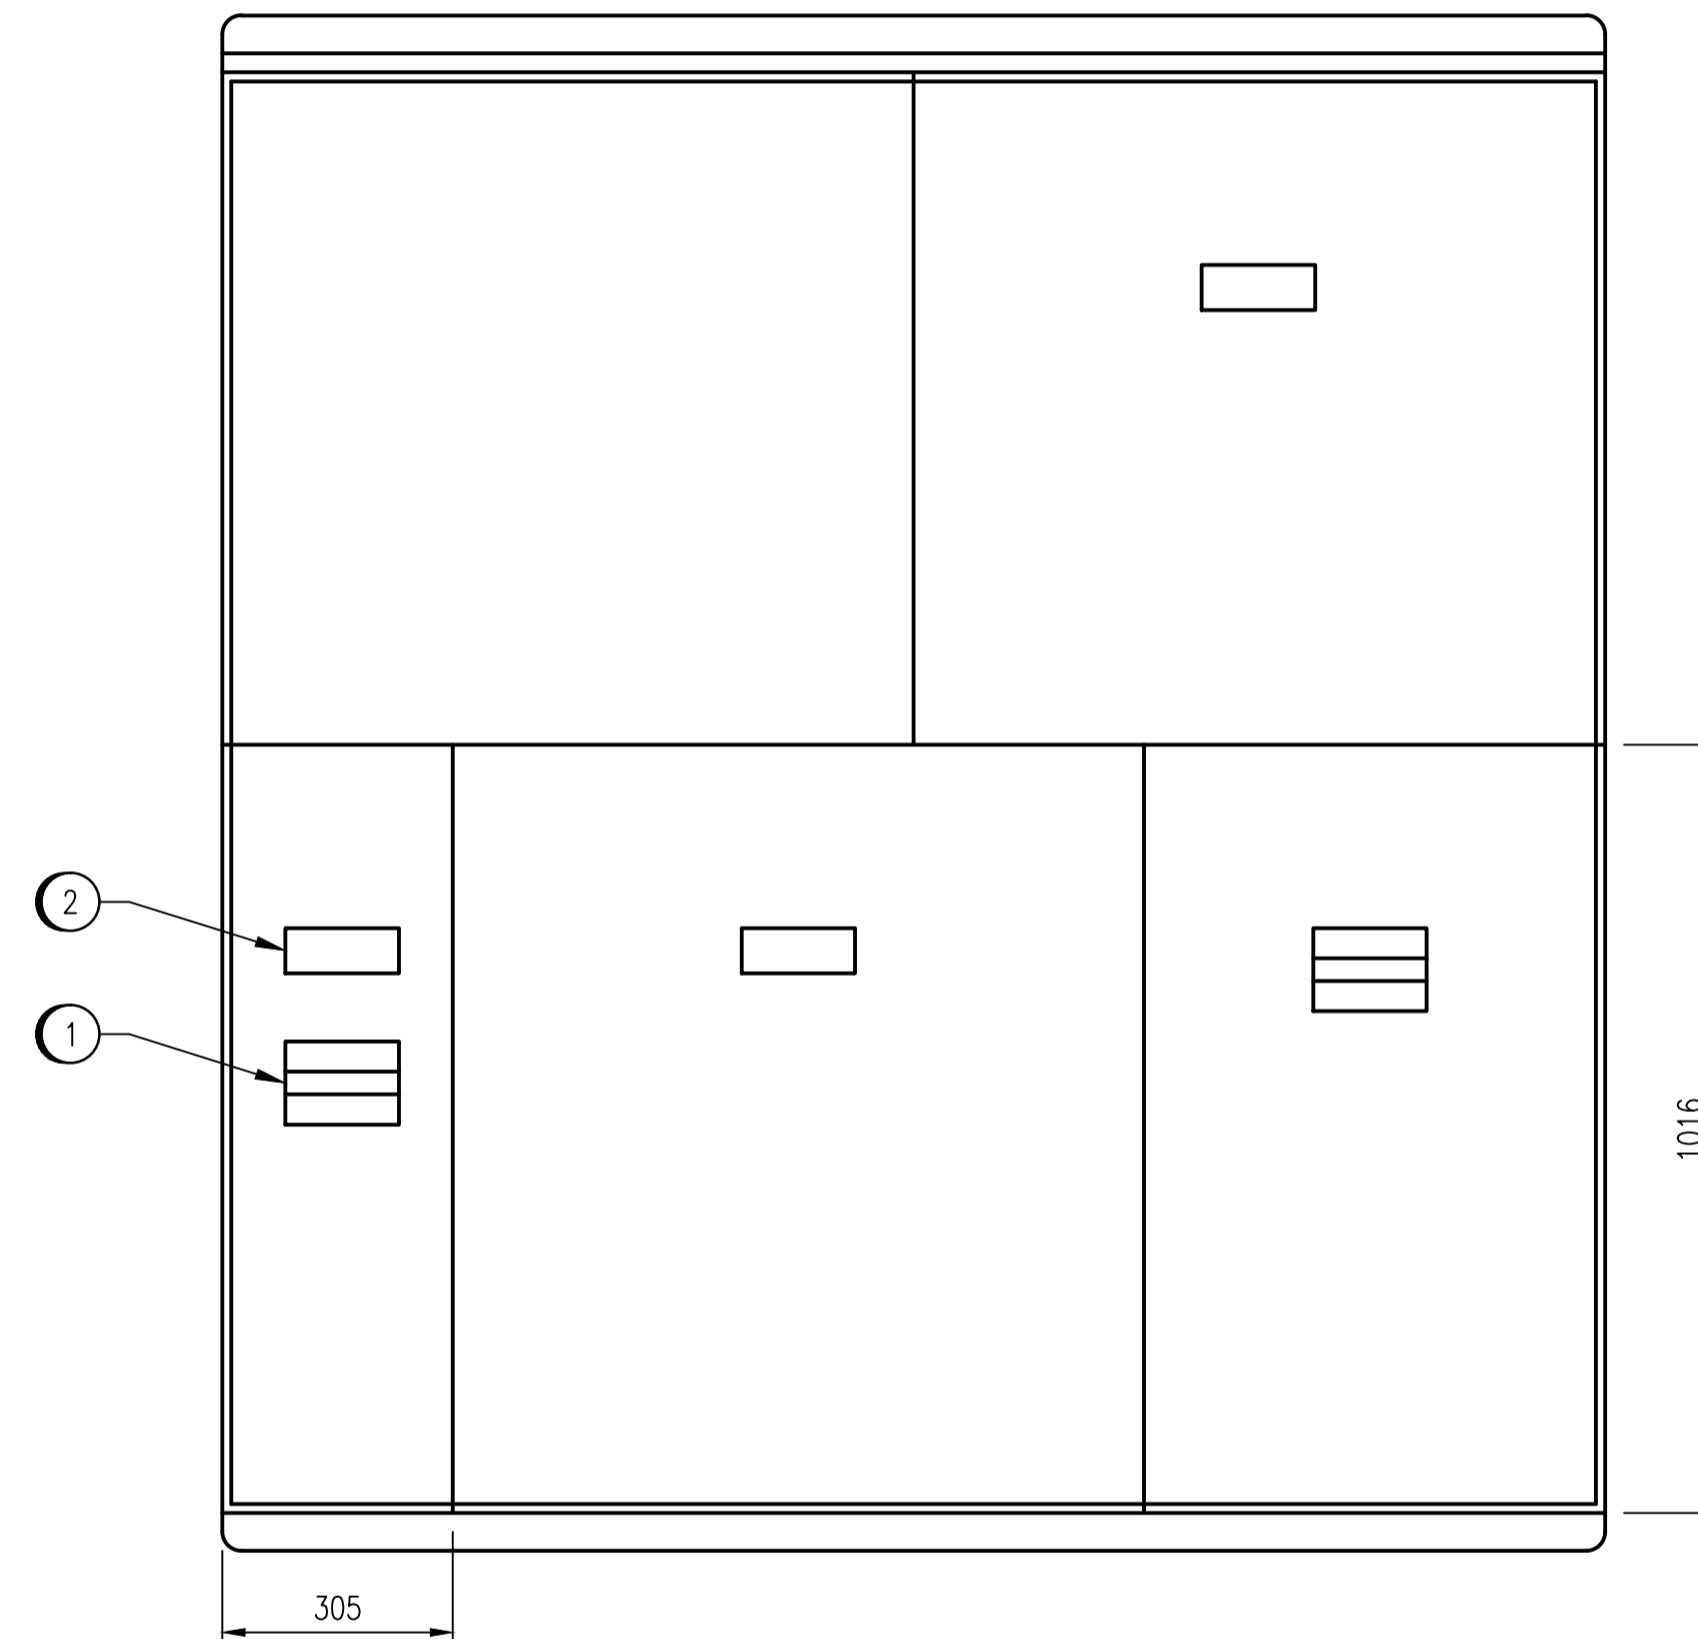

FRONT ELEVATION LESS OUTER DOOR
SCALE: 1 : 10

INSTALLATION NOTES:

- ① MODIFY CSTE TO INSTALL NEW 600A BREAKER WITH LS TRIP UNIT. REPLACE SPLITTER TAP AND CABLES AS REQUIRED. PROVIDE BONDING LUG FOR TERMINATING 3 AWG BONDING CONDUCTOR. MODIFICATIONS TO BE FIELD INSPECTED AND APPROVED BY THE DEPARTMENT OF LABOUR.
- ② INSTALL NEW LAMACOID. REFER TO LAMACOID SCHEDULE.

NOTES:

1. SHOP DRAWINGS: J.R. STEPHENSON FACTORY ORDER NUMBER J-1368-89.



				SNC-LAVALIN INC. 148 Nature Park Way Winnipeg, MB, Canada R3P 0X7 204-798-8080		ENGINEER'S SEAL		THE CITY OF WINNIPEG WATER AND WASTE DEPARTMENT		
				DESIGNED BY: B. CLEVEN	CHECKED BY: C. REIMER	ORIGINAL DRAWING SEALED BY: C. REIMER SNC-LAVALIN INC. 2010/10/02 REV. 00		MARION FLOOD PUMPING STATION INSTALLATION OF PUMPING UNITS & BUILDING UPGRADES PANEL LAYOUT CSTE		
				DRAWN BY: S. COATES	APPROVED BY: C. REIMER					
				SCALE: 1:10	RELEASED FOR CONSTRUCTION BY: K. ZUREK					
				DATE: 2010/07/29	DATE: 2010/10/04					
				CONSULTANT NO.: 1133368-0000-47DD-0102		CITY DRAWING NUMBER				
00 ISSUED FOR TENDER				2010/09/29	BC	CJR	BID OPP.: 760-2010		1-0159F-E0002	
NO. REVISIONS				DATE	DESIGN	CHECK	SHEET REV. SIZE		001 00 A1	