
 


MAIN FLOOR PLAN
SCALE: 1 : 40
-TOP OF NEW FLOOR TO MATCH TOP OF EXIST.

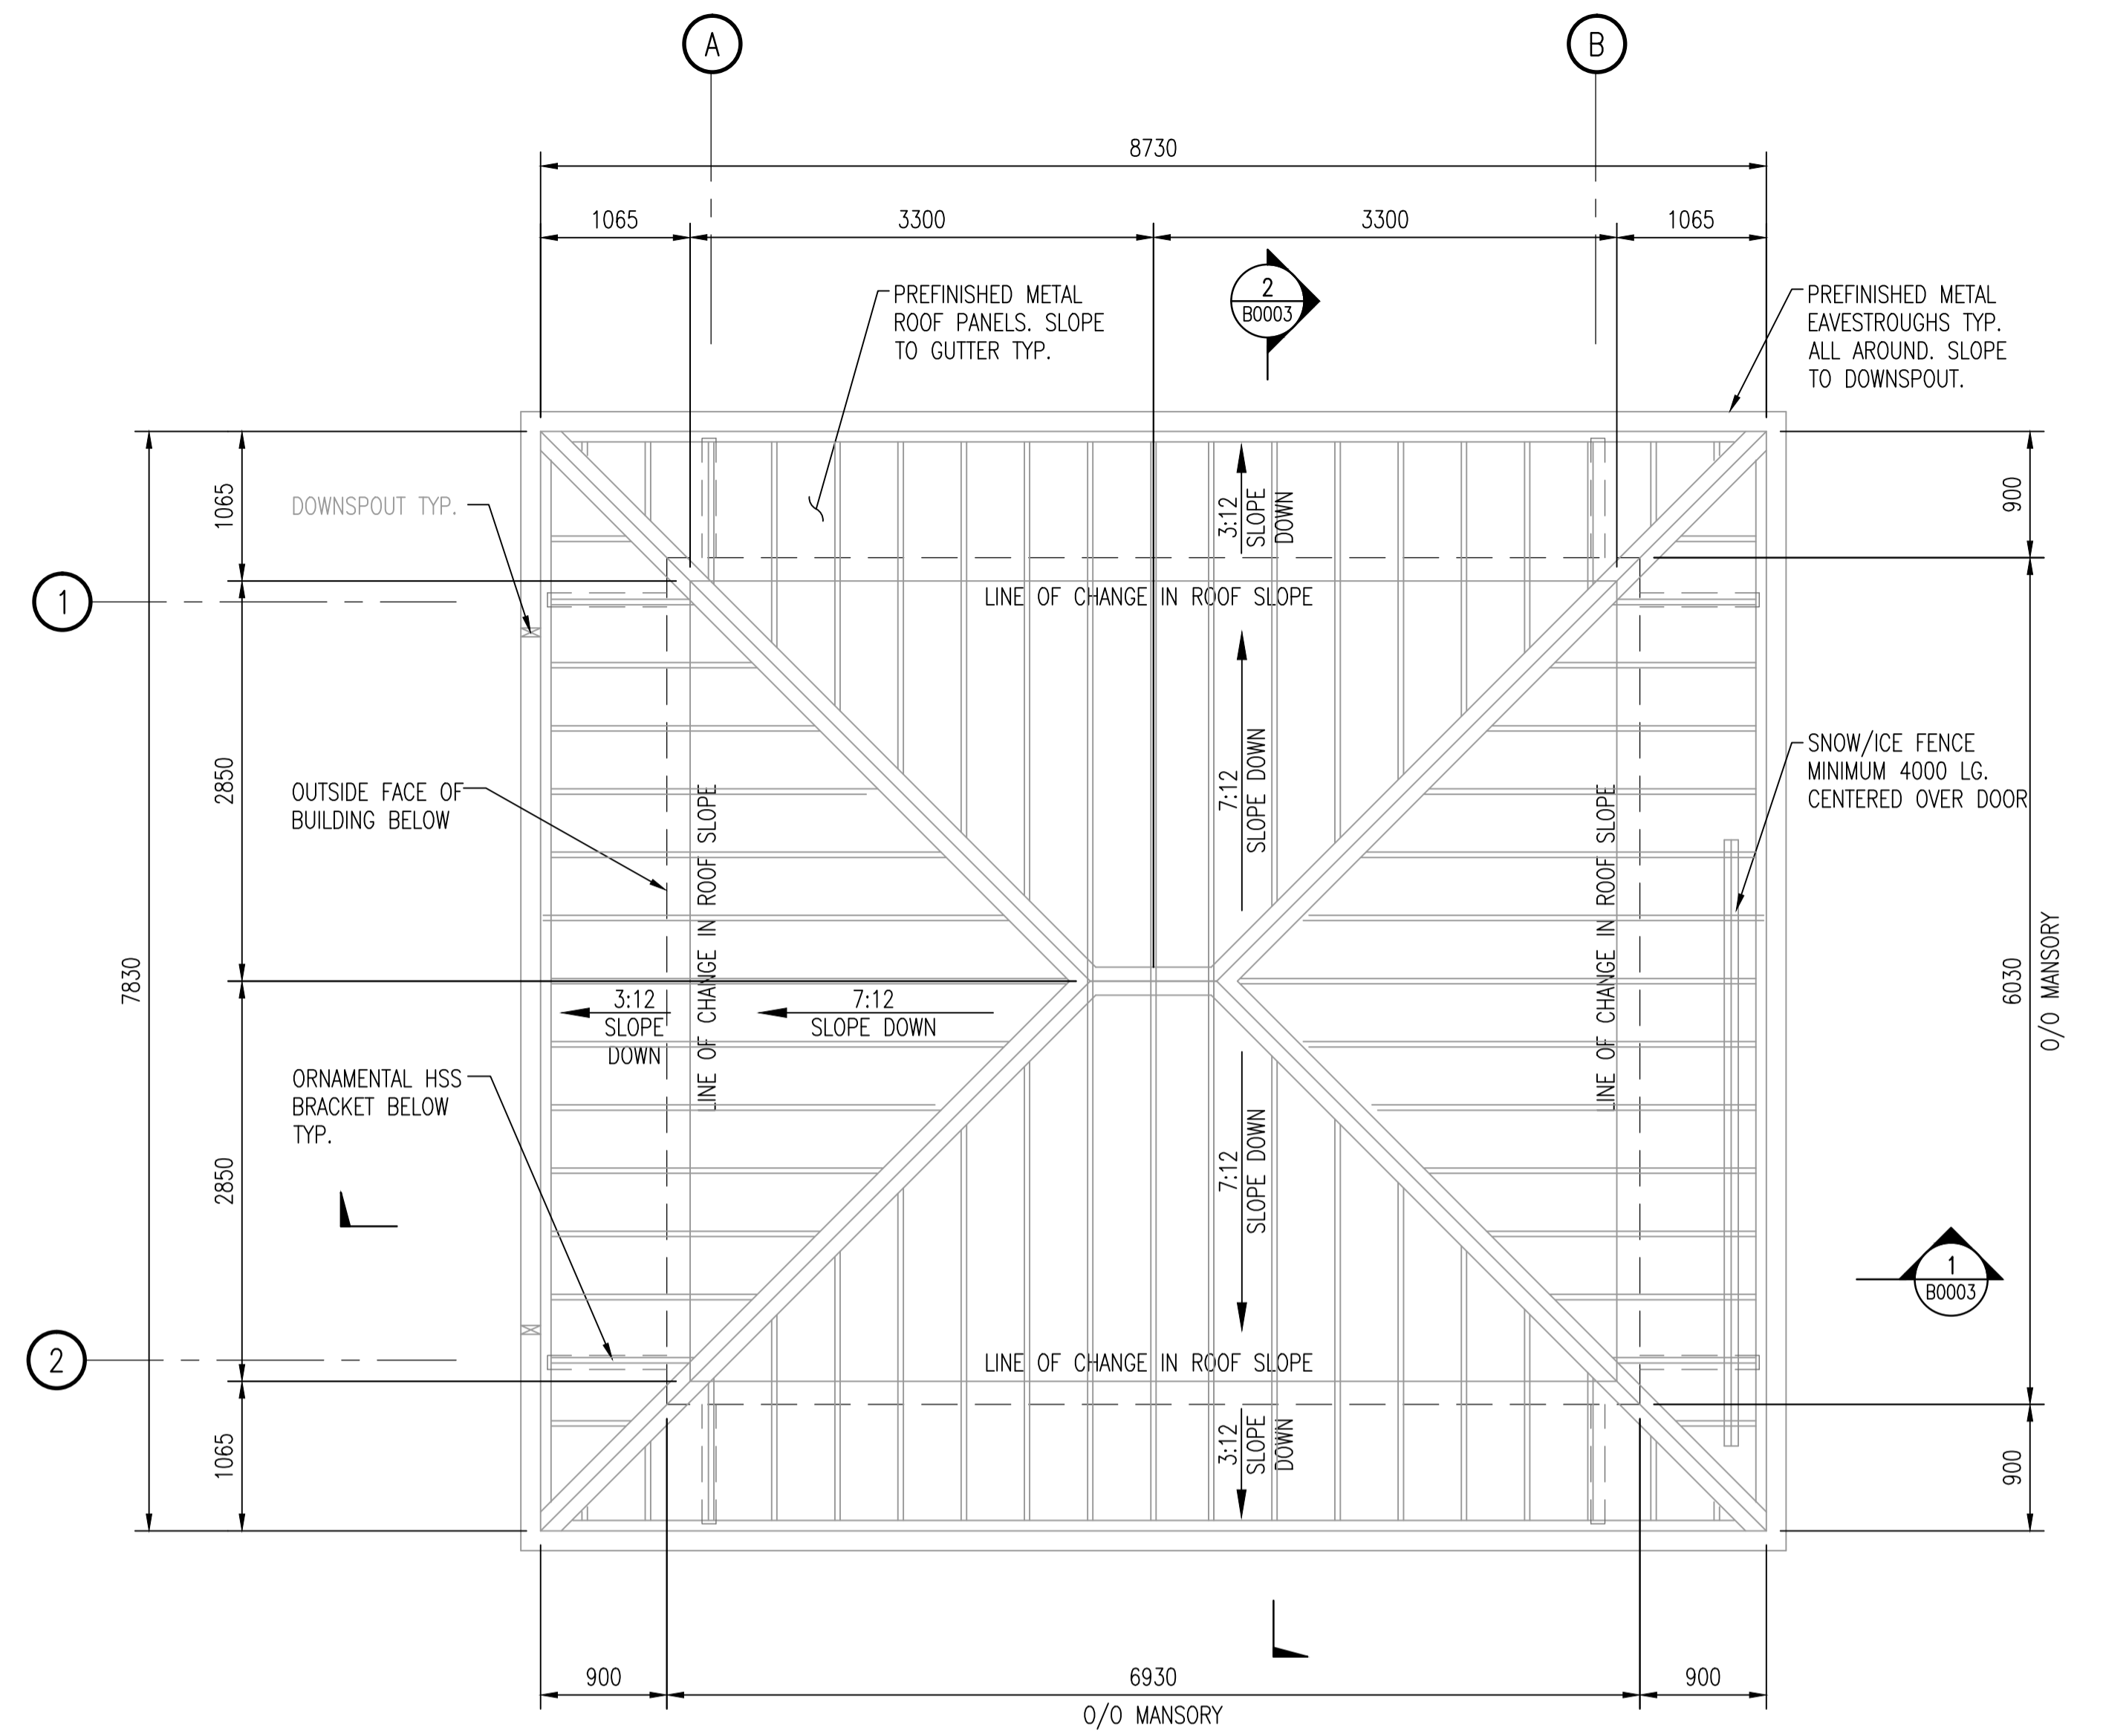

ROOF PLAN
SCALE: 1 : 40



APECM
Certificate of Authorization
SNC-Lavalin Inc.
No. 4489

<p>SNC-LAVALIN INC. 148 Nature Park Way Winnipeg, MB, Canada R3P 0X7 204-786-8080</p>		<p>ENGINEER'S SEAL</p> <p>ORIGINAL DRAWING SEALED BY: NEIL COOPER 2010/10/01 REV. 00</p>	<p> THE CITY OF WINNIPEG WATER AND WASTE DEPARTMENT</p> <p>MARION WASTEWATER PUMPING STATION INSTALLATION OF PUMPING UNITS & BUILDING UPGRADES PLAN MAIN FLOOR AND ROOF</p>
<p>DESIGNED BY: A. DEGER</p> <p>DRAWN BY: L. GAO</p> <p>SCALE: 1:40</p> <p>DATE: 2010/07/07</p>	<p>CHECKED BY: N. COOPER</p> <p>APPROVED BY: C. REIMER</p> <p>RELEASED FOR CONSTRUCTION BY: K. ZUREK</p> <p>DATE: 2010/10/04</p>	<p>BID OPP.: 760-2010</p>	<p>CITY DRAWING NUMBER 1-0159L-B0002</p> <p>SHEET 001</p> <p>REV. 00</p> <p>SIZE A1</p>
<p>00 ISSUED FOR TENDER</p>	<p>2010/10/01</p>	<p>AD NC</p>	<p>CONSULTANT NO.: 113368-0000-44DD-0002</p>
<p>NO. REVISIONS</p>	<p>DATE</p>	<p>DESIGN CHECK</p>	<p>113368-0000-44DD-0002</p>