
 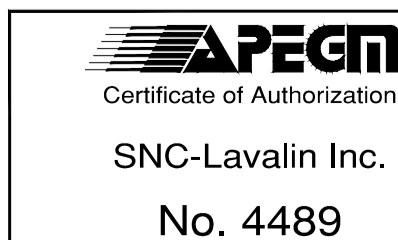


THIS DRAWING IS ONLY A SKETCH BASED ON EXISTING DRAWINGS AND A CURSORY SITE VISIT. THE LOCATION OF UNDERGROUND STRUCTURES AND DIMENSIONS ARE NOT EXACT. NO GUARANTEE IS GIVEN THAT ALL EXISTING UTILITIES ARE SHOWN ON THE DRAWING AND CONFIRMATION OF EXISTENCE AND EXACT LOCATION MUST BE OBTAINED FROM THE INDIVIDUAL UTILITIES BY THE CONTRACTOR BEFORE PERFORMING THE WORK. SITE ELEVATIONS ARE BASED ON EXISTING DRAWINGS AND UNCONFIRMED. ALL ELEVATIONS MUST BE SITE CONFIRMED AND COORDINATED WITH THE ASSUMED FINISHED ELEVATIONS BY THE CONTRACTOR BEFORE FOUNDATION WORK BEGINS.

SITE PLAN
SCALE: 1 : 100

LEGEND

- NEW BUILDING: _____
- DEMOLISHED: - - - - -
- REMAINED EXIS. STRUCTURE: _____



00	ISSUED FOR TENDER	2010/10/01	AD	NC
NO.	REVISIONS	DATE	DESIGN	CHECK

SNC-LAVALIN INC.
148 Nature Park Way
Winnipeg, MB, Canada R3P 0X7
204-786-8080

DESIGNED BY: A. DEGER
DRAWN BY: L. GAO
SCALE: 1:100
DATE: 2010/07/07

CHECKED BY: N. COOPER
APPROVED BY: C. REIMER
RELEASED FOR CONSTRUCTION BY: K. ZUREK
DATE: 2010/10/04

CONSULTANT NO.: 113368-0000-41DD-0001

ENGINEER'S SEAL

ORIGINAL DRAWING
SEALED BY:
NEIL COOPER
2010/10/01
REV. 00

BID OPP: 760-2010

THE CITY OF WINNIPEG
WATER AND WASTE DEPARTMENT

Winnipeg

MARION WASTEWATER PUMPING STATION
INSTALLATION OF PUMPING UNITS & BUILDING UPGRADES
SITE PLAN

CITY DRAWING NUMBER: 1-0159L-C0001
SHEET: 001
REV: 00
SIZE: A1