


- INSTALLATION NOTES:
- ① TO LIGHT FIXTURES ON LOWER LEVELS (MOTOR ROOM AND PUMP ROOM).
 - ② TO LIGHT FIXTURES IN COMMUNOTOR AND GATE CHAMBER.

MAIN FLOOR PLAN
SCALE: 1 : 20

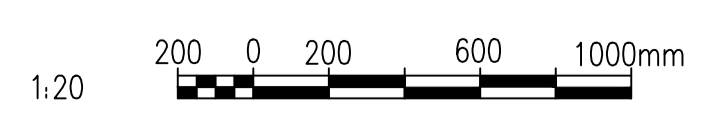

LAST SAVE: 2010/10/04 - 1:26pm
PATH: M:\113368\ENGS\47\ELE\DO - General DWG\1-0159L-E0005-001-00.dwg

1-0159L-E0008	ELECTRICAL SCHEDULES
DRAWING NUMBER	REFERENCE DRAWINGS

NO.	REVISIONS	DATE	DESIGN	CHECK
00	ISSUED FOR TENDER	2010/09/29	BC	CJR

SNC-LAVALIN INC.
148 Nature Park Way
Winnipeg, MB, Canada R3P 0X7
204-786-8080

DESIGNED BY: B. CLEVEN
DRAWN BY: S. COATES
SCALE: 1:20
DATE: 2010/06/30

CHECKED BY: C. REIMER
APPROVED BY: C. REIMER
RELEASED FOR CONSTRUCTION BY: K. ZUREK
DATE: 2010/10/04

CONSULTANT NO.: 113368-0000-47DD-0005

ENGINEER'S SEAL

ORIGINAL DRAWING
SEALED BY:
C. REIMER
SNC-LAVALIN INC.
2010/10/02
REV. 00

BID OPP.: 760-2010

THE CITY OF WINNIPEG
WATER AND WASTE DEPARTMENT

Marion Wastewater Pumping Station

LIGHTING PLAN LAYOUT
MAIN FLOOR

CITY DRAWING NUMBER: 1-0159L-E0005

SHEET	REV.	SIZE
001	00	A1