


DETAIL: TRENCH LAYOUT
SCALE: 1 : 10

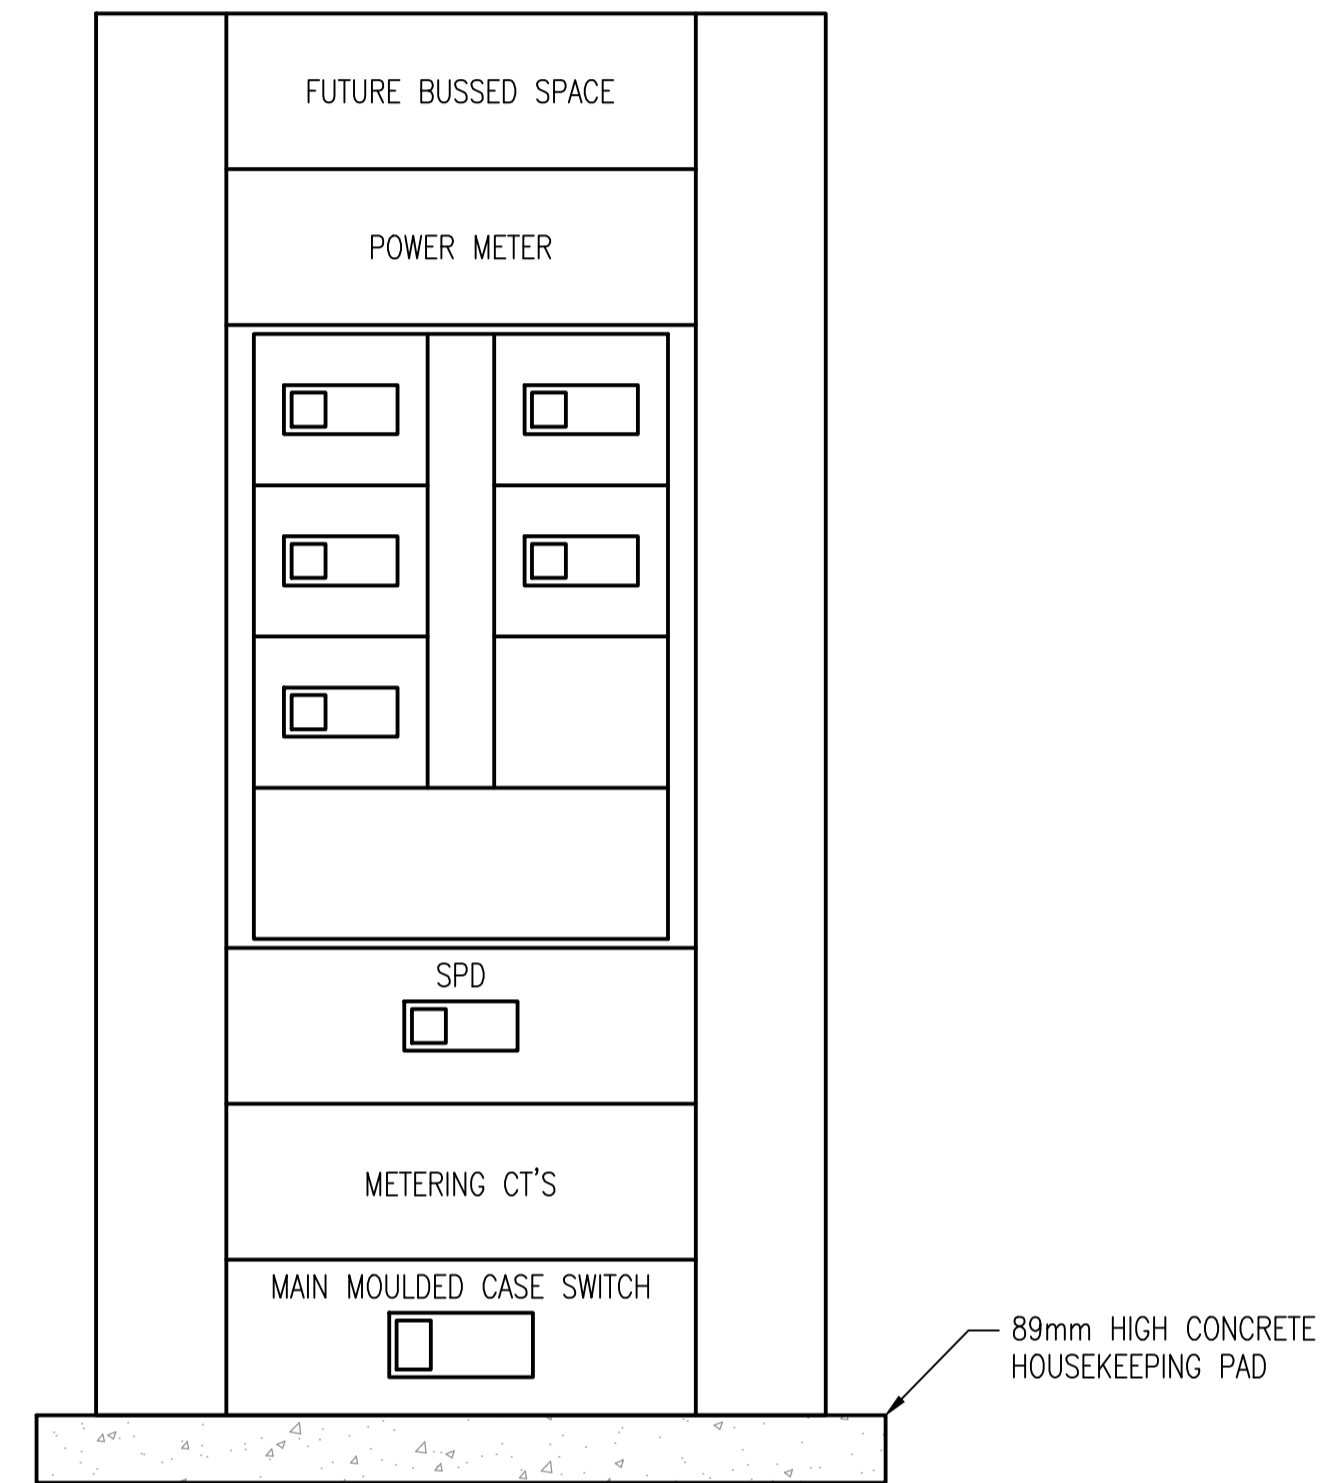

MAIN DISTRIBUTION PANEL ELEVATION
SCALE: NTS

1-0159L-C0001	SITE PLAN
DRAWING NUMBER	REFERENCE DRAWINGS



NO.	REVISIONS	DATE	DESIGN	CHECK
00	ISSUED FOR TENDER	2010/09/29	BC	CJR

SNC-LAVALIN INC.
148 Nature Park Way
Winnipeg, MB, Canada R3P 0X7
204-786-8080

DESIGNED BY: B. CLEVEN
DRAWN BY: S. COATES
SCALE: AS SHOWN
DATE: 2010/07/29

CHECKED BY: C. REIMER
APPROVED BY: C. REIMER
RELEASED FOR CONSTRUCTION BY: K. ZUREK
DATE: 2010/10/04

CONSULTANT NO.: 113368-0000-47DD-0016

ENGINEER'S SEAL

ORIGINAL DRAWING
SEALED BY:
C. REIMER
SNC-LAVALIN INC.
2010/10/02
REV. 00

BID OPP.: 760-2010

Winnipeg THE CITY OF WINNIPEG
WATER AND WASTE DEPARTMENT

MARION WASTEWATER PUMPING STATION
INSTALLATION OF PUMPING UNITS & BUILDING UPGRADES
ELECTRICAL DETAILS

CITY DRAWING NUMBER
1-0159L-E0016

SHEET REV. SIZE
001 00 A1