
 


ROOF FRAMING PLAN
SCALE: 1 : 40

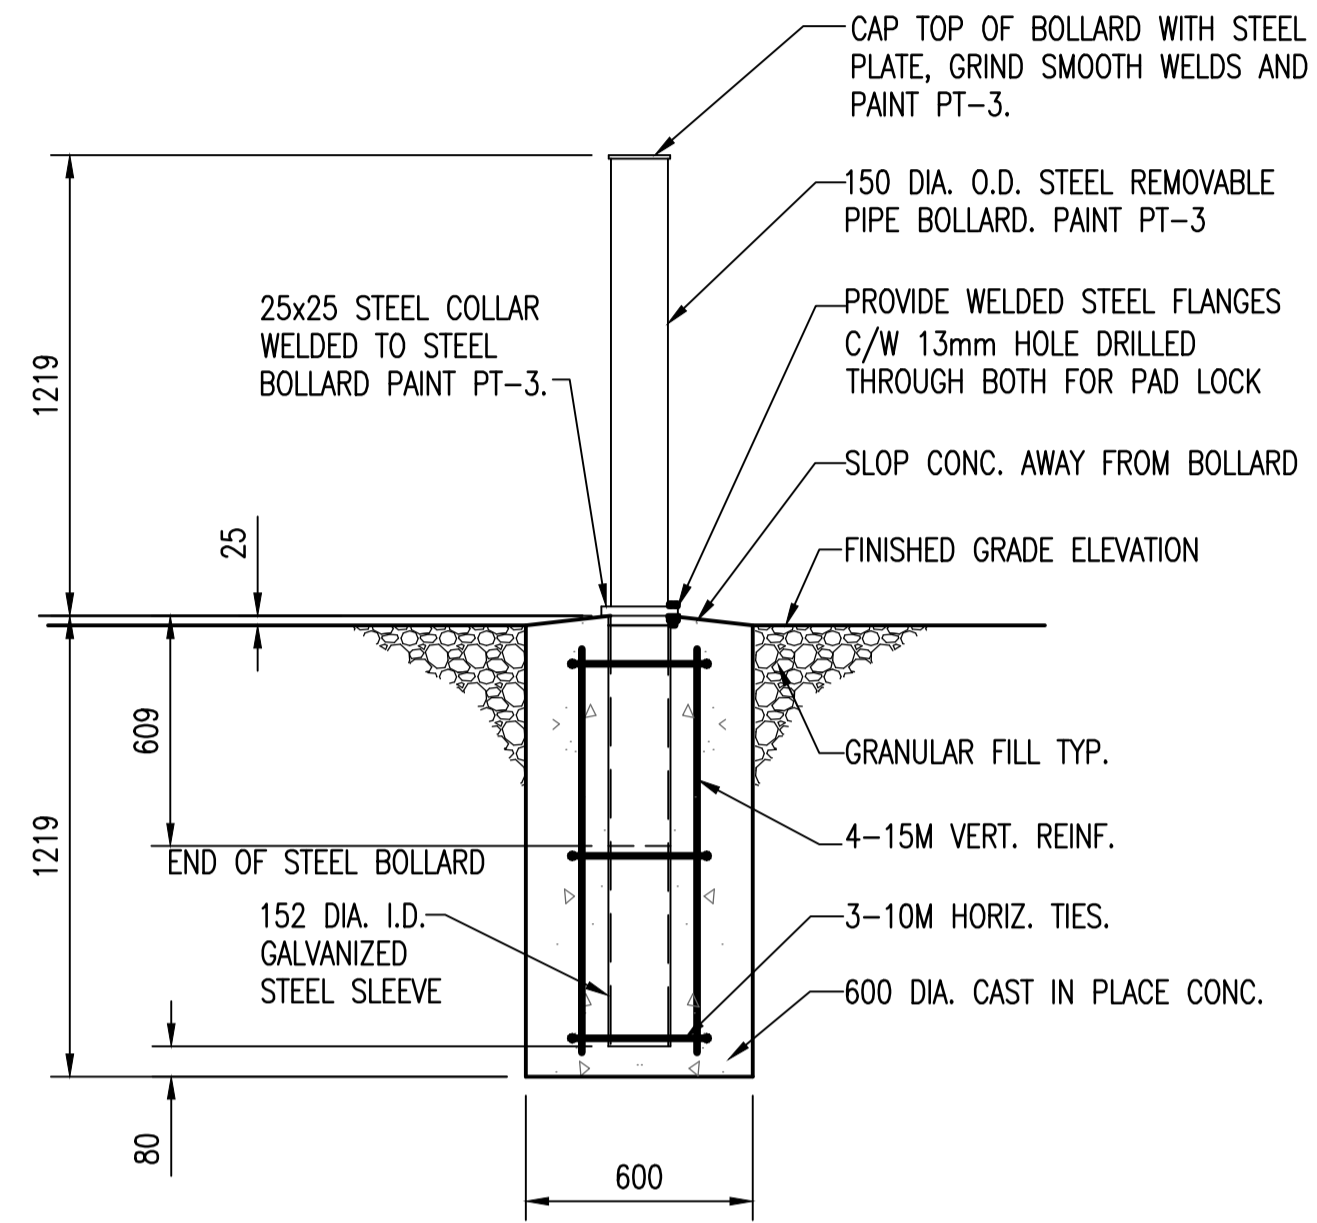

REMOVABLE BOLLARD DETAIL
SCALE: 1 : 20



APECM
Certificate of Authorization
SNC-Lavalin Inc.
No. 4489

NO.	REVISIONS	DATE	DESIGN	CHECK
00	ISSUED FOR TENDER	2010/10/01	AD	RB

		SNC-LAVALIN INC. 148 Nature Park Way Winnipeg, MB, Canada R3P 0X7 204-786-8080	
DESIGNED BY:	A. DEGER	CHECKED BY:	R. BEAN
DRAWN BY:	L. GAO	APPROVED BY:	C. REIMER
SCALE:	1:40	RELEASED FOR CONSTRUCTION BY:	K. ZUREK
DATE:	2010/08/27	DATE:	2010/10/04
CONSULTANT NO.:	113368-0000-42DD-0001		

ENGINEER'S SEAL
ORIGINAL DRAWING
SEALED BY:
ANTHONY DEGER
SNC-LAVALIN
2010/10/01
REV. 00

		THE CITY OF WINNIPEG WATER AND WASTE DEPARTMENT	
MARION WASTEWATER PUMPING STATION INSTALLATION OF PUMPING UNITS & BUILDING UPGRADES PLAN ROOF FRAMING			
CITY DRAWING NUMBER	1-0159L-S0005	SHEET	001
REV.	00	SIZE	A1