




SITE PLAN
SCALE: 1:250

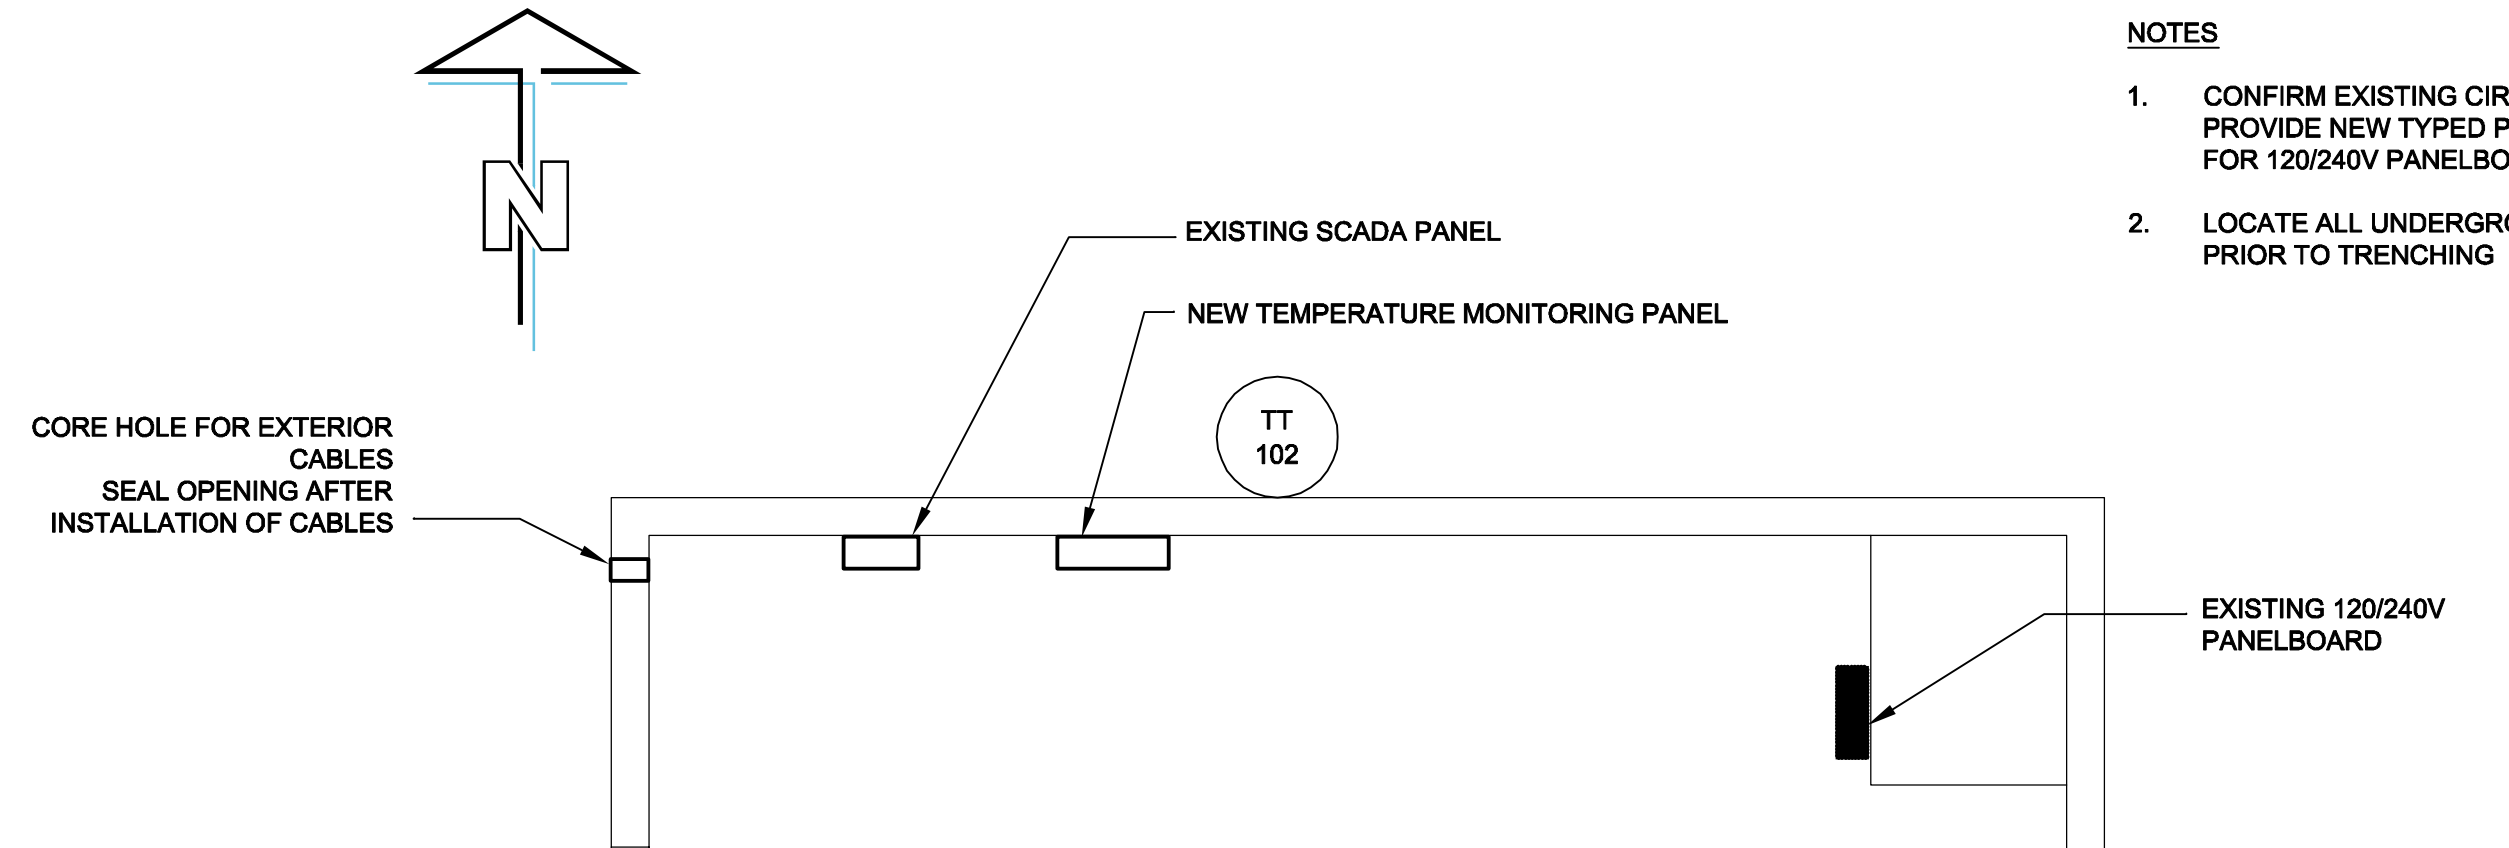

- NOTES**
- CONFIRM EXISTING CIRCUITS AND PROVIDE NEW TYPED PANEL DIRECTORY FOR 120/240V PANELBOARD.
 - LOCATE ALL UNDERGROUND UTILITIES PRIOR TO TRENCHING

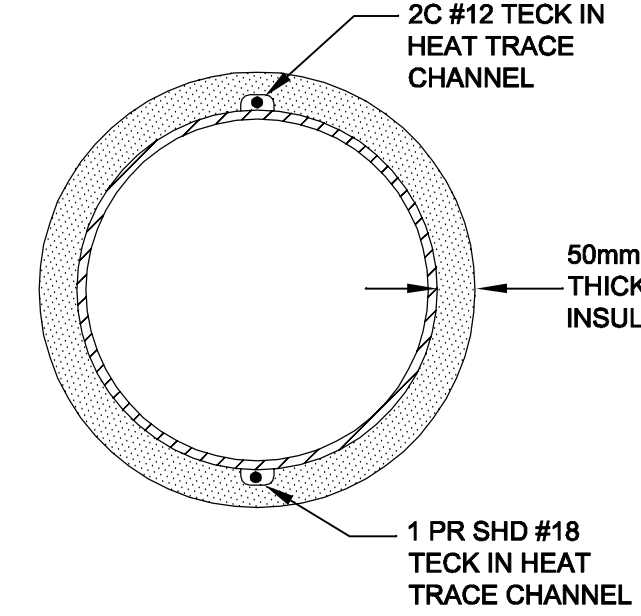

SECTION A
SCALE: NTS
HEAT TRACING

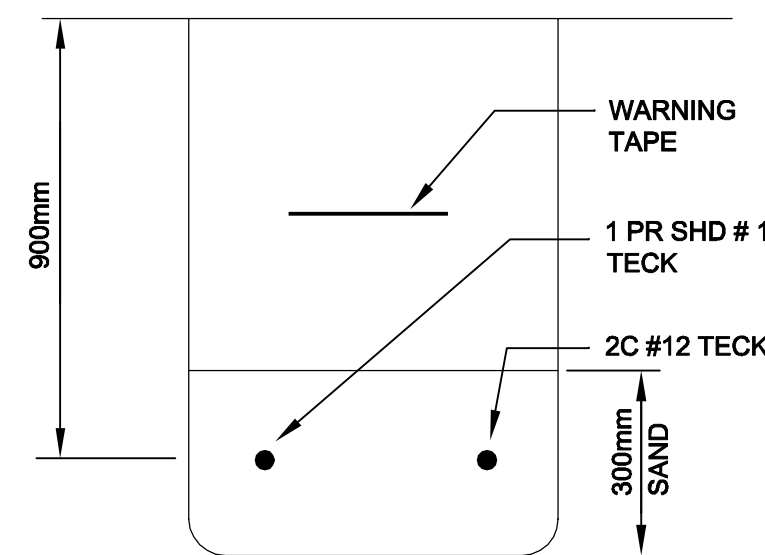

SECTION B
SCALE: NTS
TRENCH

120/240V PANELBOARD								
CCT NO	DESCRIPTION	LOAD	TRIP AMPS	N AB	TRIP AMPS	LOAD	DESCRIPTION	CCT NO
01	USED						DOWNSTAIRS LIGHTS	02
03	UPSTAIRS LIGHTS							04
05	SUMP PUMP				15		GFCI BREAKER - HEAT TRACE	06
07	USED				15		TEMPERATURE MONITORING PANEL	08
09	DOWNSTAIRS LIGHTS						SPACE	10
11	USED						SPACE	12
13	USED						SPACE	14
15	CONTROL PANEL						SPACE	16
17	OUTSIDE LIGHTS						SPACE	18
19	SPARE						SPACE	20
21	SPARE						SPACE	22
23	SPARE						SPACE	24

VOLTAGE: 120/240 PHASE: 1 WIRE: - BREAKER I.C.: -
 MAIN BREAKER: 125A MAINS: - FEEDER: -
 MOUNTING: - LOCATION: -
 FED FROM: -
 NOTES: SQUARE D QO-24M

PLAN 1
SCALE: 1:50
FLOOR PLAN

LOCATION APPROVED UNDERGROUND STRUCTURES

SUPR. U/G STRUCTURES DATE COMMITTEE
 NOTE: LOCATION OF UNDERGROUND STRUCTURES AS SHOWN ARE BASED ON THE BEST INFORMATION AVAILABLE. BUT NO GUARANTEE IS GIVEN THAT ALL EXISTING UTILITIES ARE SHOWN OR THAT THE GIVEN LOCATIONS ARE EXACT. CONFIRMATION OF EXISTENCE AND EXACT LOCATION OF ALL SERVICES MUST BE OBTAINED FROM THE INDIVIDUAL UTILITIES BEFORE PROCEEDING WITH CONSTRUCTION.



NO.	REVISIONS	DATE	BY
0	ISSUED FOR CONSTRUCTION	11/05/09	Wjd

<p>This drawing has been prepared for the use of AECOM's client and may not be used, reproduced or relied upon by third parties, except as signed by AECOM and its client, as required by law or for use by governmental reviewing agencies. AECOM accepts no responsibility, and denies any liability whatsoever, to any party that modifies this drawing without AECOM's express written consent. Do not scale this document. All measurements must be obtained from stated dimensions.</p>			
DESIGNED BY	BM	CHECKED BY	SS
DRAWN BY	SCK	APPROVED BY	AN
HOR. SCALE	1:250	RELEASED FOR CONSTRUCTION	
VERT. SCALE	-		K. Zurek
DATE			May 11/11

PROFESSIONAL'S SEAL
 REVISION '0'
 Issued For Construction
 Sealed By:
 B. L. MOORE
 May 11/11
 CONSULTANT DRAWING NO.
 D265-230-002_01-E-T001

BID OPPORTUNITY NO. 854-2010

THE CITY OF WINNIPEG
WATER AND WASTE DEPARTMENT

REHABILITATION / REPLACEMENT OF THE MID TOWN FEEDERMAIN AT THE ASSINIBOINE RIVER
ELECTRICAL
PARTIAL SITE PLAN AND BUILDING FLOOR PLAN

SHEET 12 OF 18	REV 0
CITY DRAWING NUMBER	D-12238