


2 MEZZANINE FLOOR PLAN
SCALE 1:100

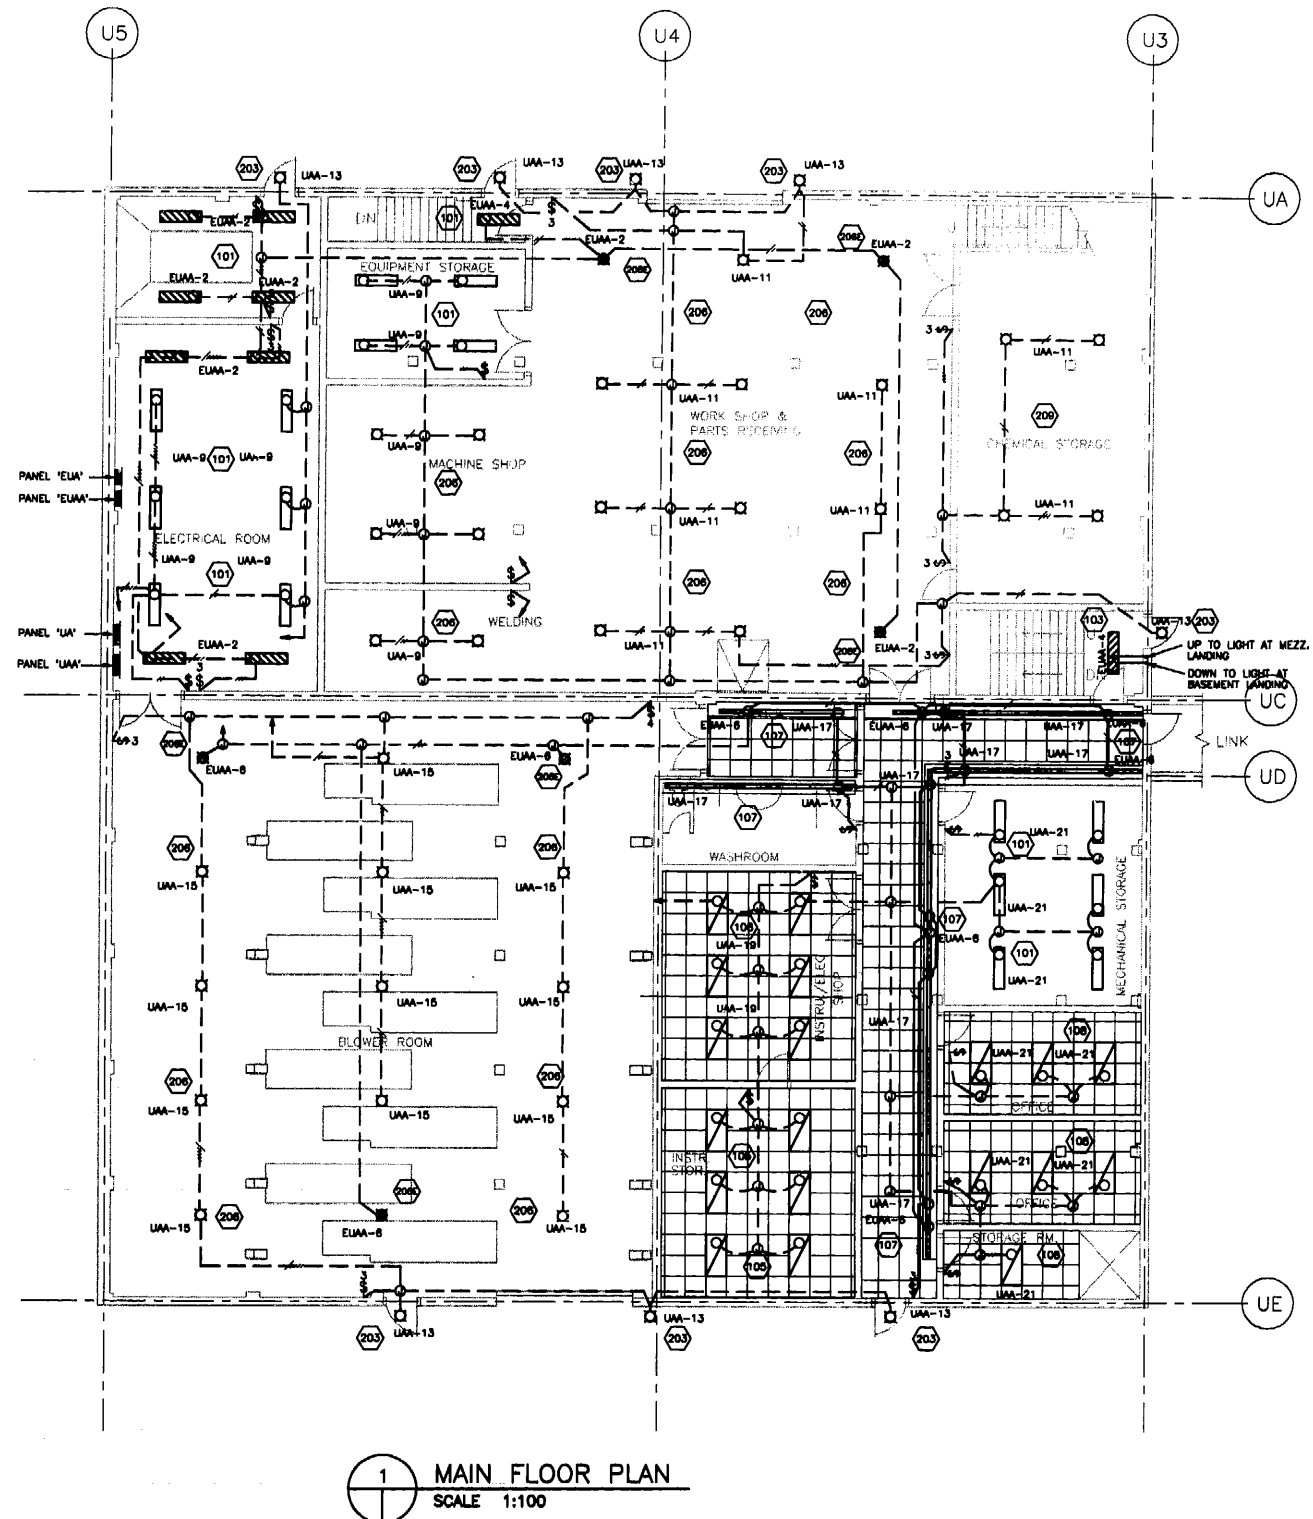

1 MAIN FLOOR PLAN
SCALE 1:100

THE ENGINEER THAT SEALED THIS DRAWING IS RESPONSIBLE FOR ONLY THE AS-CONSTRUCTED CHANGES ON THIS DRAWING. THE ORIGINAL DESIGN WAS THE RESPONSIBILITY OF THE DESIGN ENGINEER WHO SEALED THE ISSUED FOR TENDER DRAWINGS IN 1991.

REID, CROWTHER & PARTNERS LIMITED
WINNIPEG
AS CONSTRUCTED
SIG. DATE APR 23 91


detail symbol
A detail number
B drawing where detail shown
C cross reference to drawing where detail taken



B.M. 68-006	
ELEV. 237.636 m	
1 AS BUILT	93/11 DE
0 ISSUED FOR TENDER	
NO. REVISIONS	DATE BY

Reid Crowther

DESIGNED BY	LT	CHECKED BY	DJS
DRAWN BY	EJS	APPROVED BY	
HOR. SCALE:	100	RELEASED FOR CONSTRUCTION:	
VERTICAL:		DATE	91-06-06

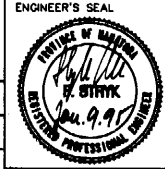

CONSULTANT DRAWING NO. 80910 - UE6

THE CITY OF WINNIPEG
WORKS AND OPERATIONS DIVISION
WATERWORKS WASTE AND DISPOSAL DEPT.

WEST END WATER POLLUTION CONTROL CENTRE
AREA U - UTILITY/BLOWER BUILDING
UTILITY/BLOWER BUILDING ELECTRICAL LIGHTING LAYOUT

CITY DRAWING NUMBER
SHEET OF
WEP-326

File # WS10380