


WINNIPEG STATION  
GROSS FLOOR AREA: 7,427 SQ. FT.

OCCUPANT LOAD : 6 PERSONS

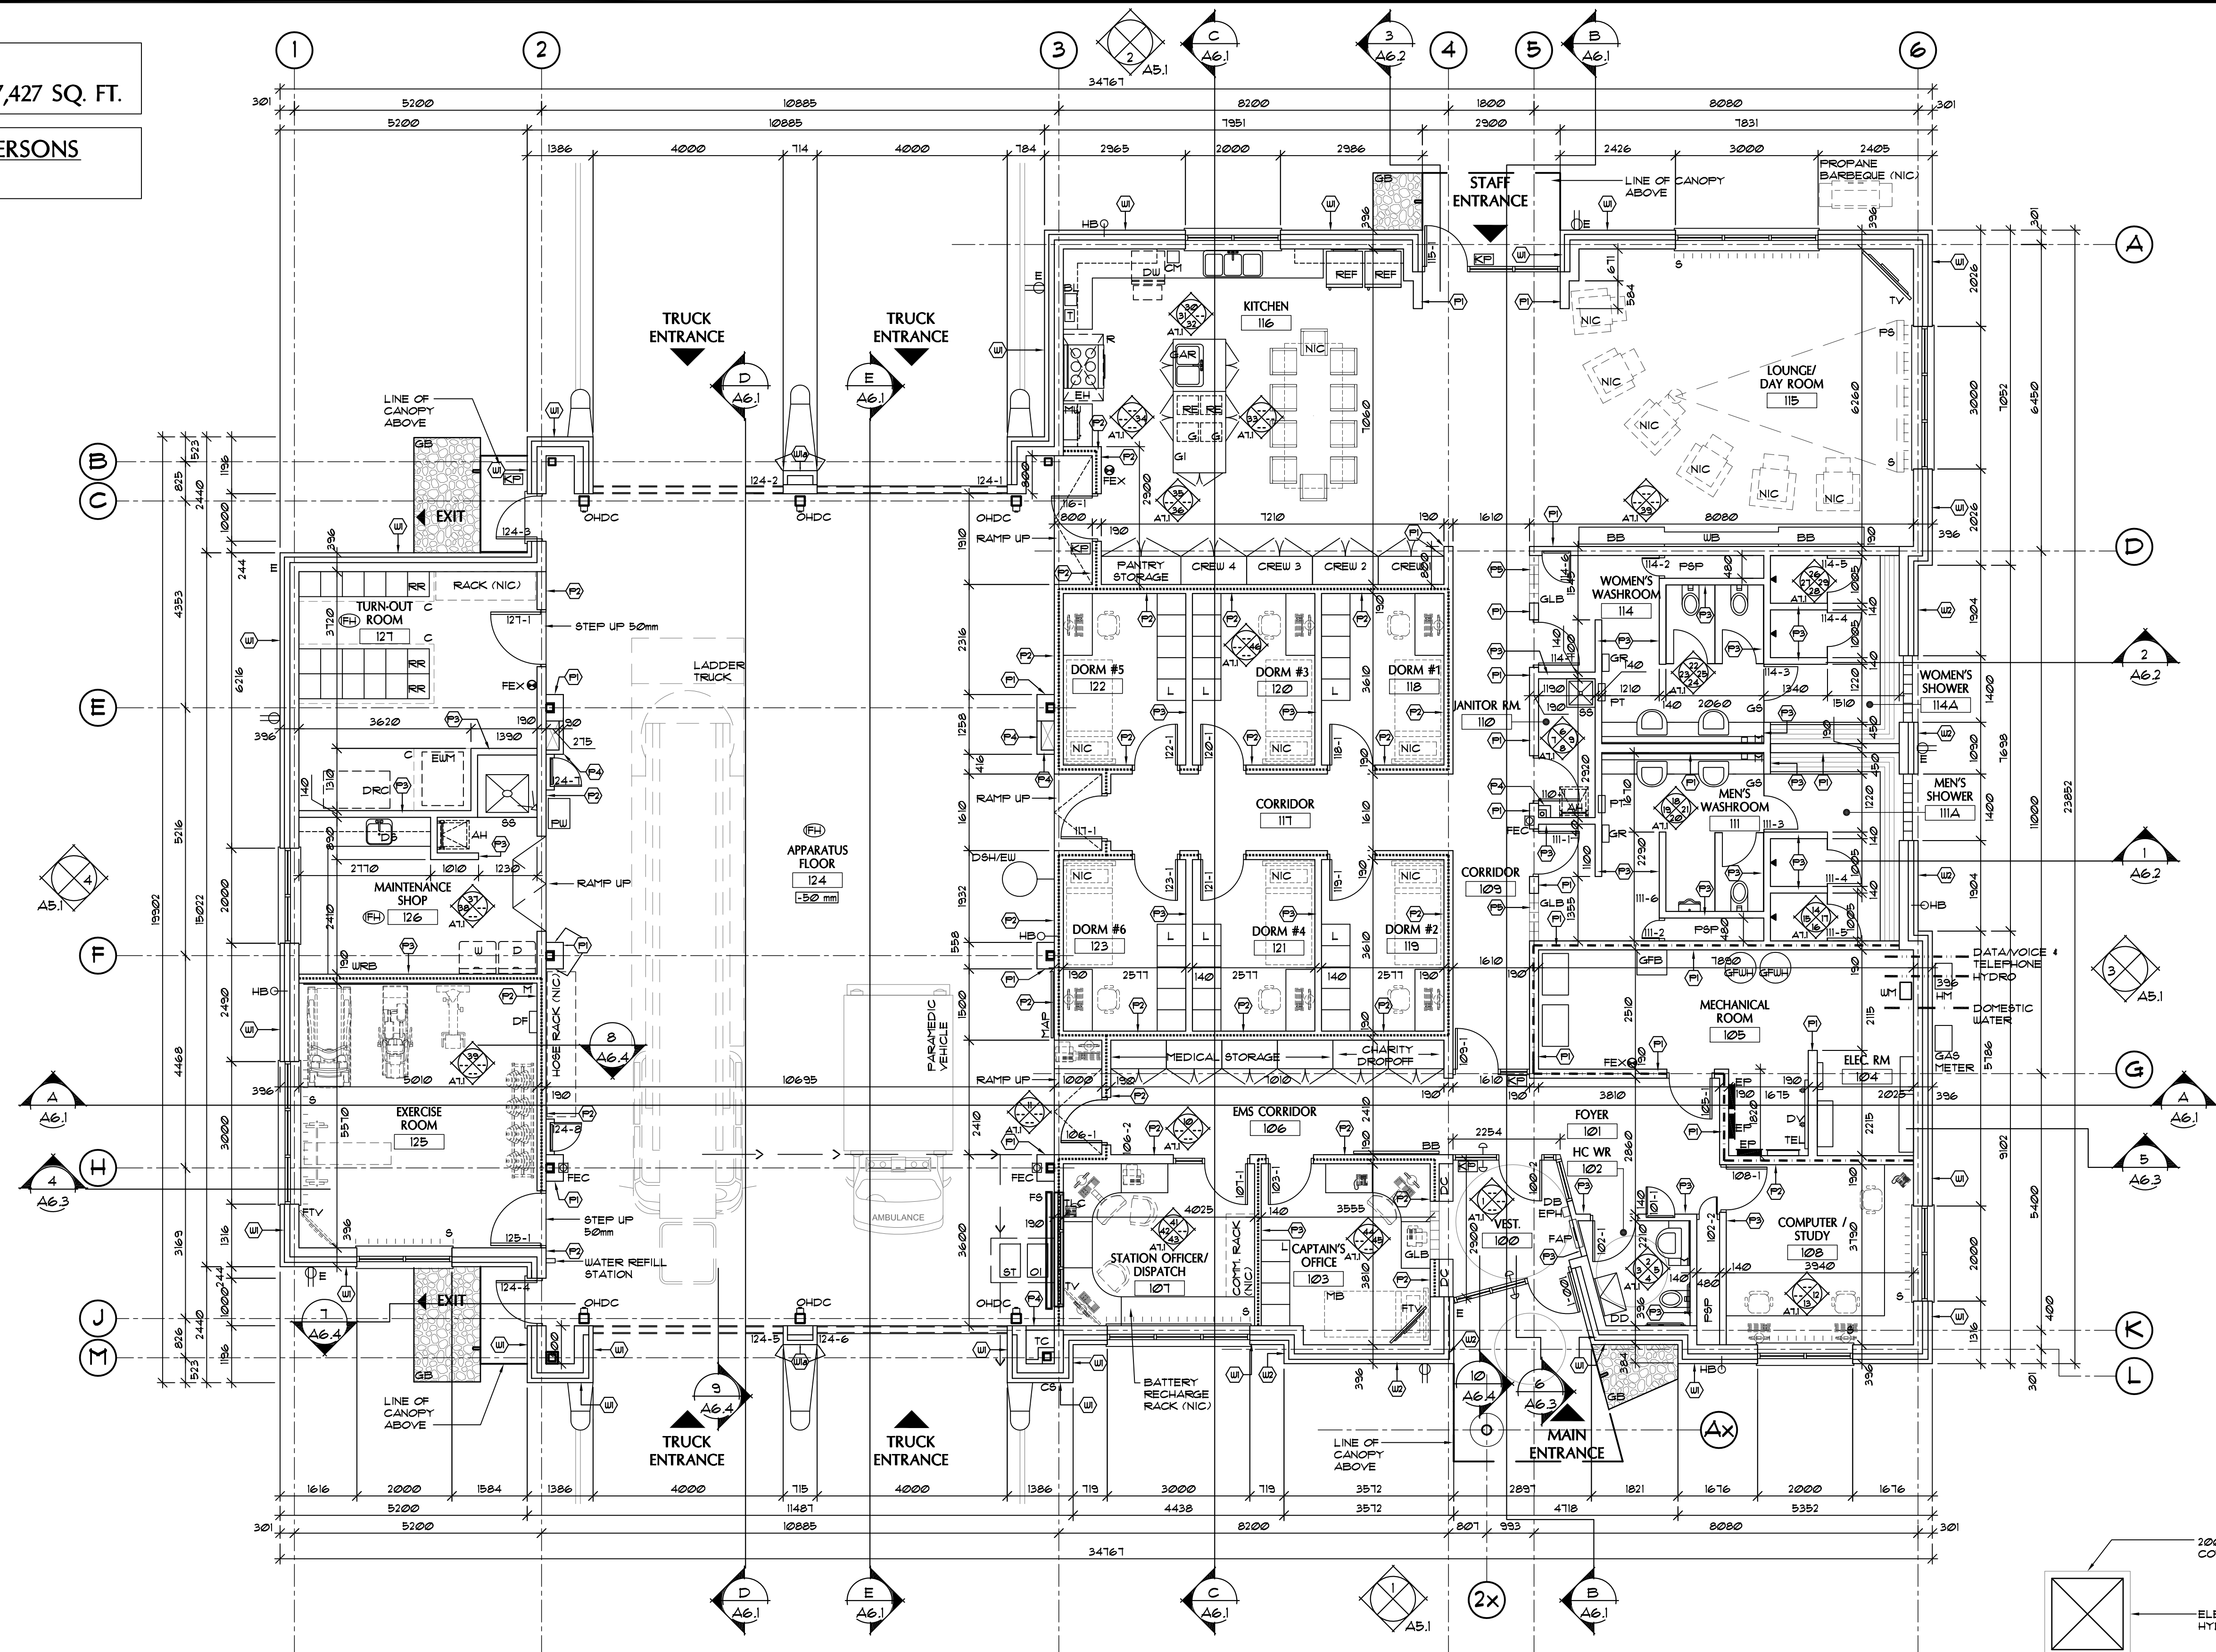

1 FLOOR PLAN  
SCALE 1: 1/8

ISSUES:

1	APRIL 2010	PHASE 1 - 10% COMPLETION
2	MAY 14, 2010	PHASE 2 - 80% COMPLETION
3	SEPT 15, 2010	PHASE 3 - BUILDING PERMIT PRELIMINARY REVIEW
4	SEPT 29, 2010	ISSUED FOR BUILDING PERMIT / TENDER

AREA SCHEDULE

	AREA m <sup>2</sup>	AREA Sq. Ft.
ADMINISTRATION AREA	279	3012
APPARATUS FLOOR	263	2830
SERVICE AREA	141	1585
TOTAL AREA	683	7421

- GENERAL NOTES
- ALL DOORS ARE TO BE INSTALLED TO SUIT A 1920MM BLOCK MODULE
  - ALL EXTERNAL WINDOWS ARE TO BE CENTERED WITHIN ROOM TO THE NEAREST 1920MM BLOCK MODULE
  - ALL FURNISHINGS SHOWN ON DRAWINGS WITH "NIC" DESIGNATION ARE NOT IN CONTRACT
  - REFER TO WASHROOM ELEVATIONS FOR WASHROOM ACCESSORIES AND LOCATIONS
  - REFER TO DETAILS 1 & 5 ON A6.5 FOR TERMINATION OF CONC. BLOCK AT CORESLAB ROOF STRUCTURE.
  - REFER TO MECHANICAL PLUMBING DRAWINGS FOR ALL FLOOR DRAIN LOCATIONS.
  - REFER TO ELECTRICAL DRAWINGS FOR ALL EXTERIOR BUILDING LIGHTING LOCATIONS.

© COPYRIGHT MURPHY & MURPHY ARCHITECT 2010  
NOT TO BE REPRODUCED WITHOUT CONSENT OF ARCHITECT.

CORPORATE STAMP: ARCHITECT'S STAMP:

**MURPHY & MURPHY**  
ARCHITECT INC.

775 WATERLOO STREET, LONDON, ONTARIO N6A 3W5  
PH: (519) 433-5161 FAX: (519) 433-5163

A. Detail Number  
B. Drawing Number - Where Detail Found

CONTRACTOR SHALL CHECK ALL DIMENSIONS ON THE DRAWINGS AND REPORT ANY DISCREPANCIES TO THE ARCHITECT BEFORE PROCEEDING. ALL DRAWINGS AND SPECIFICATIONS ARE PROPERTY OF THE ARCHITECT AND MUST BE RETURNED AT THE COMPLETION OF THE WORK. DRAWINGS ARE NOT TO BE SCALED. USE ONLY THE LATEST REVISED DRAWINGS OR THOSE THAT ARE MARKED "ISSUED FOR CONSTRUCTION". ANY UNAUTHORIZED USE IS PROHIBITED. AREA CALCULATIONS ARE APPROXIMATE.

PROJECT NAME:  
**NEW WINNIPEG STATION No. 27 PROJECT**

SAGE CREEK, WINNIPEG, MANITOBA

DRAWING TITLE:  
**FLOOR PLAN / WALL TYPES / ROOF TYPES / LEGEND**

PROJECT NORTH:

STAMP:

SCALE: 1: 1/8	PROJECT NO: 2261
DATE: MARCH 2010	FILE NAME:
ISSUED: SEPTEMBER 29, 2010	DRAWING NO: A2.1
DRAWN BY: MTR	
CHECKED BY: DRM	

**WALL TYPES**

W1	190 CONCRETE BLOCK AIR/VAPOUR BARRIER MEMBRANE 91 RIGID INSULATION (R20 MIN) 25 AIR SPACE 90 ROCK FACED STONE FROM TOP OF FOUNDATION WALL - 3 COURSES 90 JUMBO BRICK (RED)
W1a	190 CONCRETE BLOCK AIR/VAPOUR BARRIER MEMBRANE 91 RIGID INSULATION (R20 MIN) 25 AIR SPACE 90 FLAT FACED STONE / ROUGH FACE STONE (REFER TO WALL SECTION FOR PATTERN SEQUENCE)
W2	190 CONCRETE BLOCK AIR/VAPOUR BARRIER MEMBRANE 91 RIGID INSULATION (R20 MIN) 25 AIR SPACE 90 FLAT FACED STONE / ROUGH FACE STONE (REFER TO WALL SECTION FOR PATTERN SEQUENCE)

**ROOF TYPES**

R1	GRAVEL BALLAST (AS SPECIFIED) ROOF MEMBRANE (AS SPECIFIED) 102 RIGID INSULATION (R15 MIN) SLOPED CONCRETE CORESLAB ROOF STRUCTURE (REFER TO STRUCTURAL)
R2	"VICQUEST" STANDING BEAM TRADITIONAL PROFILE FIRE FINISHED SLOPED STEEL ROOF (AS SPECIFIED) CONTINUOUS VAPOUR BARRIER (AS SPECIFIED) 127mm RIGID INSULATION @ 1" GIRTS @ 1200mm O.C. MIN 13mm DENSDECK SHEATHING 38mm GALVANIZED METAL DECK STEEL STRUCTURE (REFER TO STRUCTURAL)
R3	ROOF MEMBRANE (AS SPECIFIED) 50mm SLOPED RIGID INSULATION 6mm PROTECTION BOARD STEEL DECK AS SPECIFIED 41 METAL STUDS @ 900 O.C. 22 METAL FURRING CHANNELS @ 400 O.C. 13mm CEMENT BOARD DUREX COATING AS SPECIFIED

NOTE: ALL PARTITIONS TO UNDERSIDE OF CONC. CORESLAB OR STEEL DECK

**LEGEND**

AH	ROOF ACCESS HATCH	FAP	FIRE ALARM PANEL	OHDC	OVERHEAD DOOR CONTROL PANEL
BB	BULLETIN BOARD	FEC	SEMI-RECESSED FIRE EXTINGUISHER CABINET	OI	OIL INTERCEPTOR
BL	BLENDER (NIC)	FEX	SURFACE MOUNTED FIRE EXTINGUISHER	PS	PROJECTION SCREEN
C	90 mm HIGH CONCRETE PAD	FTV	FUTURE TV LOCATION - (PROVIDE CABLE (AND OUTLETS FOR FUTURE HOOK UP))	PT	PAPER TOWEL DISPENSER - NIC
CM	COFFEE MAKER	G	GARBAGE DROP-IN	PSP	PIPE SERVICE SPACE
COMP.	COMPRESSOR - NIC	GB	GARBORATOR	FU	FOUNDER WASH - NIC
CS	CORNERSTONE	GB	GRAVEL BED	R	RANGE
DB	DECONTAMINATION SINK	GB	GREASE INTERCEPTOR	RE	RECYCLING DROP-IN
D	FRONT LOAD DRYER	GB	GAS FIRED BOILER	REF	REFRIGERATOR
DB	DOOR BELL	GLB	GAS FIRED WATER HEATER	RR	READY RACK
DC	DISPLAY CASE	GLB	GLASS BLOCK	S	FABRIC SHADE
DD	DIAPER DECK	GR	GARBAGE RECEPTACLE (RECESSED IN WALL)	SS	SLOP SINK
DF	DRINKING FOUNTAIN	GS	GLASS PRIVACY SCREEN	T	TOASTER
DRC	DRYING CABINET	HB	HOSE BIB (REFER TO MECHANICAL)	TEL	TELEPHONE PANEL
DSH	DRENCH SHOWER	HC	BARRIER FREE PUSH BUTTON	TLC	TRAFFIC LIGHT CONTROL BUTTON
DV	DATA / VOICE PANEL	IFH	IN FLOOR HEATING	TV	FLAT SCREEN TELEVISION
DW	DISH WASHER	KP	KEY PAD / SECURITY PAD	W	WASHING MACHINE
E	EXTERIOR WATERPROOF GROUND FAULT DUPLEX RECEPTACLE	L	LOCKER	WB	WHITE BOARD
EH	EXHAUST HOOD	LB	LANDSCAPE BED	WM	WATER METER
EP	ELECTRICAL PANEL	M	MIRROR		
EPH	EMERGENCY 911 TELEPHONE	MB	MURPHY BED		
EW	EYE WASH STATION	MU	MICROWAVE		
EUM	WASHER - EXTRACTOR	NIC	NOT IN CONTRACT		