

REFLECTED CEILING PLAN LEGEND

- 610 x 1220 RECESSED FLUORESCENT LIGHT FIXTURE - FLAT LENS (REFER TO ELECTRICAL)
- 610 x 1220 RECESSED FLUORESCENT LIGHTING FIXTURE - PARABOLIC LENS (REFER TO ELECTRICAL)
- 305 x 1220 SUSPENDED FLUORESCENT LIGHTING FIXTURE (3005 x 2440 IN APPARATUS BAY) REFER TO ELECTRICAL
- SUSPENDED INCANDESCENT FIXTURE REFER TO ELECTRICAL
- POT LIGHT FIXTURE REFER TO ELECTRICAL
- WHITE HOLOPHANE LIGHT FIXTURE REFER TO ELECTRICAL
- RED / GREEN O/H DOOR SIGNAL LIGHT REFER TO ELECTRICAL
- WALL MOUNTED LIGHT FIXTURE REFER TO ELECTRICAL
- EXTERIOR LIGHT FIXTURE REFER TO ELECTRICAL
- AIR SUPPLY DIFFUSERS REFER TO MECHANICAL
- RETURN AIR DIFFUSERS REFER TO MECHANICAL
- EXHAUST DIFFUSER REFER TO MECHANICAL
- SCUPPER (DRAINED INTO GRAVEL BED - REFER TO ALL)
- CONCRETE BLOCK LINTEL - BOND BEAM (ALL OPENINGS IN CONCRETE BLOCK)
- POWER OPERATED PROJECTION SCREEN AS SPECIFIED
- CONTROL JOINT, AS SPECIFIED
- EXPOSED CEILING TO U/S OF STRUCTURE
- ACCESS HATCH (AS SPECIFIED)

CEILING FINISH / HEIGHT LEGEND

CEILING HEIGHT TO BE THE FOLLOWING UNLESS OTHERWISE NOTED:


- 610 x 1220 ACOUSTIC CEILING TILE AS SPECIFIED (MOISTURE RESISTANT ACOUSTIC TILE TO BE SUPPLIED IN ROOMS 102, 111, 114) (REGULAR ACOUSTIC CEILING TILE TO BE SUPPLIED IN ALL OTHER ROOMS INDICATED)
- GYPSUM BOARD BULKHEAD
- CEMENT BOARD CEILING (ALL CANOPIES AND SHOWER)
- GYPSUM BOARD CEILING
- MESH CEILING HEIGHT = 3200 mm (DUCTWORK PERMISSIBLE)
- FINISHED CHERRY (GOOD SIDE) 10mm EDGE BAND W/ 4mm V-GROOVE (BLACK)
- EXPOSED STRUCTURE CEILING
- INDICATES CEILING / BULKHEAD HEIGHT

ISSUES

1	APRIL 2010	PHASE 1 - 10% COMPLETION
2	MAY 14, 2010	PHASE 2 - 80% COMPLETION
3	SEPT 15, 2010	PHASE 3 - BUILDING PERMIT PRELIMINARY REVIEW
4	SEPT 29, 2010	ISSUED FOR BUILDING PERMIT / TENDER

NOTE: SUPPLY AND INSTALL 15x15x6 CONTINUOUS STEEL ANGLES FOR SUPPORT OF CEILING LIGHT FIXTURES, PLYMOVENT EXHAUST, RADIANT HEATING ETC. MECHANICALLY FASTENED TO UNDERSIDE OF STEEL TRUSSES. USE THREADED ROD TO SUPPORT VERTICALLY WHERE APPLICABLE.

© COPYRIGHT MURPHY & MURPHY ARCHITECT 2010
NOT TO BE REPRODUCED WITHOUT CONSENT OF ARCHITECT.

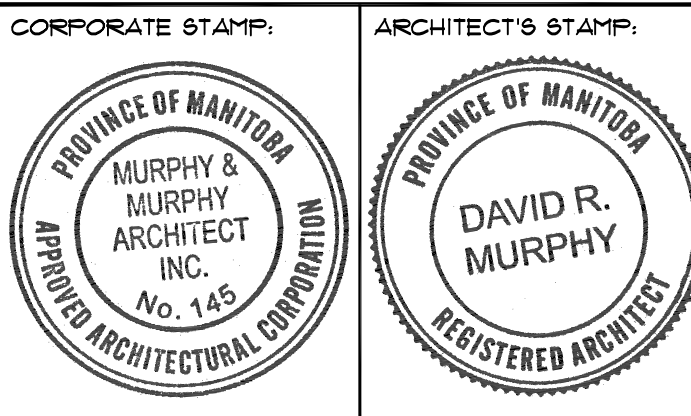

MURPHY & MURPHY ARCHITECT INC.
775 WATERLOO STREET, LONDON, ONTARIO N6A 3W5
PH: (519) 433-5161 FAX: (519) 433-5163

A A. Detail Number
B B. Drawing Number - Where Detail Found

CONTRACTOR SHALL CHECK ALL DIMENSIONS ON THE DRAWINGS AND REPORT ANY DISCREPANCIES TO THE ARCHITECT BEFORE PROCEEDING. ALL DRAWINGS AND SPECIFICATIONS ARE PROPERTY OF THE ARCHITECT AND MUST BE RETURNED AT THE COMPLETION OF THE WORK. DRAWINGS ARE NOT TO BE SCALED. USE ONLY THE LATEST REVISED DRAWINGS OR THOSE THAT ARE MARKED "ISSUED FOR CONSTRUCTION". ANY UNAUTHORIZED USE IS PROHIBITED. AREA CALCULATIONS ARE APPROXIMATE.

PROJECT NAME:
NEW WINNIPEG STATION No. 27 PROJECT
SAGE CREEK, WINNIPEG, MANITOBA

DRAWING TITLE:
REFLECTED CEILING PLAN / CEILING DETAILS

PROJECT NORTH: 	STAMP:
SCALE: AS NOTED	PROJECT NO: 2261
DATE: MARCH 2010	FILE NAME:
ISSUED: SEPTEMBER 29, 2010	DRAWING NO: A3.1
DRAWN BY: MTR	
CHECKED BY: DRM	

1 REFLECTED CEILING PLAN
SCALE 1: 15

2 RESERVED
SCALE 1: 15

