







- NOTES:**
- LIMIT SWITCH #1 OPENS WHEN DOOR REACHES CLOSED POSITION. WHEN DOOR RISES, SWITCH CLOSES WHICH TURNS RED LAMP ON.
 - LIMIT SWITCH #2 OPERATES AT FULLY OPEN EXTENT OF DOOR TRAVEL. THIS TURNS RED LAMP OFF AND GREEN LAMP ON.
 - LIMIT SWITCHES SUPPLIED BY DOOR SUPPLIER, WIRED BY DIVISION 16. RELAYS AND LIGHTS PROVIDED BY DIVISION 16.

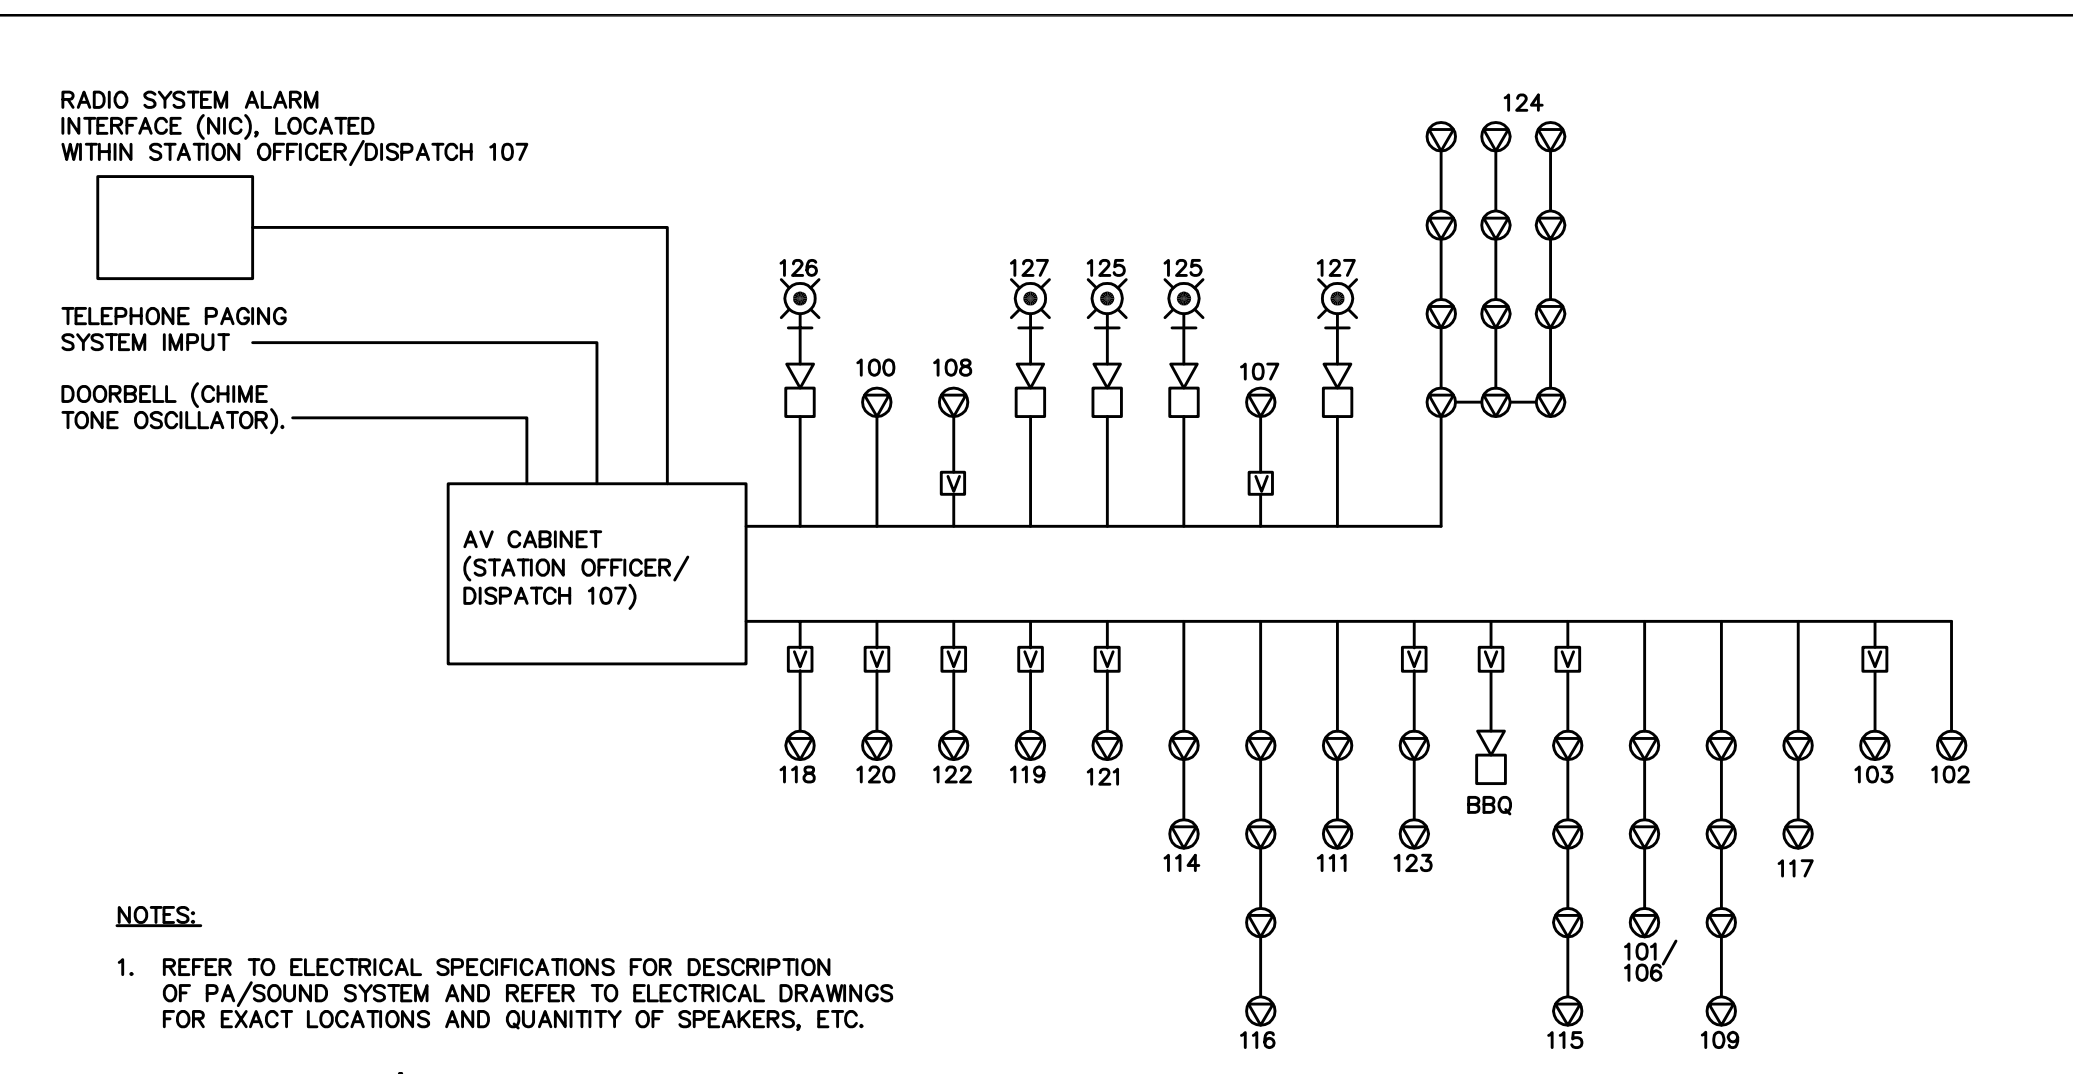



- NOTES:**
- REFER TO ELECTRICAL SPECIFICATIONS FOR DESCRIPTION OF PA/SOUND SYSTEM AND REFER TO ELECTRICAL DRAWINGS FOR EXACT LOCATIONS AND QUANTITY OF SPEAKERS, ETC.

FIRE ALARM SCHEDULE


IDENT. No.	DEVICE	ALARM	FUNCTION SUPERVISION	CONTROL	DESCRIPTION AND / OR ANNUNCIATOR LABEL
1.0	SA	X			EAST SIDE
2.0		X			APPARATUS FLOOR
3.0		X			WEST SIDE
4.0				X	HORN SIGNAL CIRCUITS
5.0	ST		X		EXERCISE ROOM
6.0	ST		X		MAINTENANCE SHOP
7.0	ST		X		TURN-OUT ROOM
8.0					TELEPHONE CONNECTION TO 24HR. MONITORING STATION
9.0					AUXILIARY CONTACTS FOR OWNER'S MONITORING SYSTEM
10.0				X	EXHAUST HOOD SHUT DOWN
11.0		X			EXHAUST HOOD IN KITCHEN

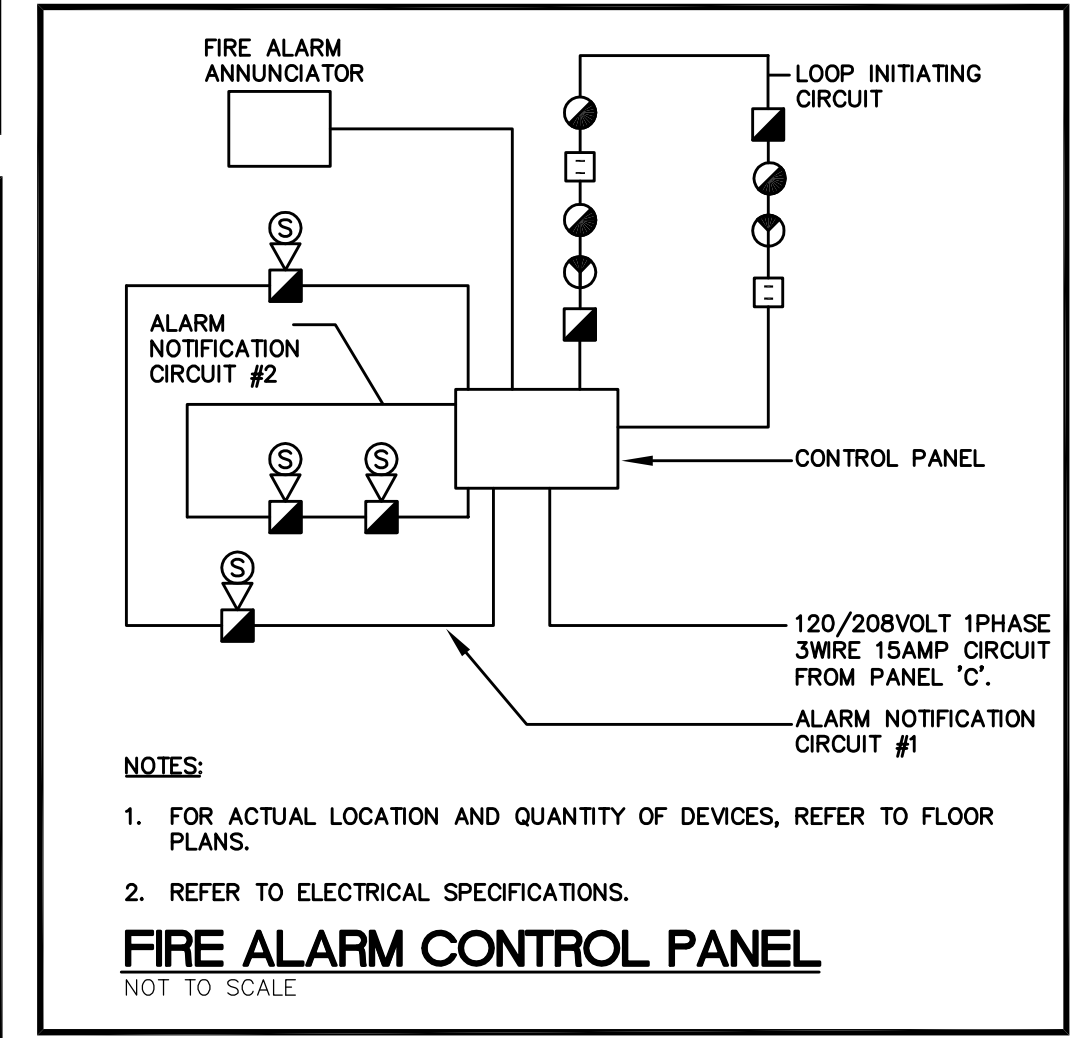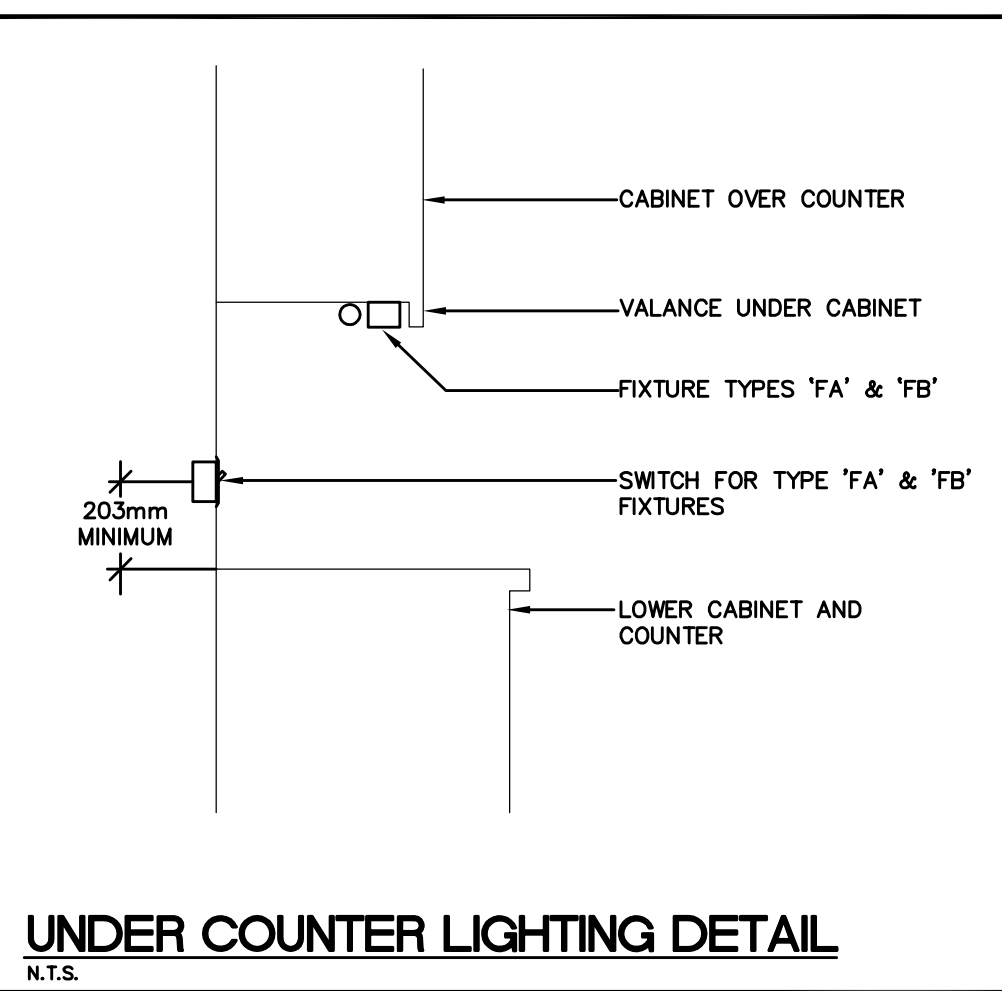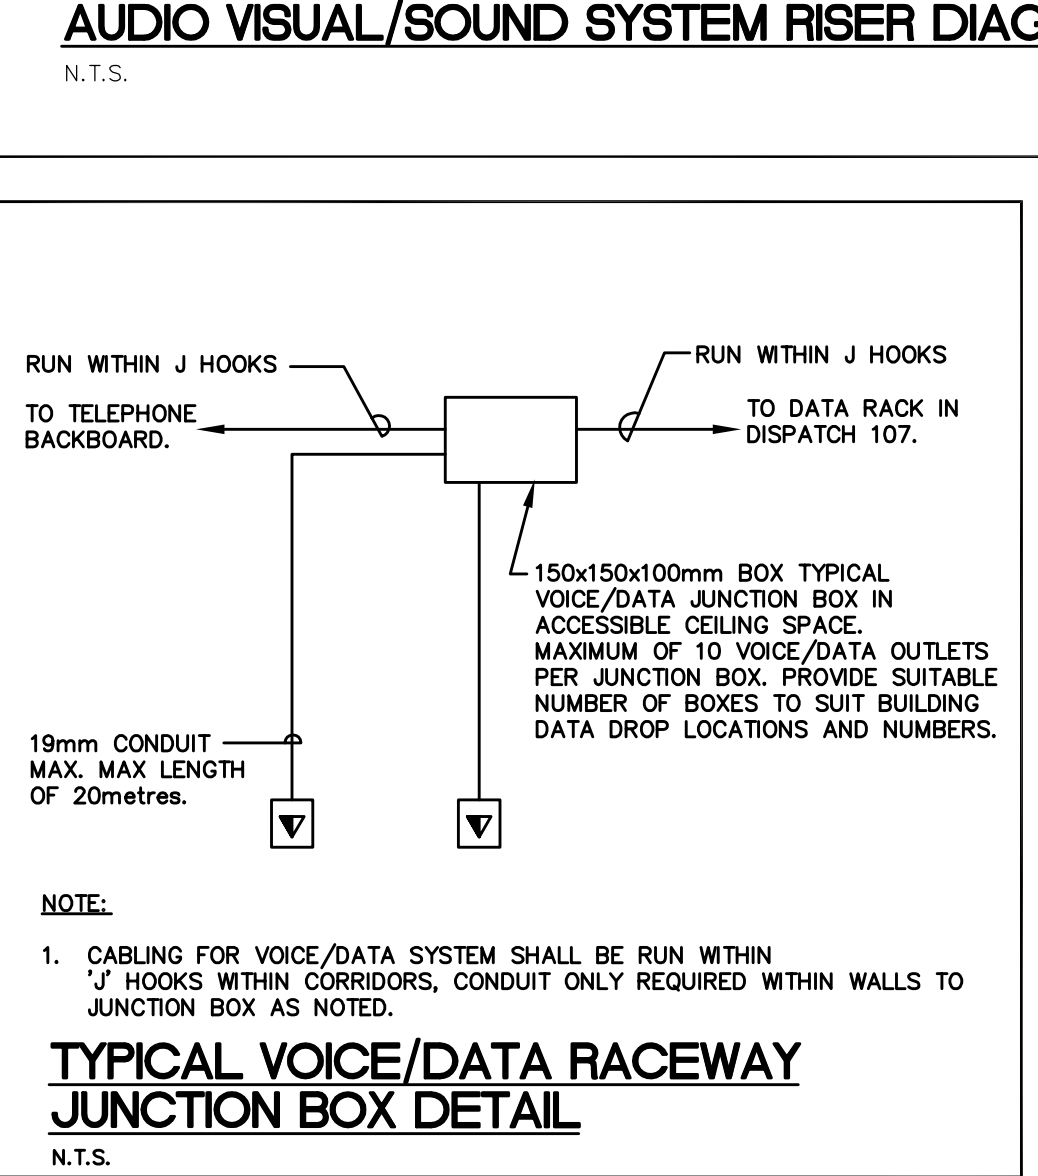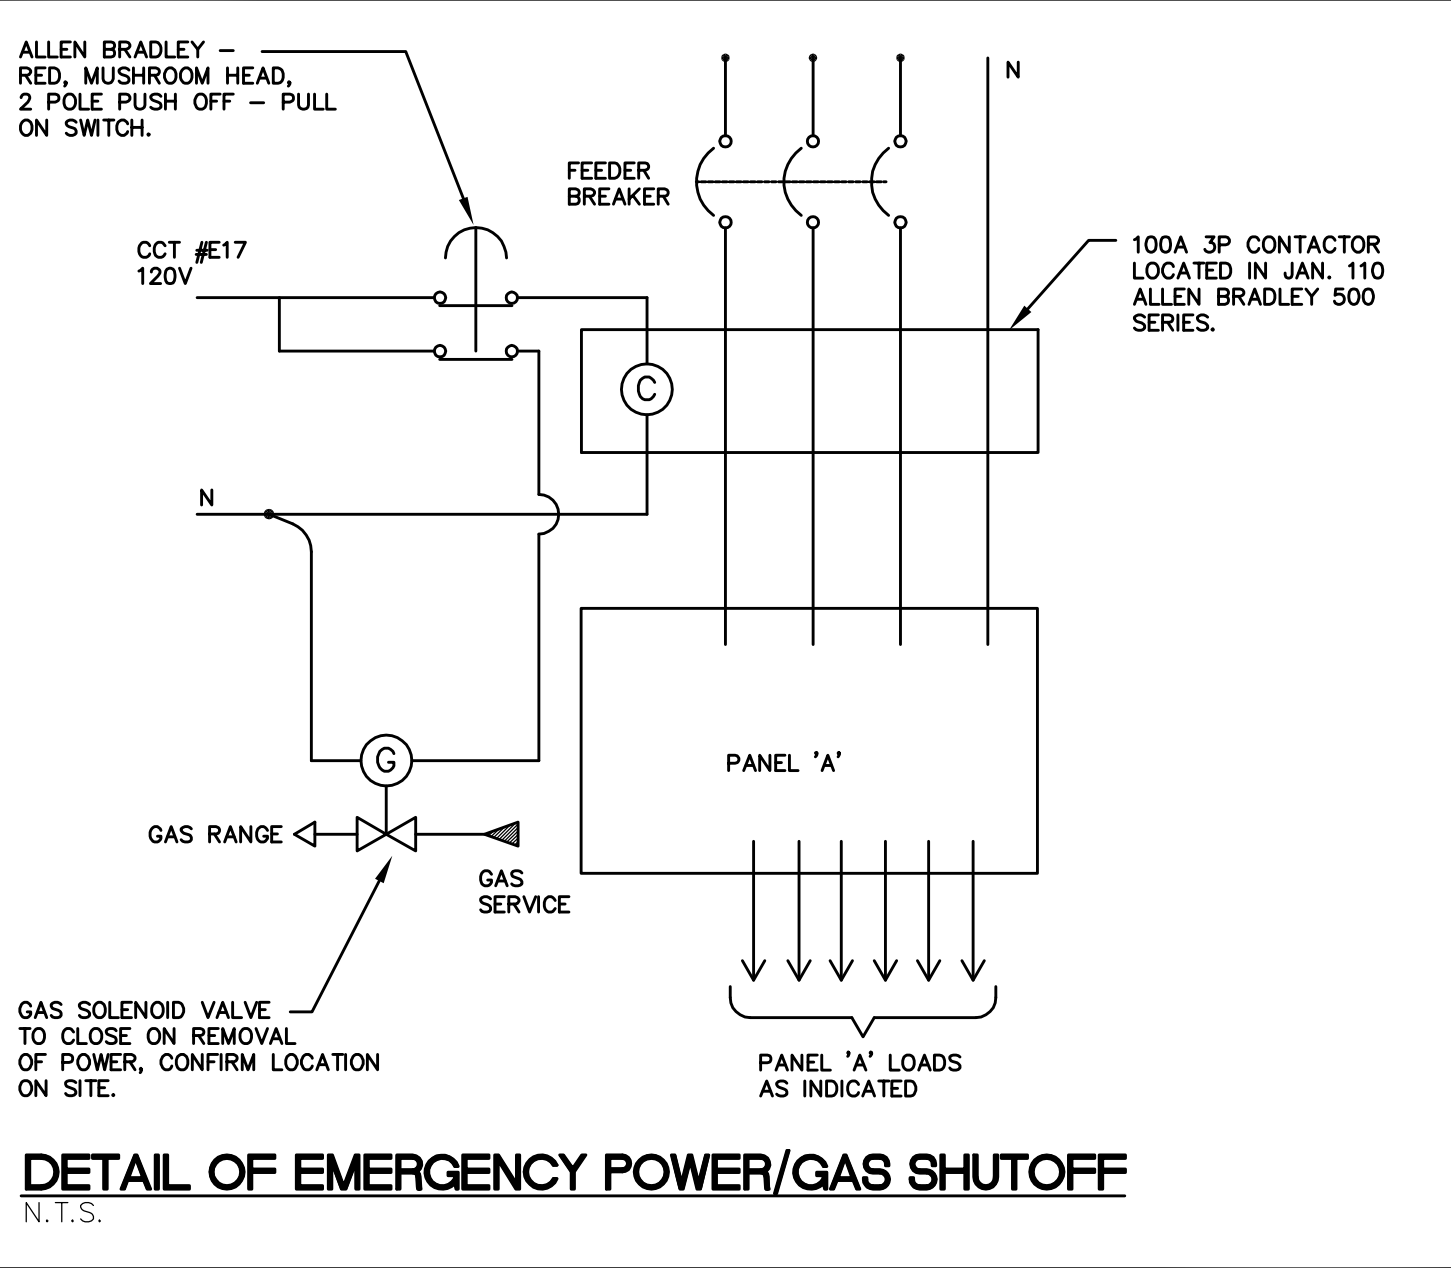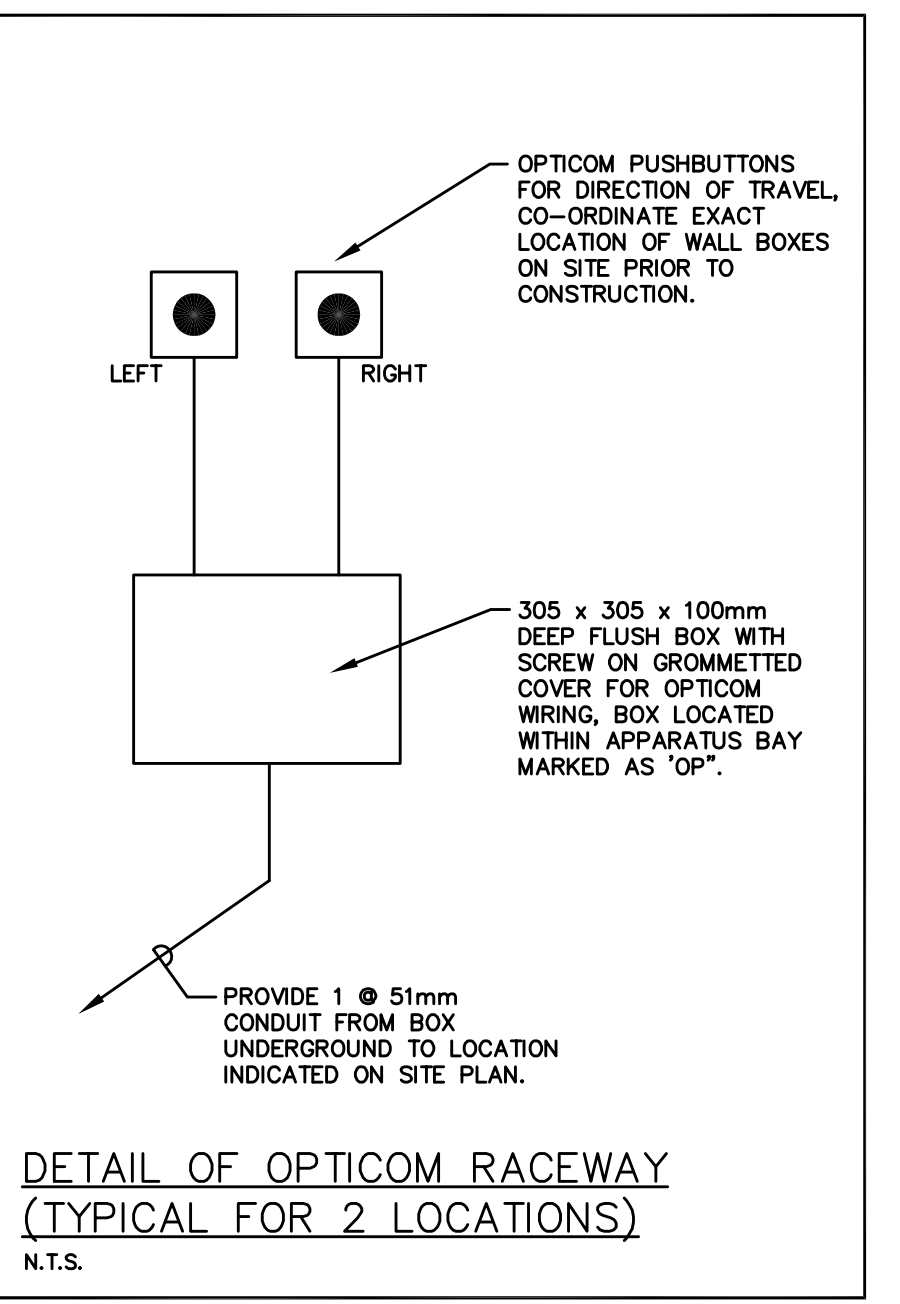


- NOTES:**
- FOR ACTUAL LOCATION AND QUANTITY OF DEVICES, REFER TO FLOOR PLANS.
 - REFER TO ELECTRICAL SPECIFICATIONS.

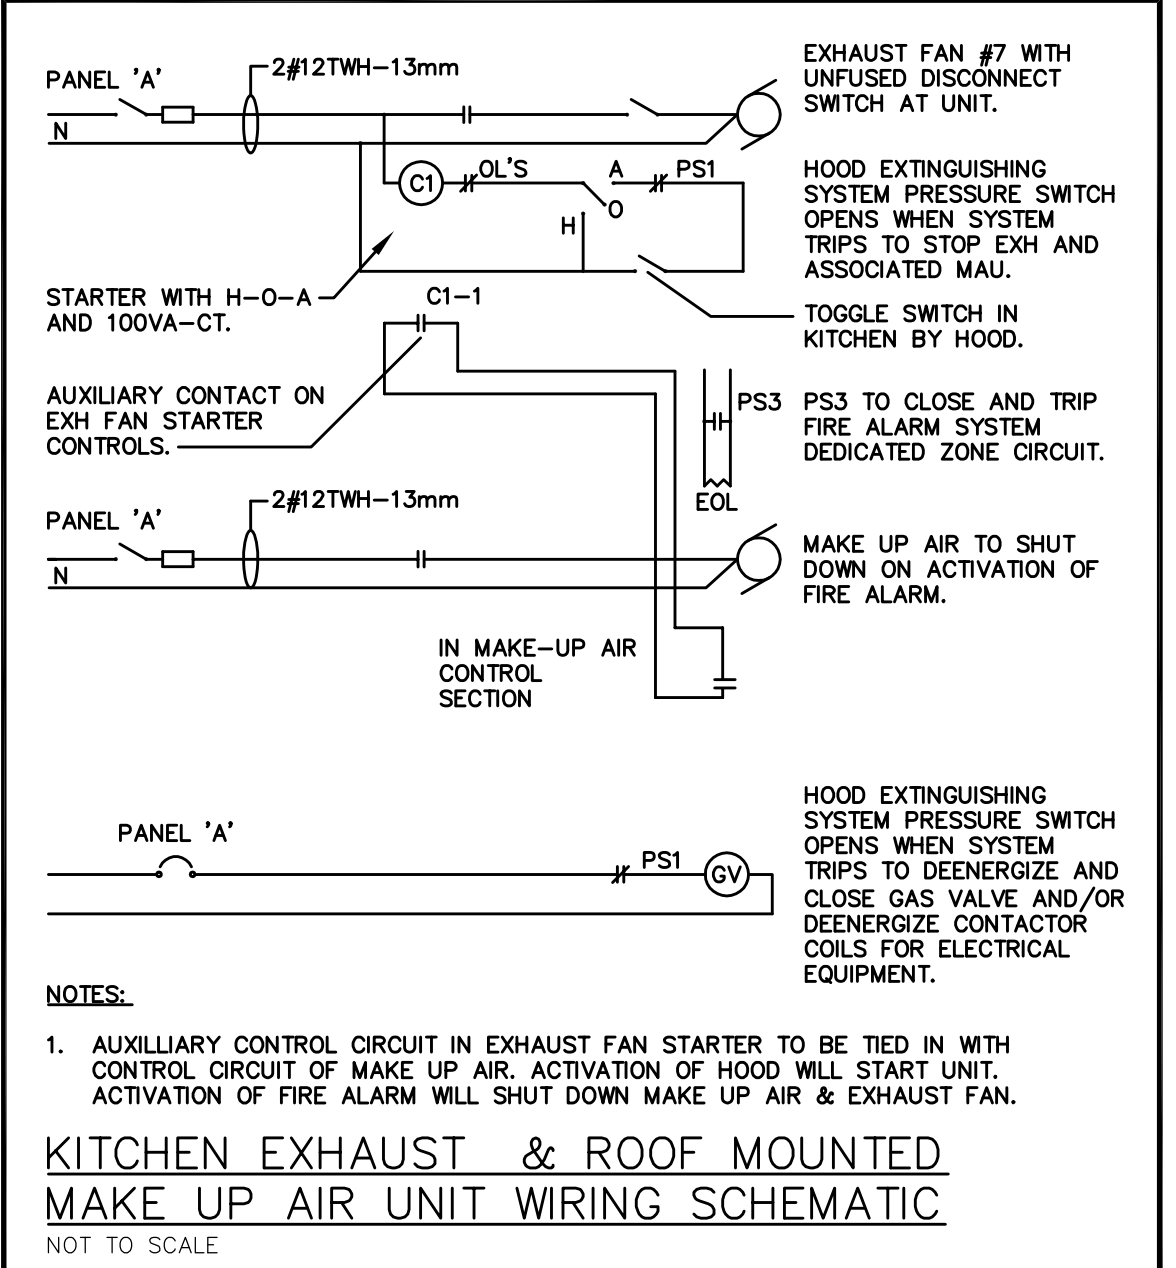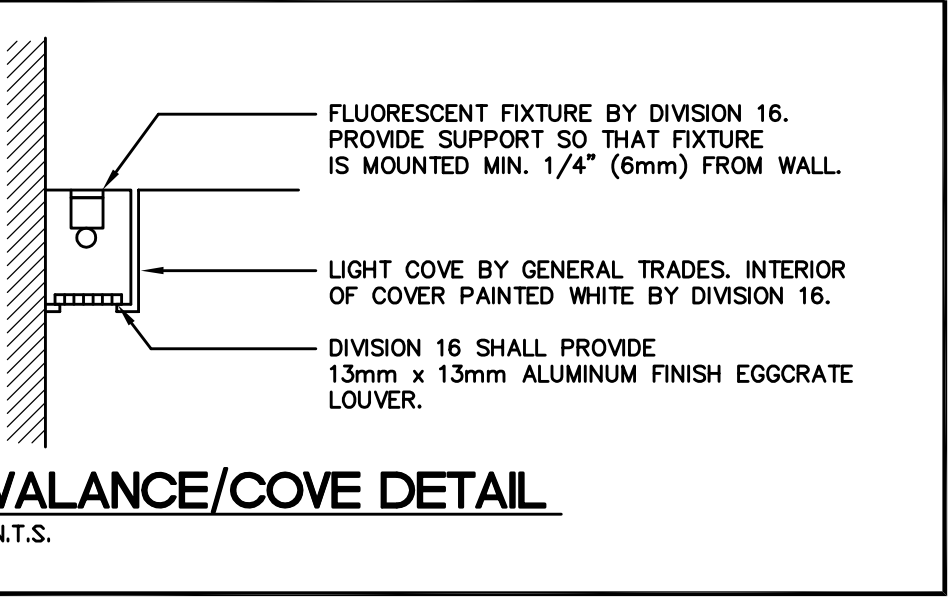

- NOTES:**
- AUXILIARY CONTROL CIRCUIT IN EXHAUST FAN STARTER TO BE TIED IN WITH CONTROL CIRCUIT OF MAKE UP AIR. ACTIVATION OF HOOD WILL START UNIT. ACTIVATION OF FIRE ALARM WILL SHUT DOWN MAKE UP AIR & EXHAUST FAN.

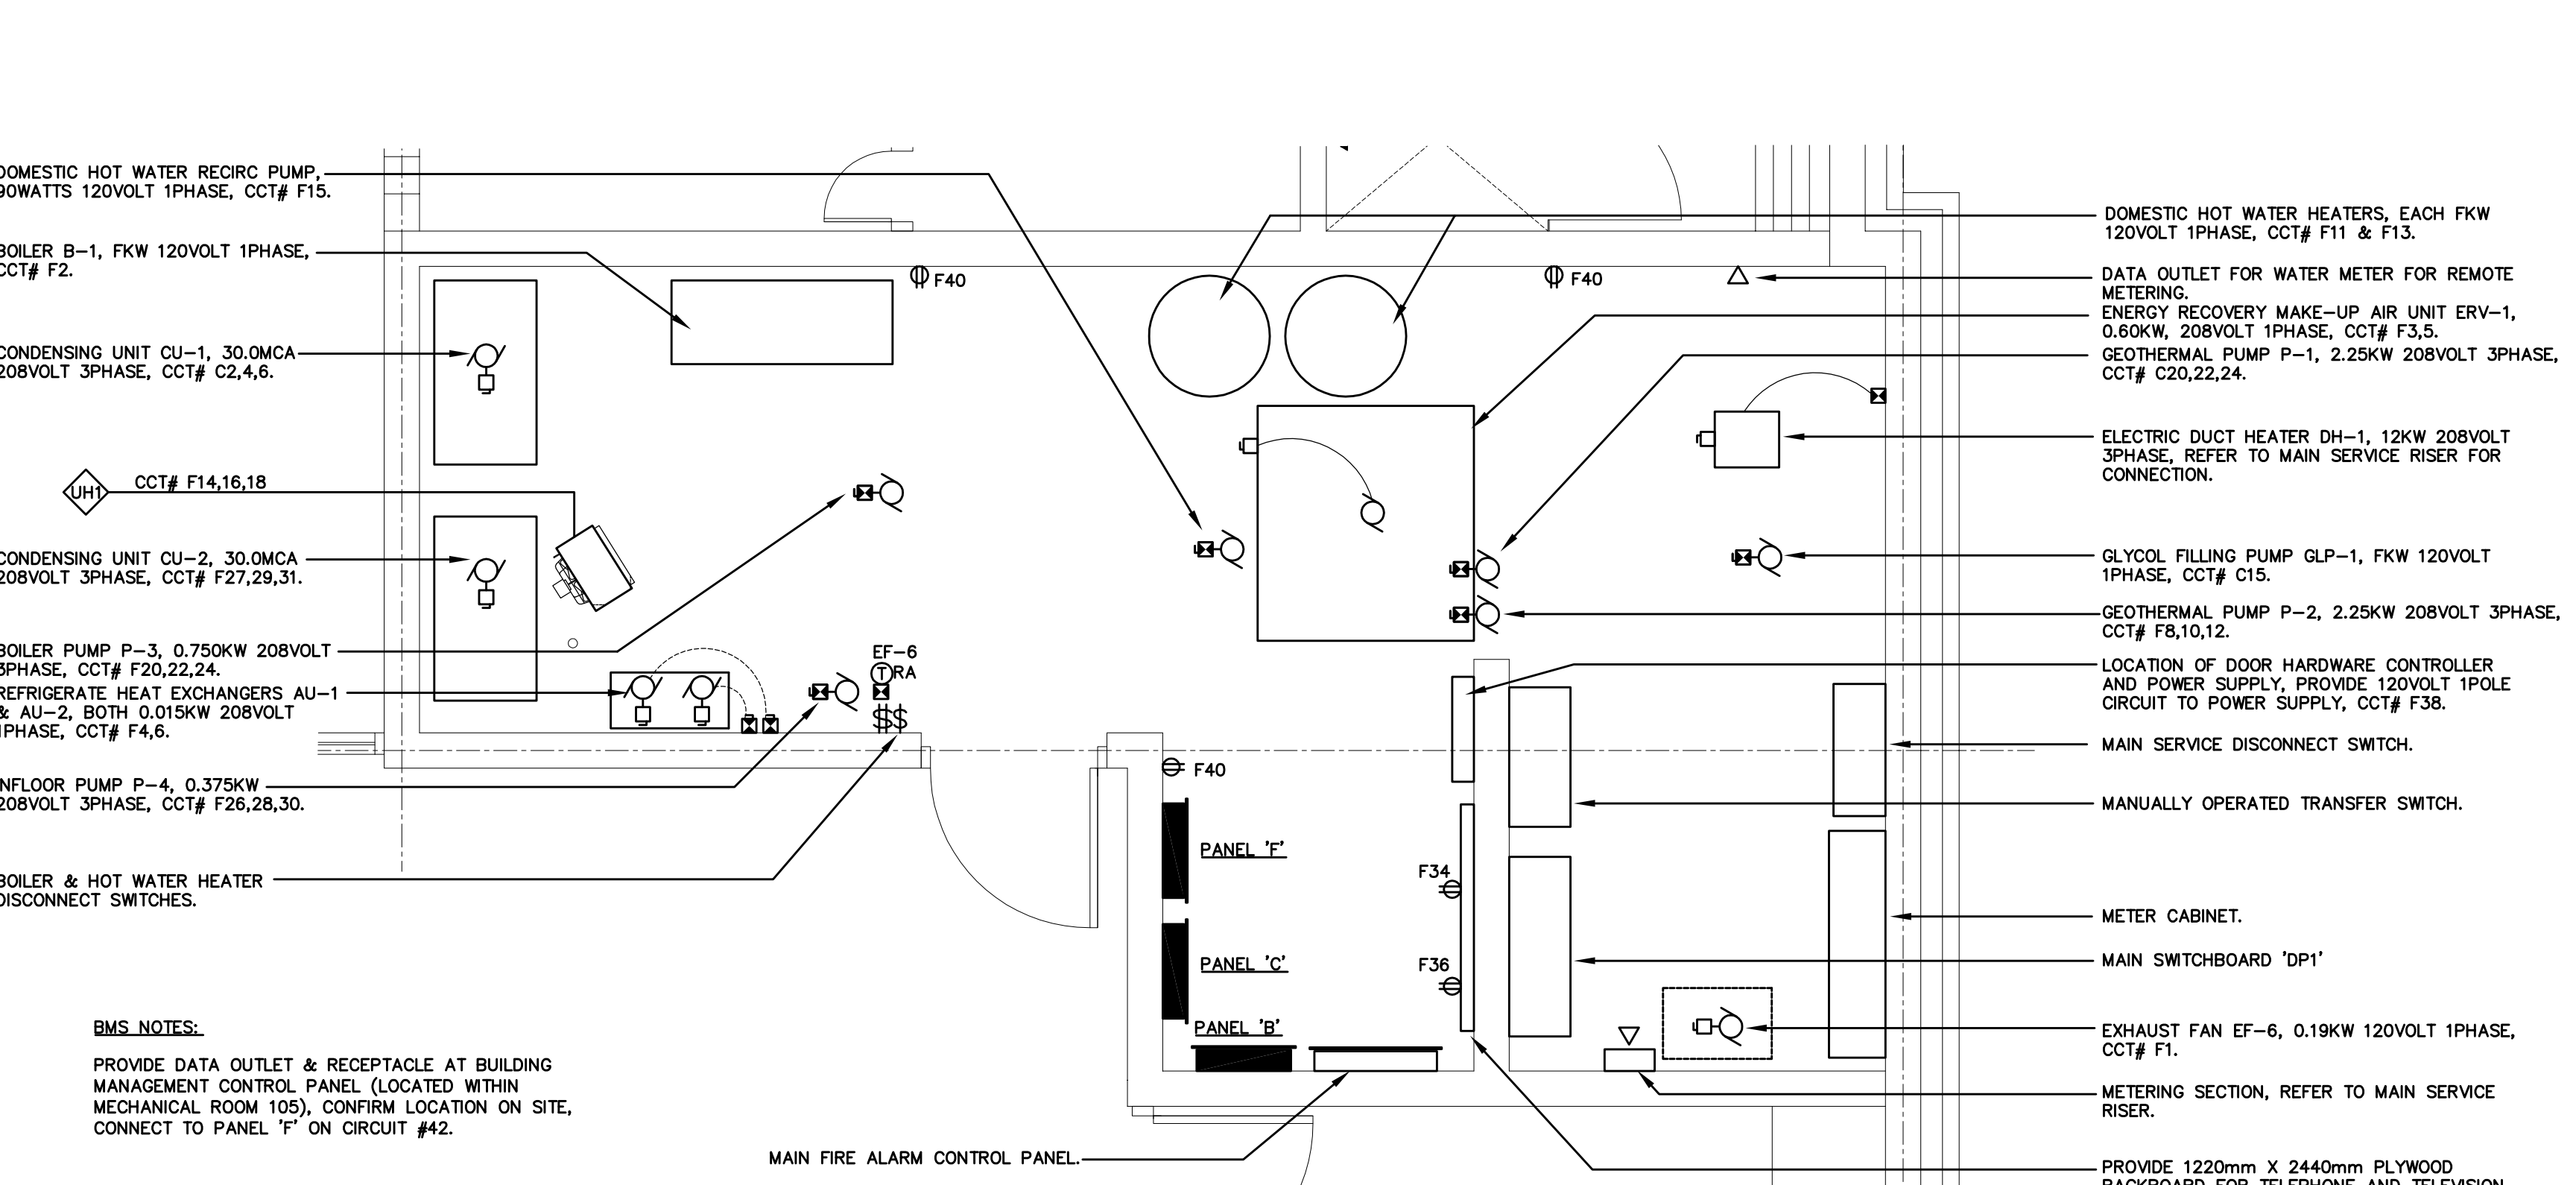

- BMS NOTES:**
- PROVIDE DATA OUTLET & RECEPTACLE AT BUILDING MANAGEMENT CONTROL PANEL (LOCATED WITHIN MECHANICAL ROOM 105), CONFIRM LOCATION ON SITE. CONNECT TO PANEL 'F' ON CIRCUIT #42.

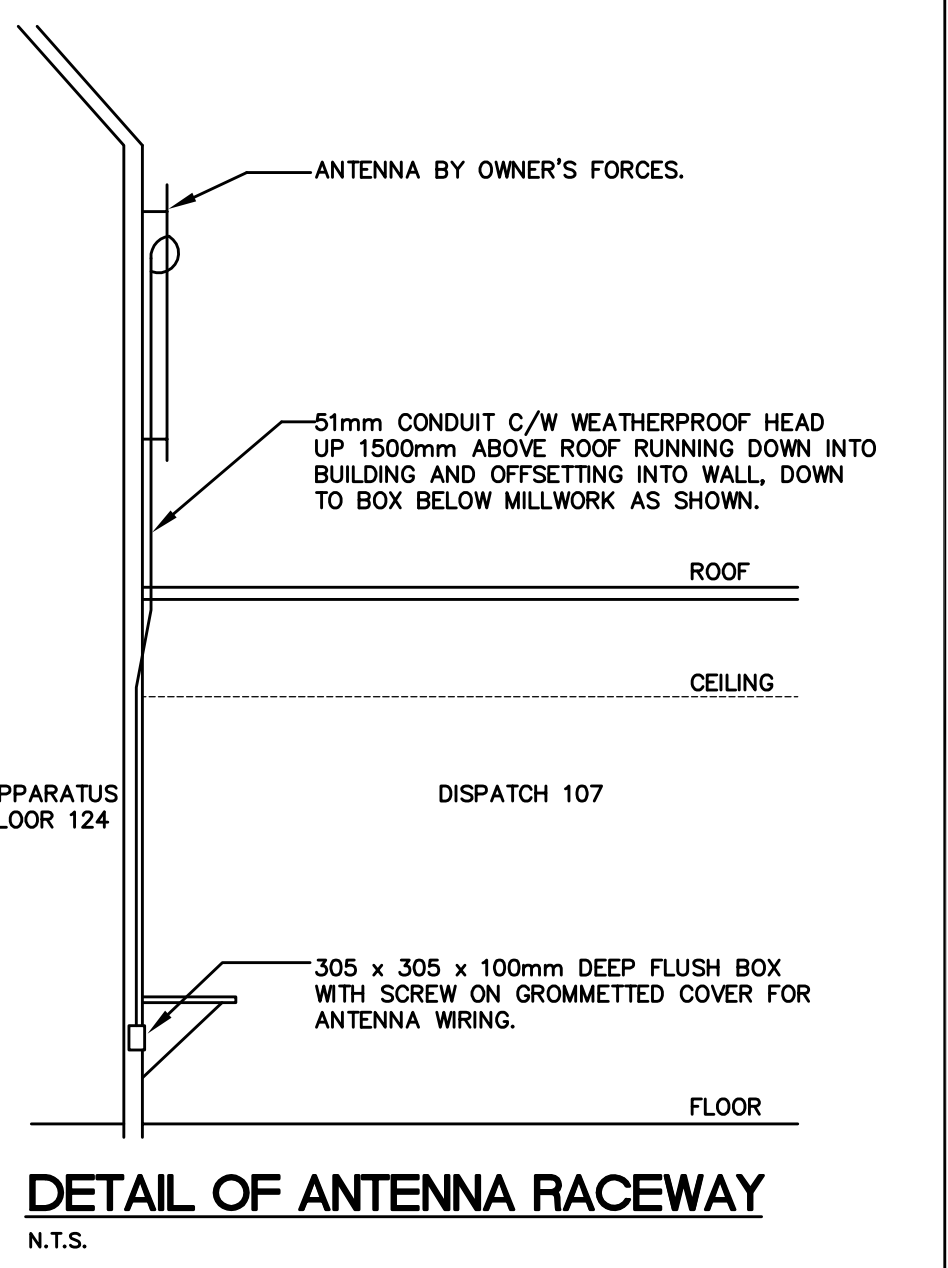

ISSUES:

NO	DATE	DESCRIPTION
1	MAY 14, 2010	ISSUED FOR CLIENT REVIEW
2	MAY 19, 2010	ISSUED FOR CLIENT REVIEW
3	SEPT. 24, 2010	ISSUED FOR BUILDING PERMIT
4	DEC. 10, 2010	ISSUED FOR TENDER

VRM
VANDERWESTEN RUTHERFORD MANTECON INC.
CONSULTING STRUCTURAL/MECHANICAL/ELECTRICAL ENGINEERS
LONDON • HAMMILTON • WINNIPEG • OTTAWA
7342 COLLEGE VALLEY ROAD, LONDON, ONTARIO, M6L 1H8
PHONE: (519) 662-5041 • FAX: (519) 662-9058 • www.vrm.com

REVIEW ALL DRAWINGS AND VERIFY ALL DIMENSIONS AT THE SITE. DO NOT SCALE THE DRAWINGS. REPORT ALL DISCREPANCIES TO THE ENGINEER BEFORE PROCEEDING WITH ANY CONSTRUCTION OR SHOP FABRICATION. ALL DRAWINGS, SPECIFICATIONS AND RELATED DOCUMENTS ARE THE COPYRIGHT PROPERTY OF VANDERWESTEN RUTHERFORD MANTECON AND MUST BE RETURNED UPON REQUEST. REPRODUCTION OF DRAWINGS, SPECIFICATIONS AND RELATED DOCUMENTS IN PART OR WHOLE IS FORBIDDEN WITHOUT THE CONSULTANT'S WRITTEN PERMISSION.

PROJECT NAME:
NEW WINNIPEG STATION No. 27 PROJECT
SAGE CREEK, WINNIPEG, MANITOBA

DRAWING TITLE:
ELECTRICAL DETAILS & ENLARGED ROOM LAYOUTS

PROJECT NORTH: [North Arrow]

PROJECT NO.: 2261
FILE NAME:
DRAWING NO.: E3.1

SCALE: AS NOTED
DATE: DECEMBER 10, 2010
ISSUED: DECEMBER 10, 2010
DRAWN BY: PDL
CHECKED BY: ELC

NOT VALID FOR CONSTRUCTION UNLESS SIGNED