

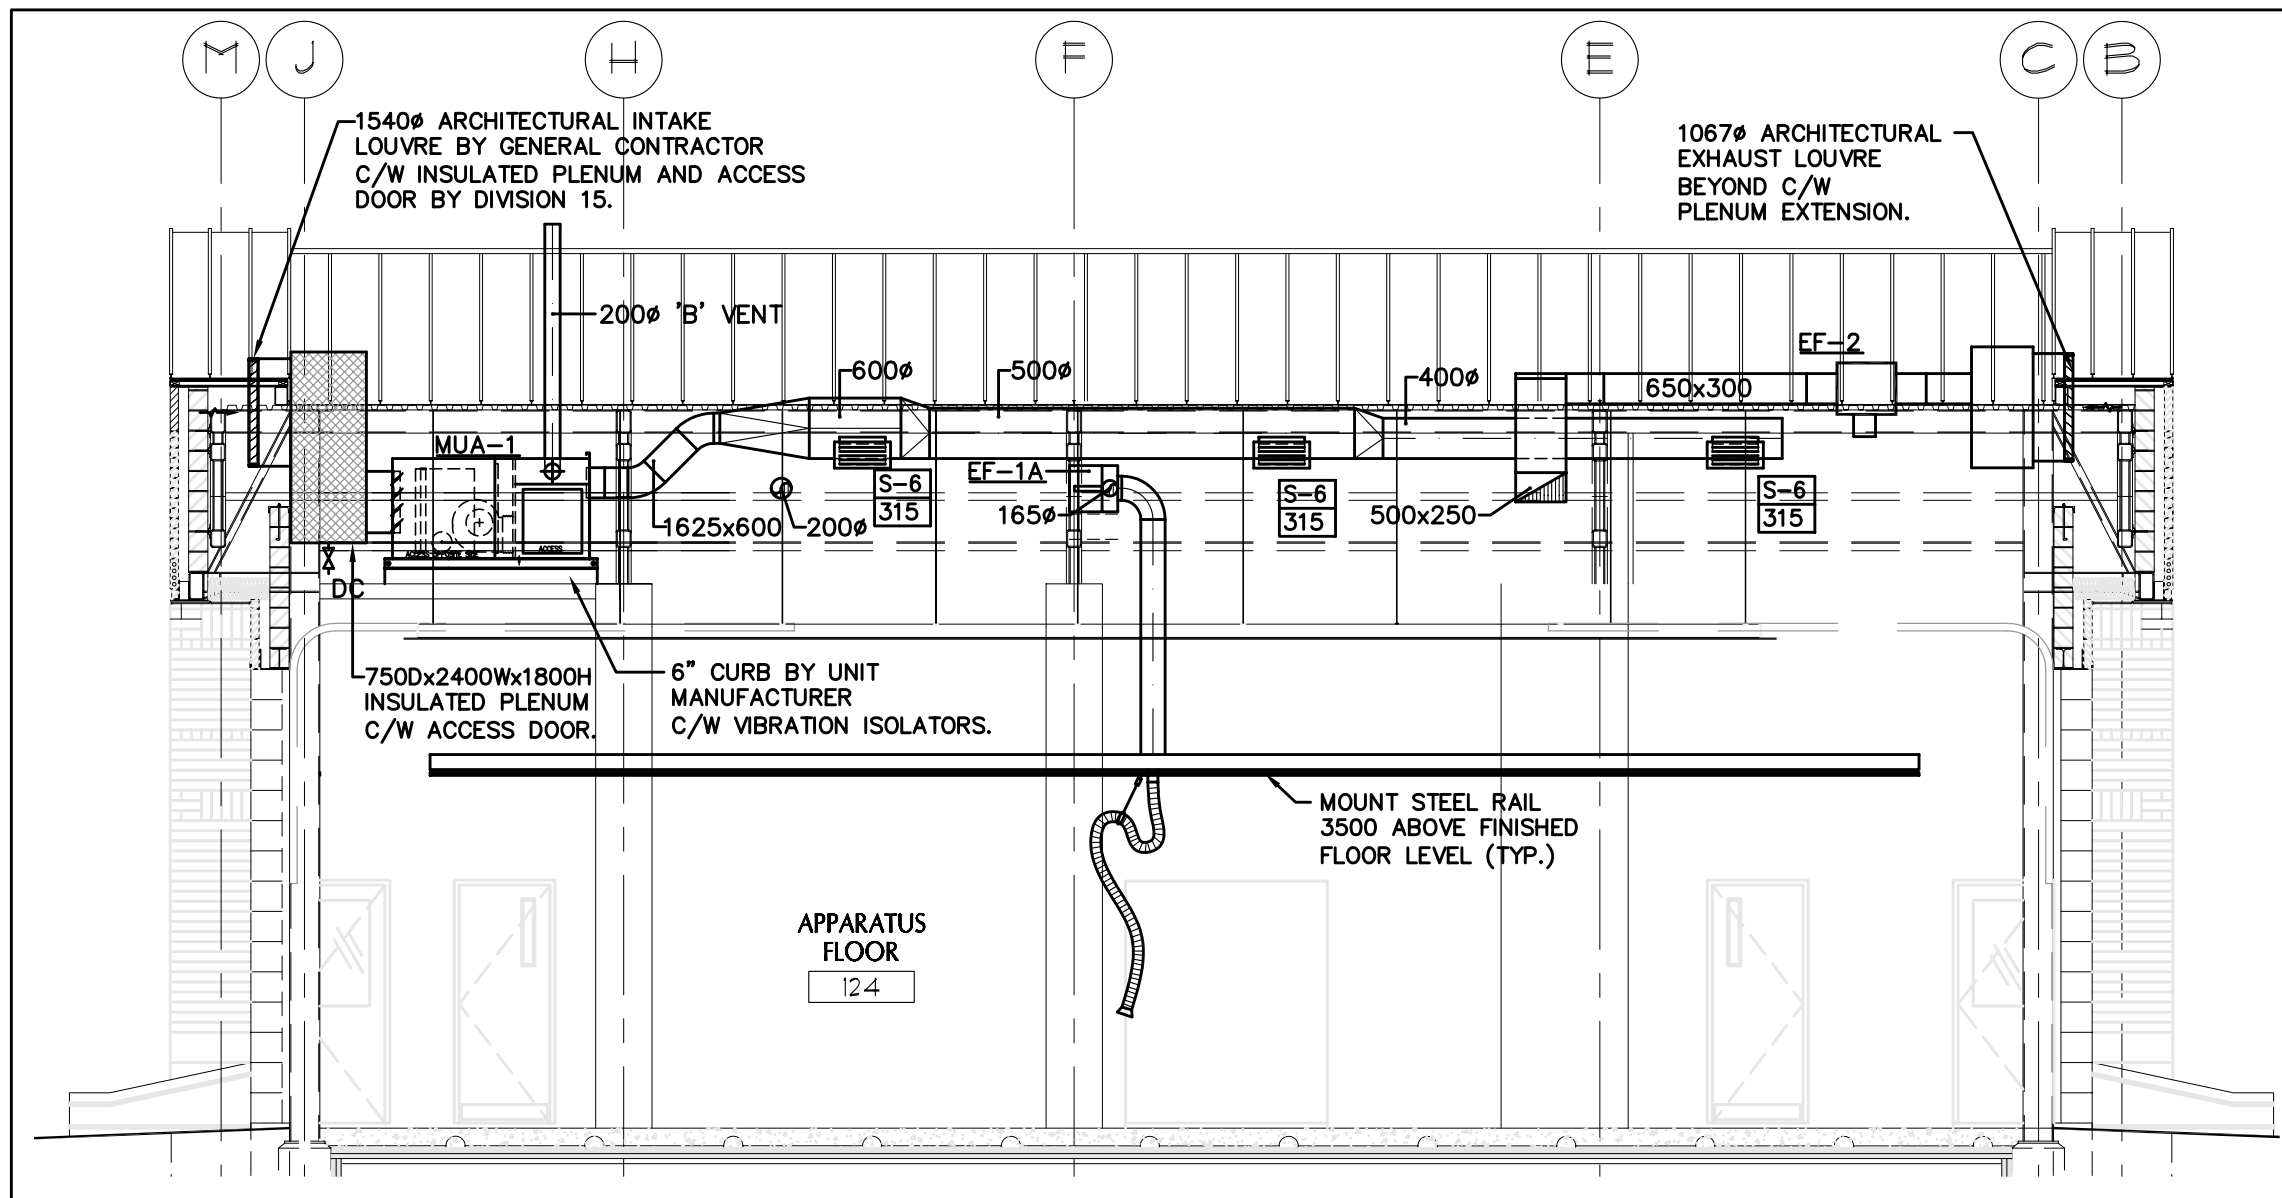



ISSUES:		
NO.	DATE	DESCRIPTION
1	MAY 14, 2010	ISSUED FOR CLIENT REVIEW
2	MAY 19, 2010	ISSUED FOR CLIENT REVIEW
3	SEPT. 24, 2010	ISSUED FOR BUILDING PERMIT
4	DEC. 10, 2010	ISSUED FOR TENDER

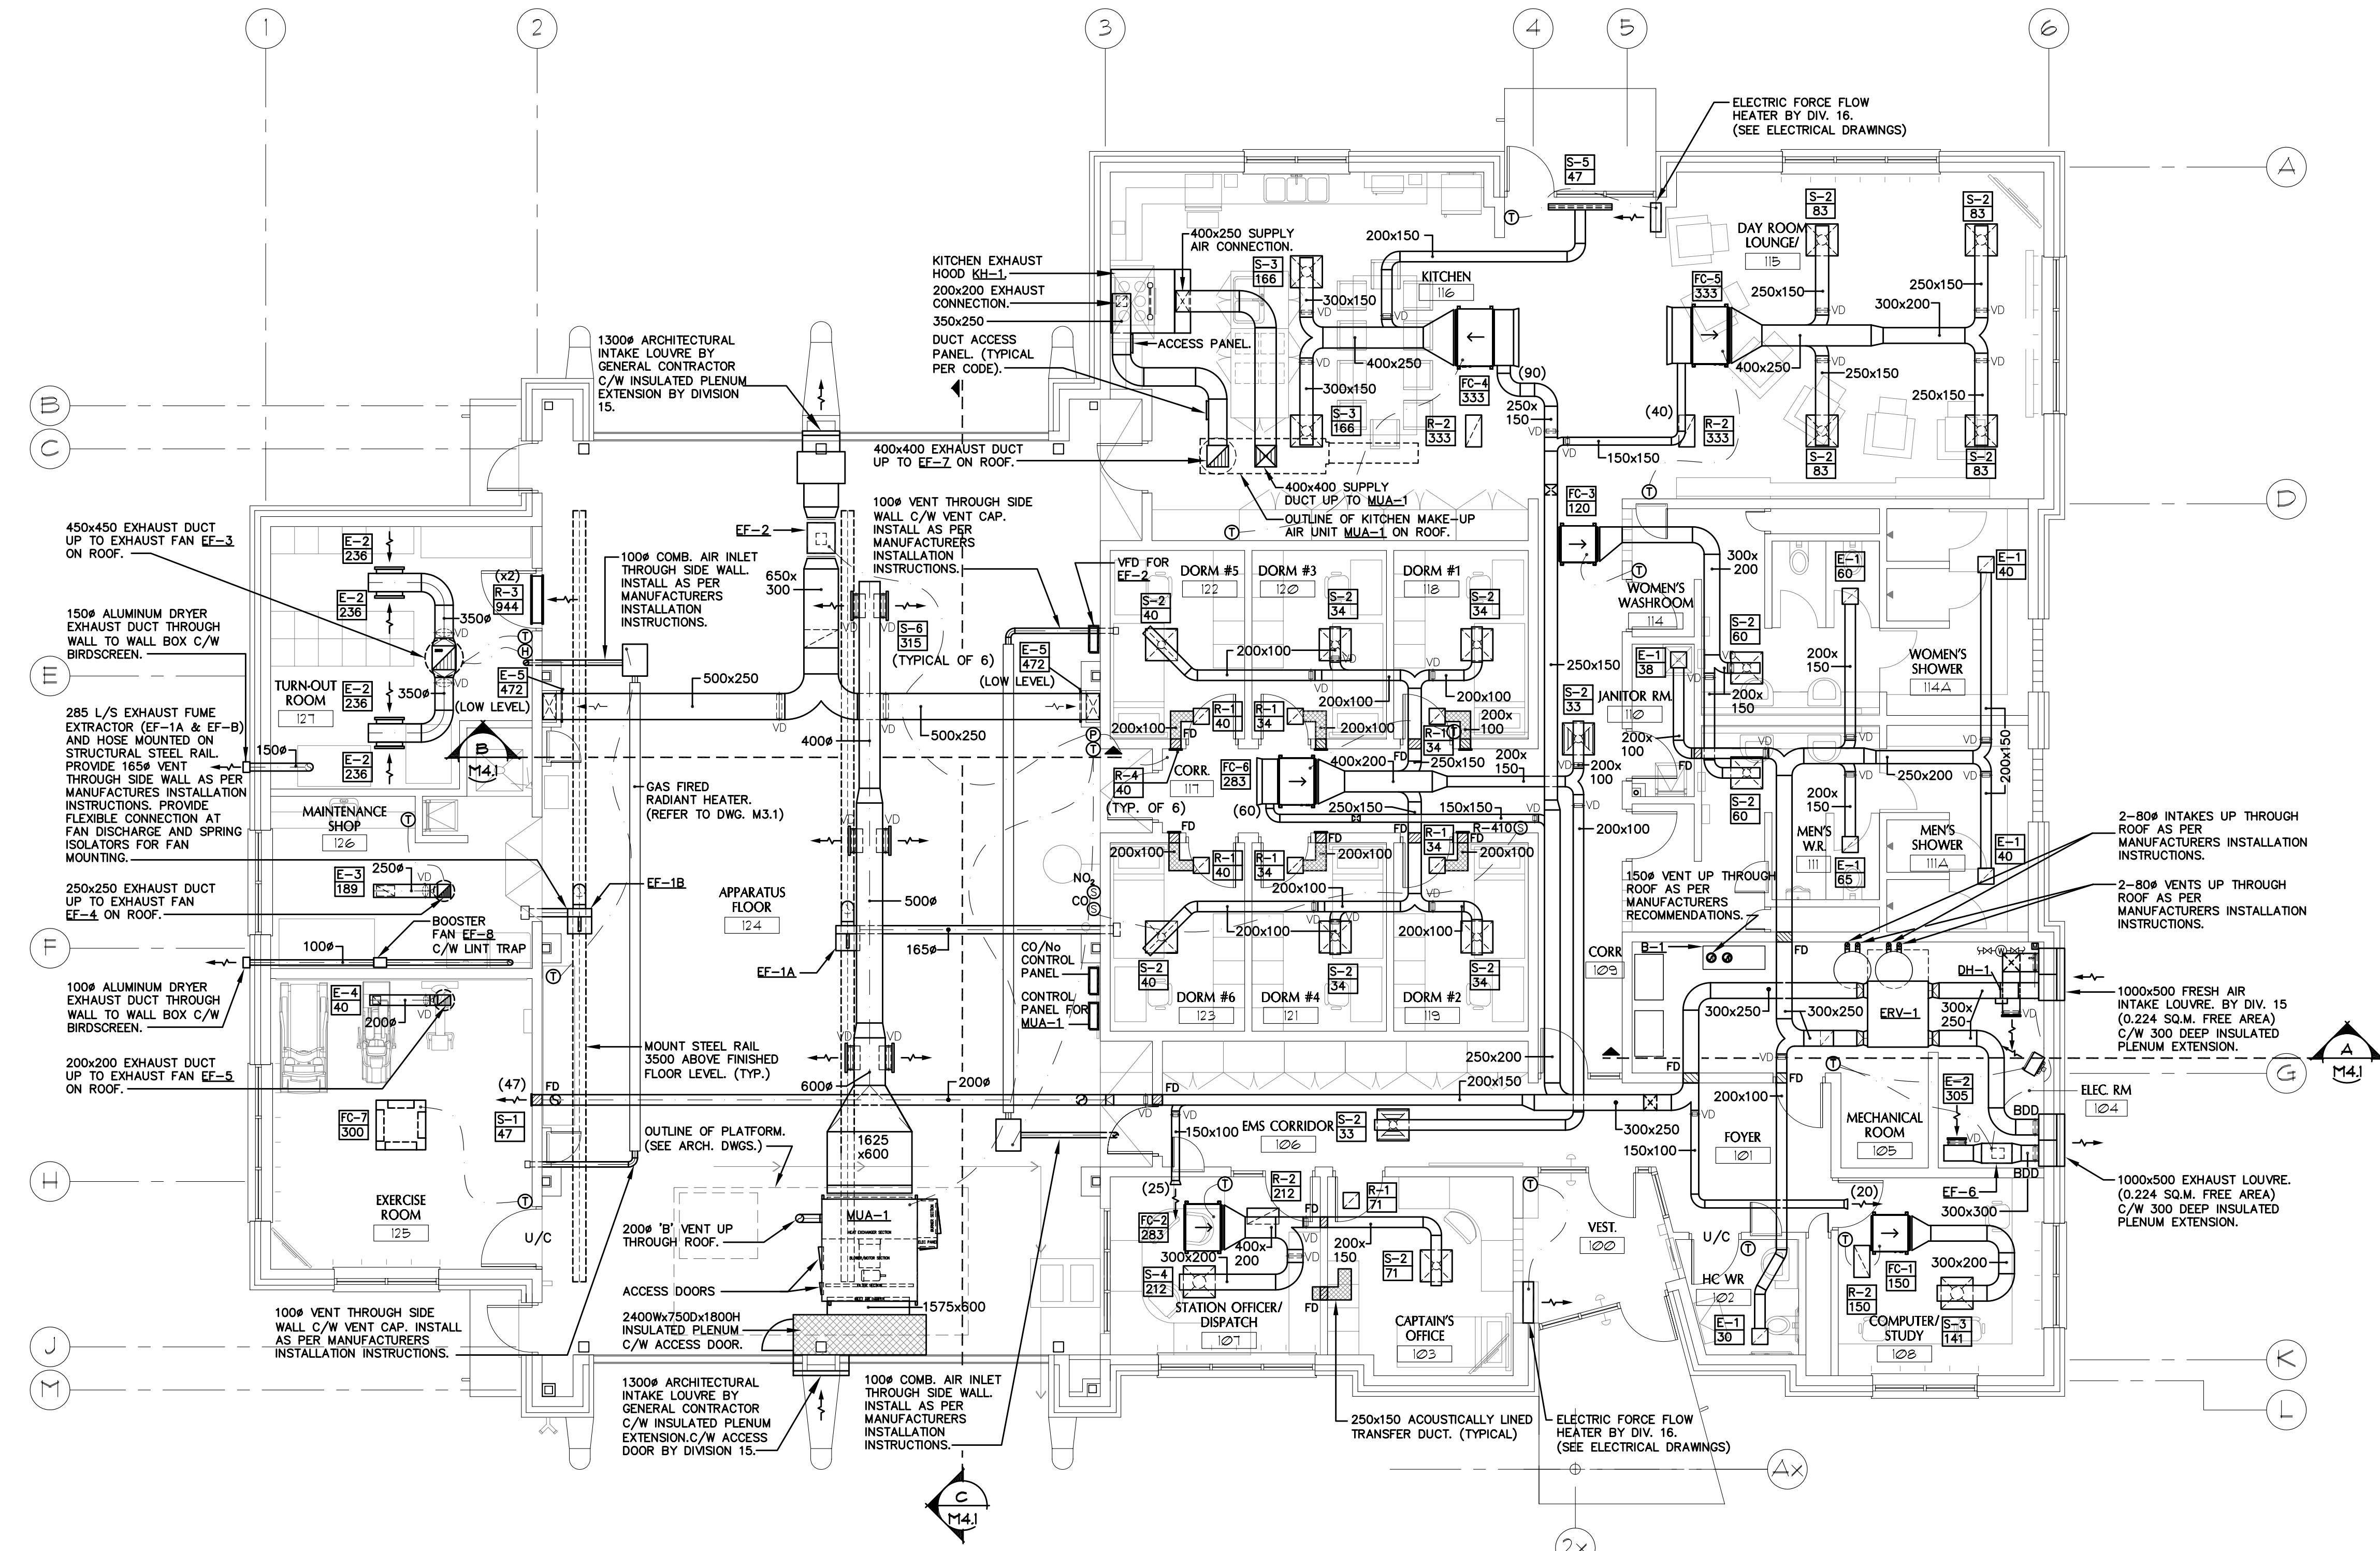

C M4.1 SECTION VIEW - APPARATUS FLOOR
SCALE 1: 15

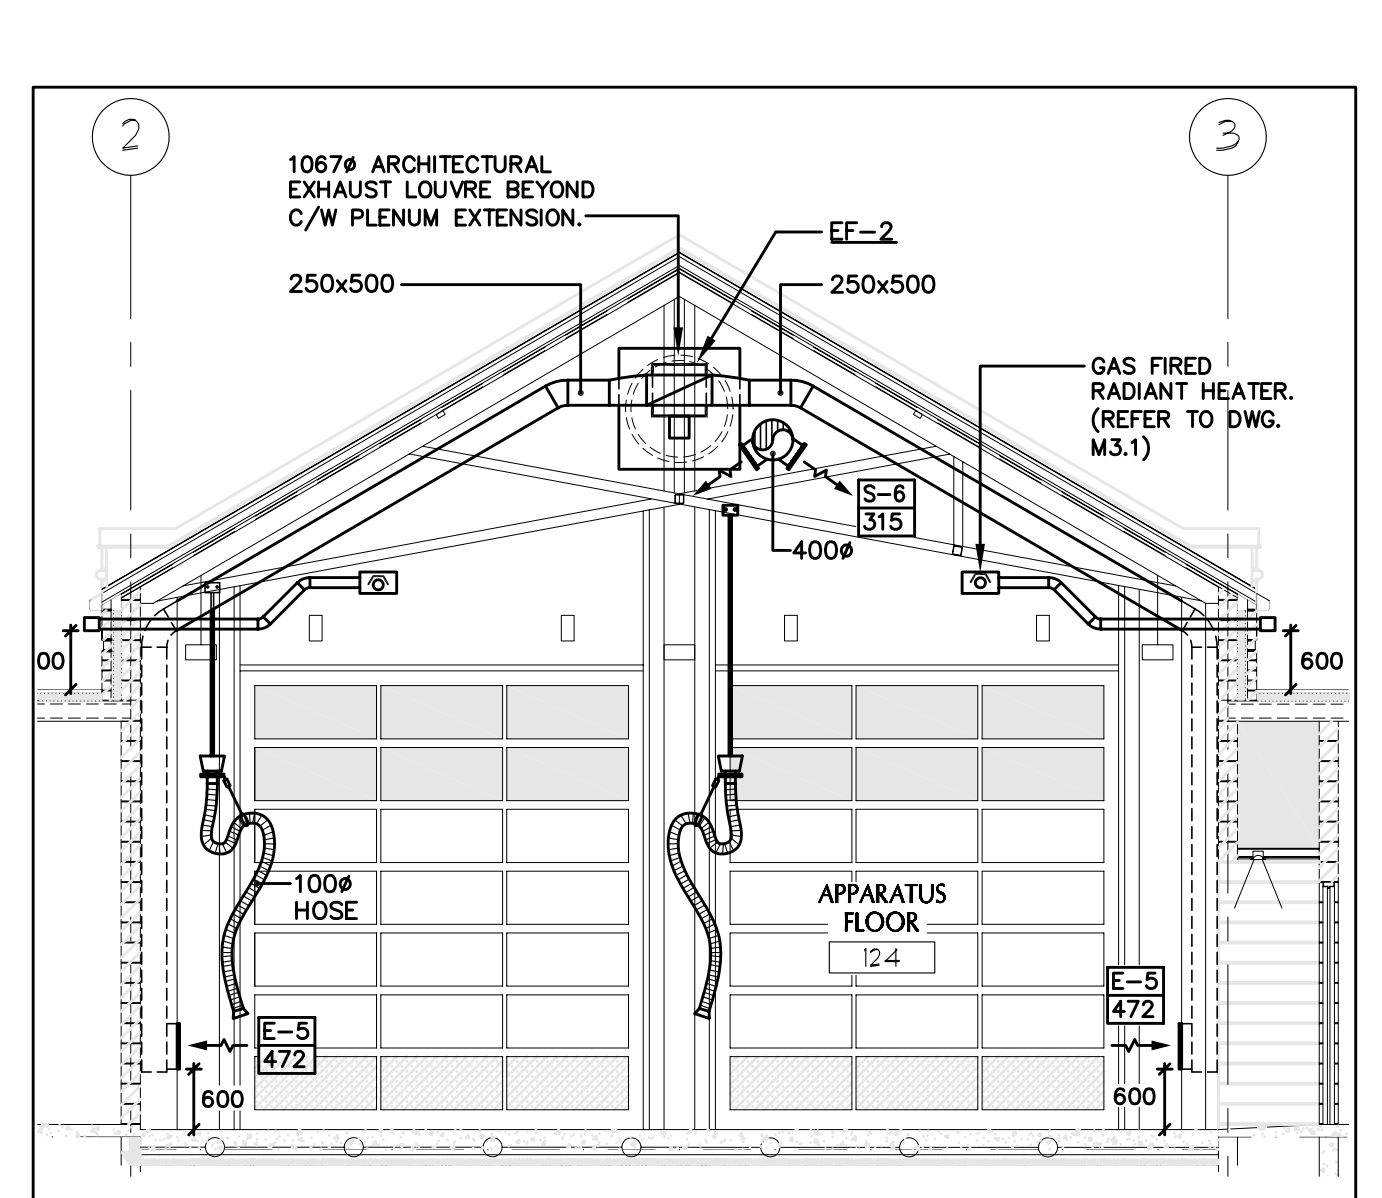

B M4.1 SECTION VIEW - APPARATUS FLOOR
SCALE 1: 15

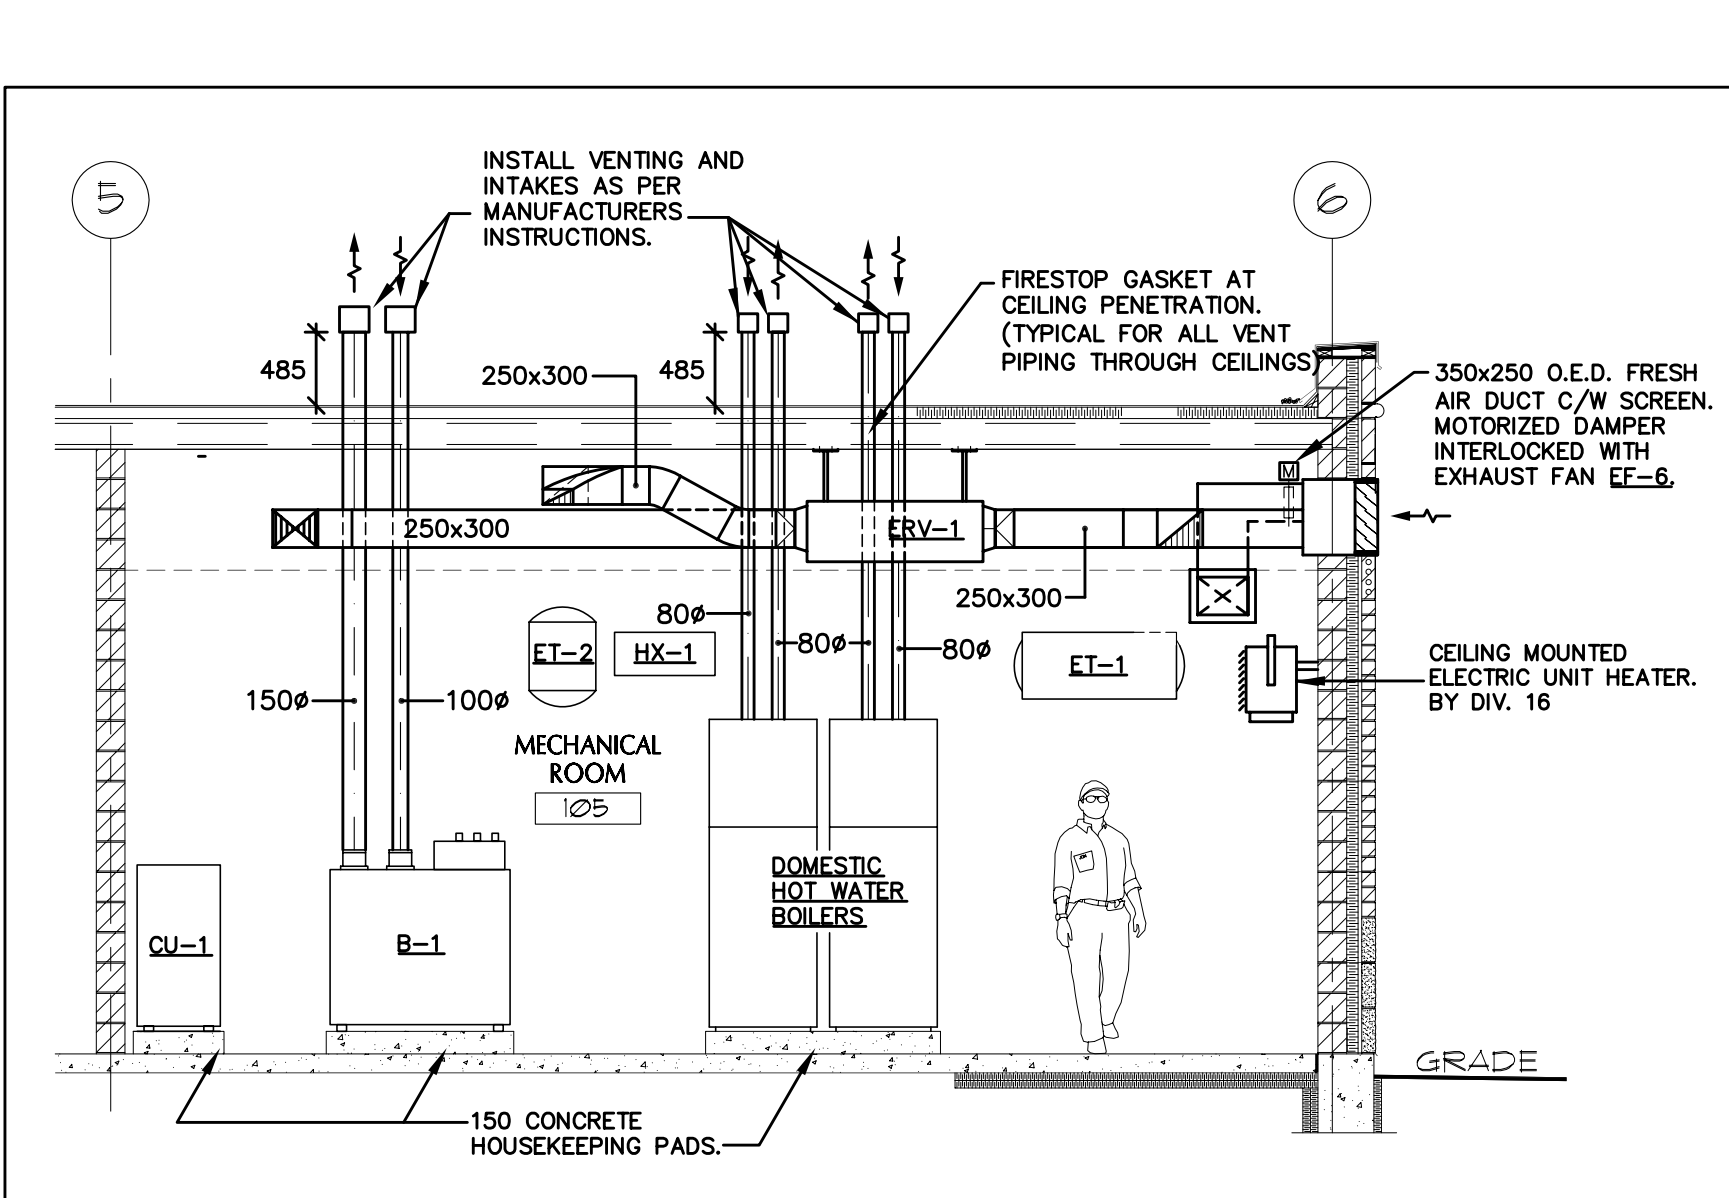

A M4.1 SECTION - MECHANICAL ROOM
SCALE 1: 50




REVIEW ALL DRAWINGS AND VERIFY ALL DIMENSIONS AT THE SITE. DO NOT SCALE THE DRAWINGS. REPORT ALL DISCREPANCIES TO THE ENGINEER BEFORE PROCEEDING WITH ANY CONSTRUCTION OR SHOP FABRICATION. ALL DRAWINGS, SPECIFICATIONS AND RELATED DOCUMENTS ARE THE COPYRIGHT PROPERTY OF VANDERWESTEN RUTHERFORD MANTECON AND MUST BE RETURNED UPON REQUEST. REPRODUCTION OF DRAWINGS, SPECIFICATIONS AND RELATED DOCUMENTS IN PART OR WHOLE IS FORBIDDEN WITHOUT THE CONSULTANT'S WRITTEN PERMISSION.

PROJECT NAME:
NEW WINNIPEG STATION No. 27 PROJECT

SAGE CREEK, WINNIPEG, MANITOBA

DRAWING TITLE:
FLOOR PLAN AIR DISTRIBUTION

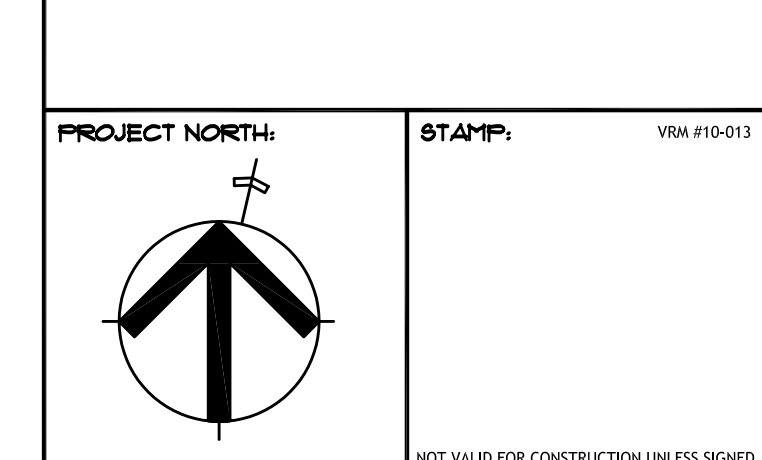

PROJECT NORTH:
STAMP: VRM P10-013
SCALE: 1:15
DATE: DECEMBER 10, 2010
ISSUED: DECEMBER 10, 2010
DRAWN BY: AP
CHECKED BY: WAR
PROJECT NO.: 2261
FILE NAME:
DRAWING NO.: M4.1