


File Name: P:\Projects\2011\11-0107-33\Doc\Control\ToBeIssued\DWG\11-0107-33_LD-5726-Rev 0.dwg - Tab: LD-5726 Plotted By: DDeRoche 11/12/19 [Mon 2:03pm] A:\PLOT SCALE: 1:1

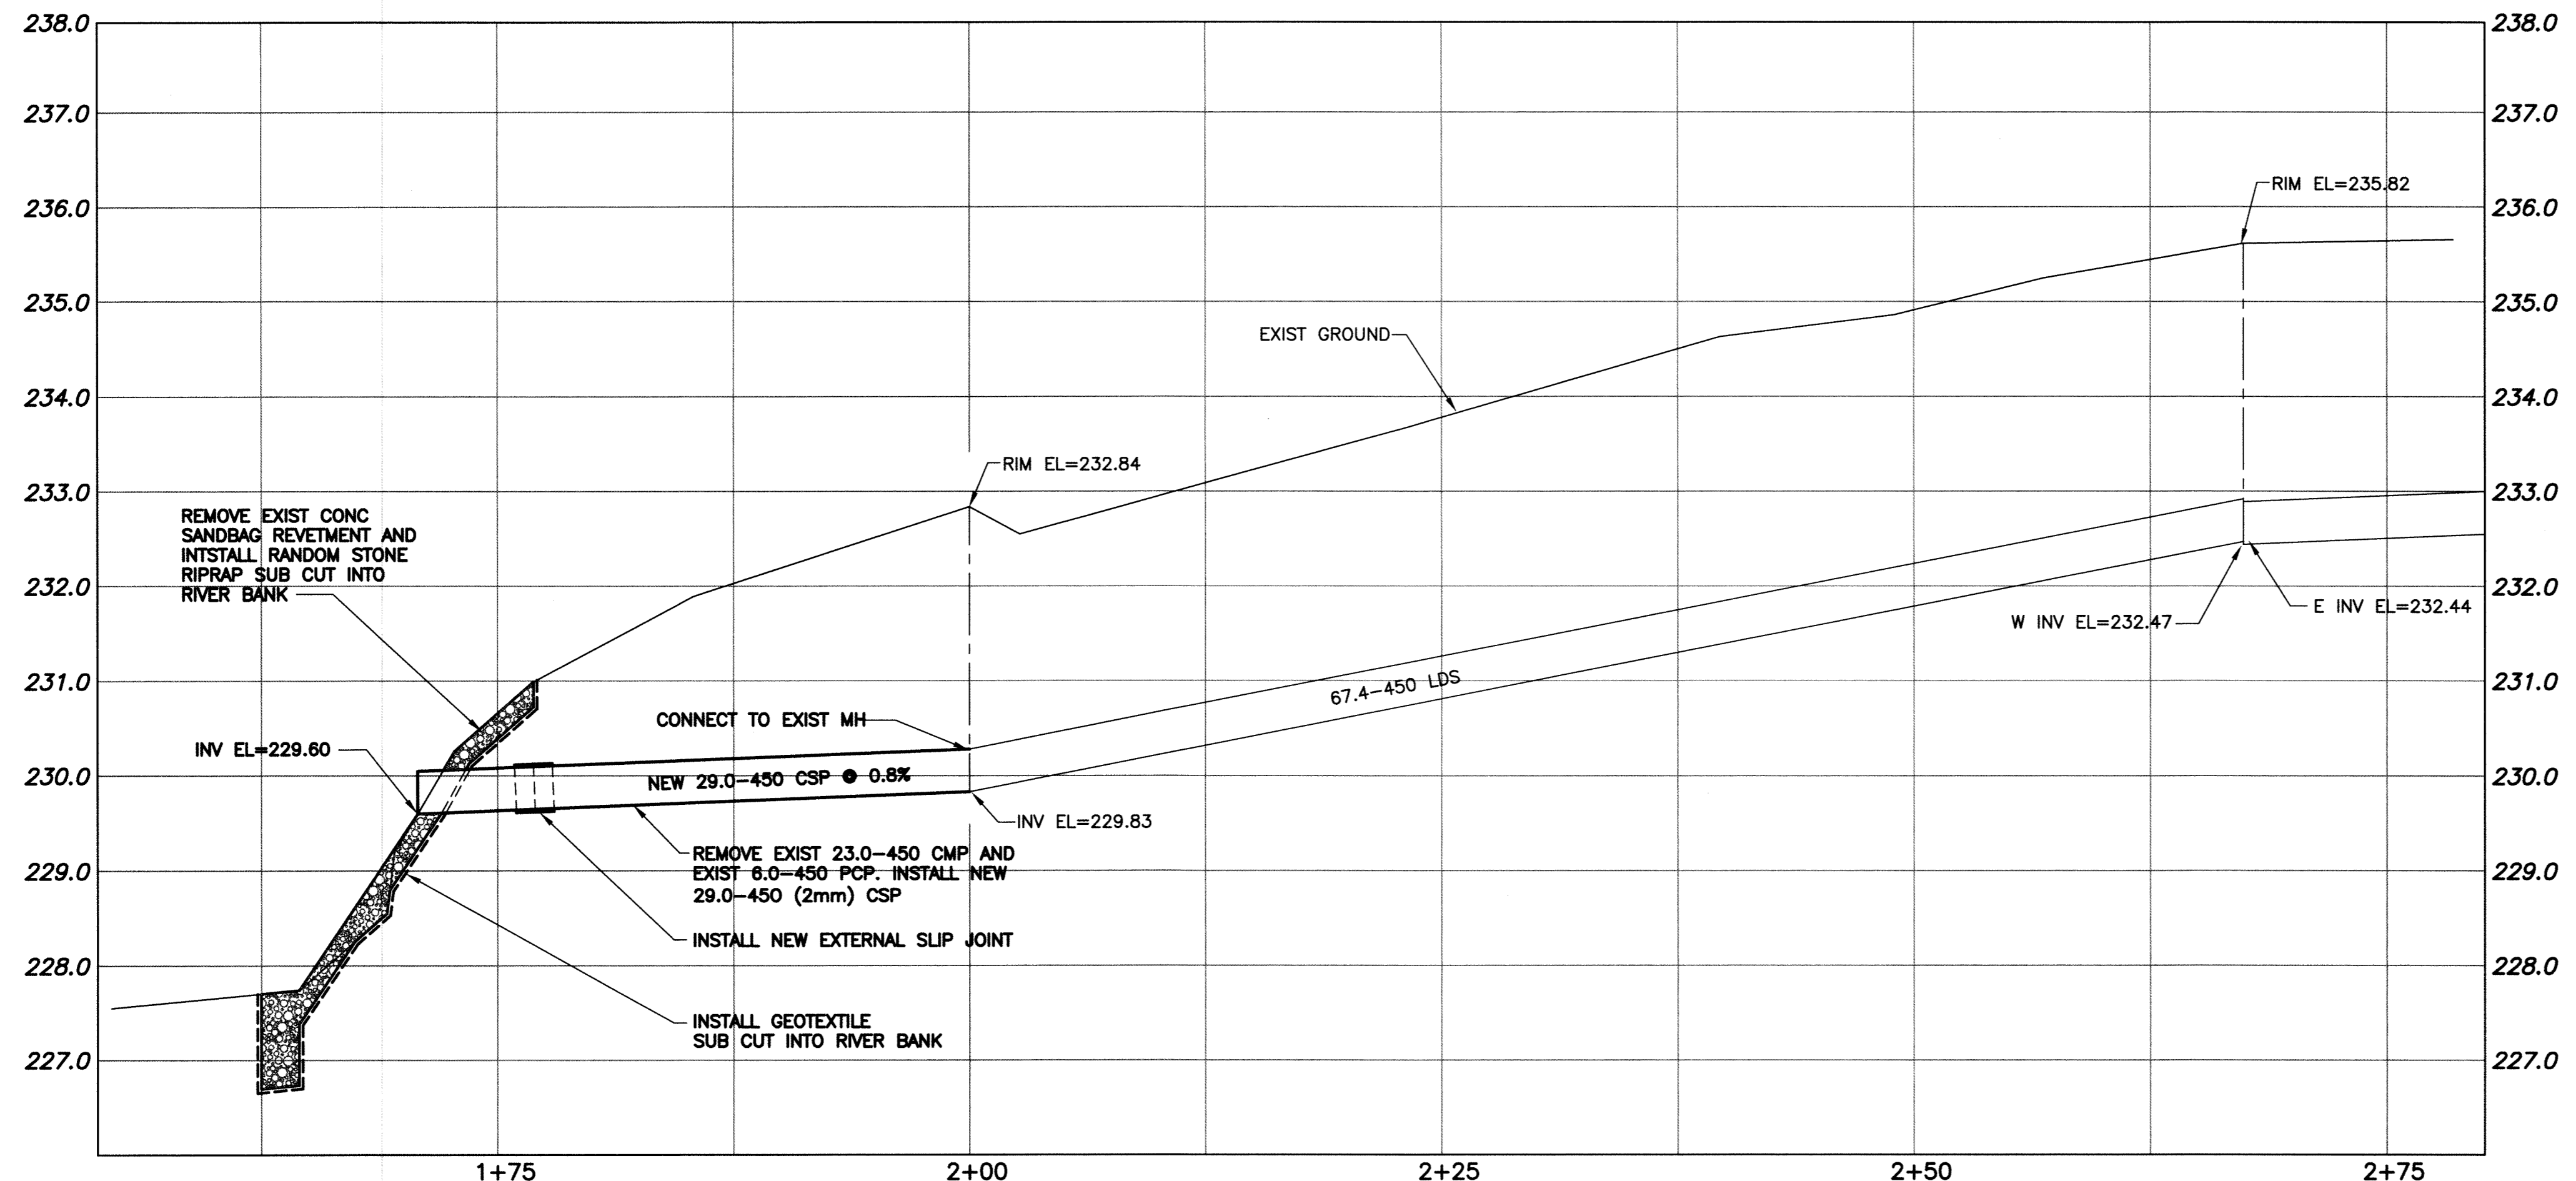

- NOTE:**
- PIPE ELEVATIONS ARE ESTABLISHED FROM CITY OF WINNIPEG RECORD DRAWINGS
 - ALL EXCAVATED MATERIAL TO BE MOVED OFF SITE



PROPERTY LIMITS DELINEATION

DELINEATION OF PROPERTY LIMITS AS SHOWN ON THIS DWG DOES NOT REPRESENT A "LEGAL SURVEY". KGS GROUP MAKES NO REPRESENTATION OR WARRANTY AS TO THE ACCURACY OF PROPERTY LIMITS DELINEATED ON THIS DWG, NOR ON THE DIMENSIONAL ACCURACY OF DWG FEATURES RELATIVE TO THOSE PROPERTY LIMITS.

- WARNING**
- NOTIFY THE GAS COMPANY OF THE PROPOSED LOCATION OF EXCAVATION.
 - TAKE PRECAUTION TO AVOID DAMAGE TO GAS COMPANY INSTALLATIONS.
 - SEE PROVINCIAL REGULATION 210/72 FOR DETAILS.

METRIC

WHOLE NUMBERS INDICATE MILLIMETRES
DECIMALIZED NUMBERS INDICATE METRES

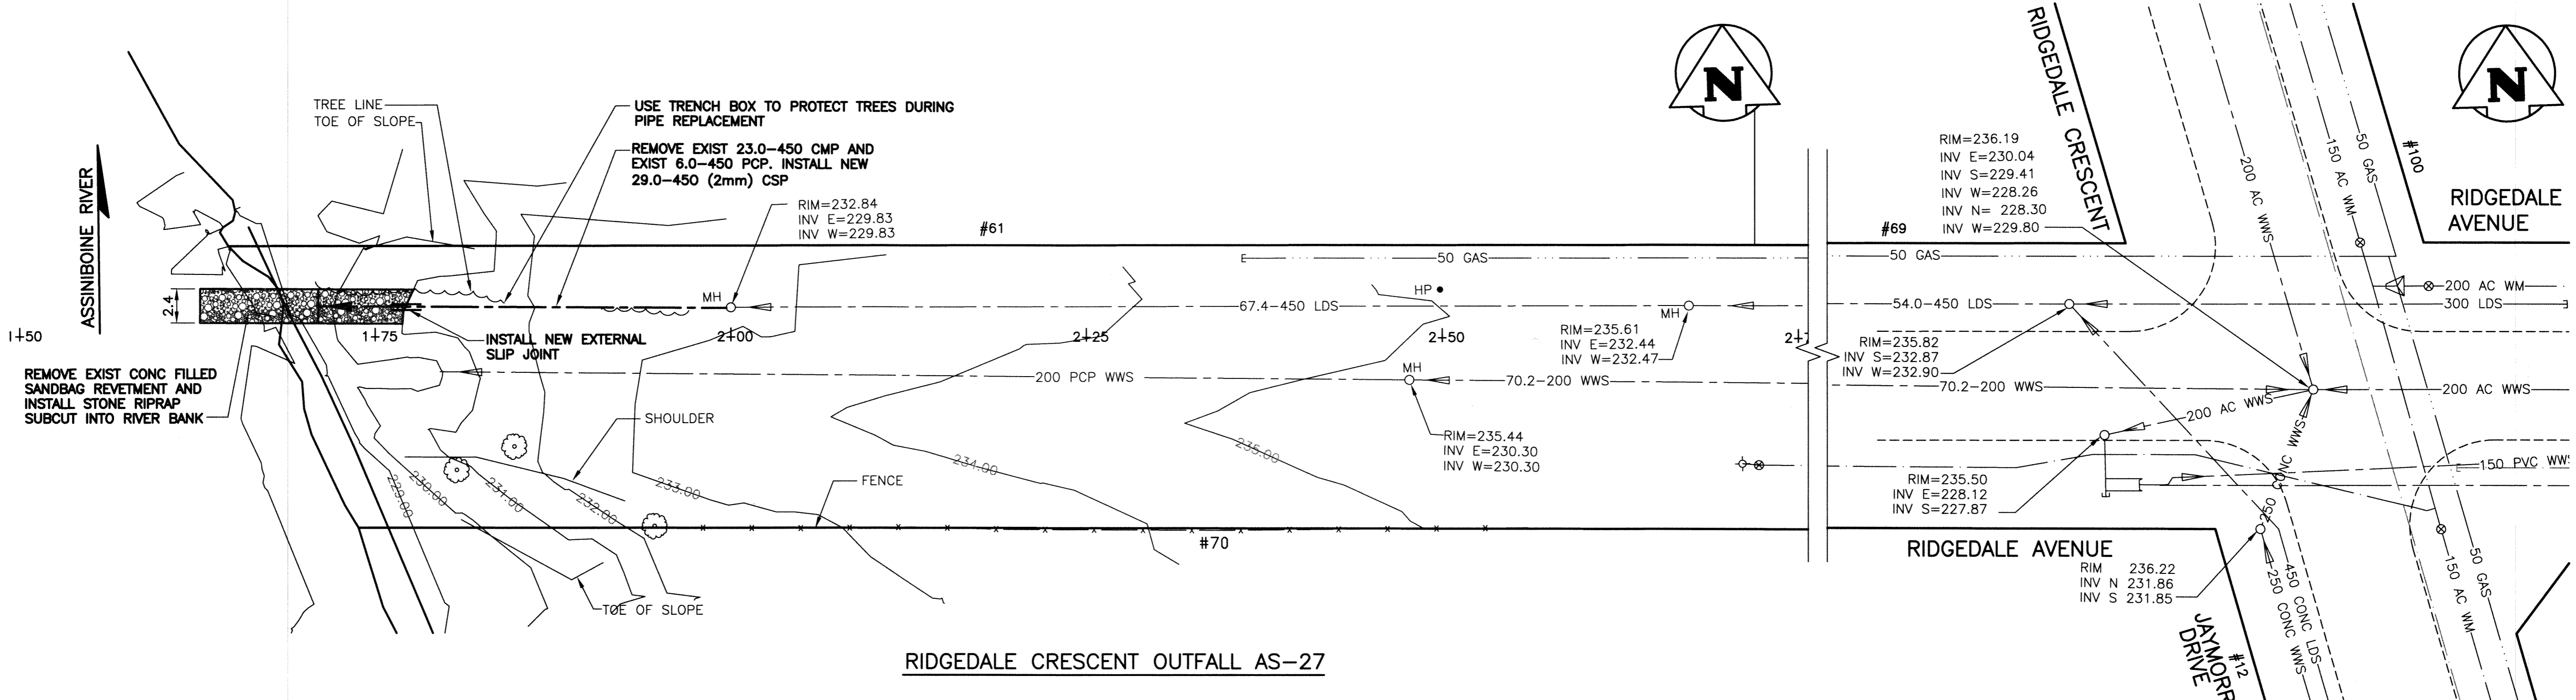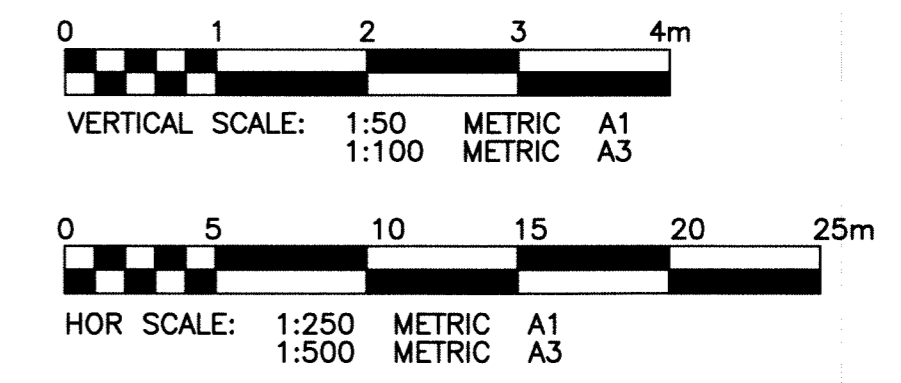

RIDGE DALE CRESCENT OUTFALL AS-27

300 LDS	LAND DRAINAGE SEWER	300 LDS	EXISTING	LEGEND-PLAN	PROPOSED	EXISTING	LEGEND-PLAN	PROPOSED	EXISTING	LEGEND-PROFILE	PROPOSED
---	WASTE WATER SEWER	---	---	---	---	---	---	---	---	---	---
---	GAS	---	---	---	---	---	---	---	---	---	---
---	HYDRO	---	---	---	---	---	---	---	---	---	---
---	M.T.S.	---	---	---	---	---	---	---	---	---	---
---	WATERMAIN	---	---	---	---	---	---	---	---	---	---
---	HYDRANT	---	---	---	---	---	---	---	---	---	---
---	VALVE	---	---	---	---	---	---	---	---	---	---
---	MANHOLE	---	---	---	---	---	---	---	---	---	---
---	CATCH BASIN	---	---	---	---	---	---	---	---	---	---
---	CURB INLET	---	---	---	---	---	---	---	---	---	---
---	POLES	---	---	---	---	---	---	---	---	---	---
---	LEGEND-PLAN	---	---	---	---	---	---	---	---	---	---

LOCATION APPROVED UNDERGROUND STRUCTURES

SUPV. U/G STRUCTURES DATE COMMITTEE

NOTE:
LOCATION OF UNDERGROUND STRUCTURES AS SHOWN ARE BASED ON THE BEST INFORMATION AVAILABLE BUT NO GUARANTEE IS GIVEN THAT ALL EXISTING UTILITIES ARE SHOWN OR THAT THE GIVEN LOCATIONS ARE EXACT. CONFIRMATION OF EXISTENCE AND EXACT LOCATION OF ALL SERVICES MUST BE OBTAINED FROM THE INDIVIDUAL UTILITIES BEFORE PROCEEDING WITH CONSTRUCTION.

B.M. KGS BASE ELEV.	DWGS BASED ON C.S.R.S. NAD 83 SYSTEM, UTM GRID	NO.	REVISIONS	DATE	BY
		0	ISSUED FOR TENDER	11/12/19	RBO

KGS GROUP CONSULTING ENGINEERS

DESIGNED BY: RBO
DRAWN BY: DMW
CHECKED BY: RJH
APPROVED BY: [Signature]
HOR. SCALE: 1:250
VERTICAL: 1:50
DATE: 11/11/03

ENGINEER'S SEAL

R.B. OFFMAN
Member
24701
REGISTERED PROFESSIONAL ENGINEER

THE CITY OF WINNIPEG WATER AND WASTE DEPARTMENT

PROJECT TITLE: 2012 OUTFALL RENEWAL/REHABILITATION PROGRAM
RIDGE DALE CRESCENT OUTFALL (AS-27)
PROPOSED PLAN AND PROFILE

SHEET 01 OF 07
COMPUTER FILE NAME: 11-0107-33_01
CITY DRAWING NUMBER: LD-5726

CONSULTANT DRAWING NO. 11-0107-33_01

APEGM
Certificate of Authorization
KGS Group
No. 245