



1 PULL STATION DETAIL - CLASS 1, ZONE 2
SCALE 1:4

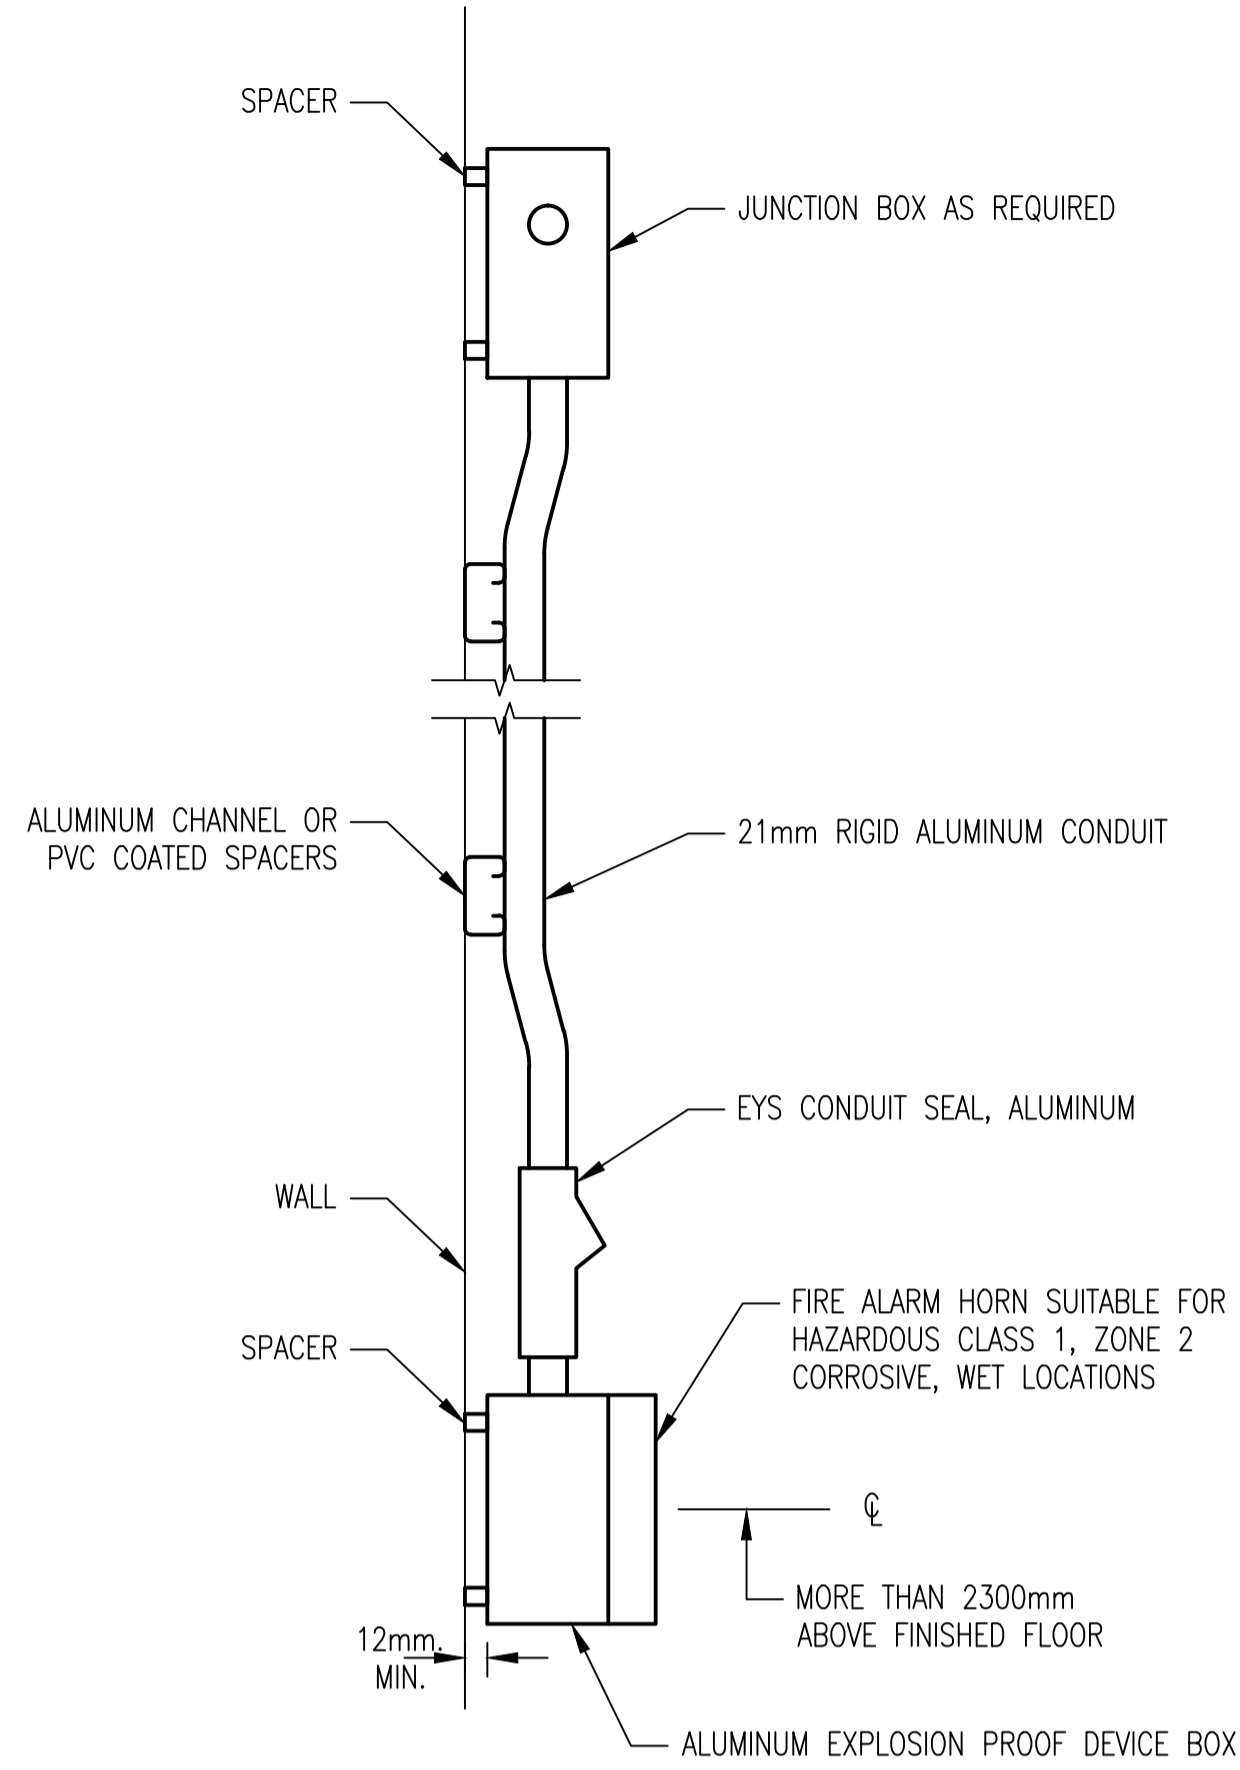

2 AUDIBLE SIGNAL DEVICE - CLASS 1, ZONE 2
SCALE 1:4

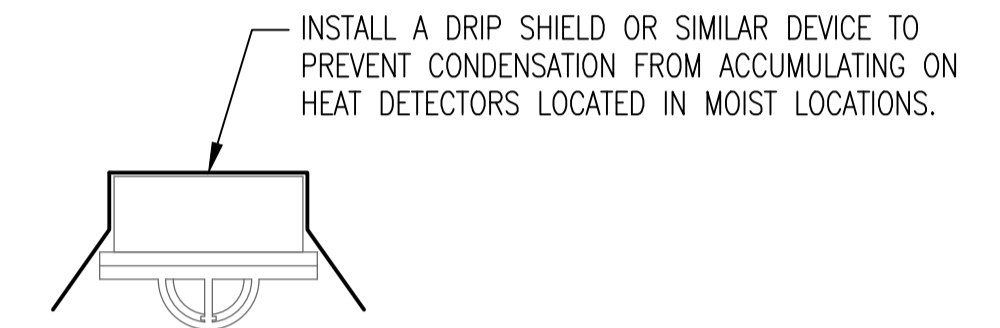

3 HEAT DETECTOR DRIP SHIELD DETAIL
SCALE 1:4

NOTES:

- THE DETAILS SHOWN ARE SUITABLE FOR CATEGORY 2 WET LOCATIONS.



NO.	REVISIONS	DATE	DESIGN	CHECK
00	ISSUED FOR TENDER, BID OPP. 209-2011	2011/03/11	EFB	CJR

SNC-LAVALIN INC. 148 Nature Park Way Winnipeg, MB, Canada R3P 0X7 204-786-8080	
DESIGNED BY: E. BOHNCKE	CHECKED BY: C. REIMER
DRAWN BY: S. COATES	APPROVED BY: C. REIMER
SCALE: 1:4	RELEASED FOR CONSTRUCTION BY: N. HARRINGTON DATE: 2011/03/11
DATE: 2011/03/22	DATE: 2011/03/11
CONSULTANT NO.: 112577-0101-40DD-0005	

ENGINEER'S SEAL
 ORIGINAL DRAWING
 SEALED BY:
 C. J. REIMER
 SNC-LAVALIN
 MEMBER #21968
 2011/03/25
 REV. 00

THE CITY OF WINNIPEG
 WATER AND WASTE DEPARTMENT
 SOUTH END WATER POLLUTION CONTROL CENTER
 FIRE ALARM UPGRADE
 INSTALLATION DETAILS
 HAZARDOUS CLASS 1, ZONE 2
 CITY DRAWING NUMBER: 1-0102A-E0005
 SHEET: 001
 REV: 00
 SIZE: A1

1-0102A-E0001	FIRE ALARM LEGEND AND DETAILS
DRAWING NUMBER	REFERENCE DRAWINGS