


CONSTRUCTION NOTES	
1	COMPRESSION LUGS REQUIRED.
2	CABLE FOR J26 AND J30 ON UPS MONITORING BOARD COMES PRE-WIRED TO MAINTENANCE BYPASS CABINET.

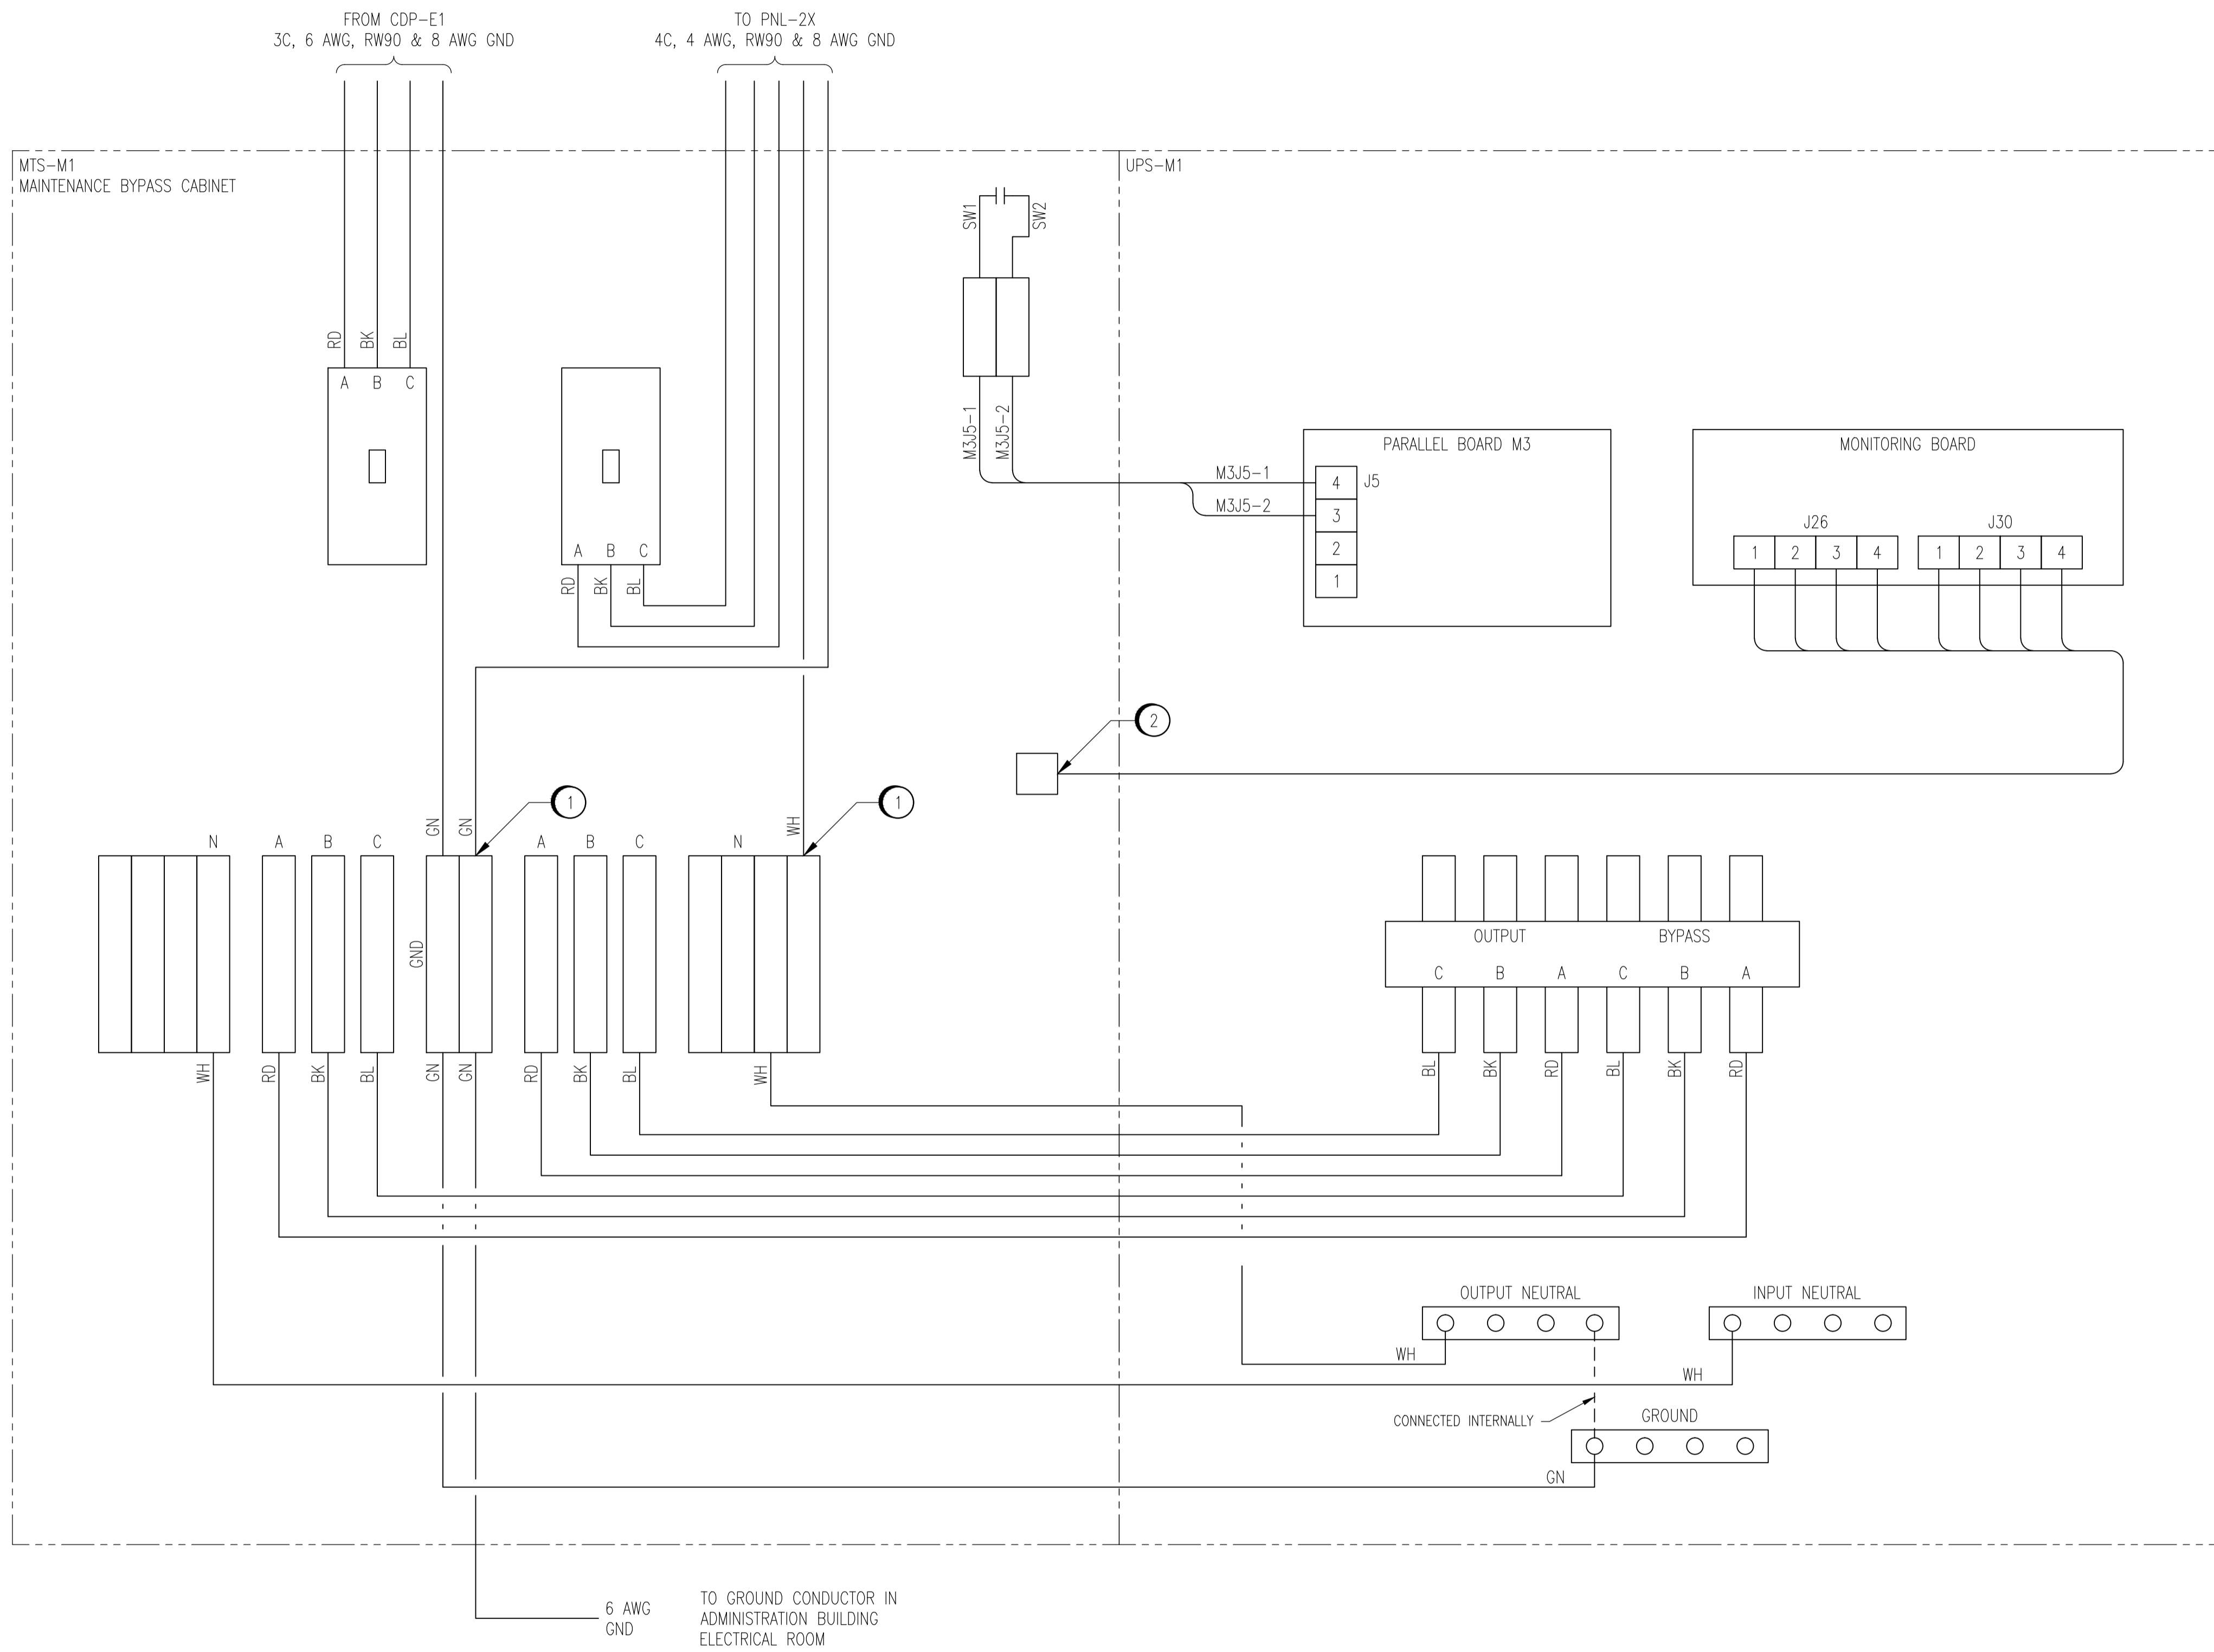

MTS-M1 AND UPS-M1

1-0102M-E0007	SINGLE LINE DIAGRAM - ADMINISTRATION BUILDING
DRAWING NUMBER	REFERENCE DRAWINGS

APECM
 Certificate of Authorization
SNC-Lavalin Inc.
 No. 4489

NO.	REVISIONS	DATE	DESIGN	CHECK
00	ISSUED FOR TENDER, BID OPP. 209-2011	2011/03/11	TMC	CJR

SNC-LAVALIN INC.
 148 Nature Park Way
 Winnipeg, MB, Canada R3P 0X7
 204-786-8080

DESIGNED BY: T. CHURCH
 CHECKED BY: C. REIMER
 DRAWN BY: S. COATES
 APPROVED BY: C. REIMER
 SCALE: NTS
 RELEASED FOR CONSTRUCTION BY: N. HARRINGTON
 DATE: 2010/01/25
 DATE: 2011/03/11
 CONSULTANT NO.: 112577-0106-47DD-0103

ENGINEER'S SEAL
 ORIGINAL DRAWING
 SEALED BY:
 T. M. CHURCH
 SNC-LAVALIN
 MEMBER # 32682
 2011/03/25
 REV. 00

THE CITY OF WINNIPEG
 WATER AND WASTE DEPARTMENT

SOUTH END WATER POLLUTION CONTROL CENTRE
 ESSENTIAL SYSTEM UPGRADES
 WIRING DIAGRAM
 UPS-M1

CITY DRAWING NUMBER: 1-0102M-E0010
 SHEET: 001
 REV: 00
 SIZE: A1