
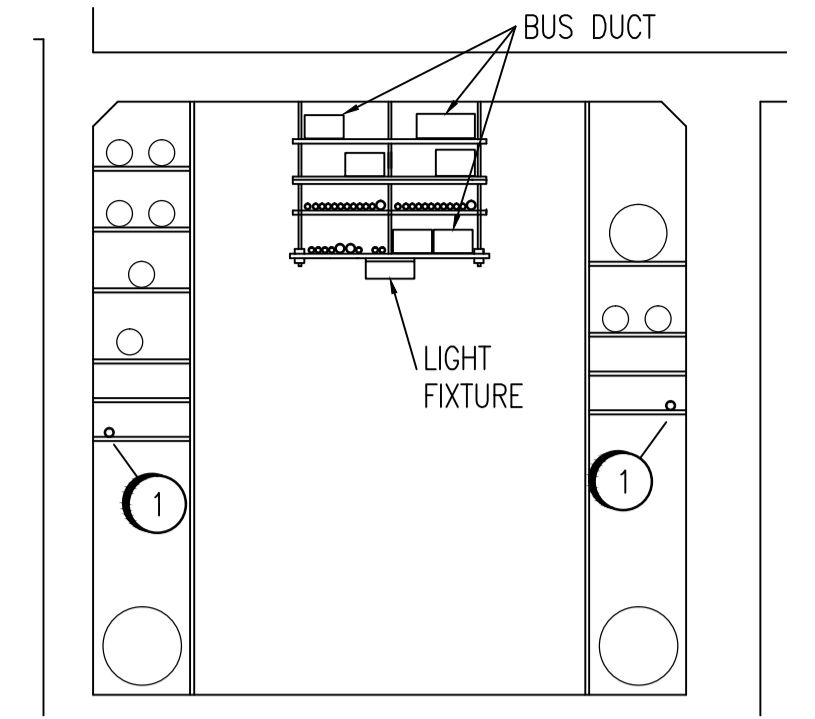
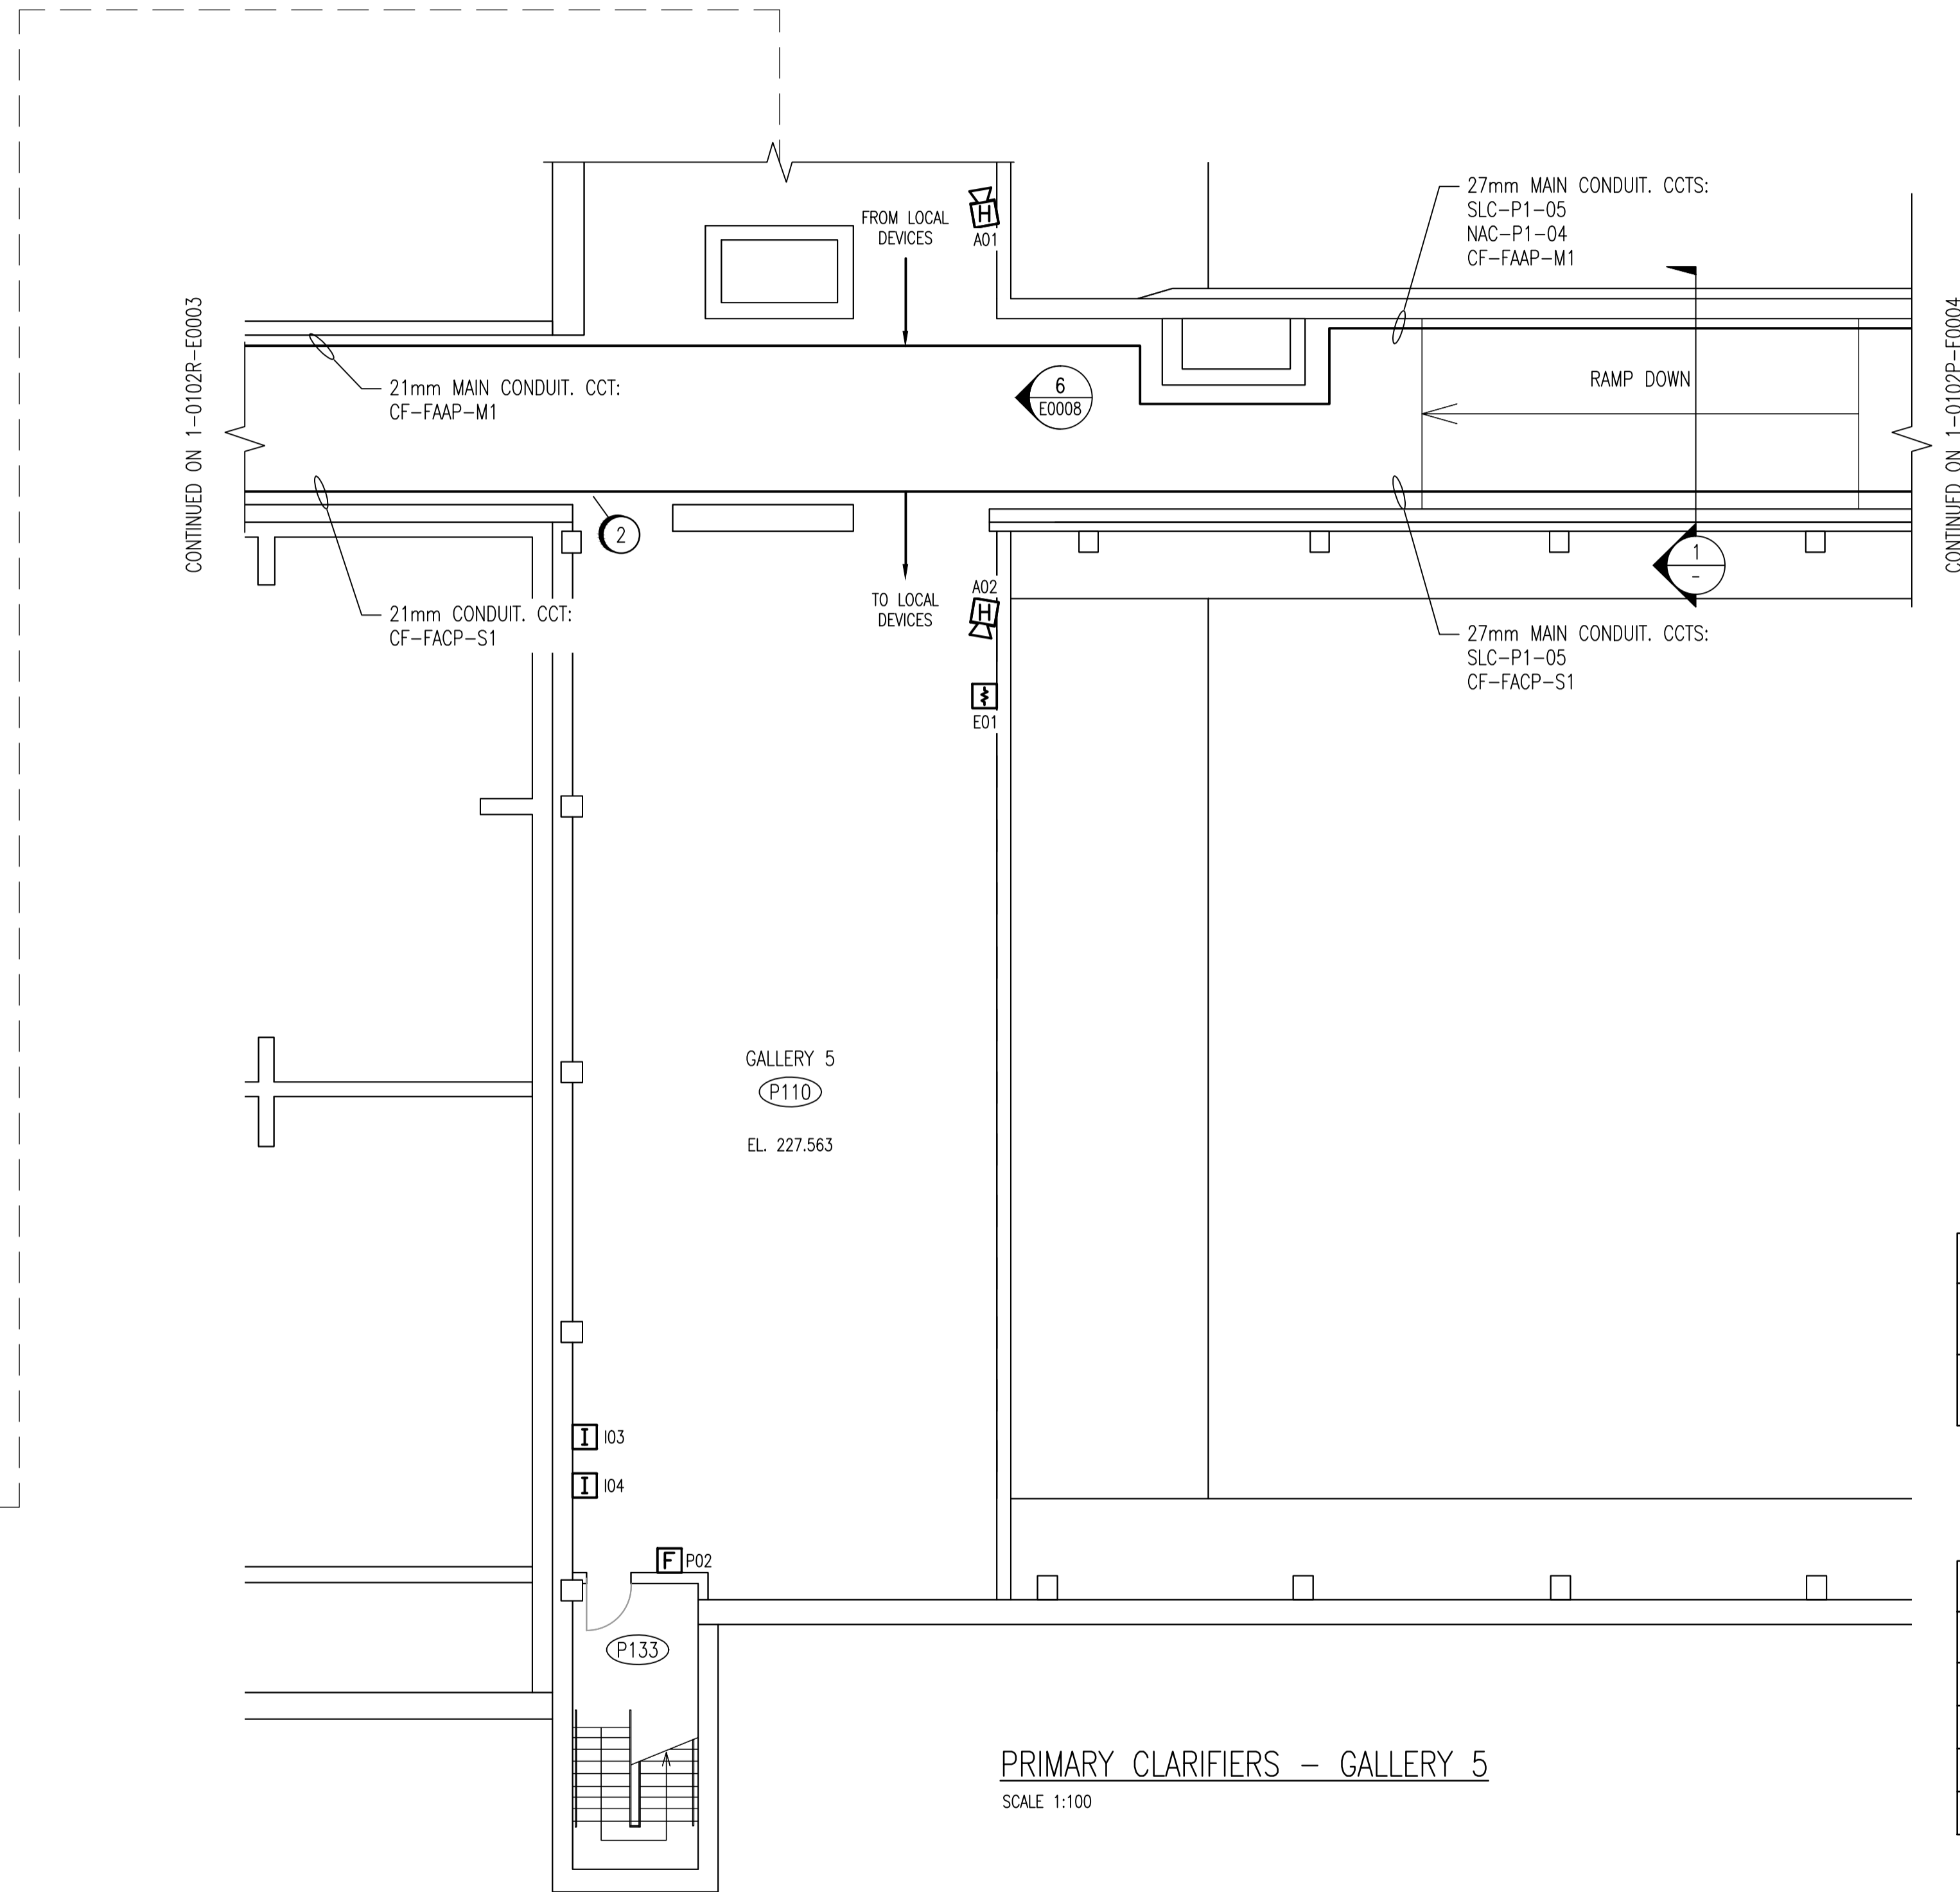


KEYPLAN

 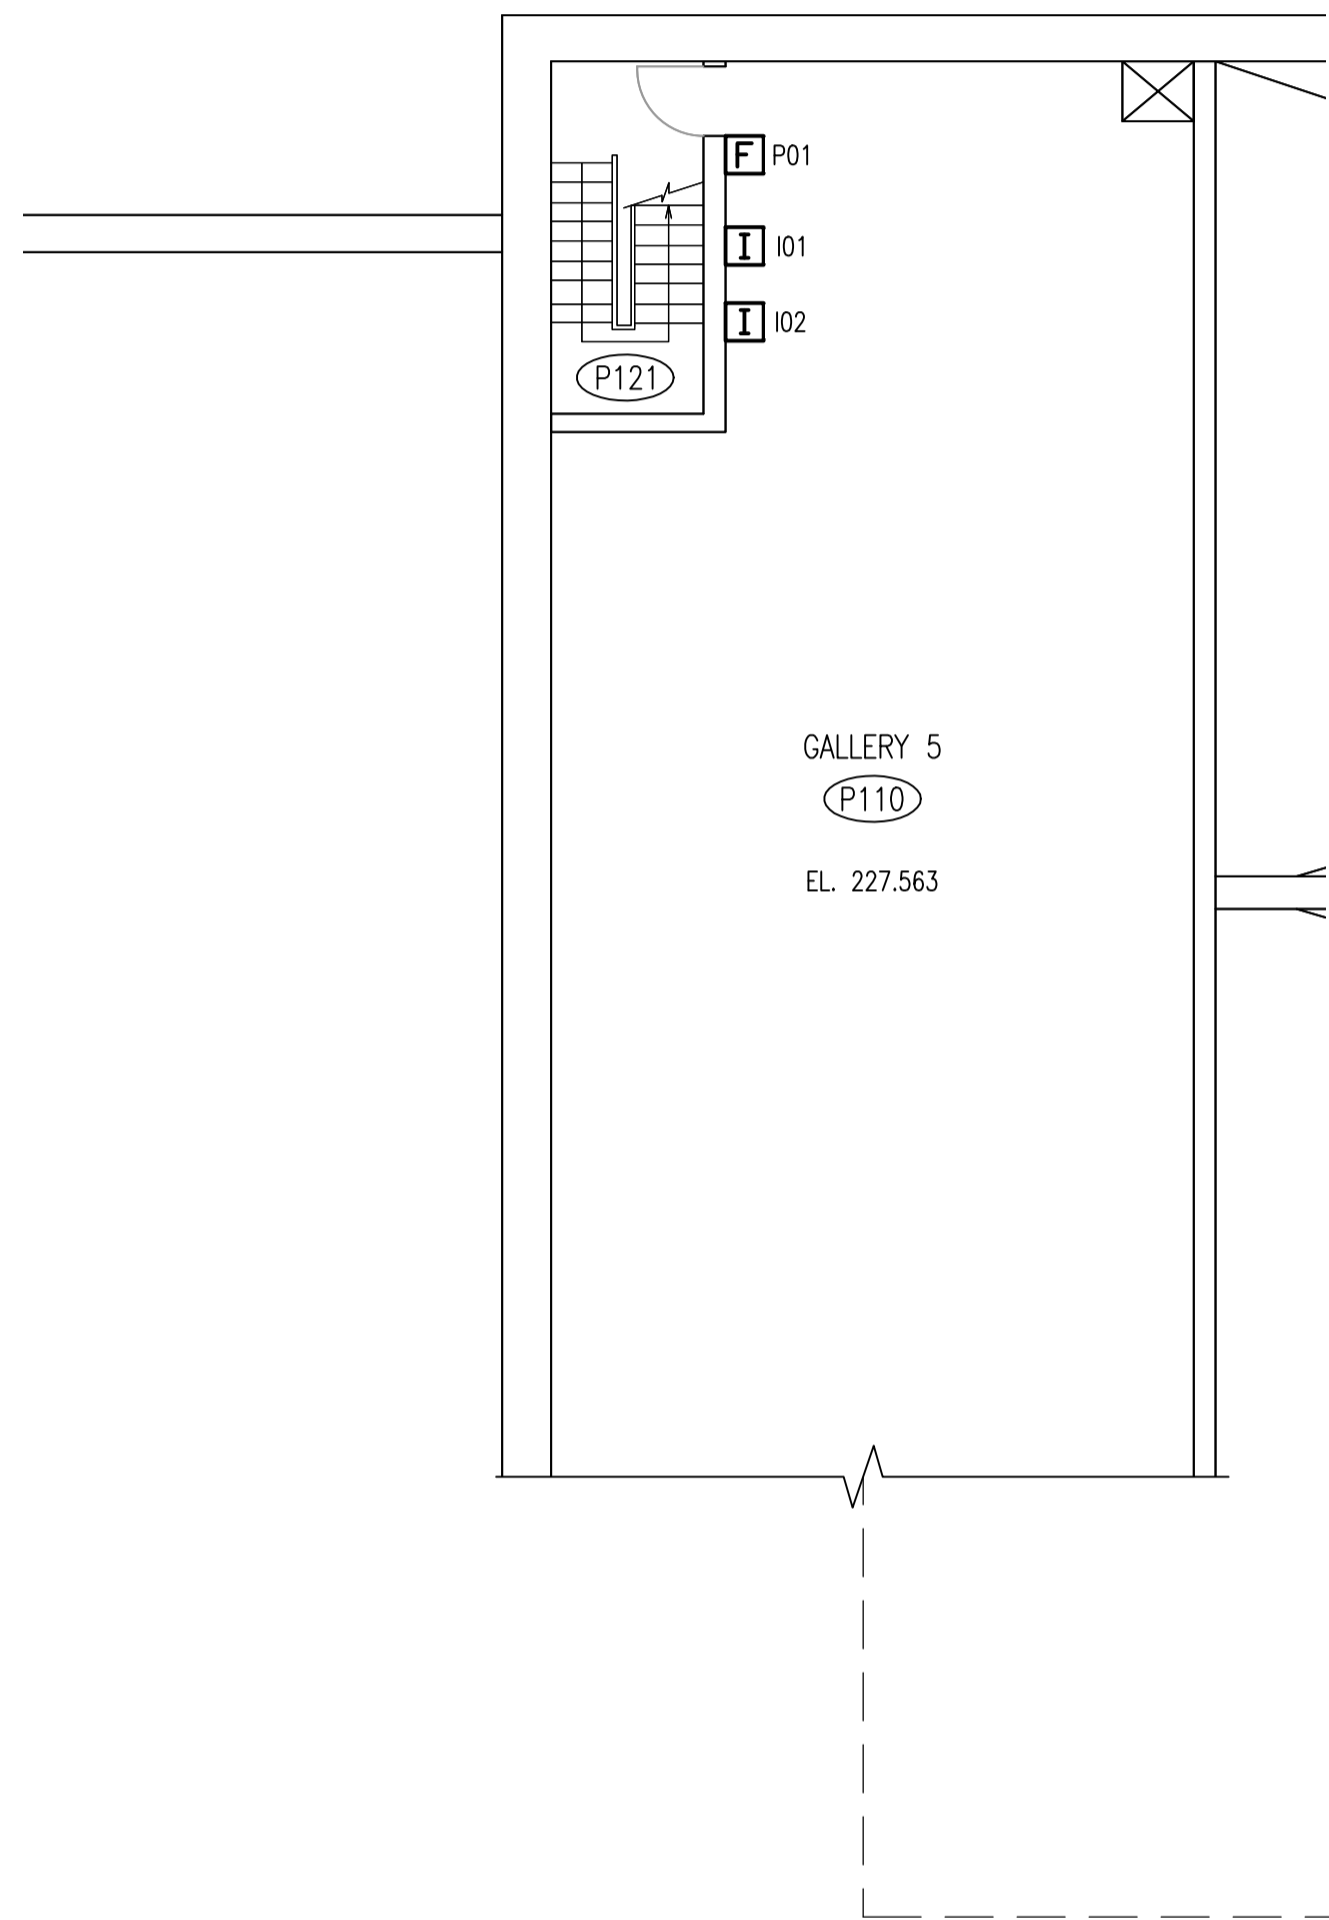


GALLERY 3  
SCALE 1:50

CONSTRUCTION NOTES	
1	PROVIDE UNISTRUT SUPPORT 150mm BELOW EXISTING PIPE SUPPORT. CLAMP CONDUIT TO NEW SUPPORT.
2	INSTALL CONDUIT EXPANSION JOINT AT LOCATION OF EXISTING JOINTS.

ROOM DETAILS			
ROOM ID	HEIGHT	Ceilings TYPE	REF DWG
P110	6.62m	CONCRETE	SEP-258
P121	14.78m	STAIRWELL	SEP-054
P127	6.62m	CONCRETE	SEP-258
P133	16.29m	STAIRWELL	SEP-252

NOTES:  
1. DEVICE TAGS ARE SHOWN IN SHORTHAND NOTATION. FULL DEVICE TAG FORMAT IS FAS-Pxxx-yyy, WHERE xxx IS THE ROOM NUMBER, AND yyy IS THE DEVICE IDENTIFIER.



NO.	REVISIONS	DATE	DESIGN	CHECK
00	ISSUED FOR TENDER, BID OPP. 209-2011	2011/03/11	EFB	CJR

**SNC-LAVALIN INC.**  
148 Nature Park Way  
Winnipeg, MB, Canada R3P 0X7  
204-786-8080

DESIGNED BY: E. BOHNCKE  
CHECKED BY: C. REIMER  
DRAWN BY: E. BOHNCKE  
APPROVED BY: C. REIMER  
SCALE: AS SHOWN  
RELEASED FOR CONSTRUCTION BY: N. HARRINGTON  
DATE: 2009/03/20  
DATE: 2011/03/11

CONSULTANT NO.: 112577-0101-47DD-0045

ENGINEER'S SEAL  
ORIGINAL DRAWING  
SEALED BY:  
C. J. REIMER  
SNC-LAVALIN  
MEMBER #21968  
2011/03/25  
REV. 00

**THE CITY OF WINNIPEG**  
WATER AND WASTE DEPARTMENT

SOUTH END WATER POLLUTION CONTROL CENTRE  
FIRE ALARM UPGRADE  
PLAN LAYOUT  
FIRE ALARM - PRIMARY CLARIFIERS  
GALLERY 5

CITY DRAWING NUMBER: 1-0102P-E0005  
SHEET: 001  
REV.: 00  
SIZE: A1

1-0102P-E0013	ELECTRICAL CLASSIFICATION PLAN
1-0102A-E0001	FIRE ALARM LEGEND AND DETAILS
DRAWING NUMBER	REFERENCE DRAWINGS