


KEYPLAN

 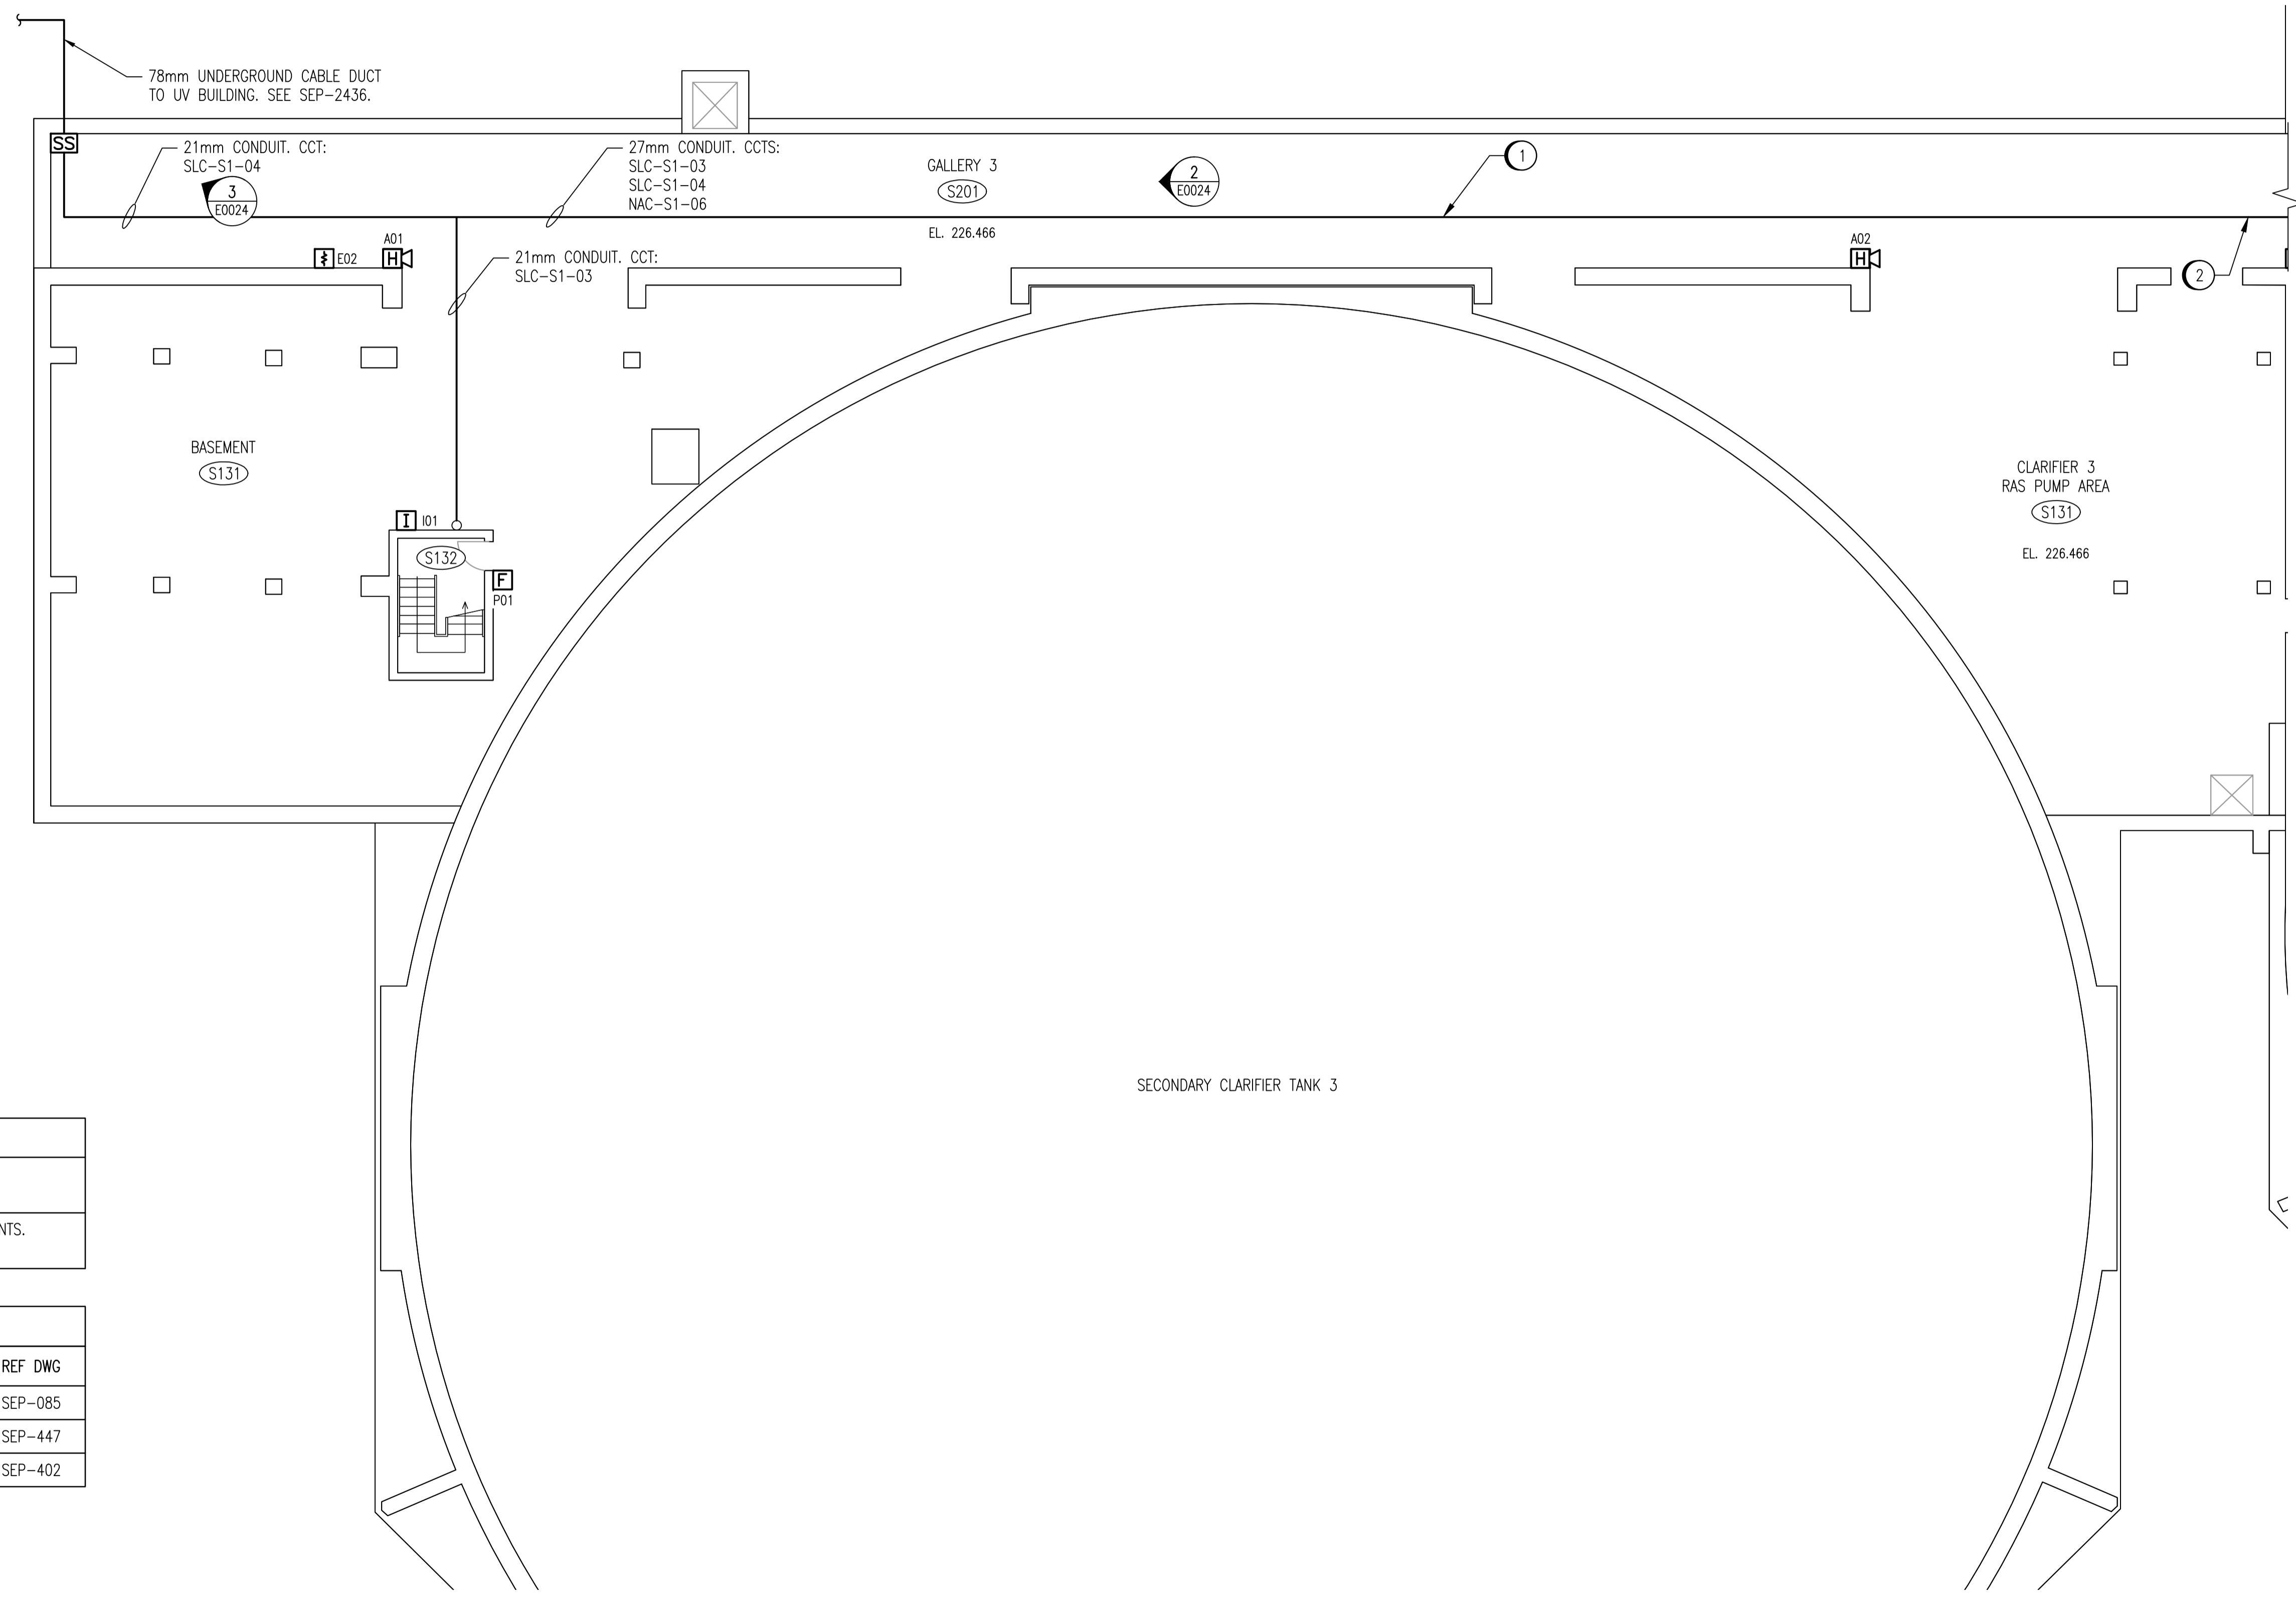


CONTINUED ON 1-0102S-E0006

CONSTRUCTION NOTES	
①	FASTEN ADJACENT TO EXISTING OVERHEAD CONDUIT SUPPORTS.
②	INSTALL CONDUIT EXPANSION JOINT AT LOCATION OF EXISTING JOINTS.

ROOM DETAILS			
ROOM ID	HEIGHT	CEILING TYPE	REF DWG
S119	11.38m	STAIRWELL	SEP-085
S201	3.20m	CONCRETE (GALLERY)	SEP-447
S132	11.48m	STAIRWELL	SEP-402

NOTES:
 1. DEVICE TAGS ARE SHOWN IN SHORTHAND NOTATION. FULL DEVICE TAG FORMAT IS FAS-Sxxx-yyy, WHERE xxx IS THE ROOM NUMBER, AND yyy IS THE DEVICE IDENTIFIER.



NO.	REVISIONS	DATE	DESIGN	CHECK
00	ISSUED FOR TENDER, BID OPP. 209-2011	2011/03/11	EFB	CJR

SNC-LAVALIN INC.
 148 Nature Park Way
 Winnipeg, MB, Canada R3P 0X7
 204-798-8080

DESIGNED BY: E. BOHNCKE
 CHECKED BY: C. REIMER
 DRAWN BY: E. BOHNCKE
 APPROVED BY: C. REIMER
 SCALE: 1:100
 RELEASED FOR CONSTRUCTION BY: N. HARRINGTON
 DATE: 2009/03/20
 DATE: 2011/03/11

CONSULTANT NO.: 112577-0101-47DD-0066

ENGINEER'S SEAL
 ORIGINAL DRAWING
 SEALED BY:
 C. J. REIMER
 SNC-LAVALIN
 MEMBER #21968
 2011/03/25
 REV. 00

THE CITY OF WINNIPEG
 WATER AND WASTE DEPARTMENT

SOUTH END WATER POLLUTION CONTROL CENTRE
 FIRE ALARM UPGRADE
 PLAN LAYOUT
 FIRE ALARM - SECONDARY CLARIFIERS
 CLARIFIER 3 LOWER LEVEL

CITY DRAWING NUMBER: 1-0102S-E0008
 SHEET: 001
 REV.: 00
 SIZE: A1

1-0102S-E0018	ELECTRICAL CLASSIFICATION PLAN
1-0102A-E0001	FIRE ALARM LEGEND AND DETAILS
DRAWING NUMBER	REFERENCE DRAWINGS