

FINISH SCHEDULE ABBREVIATIONS

G.B.	GYP-SUM BOARD	09 29 00	VSB	VINYL SHEET ROLLED BASE	09 65 00
P	PAINT	09 90 00	VCT	VINYL COMPOSITION TILE	09 65 00
			VS	VINYL SHEET	09 65 00

NOTES - FINISH SCHEDULE

N1 PROVIDE ROLLED SELF COVERED BASE
 N2 PROVIDE PAINT FINISH FOR PLASTER RETURNS TO NEW DOOR FRAMES ON ALL SIDES
 N3 PROVIDE SMOOTH SURFACE ON EXISTING BLOCK WALL FOR CT. MATCH ADJACENT LEVEL OF CT.
 N4 APPLY PLASTER FINISH OVER INT'L FEATHER OUT TO ADJACENT PLASTER SURFACES.
 N5 AFTER THE NEW CONC. BLOCK IS IN PLACE REPAINT ENTIRE WALL.

ROOM FINISH SCHEDULE

ROOM NO.	ROOM NAME	FLOOR	BASE	NORTH WALL	EAST WALL	SOUTH WALL	WEST WALL	REMARKS
100	EXISTING PUMP ROOM	TERRAZZO	-	PLAST	P	EXIST	P	N4
104	EXISTING WASTEWATER LAB	EXIST. VS	EXIST. VS	-	-	EX. PLASTER	CT	N3
107	LABORATORY	VS	ROLLED VS	CT	CT	CT	CT	N1, N2
113A	EXISTING CORRIDOR	EXIST. VT	ROLLED VS	EX.	-	-	-	N5

NOTES - DOOR SCHEDULE

N1 DOOR AND FRAME TYPE TO BE HOLLOW METAL (H.M.) WELDED.
 N2 HOLLOW METAL FRAMES UNLESS OTHERWISE NOTED ARE TO MATCH THE POSITION OF THE EXISTING DOOR FRAME LOCATION.
 N3 COORDINATE ELECTRICAL REQUIREMENTS TO DOOR FRAMES - SEE ELECTRICAL DRAWINGS
 N4 DOOR TO RECEIVE RELOCATED CARD ACCESS BY OWNER. GENERAL CONTRACTOR TO COORDINATE ROUGH-IN REQUIREMENTS WITH ELECTRICAL CONTRACTOR AND OWNER.

DOOR SCHEDULE

DOOR NO.	WIDTH	HEIGHT	DOOR				FRAME				FIRE RATING	HW. GROUP	REMARKS
			THICK	TYPE	FINISH	STYLE	PROT.	TYPE	FINISH	STYLE			
107.1	878mm/915mm	2150mm	45mm	H.M.	P	B & A	H.M.	P	1	45 MIN.	1	N1, N2, N3, N4	
107.2	273mm/916mm	2150mm	45mm	H.M.	P	B & A	H.M.	P	1	45 MIN.	2	N1, N2	

EQUIPMENT SCHEDULE ABBREVIATIONS

CM	CEILING MOUNT
IC	IN CONTRACT
OPF	OWNER FURNISHED PRODUCT
NIC	NOT IN CONTRACT

TYPICAL NOTES:


#1 INTERFACE INCLUDING STRUCTURAL SUPPORT, MECHANICAL, ELECTRICAL AND SERVICES ARE BY THE GENERAL CONTRACTOR.

REMARKS:


N1 ITEMS INDICATED ARE INSTALLED BY THE GENERAL CONTRACTOR.
 N2 ITEMS IN CONTRACT AND TO BE INSTALLED BY THE GENERAL CONTRACTOR.
 N3 ITEMS TO BE INSTALLED BY OWNER.

EQUIPMENT SCHEDULE


EQUIP. NO.	STATUS	SPEC SECTION	DESCRIPTION	QTY.	RELOC.	NEW	REMARKS
1	OPF		EXISTING INCUBATOR	3	X		N1
2	OPF		EXISTING BALANCE 1	1	X		N3
3	OPF		EXISTING LABEL PRINTER	1	X		N3
4	IC/UC		DISHWASHER	1		X	N2
5	OPF		WATER ANALYZER	1		X	N3
6	IC		FUME HOOD	1		X	N2
7	IC		EYEWASH/SHOWER DELUGE	1		X	N2
8	OPF		TABLE	1	X		N3
9	NIC		CHAIR	4			
10	OPF		WATER SUPPLY HOLDING TANK FOR THE WATER ANALYZER	1		X	N3
11	NIC		SHELF	3			
12	NIC		TACK BOARD	3			

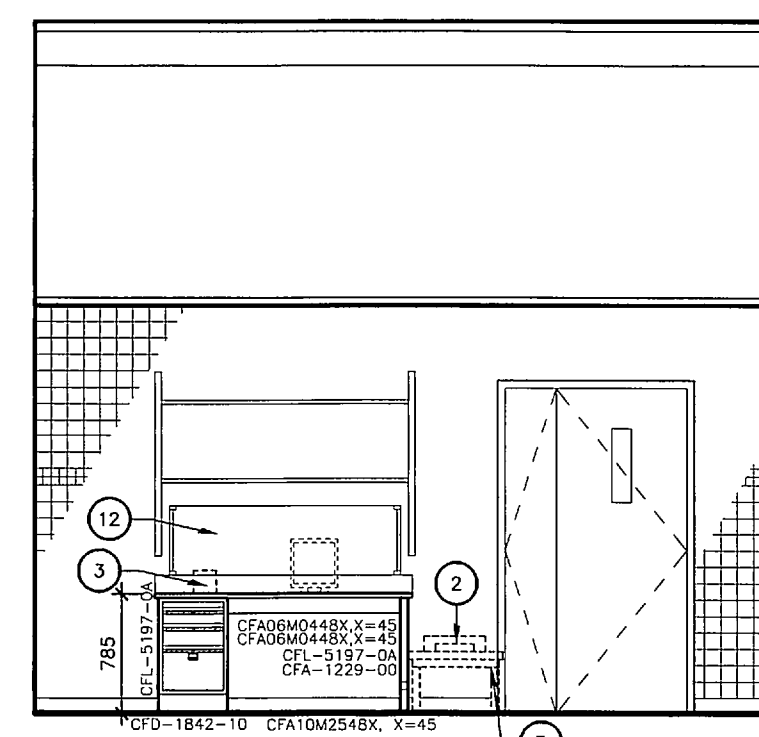


LABORATORY - 107
SCALE 1:50

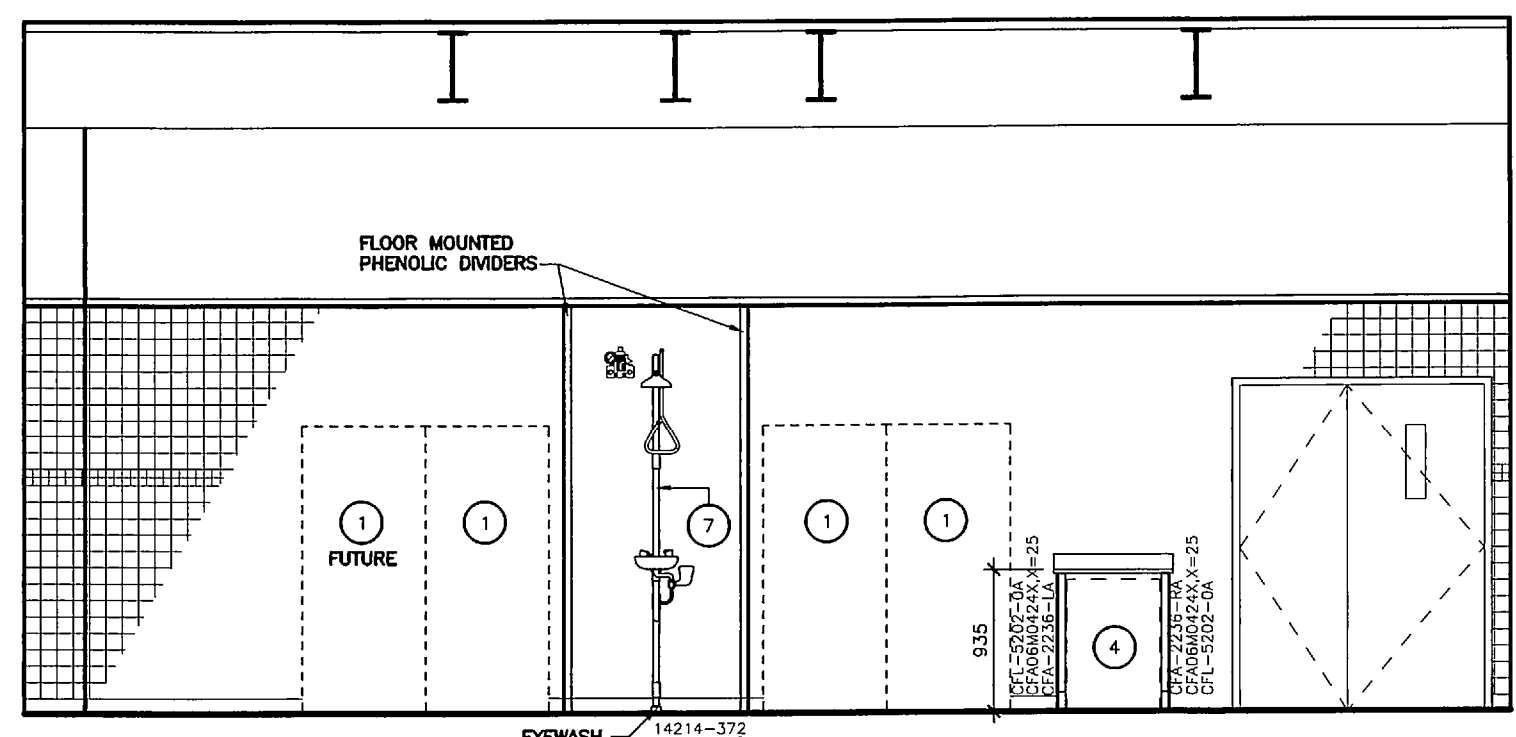


LABORATORY - 107
SCALE 1:50

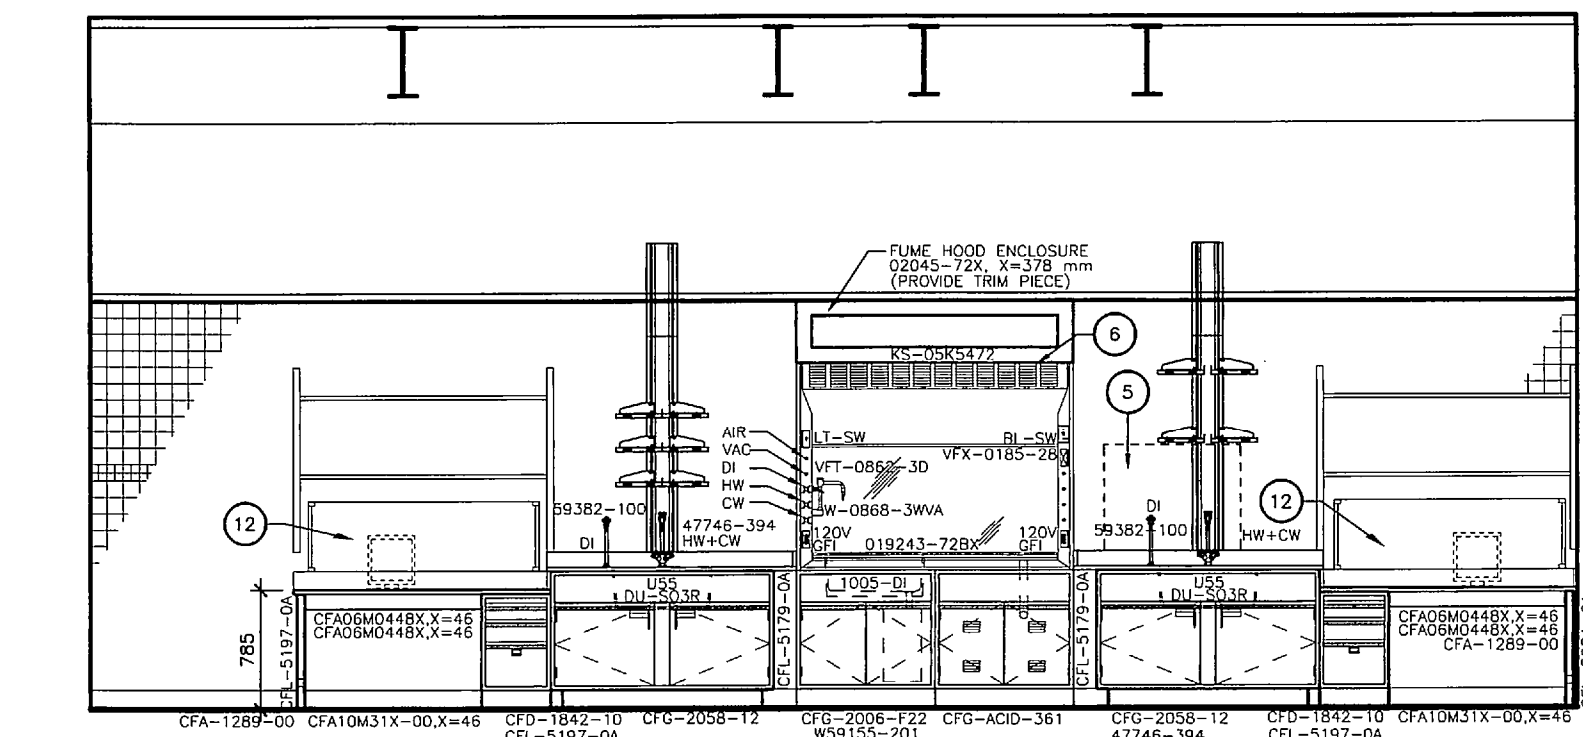


LABORATORY - 107
SCALE 1:50

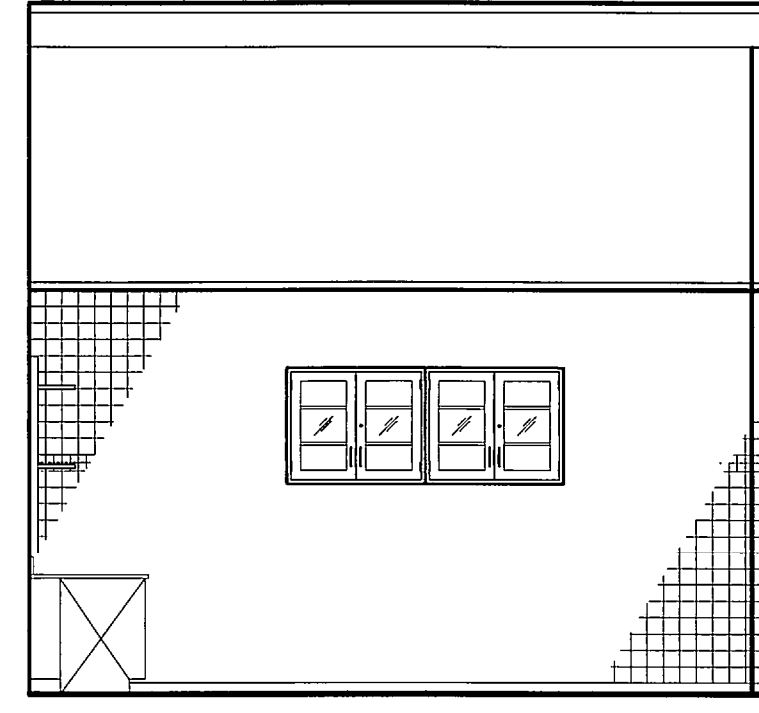


LABORATORY - 107
SCALE 1:50

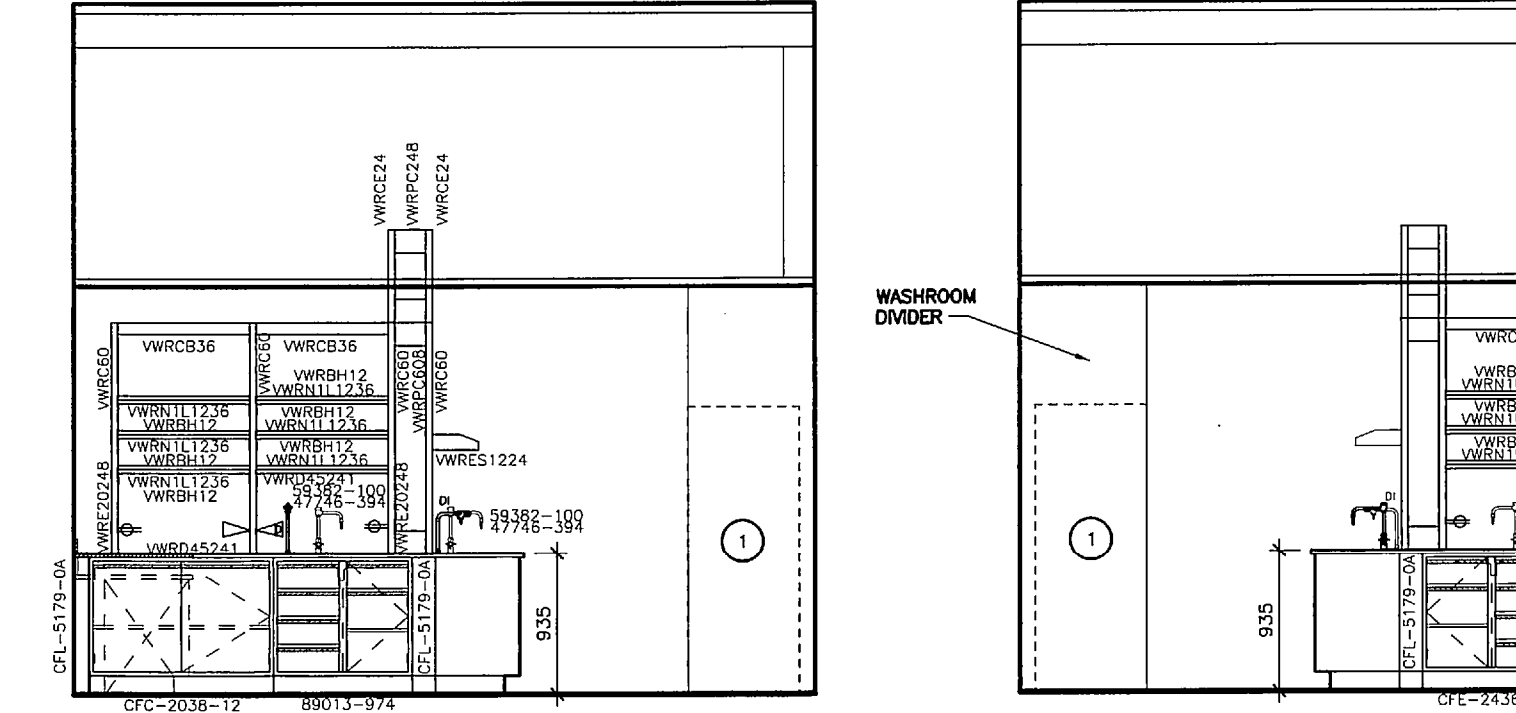


LABORATORY - 107
SCALE 1:50

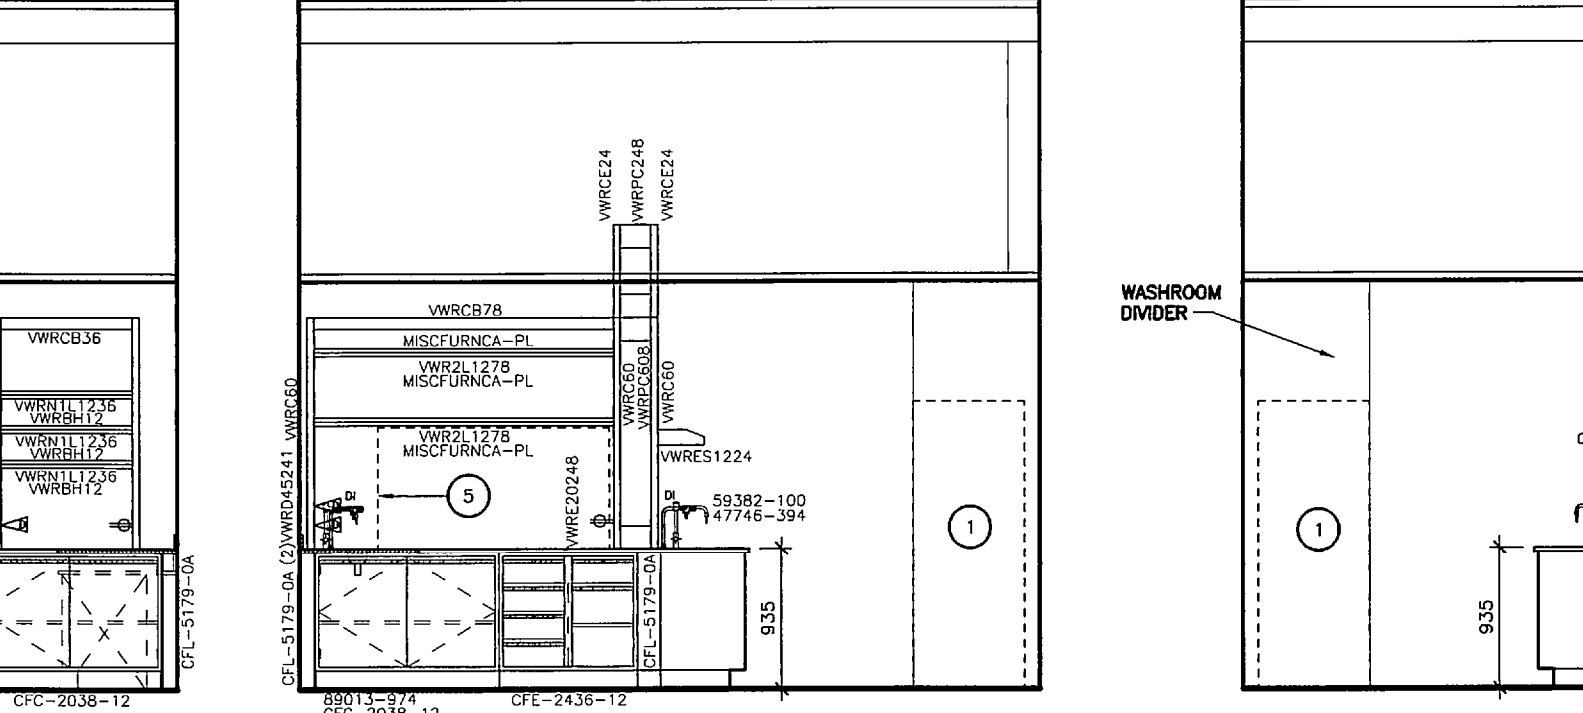


LABORATORY - 107
SCALE 1:50

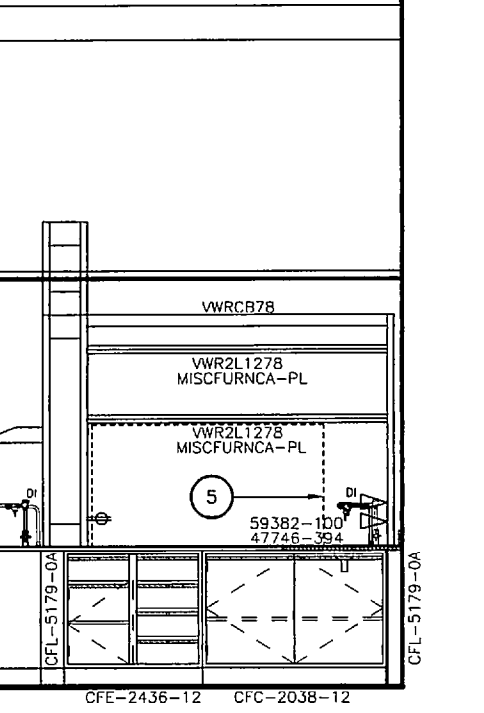


LABORATORY - 107
SCALE 1:50

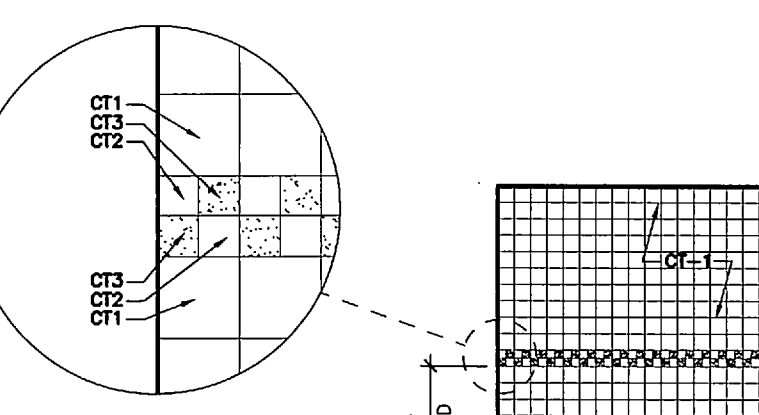


CERAMIC TILE LAYOUT - TYP.
SCALE 1:50

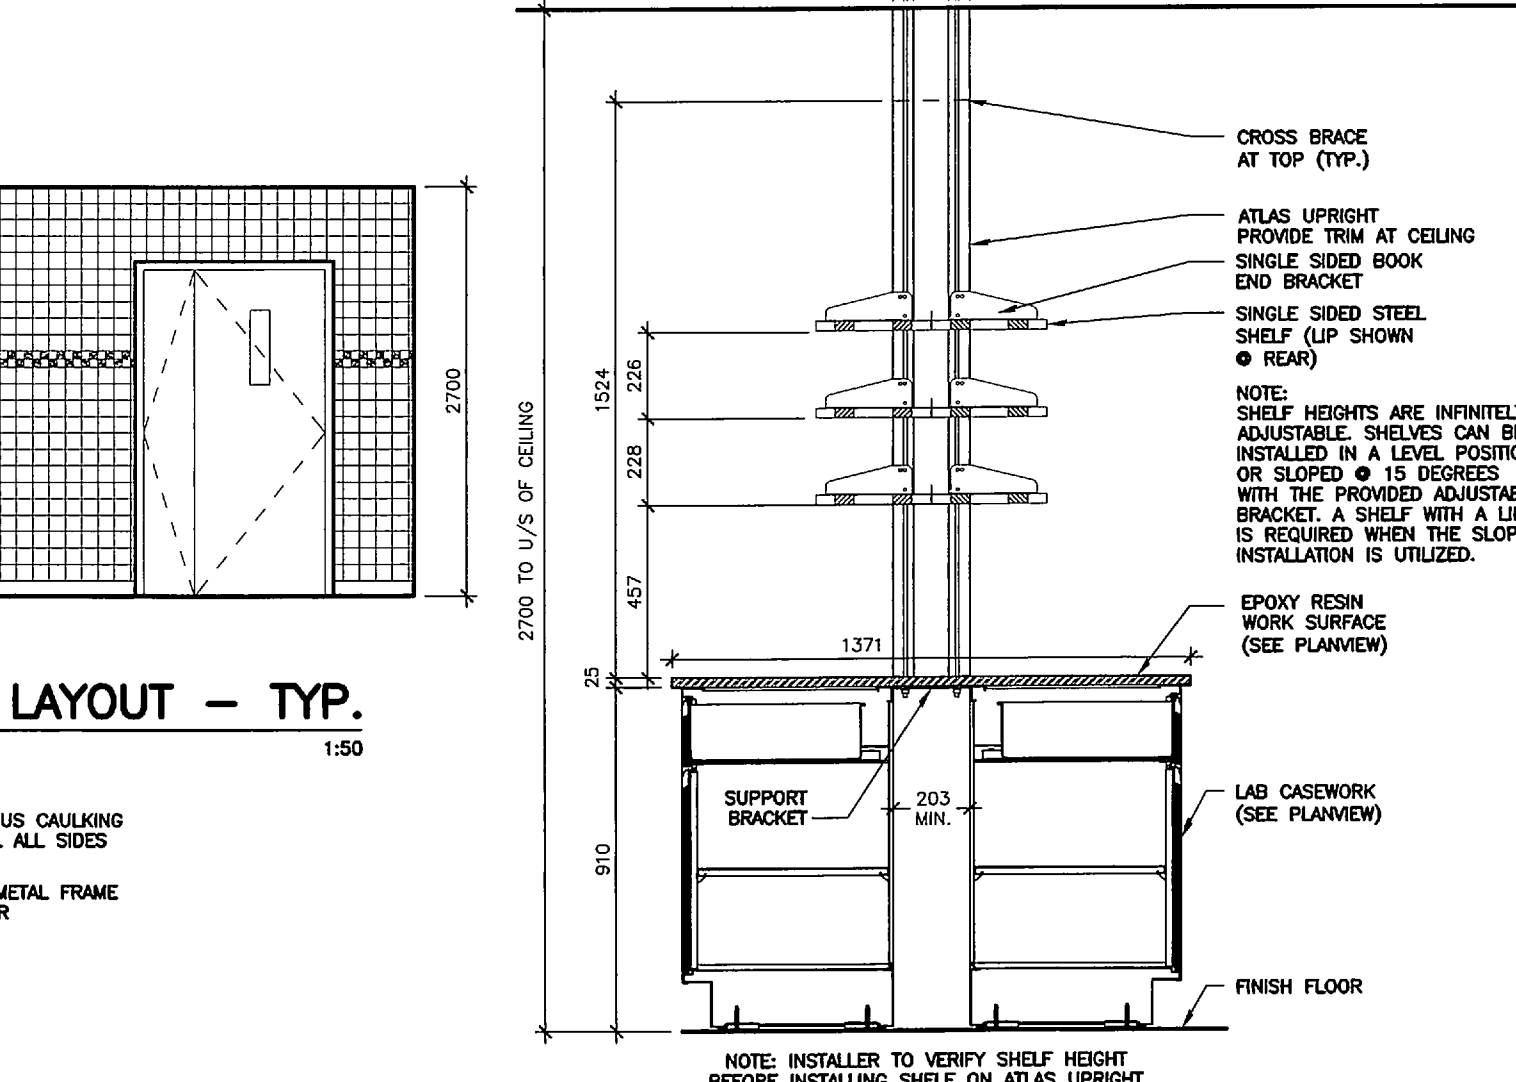


COUNTER MOUNTED ATLAS SECTION
SCALE 1:20

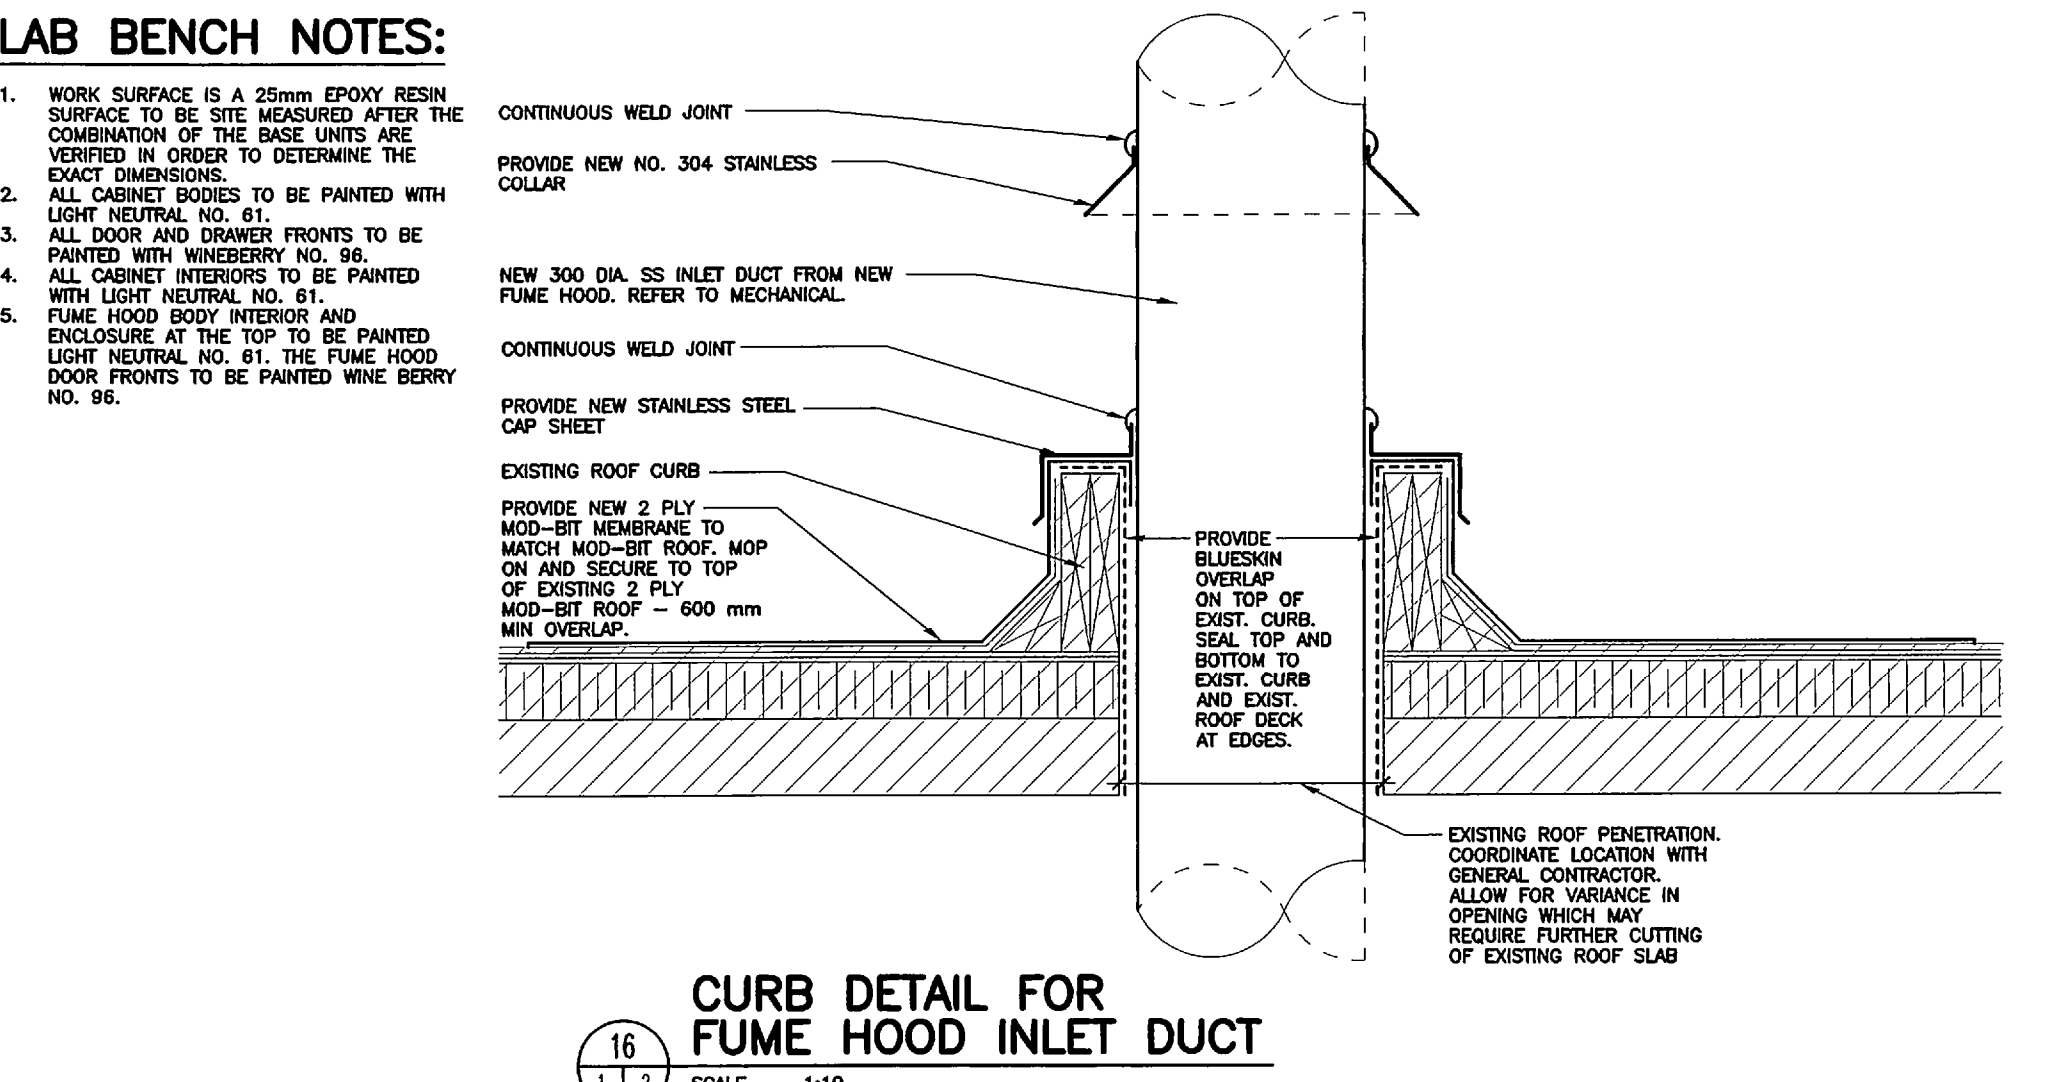


CURB DETAIL FOR FUME HOOD INLET DUCT
SCALE 1:10

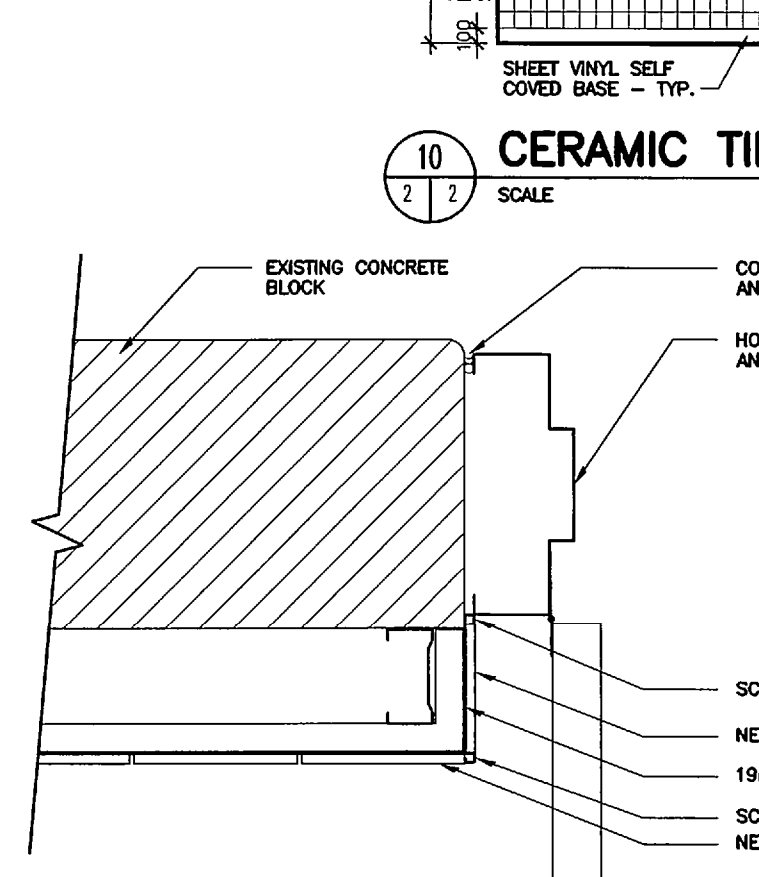


ENLARGED WALL DETAIL
SCALE 1:5

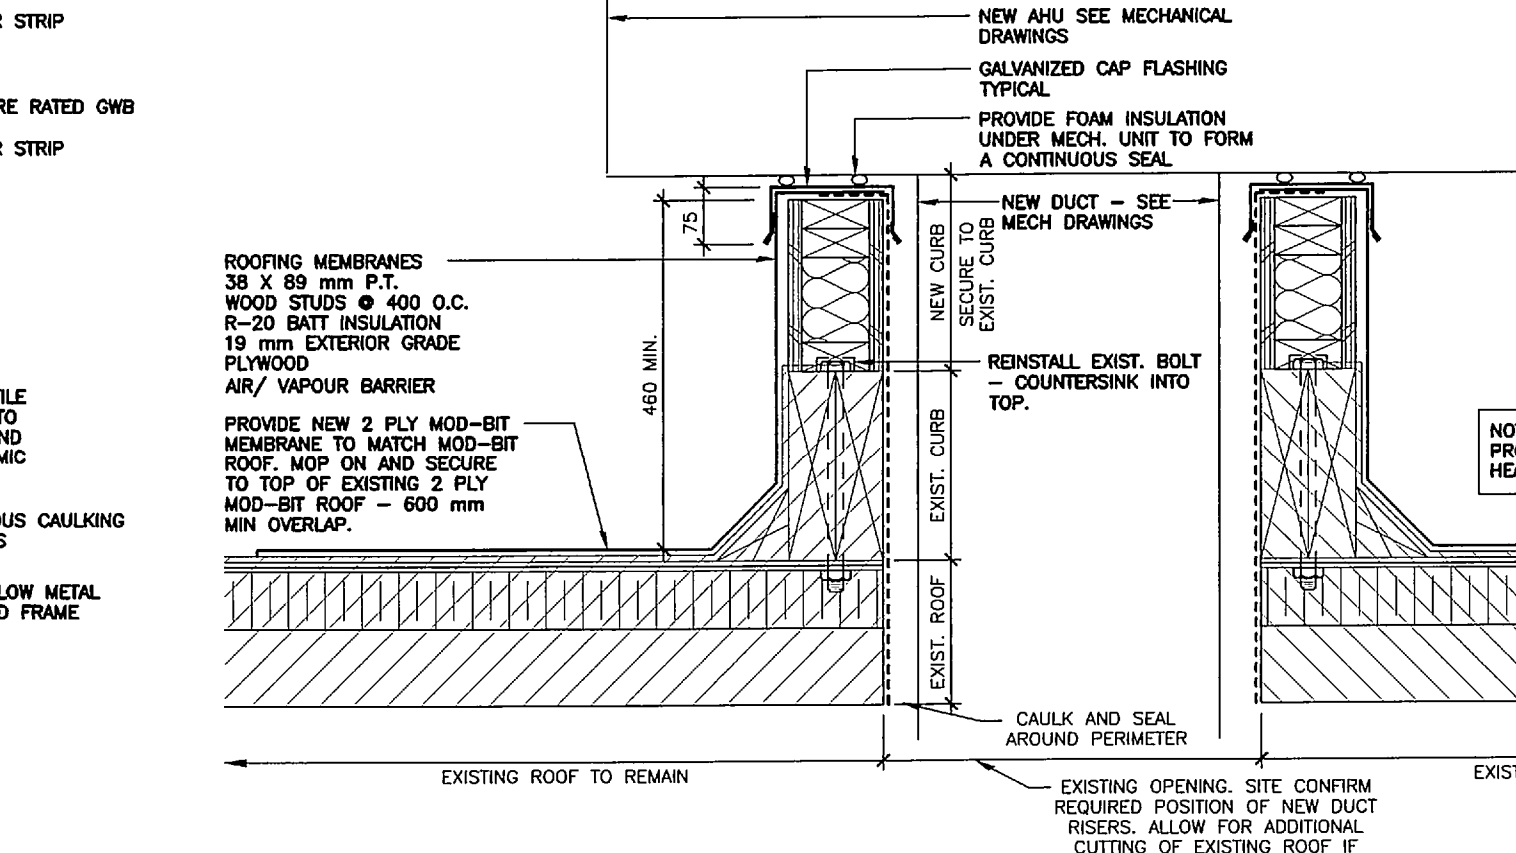

MECH. CURB DETAIL
SCALE 1:10

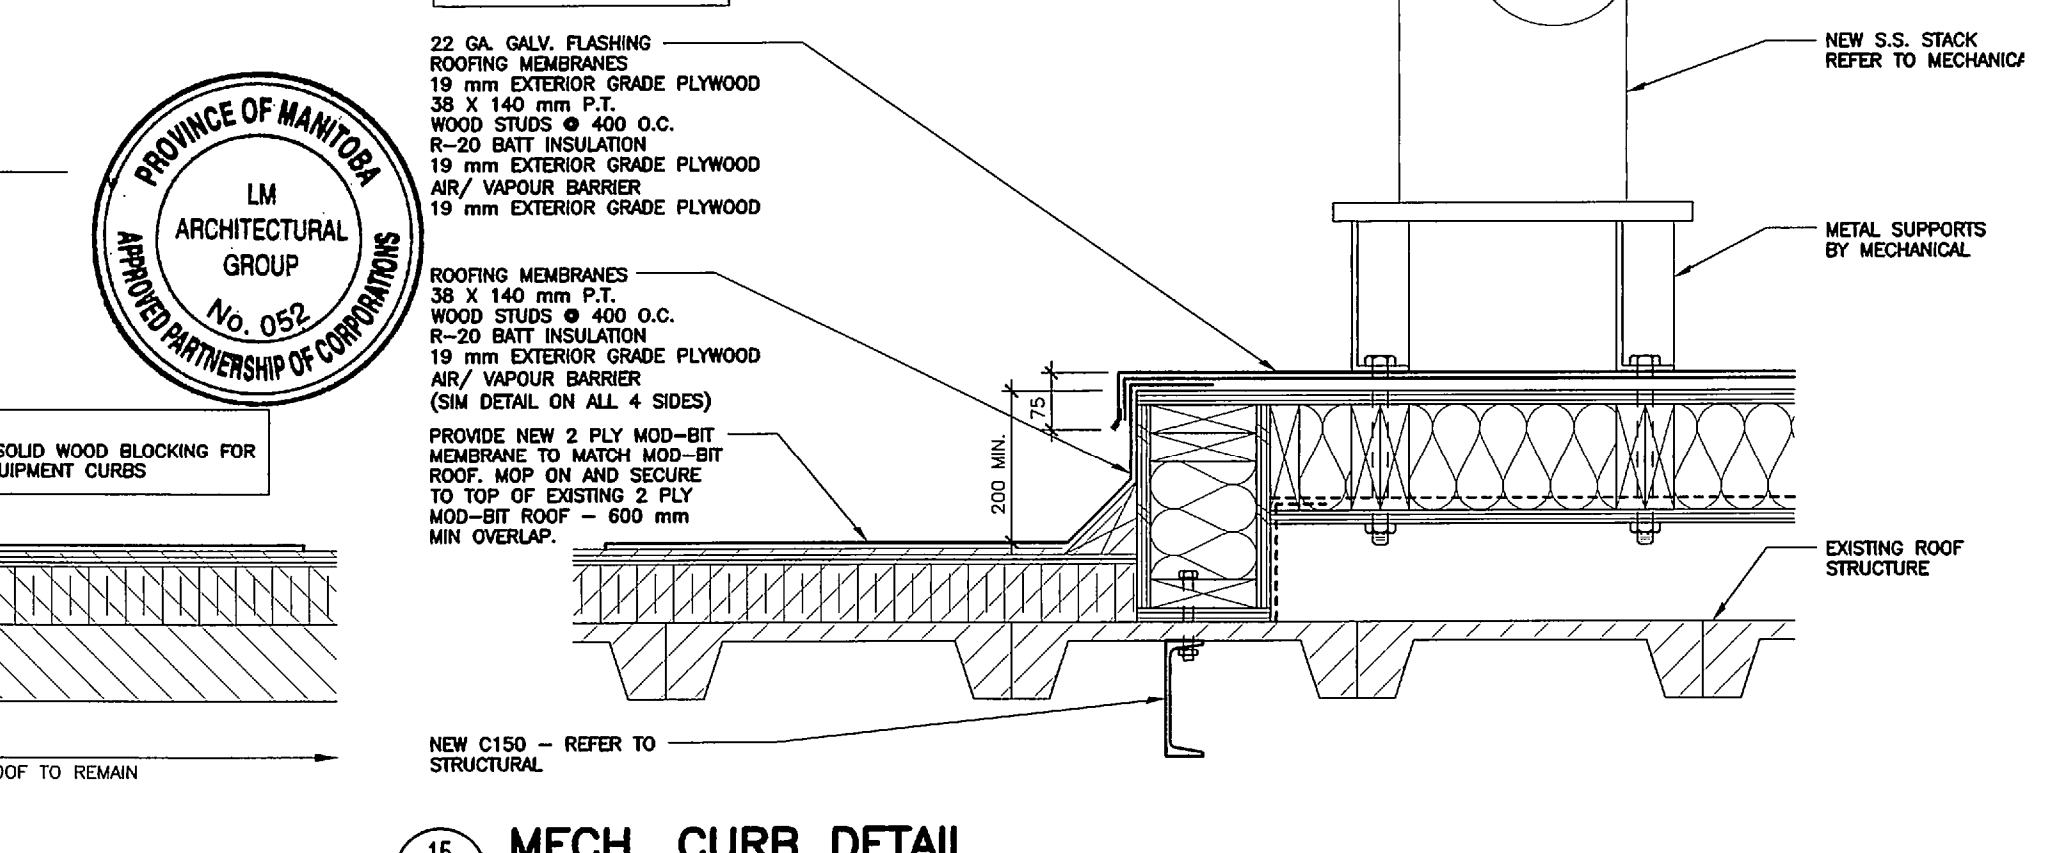

MECH. CURB DETAIL
SCALE 1:10

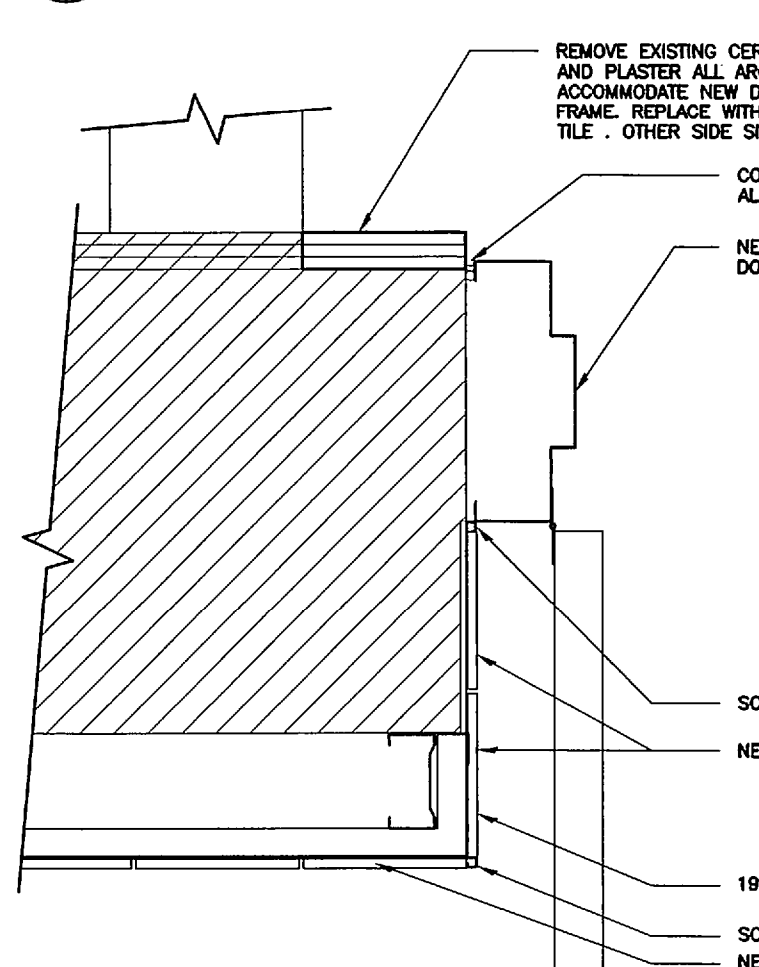

ENLARGED WALL DETAIL
SCALE 1:5

B.M. ELEV.	FIELD BOOK #:	LM Architectural Group 500-136 Market Ave Winnipeg Manitoba Canada R3B 0P4 t: (204) 942.0681 f: (204) 943.8676 www.lm-architects.com	SEAL PROVINCE OF MANITOBA TERRY W. DANIELLEY REGISTERED ARCHITECT Aug 30/11	THE CITY OF WINNIPEG WATER AND WASTE DEPARTMENT NORTH END WATER POLLUTION CONTROL CENTRE - LAB RENOVATIONS LARGE SCALE PLAN/ INTERIOR ELEVATIONS/ MISCELLANEOUS DETAILS	SHEET 3 OF 3 CITY DRAWING NUMBER 1-0101M-80003-001-01
POSTED TO LBIS	DESIGNED BY	CHECKED BY	CONSULTANT DRAWING NO. A2		
	DRAWN BY JM	APPROVED BY			
2 ISSUED FOR FINAL REVIEW	30/08/11	JM	HOR. SCALE	RELEASED FOR CONSTRUCTION	
1 ISSUED FOR REVIEW	06/06/11	JM	VERTICAL		
NO. REVISIONS	DATE	BY	DATE	DATE	