


105 TECUMSEH P.D. 86-149
 FUEL STATION M-1
 MECHANICAL

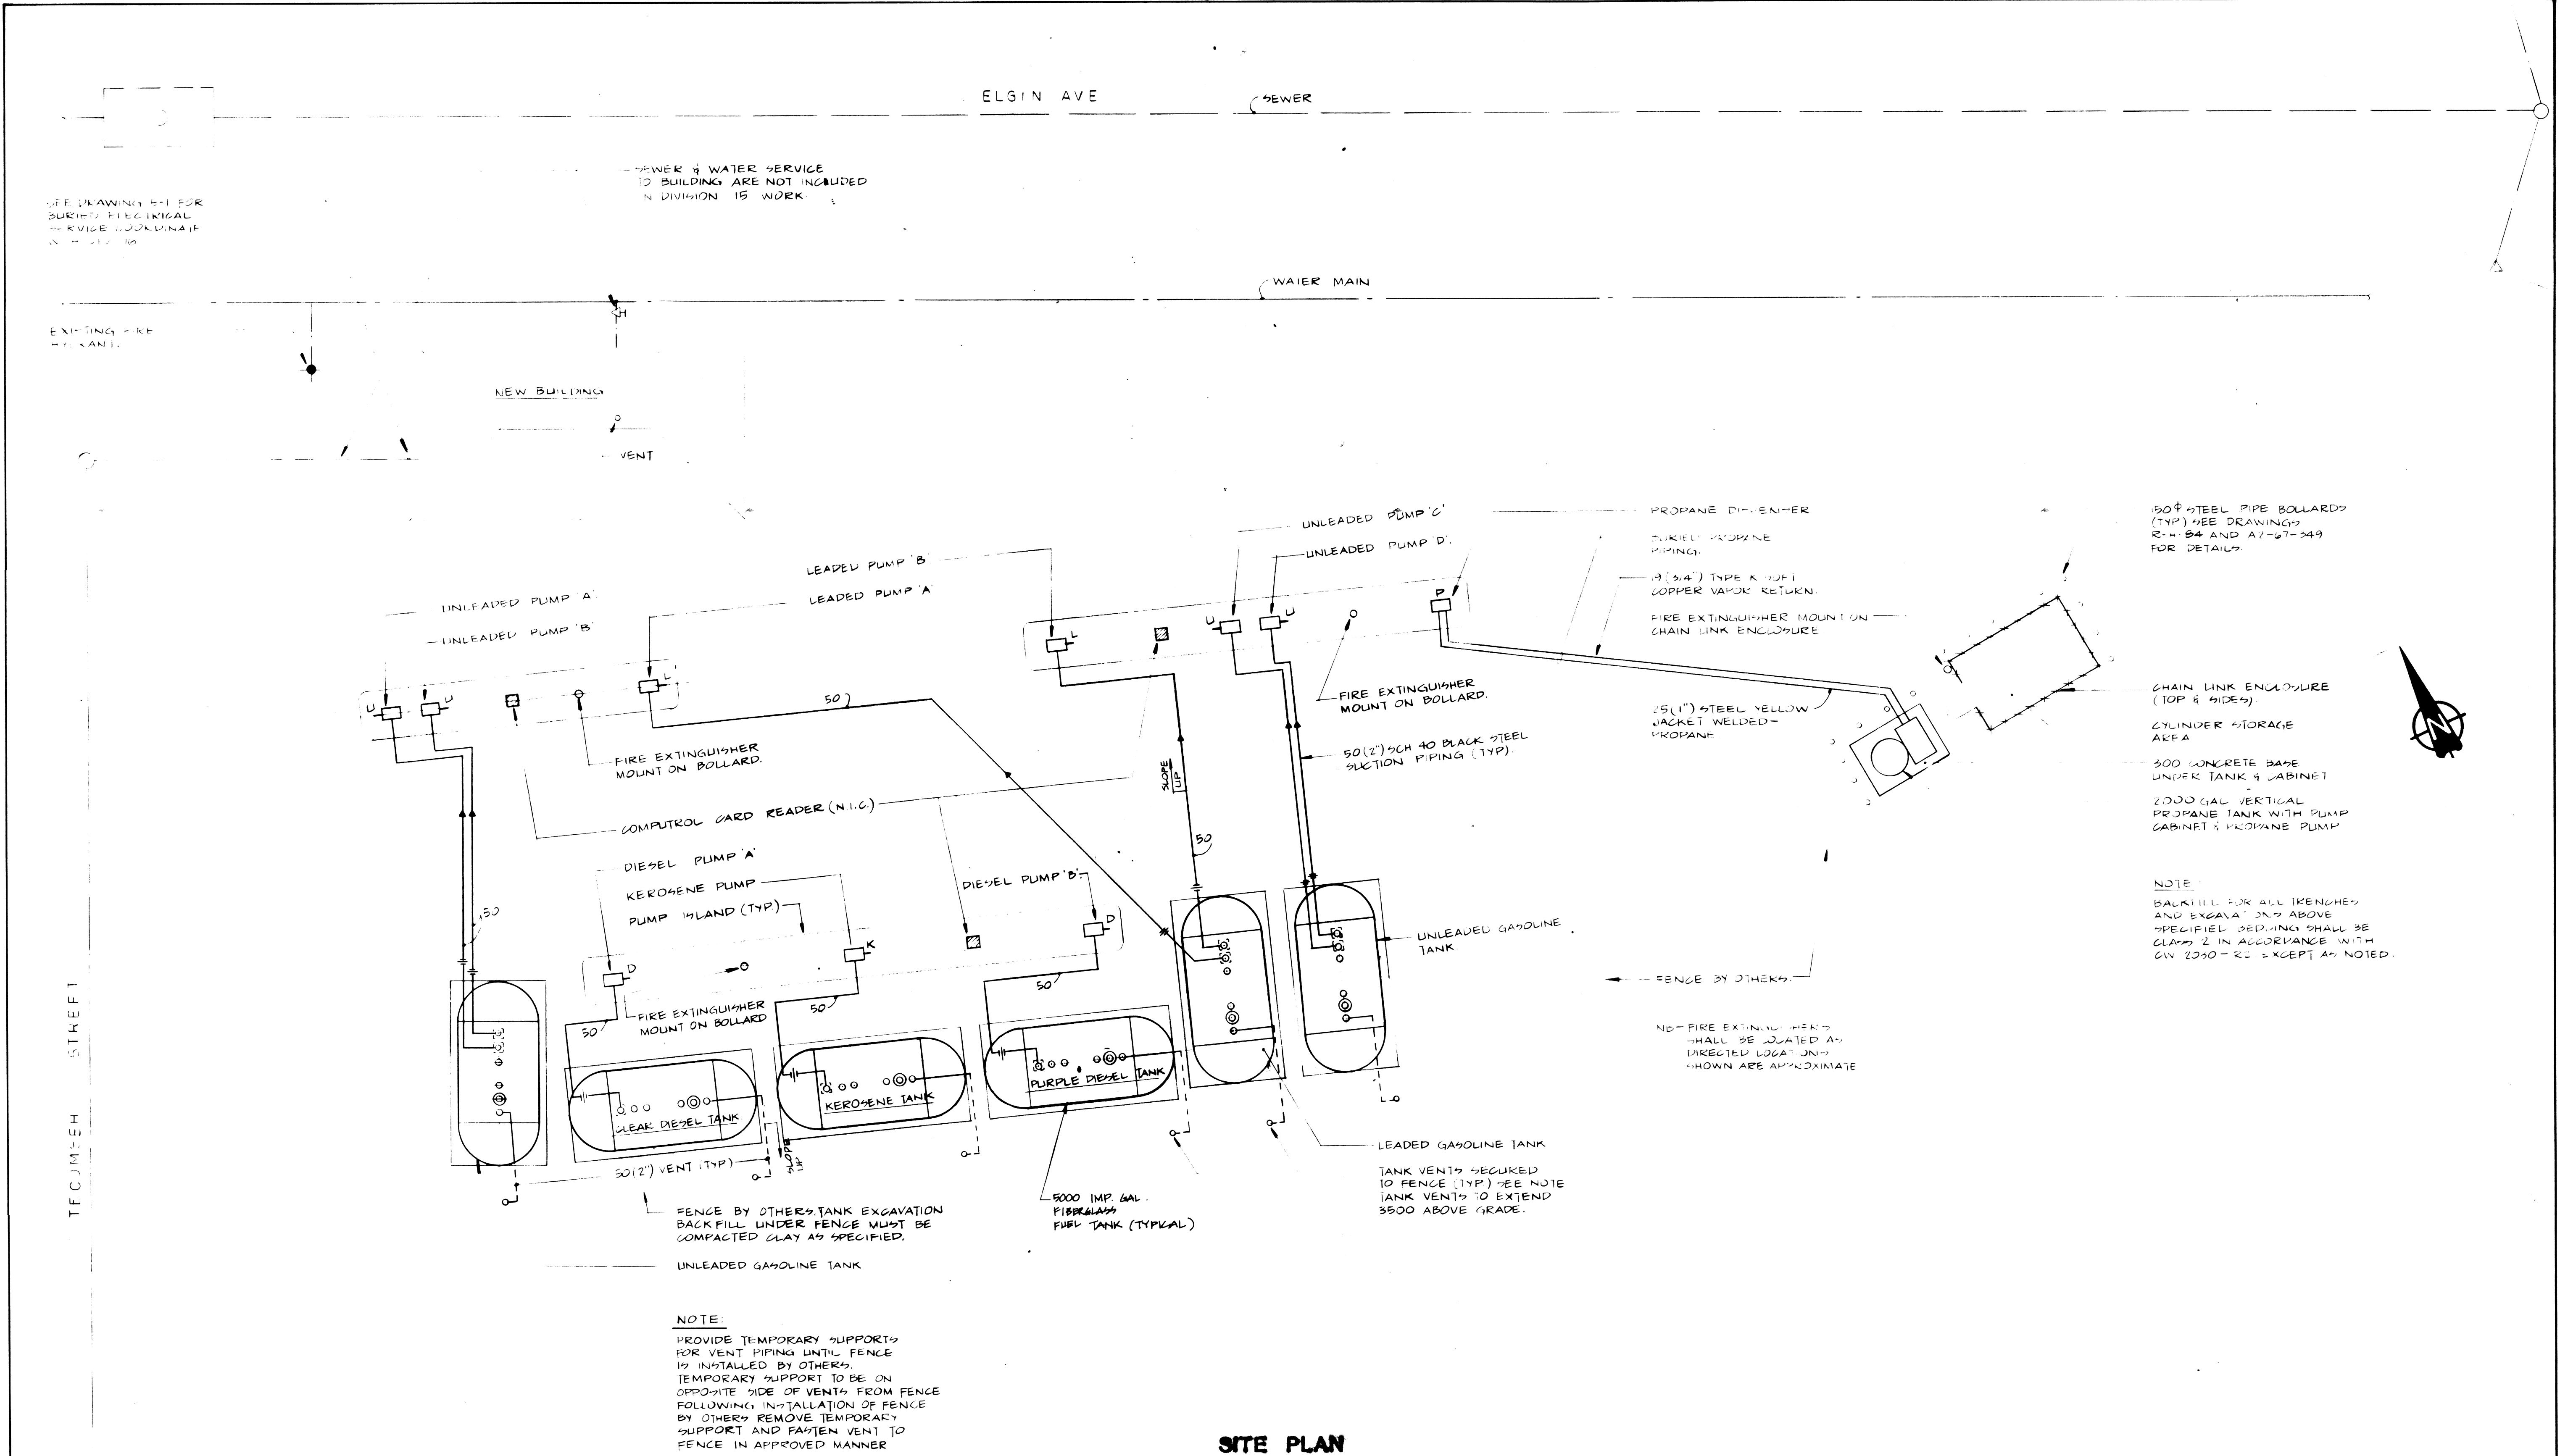

NOTE:
 PROVIDE TEMPORARY SUPPORTS FOR VENT PIPING UNTIL FENCE IS INSTALLED BY OTHERS. TEMPORARY SUPPORT TO BE ON OPPOSITE SIDE OF VENTS FROM FENCE FOLLOWING INSTALLATION OF FENCE BY OTHERS REMOVE TEMPORARY SUPPORT AND FASTEN VENT TO FENCE IN APPROVED MANNER

150# STEEL PIPE BOLLARDS (TYP) SEE DRAWINGS R-1-84 AND A2-67-349 FOR DETAILS.
 CHAIN LINK ENCLOSURE (TOP & SIDES)
 CYLINDER STORAGE AREA
 500 CONCRETE BASE UNDER TANK & CABINET
 2000 GAL VERTICAL PROPANE TANK WITH PUMP CABINET & PROPANE PUMP

NOTE:
 BACKFILL FOR ALL TRENCHES AND EXCAVATIONS ABOVE SPECIFIED BEDDING SHALL BE CLASS 2 IN ACCORDANCE WITH GW 2040-R-2 EXCEPT AS NOTED.

SITE PLAN
 SCALE 1:100

REVISED AS CONSTRUCTED
 DATE 07/2/86 BY PRAIRIE, S.W.
 CHECKED BY B

85-063-04
Scouten Mitchell Sigurdson
 Consulting Engineers
 Scouten Mitchell Sigurdson and Associates Limited
 770 Bradford Street, Winnipeg, Manitoba R3M 0N5 Telephone (204) 775-0291

EXISTING	LEGEND	PROPOSED	EXISTING	LEGEND	PROPOSED

RELEASED FOR CONSTRUCTION

DIRECTOR OF CIVIC PROPERTIES _____


DIRECTOR OF OPERATIONS _____

BENCH MARK: SEE DRAWING A2-67-349

NO.	REVISIONS	DATE	BY
1	ADDED TANK CAPACITY	12/9/86	B.P.E.
2	FIBERGLASS TANKS	10/8/86	K.W.
3	REVISE FOR PD 86-149	25/4/86	K.W.

IDE
 INTERDISCIPLINARY ENGINEERING COMPANY
 PROFESSIONAL ENGINEERS
 WINNIPEG MANITOBA

DESIGNED BY K.W.
 DRAWN BY M.D.
 SCALE: 1:100
 CHECKED BY K.W.
 DATE AUG. 1986
 APPROVED BY [Signature]
 DATE 21/8/86

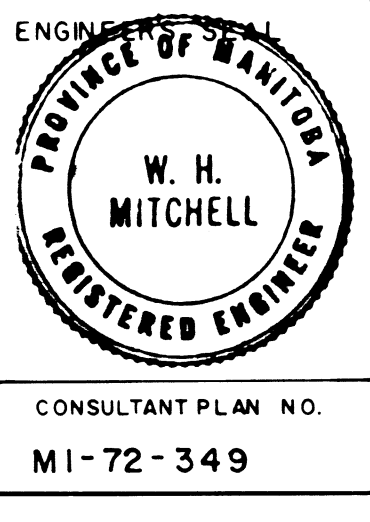

THE CITY OF WINNIPEG
 CIVIC PROPERTIES DEPARTMENT

CENTRAL YARD REORGANIZATION PROJECT

FUEL STATION MECHANICAL

FIELD BOOK

PLAN NO. **M-1R**