
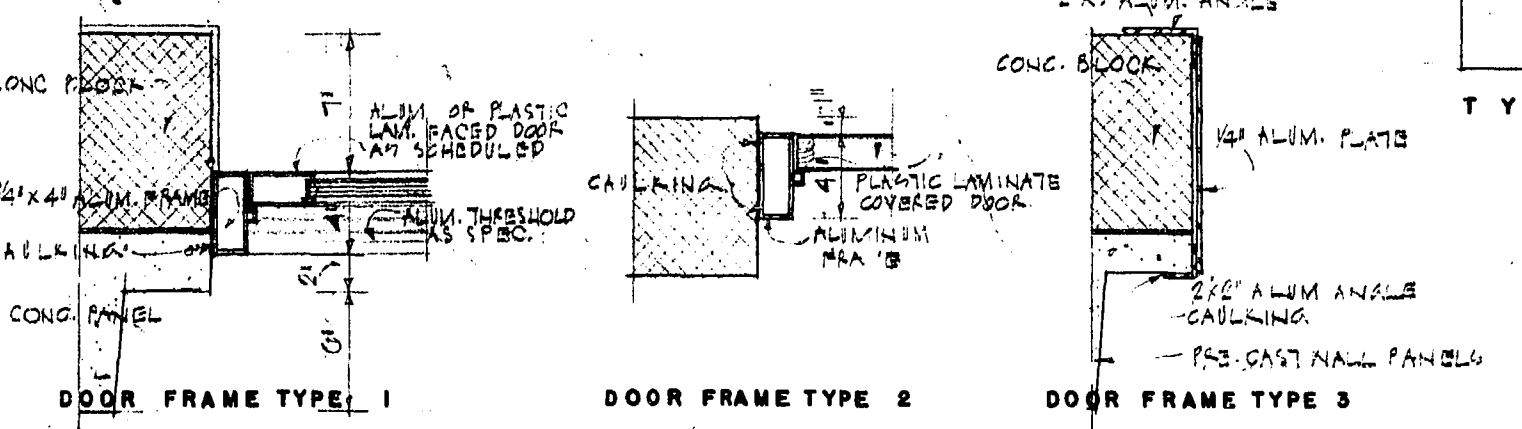


PLAN OF LOWER LEVEL

DOOR SCHEDULE

NO.	WIDTH	HIGHTH	TYPE	FRAME	HARDWARE	REMARKS
01	2'-0"	7'-0"	A	2	1	10X10 LOUVES
02	2'-0"	7'-0"	B	2	2	10X10 LOUVES
1	3'-0"	7'-4"	A	1	3	
2	3'-0"	7'-4"	B	1	4	
3	3'-0"	7'-0"	B	1	4	
4	3'-0"	7'-0"	B	2	2	
5	3'-0"	11'-0"	C	1	5	AS SPECIFIED
6	10'-0"	10'-0"	VERTICAL LIFT ALUM.			ADDITIONAL DOORS
7	10'-0"	10'-0"				AS SPECIFIED C

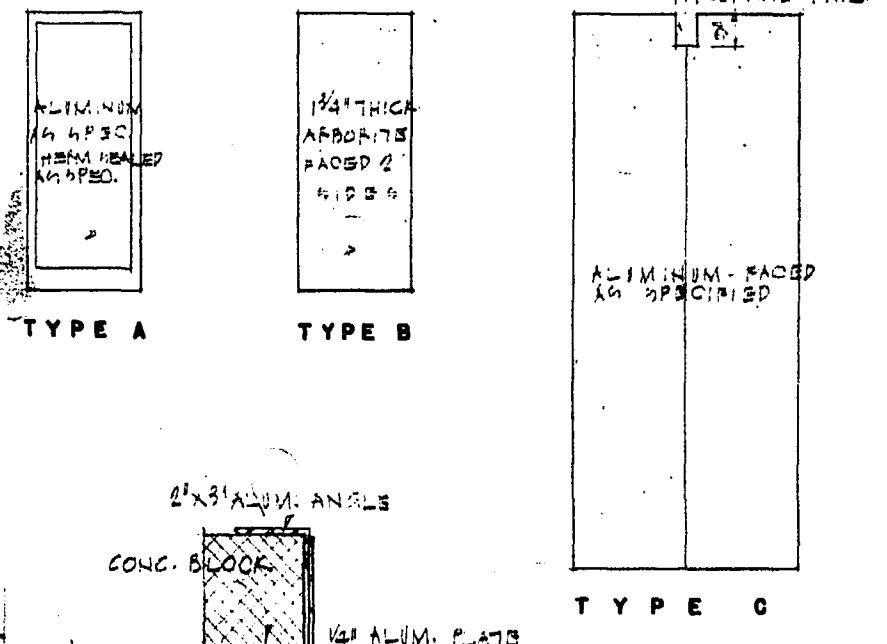

NO.	REF.	DESCRIPTION	DATE	CHKD.
1	GEN.	GENERATOR BASE	25.11.57	

REVISIONS (READ UP)

DRAWN BY: B. T.
 CHECKED BY: [Signature]
 APPROVED BY: [Signature]
 DATE: NOV. 10, 1959
 CITY FILE NO.: WH5622-3

SMITH CARTER SEARLE ASSOCIATES
 ARCHITECTS AND ENGINEERS
 WINNIPEG AND BRANDON
 CITY OF WINNIPEG
 WILKES AVE. PUMPING STATION
 WINNIPEG, MANITOBA
 SHEET TITLE: FLOOR PLANS & SCHEDULES
 SCALE: 1/8" = 1'-0"
 FILE NUMBER: 59151
 SHEET NUMBER: 3