



PLAN - EL. 231.22

SCALE: 1:40

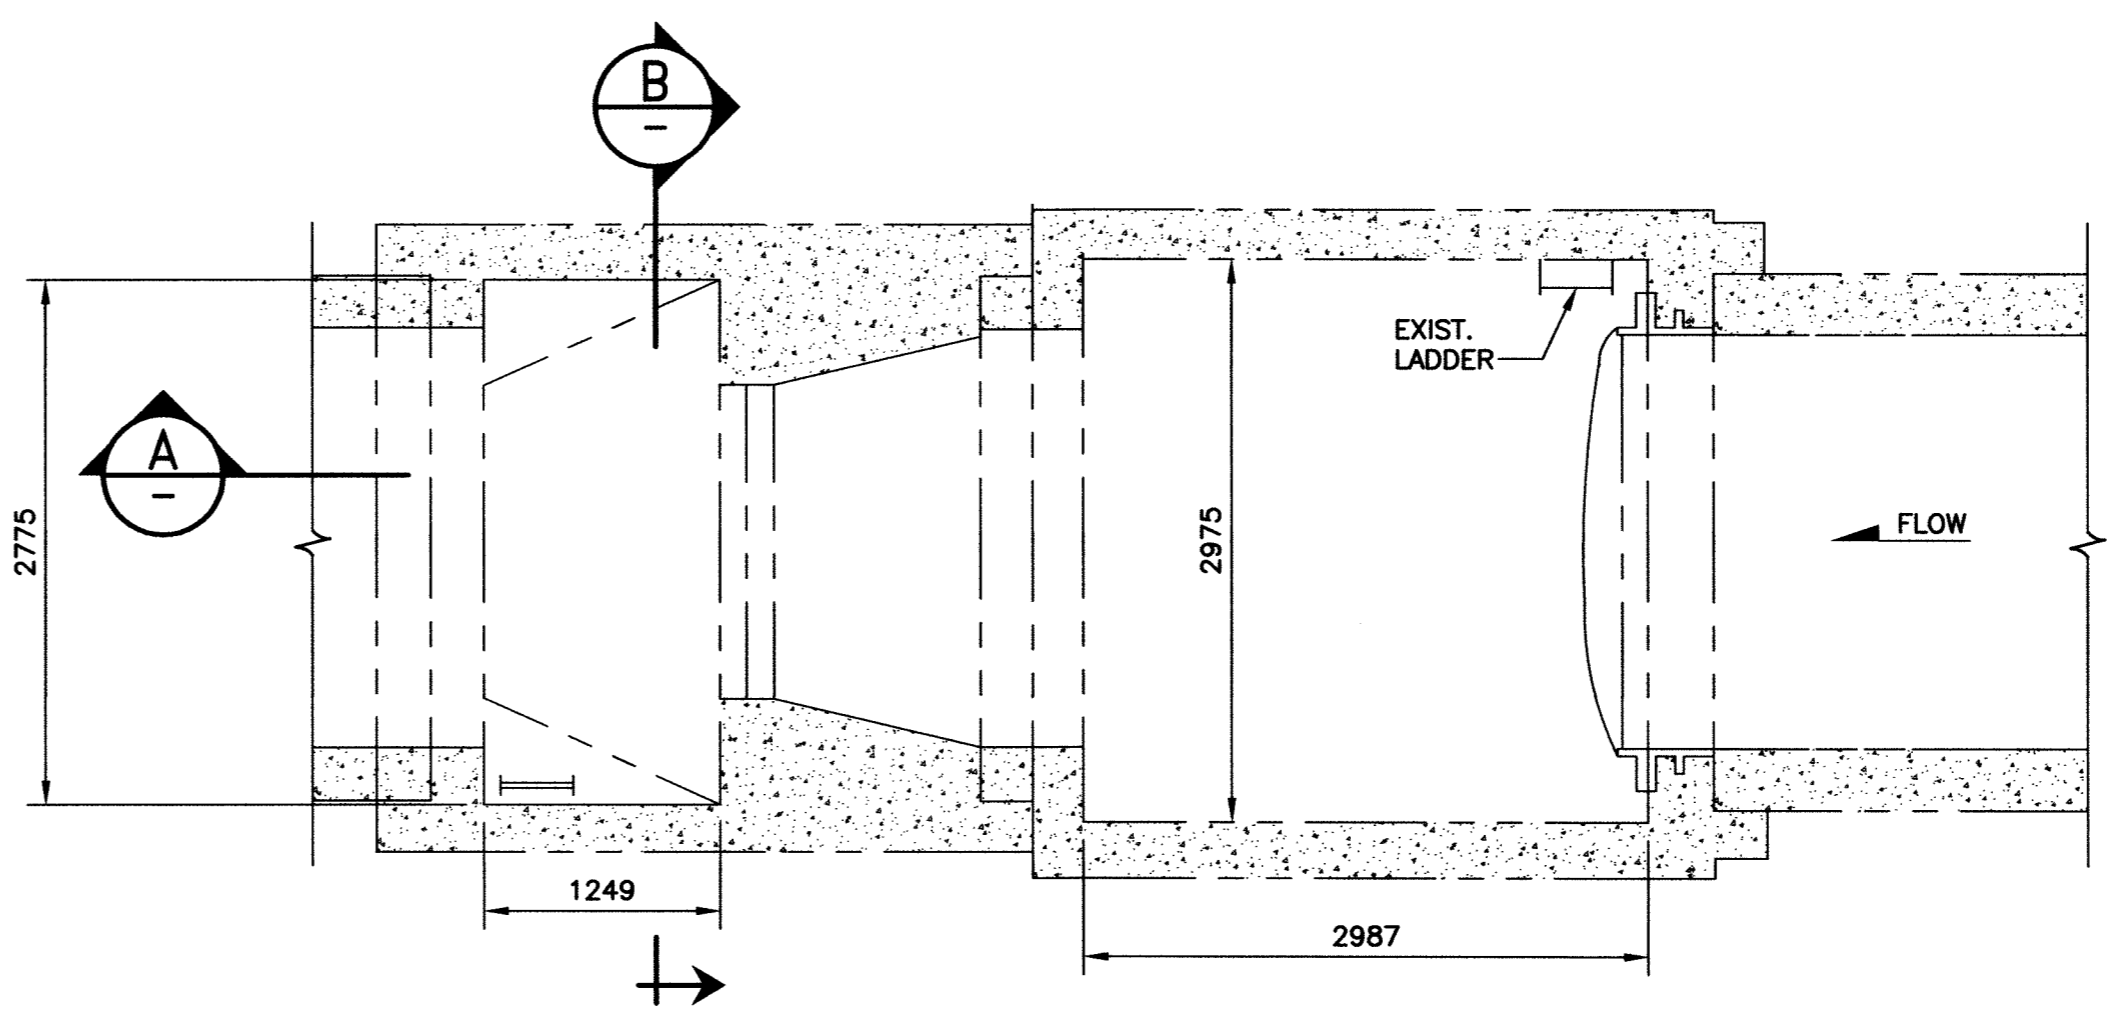


PLAN - EL. 223.26


SCALE: 1:40

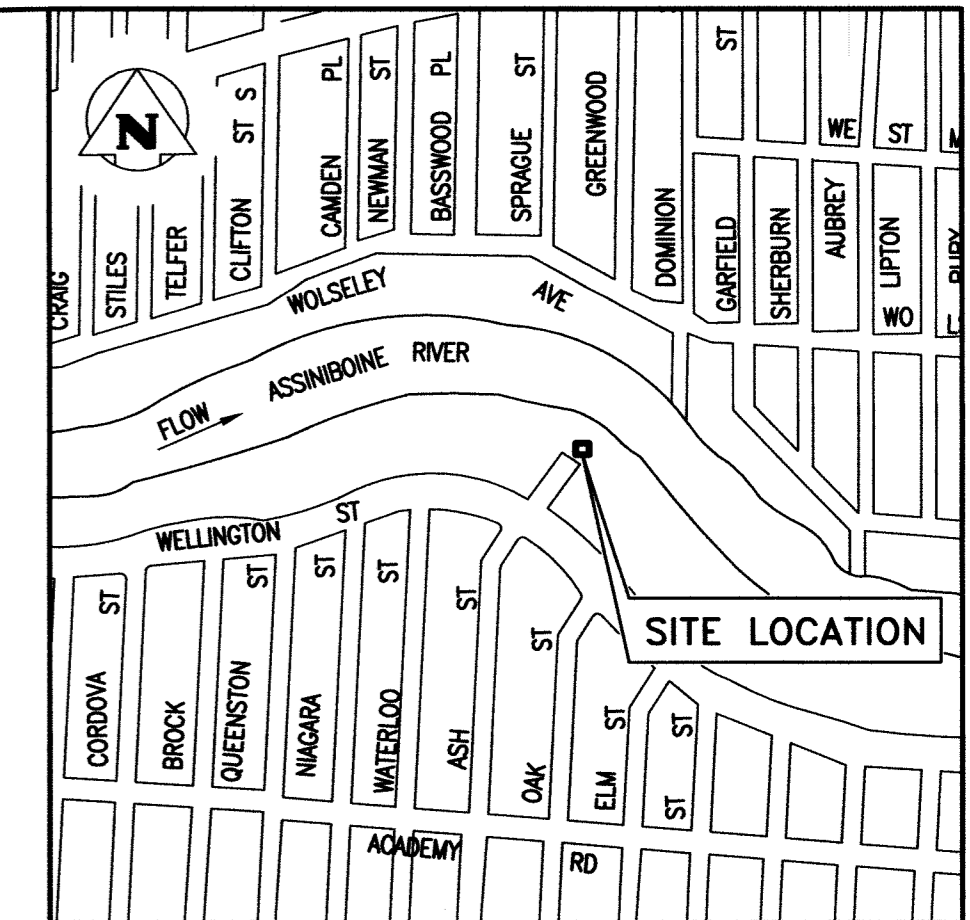


SITE PLAN
N.T.S.

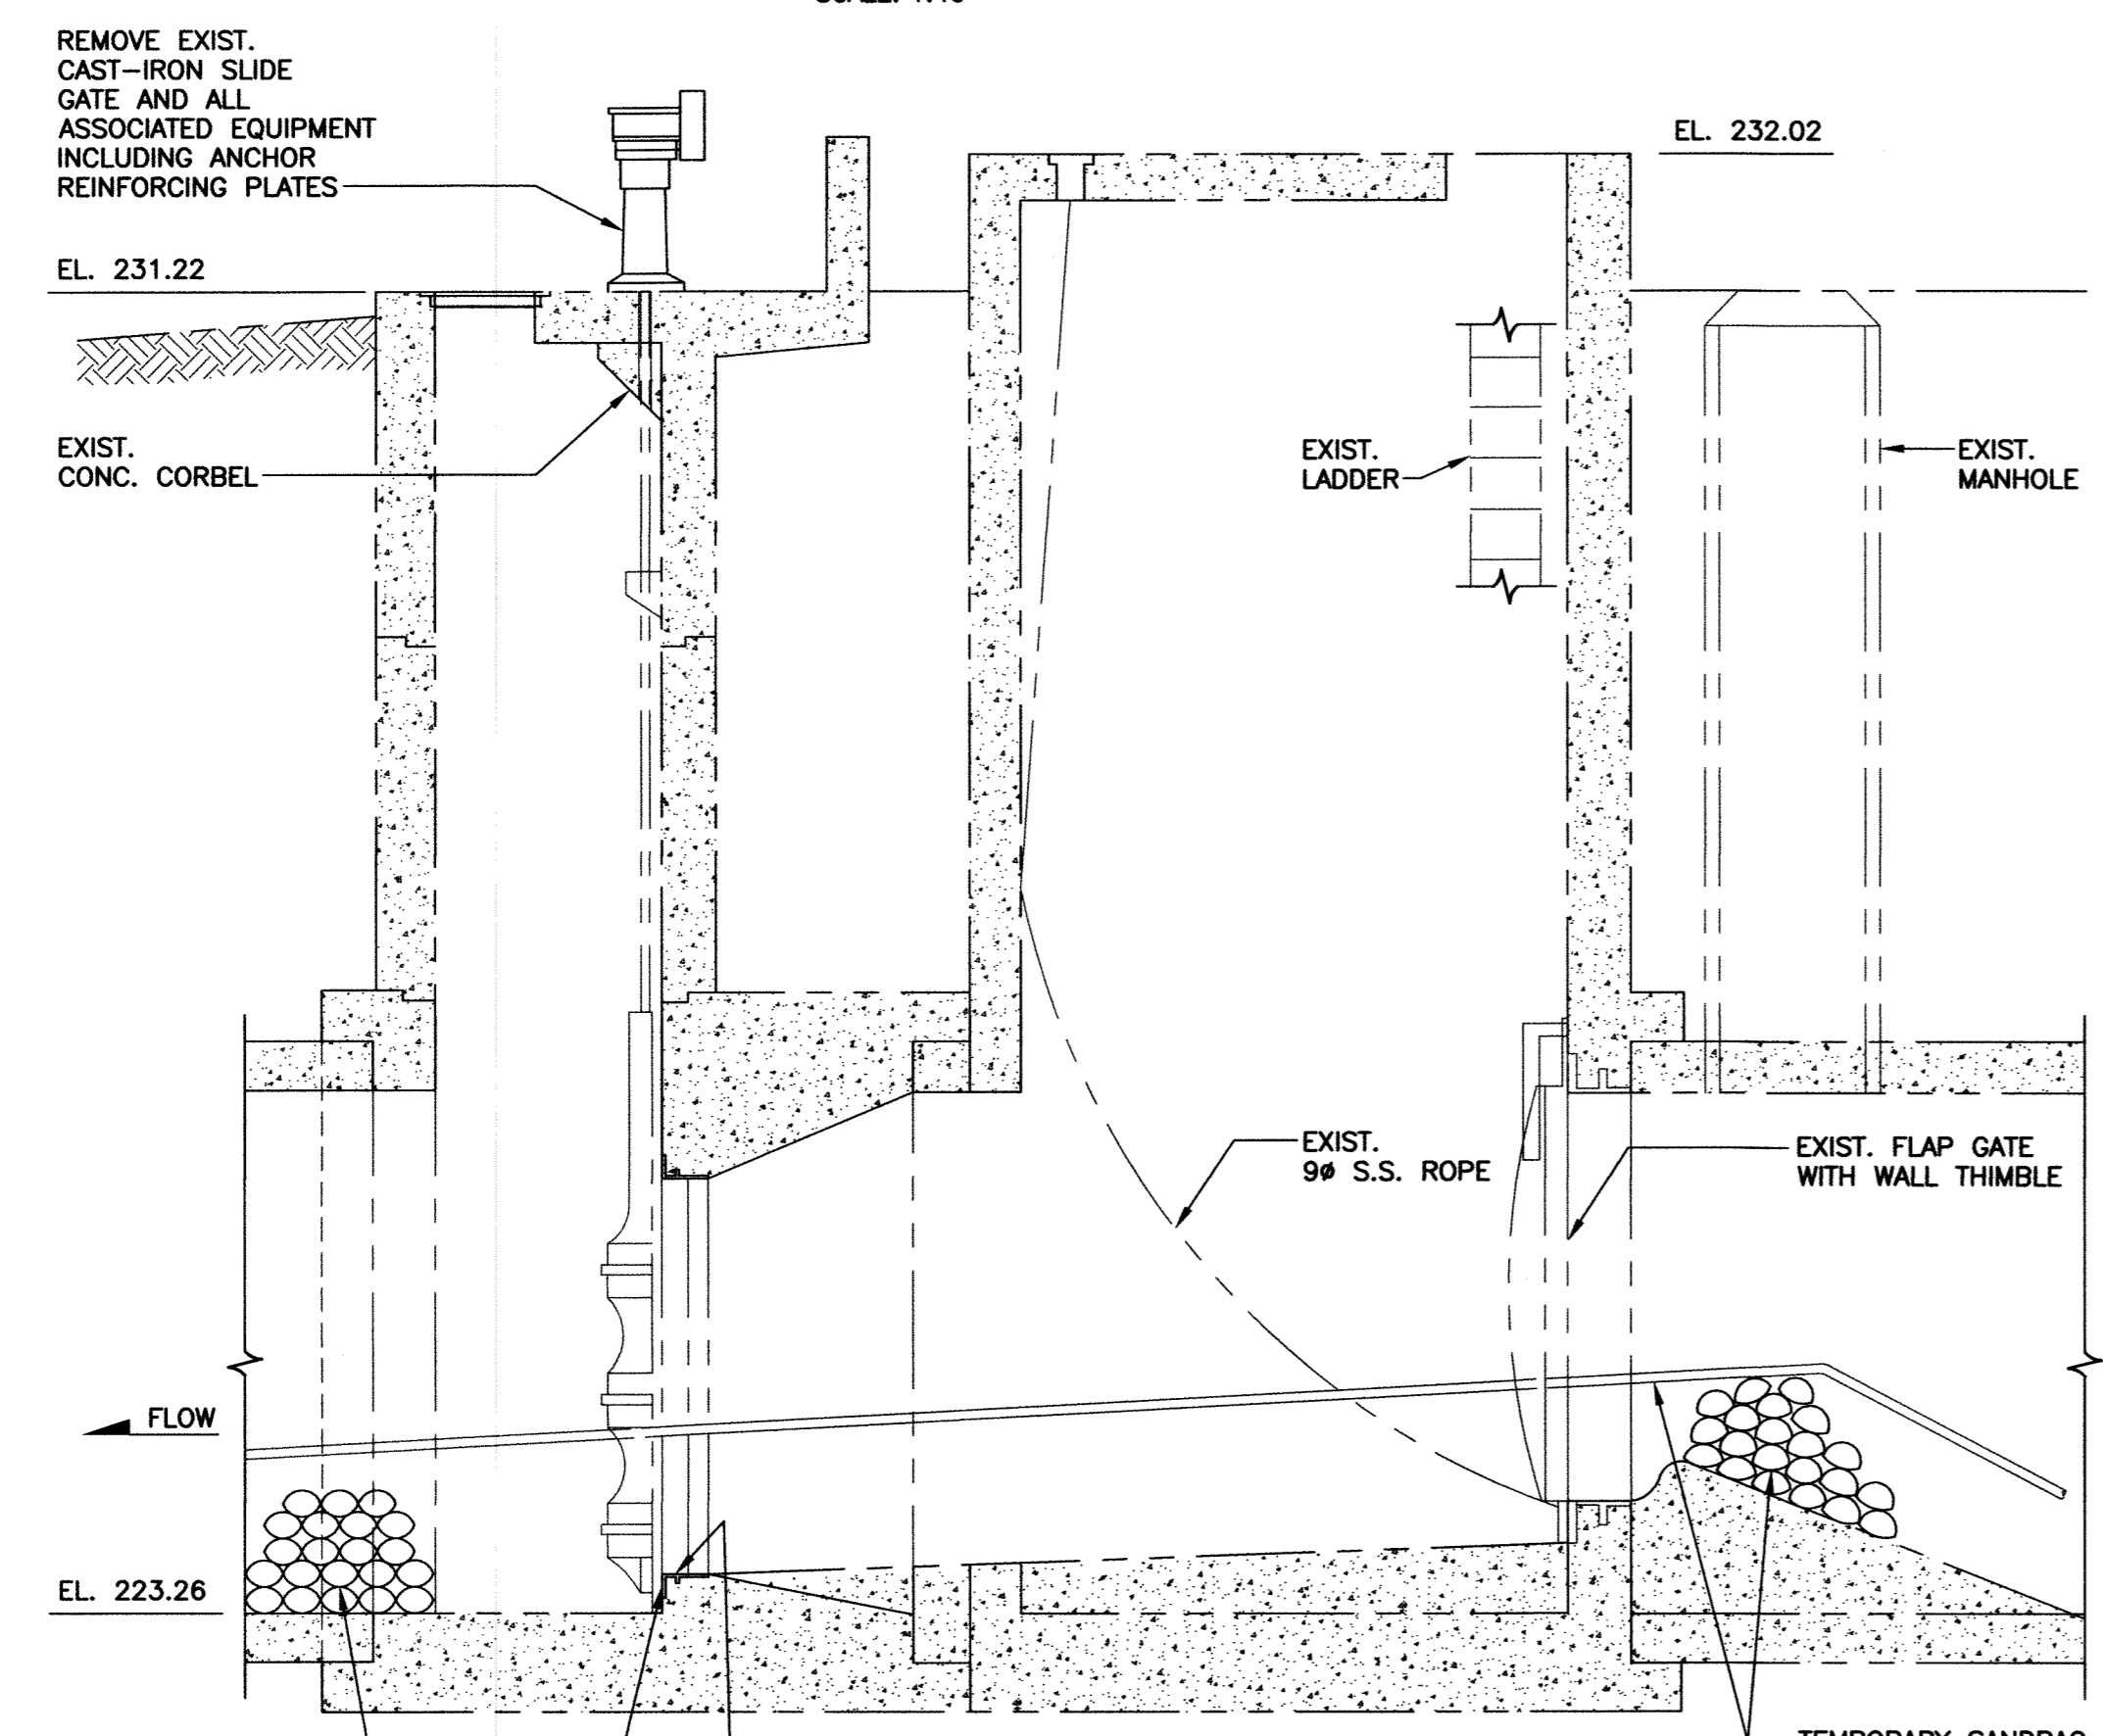


SECTION A-A
SCALE: 1:40

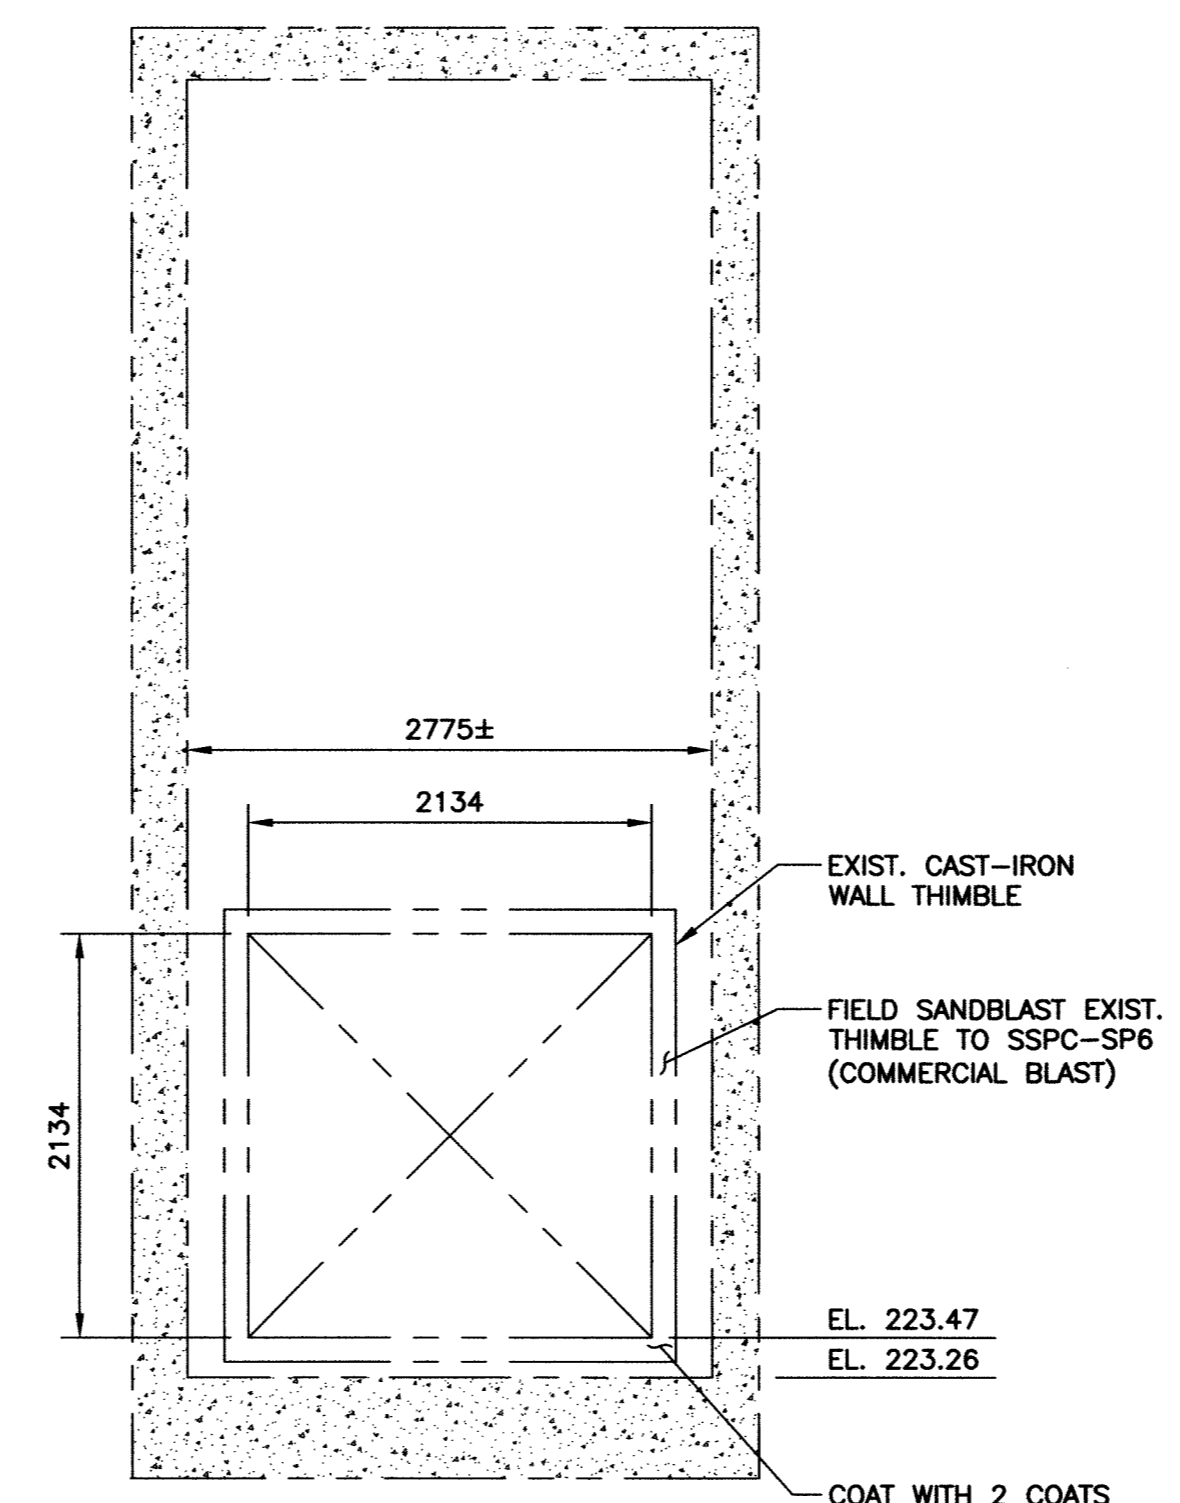


(EXIST. OPENING)
B1 SECTION
SCALE: 1:40

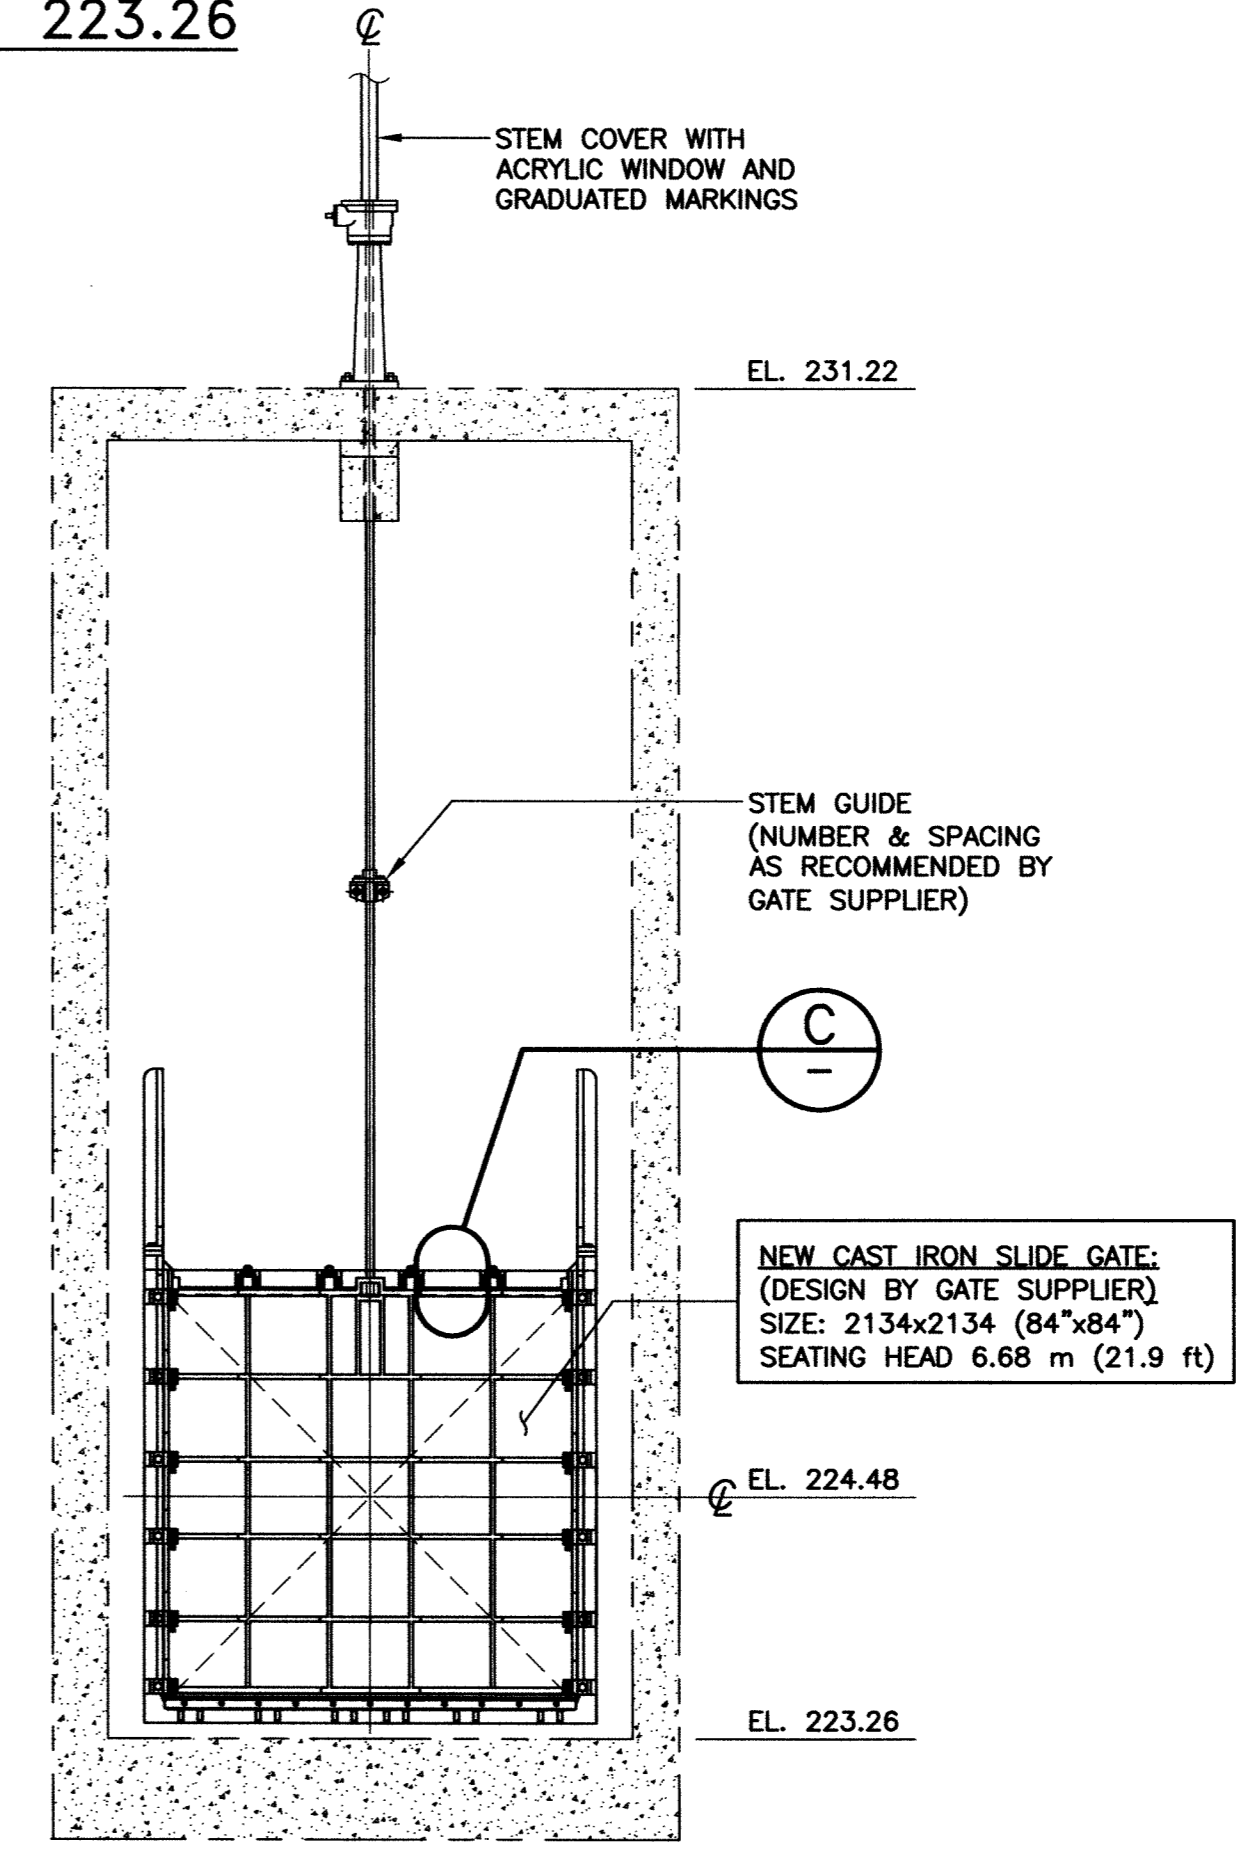


(NEW SLIDE GATE)
B2 SECTION
SCALE: 1:40

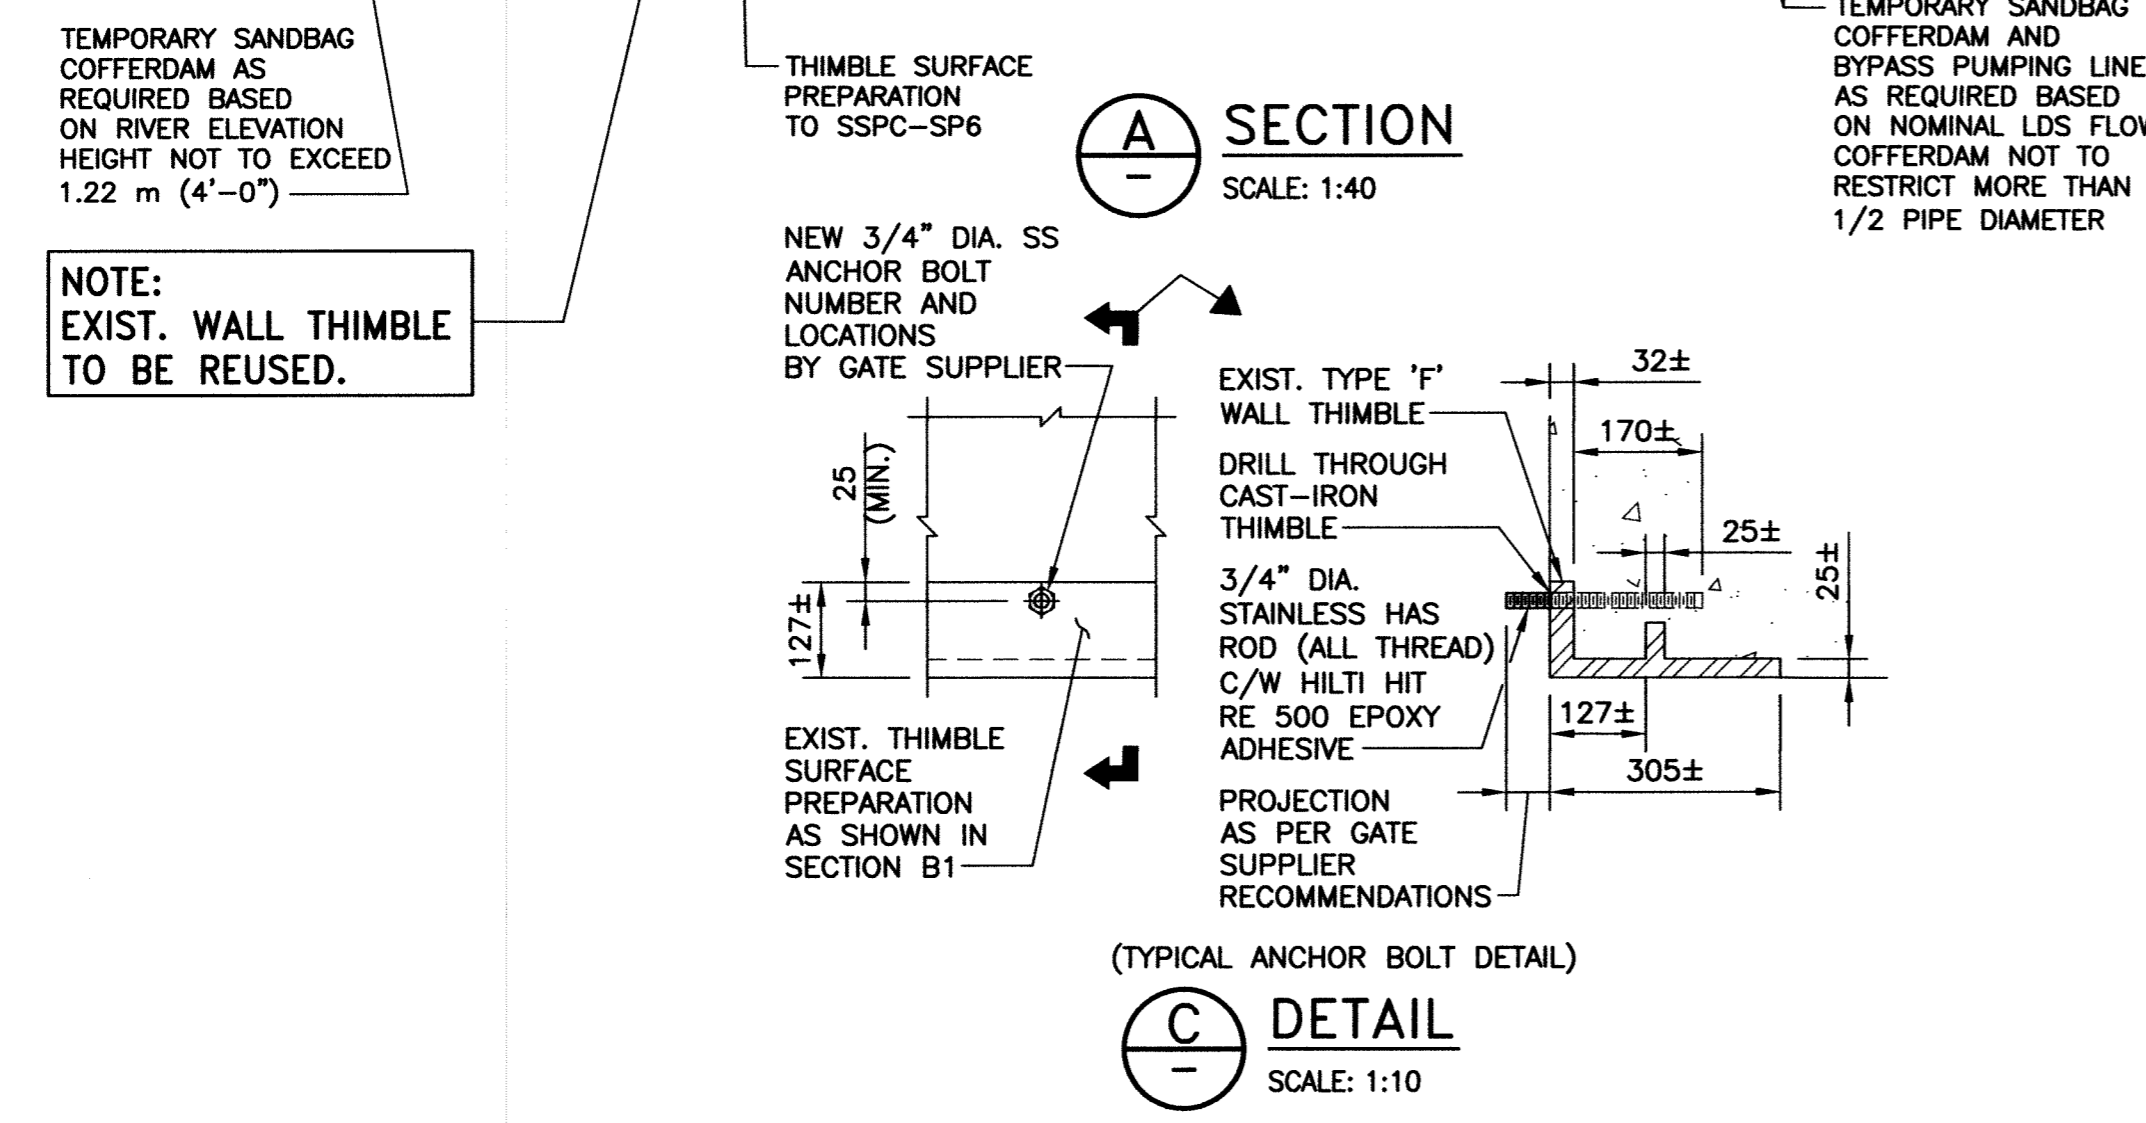

 (TYPICAL ANCHOR BOLT DETAIL)
C DETAIL
SCALE: 1:10



 SCALE: 1:40 METRIC (A1)
1:80 METRIC (A3)



SCALE: 1:10 METRIC (A1)
1:20 METRIC (A3)

METRIC
WHOLE NUMBERS INDICATE MILLIMETRES
DECIMALIZED NUMBERS INDICATE METRES

File Name: \\k-file-2\p-data\Projects\2010\10-0107-19\Doc\Control\TobBelaus\DWG\1-0114F-S0001-001.dwg - Tab: S1 Plotted By: Dberoch 08/24/2011 [Wed 1:24pm]



BM. ELEV.	N/A	FIELD BOOK #	
POSTED TO LBS			
DESIGNED BY	KRD	CHECKED BY	CMS
DRAWN BY	FBV	APPROVED BY	
HDR. SCALE		RELEASED FOR CONSTRUCTION	
0 ISSUED FOR CONSTRUCTION	2011-08-23	CMS	VERTICAL
NO. REVISIONS	DATE	BY	DATE
			2011-03-01

KGS GROUP
CONSULTING ENGINEERS

ENGINEER'S SEAL

 TENDER No. 1-0114F-S0001-001.dwg
 FILENAME 1-0114F-S0001-001.dwg
 PLOT DATE: 2011/08/24

THE CITY OF WINNIPEG
WATER AND WASTE DEPARTMENT

ASH FLOOD PUMPING STATION
SLIDE GATE REFURBISHMENT
STRUCTURAL
PLAN, SECTIONS & DETAILS

SHEET 1 OF 1
CITY DRAWING NUMBER
1-0114F-S0001-001