




File Name: \\k-file-2\p-data\Projects\2010\10-0107-19\Doc-Control\Tobias\dwg\1-0144F-S0001-001.dwg - Tab: S2 Plotted By: DDeroche 08/24/2011 [Wed 1:23pm]

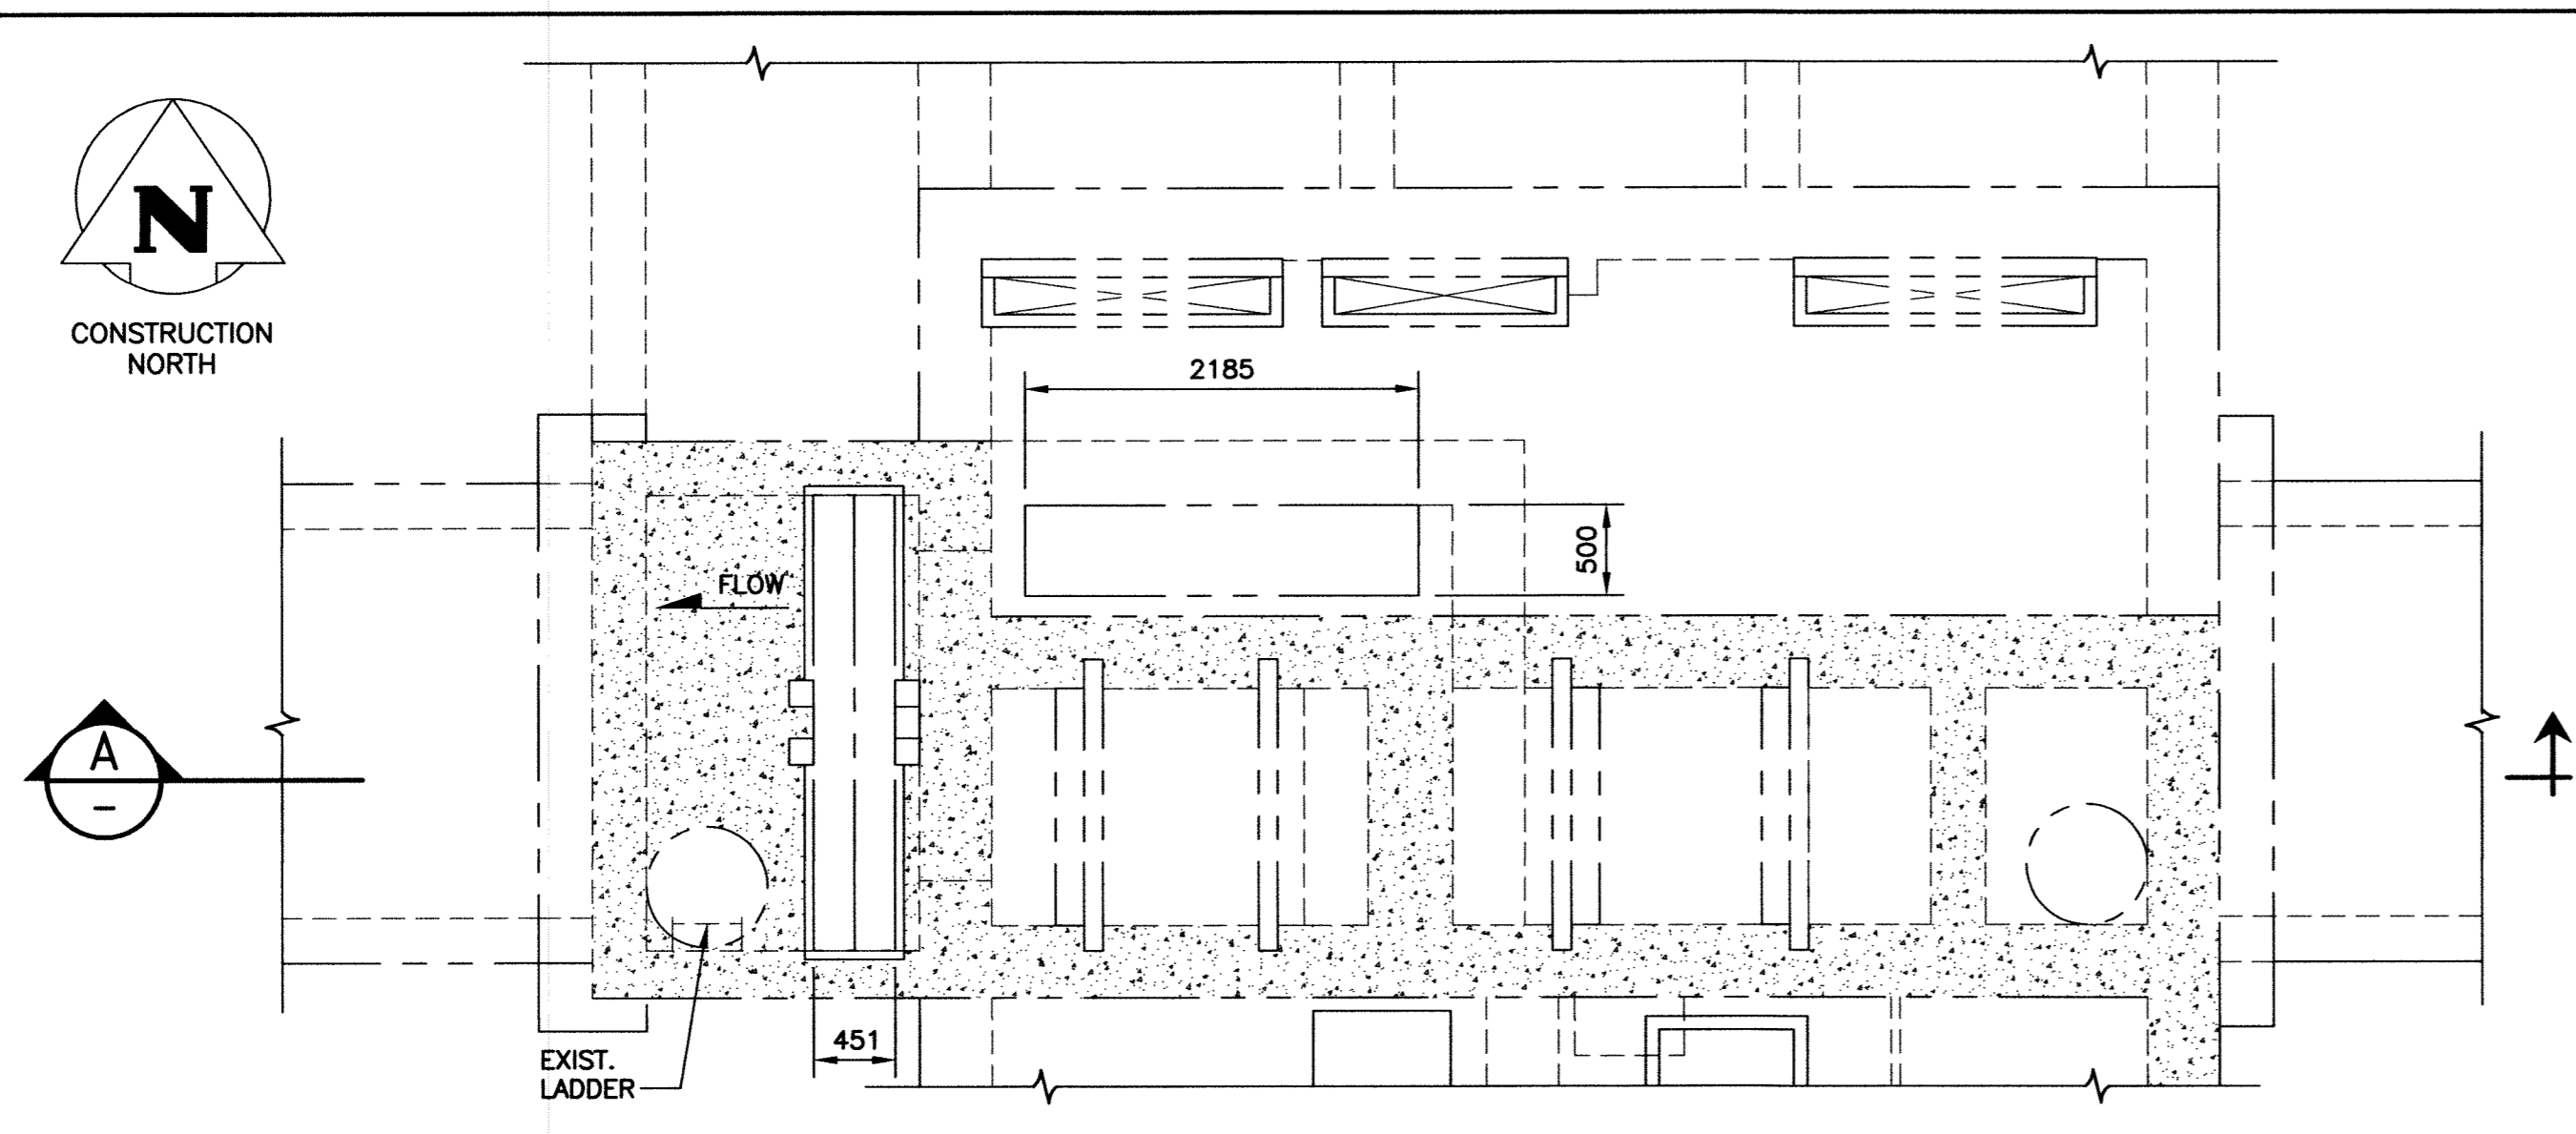


PLAN - EL. 231.88
SCALE: 1:40

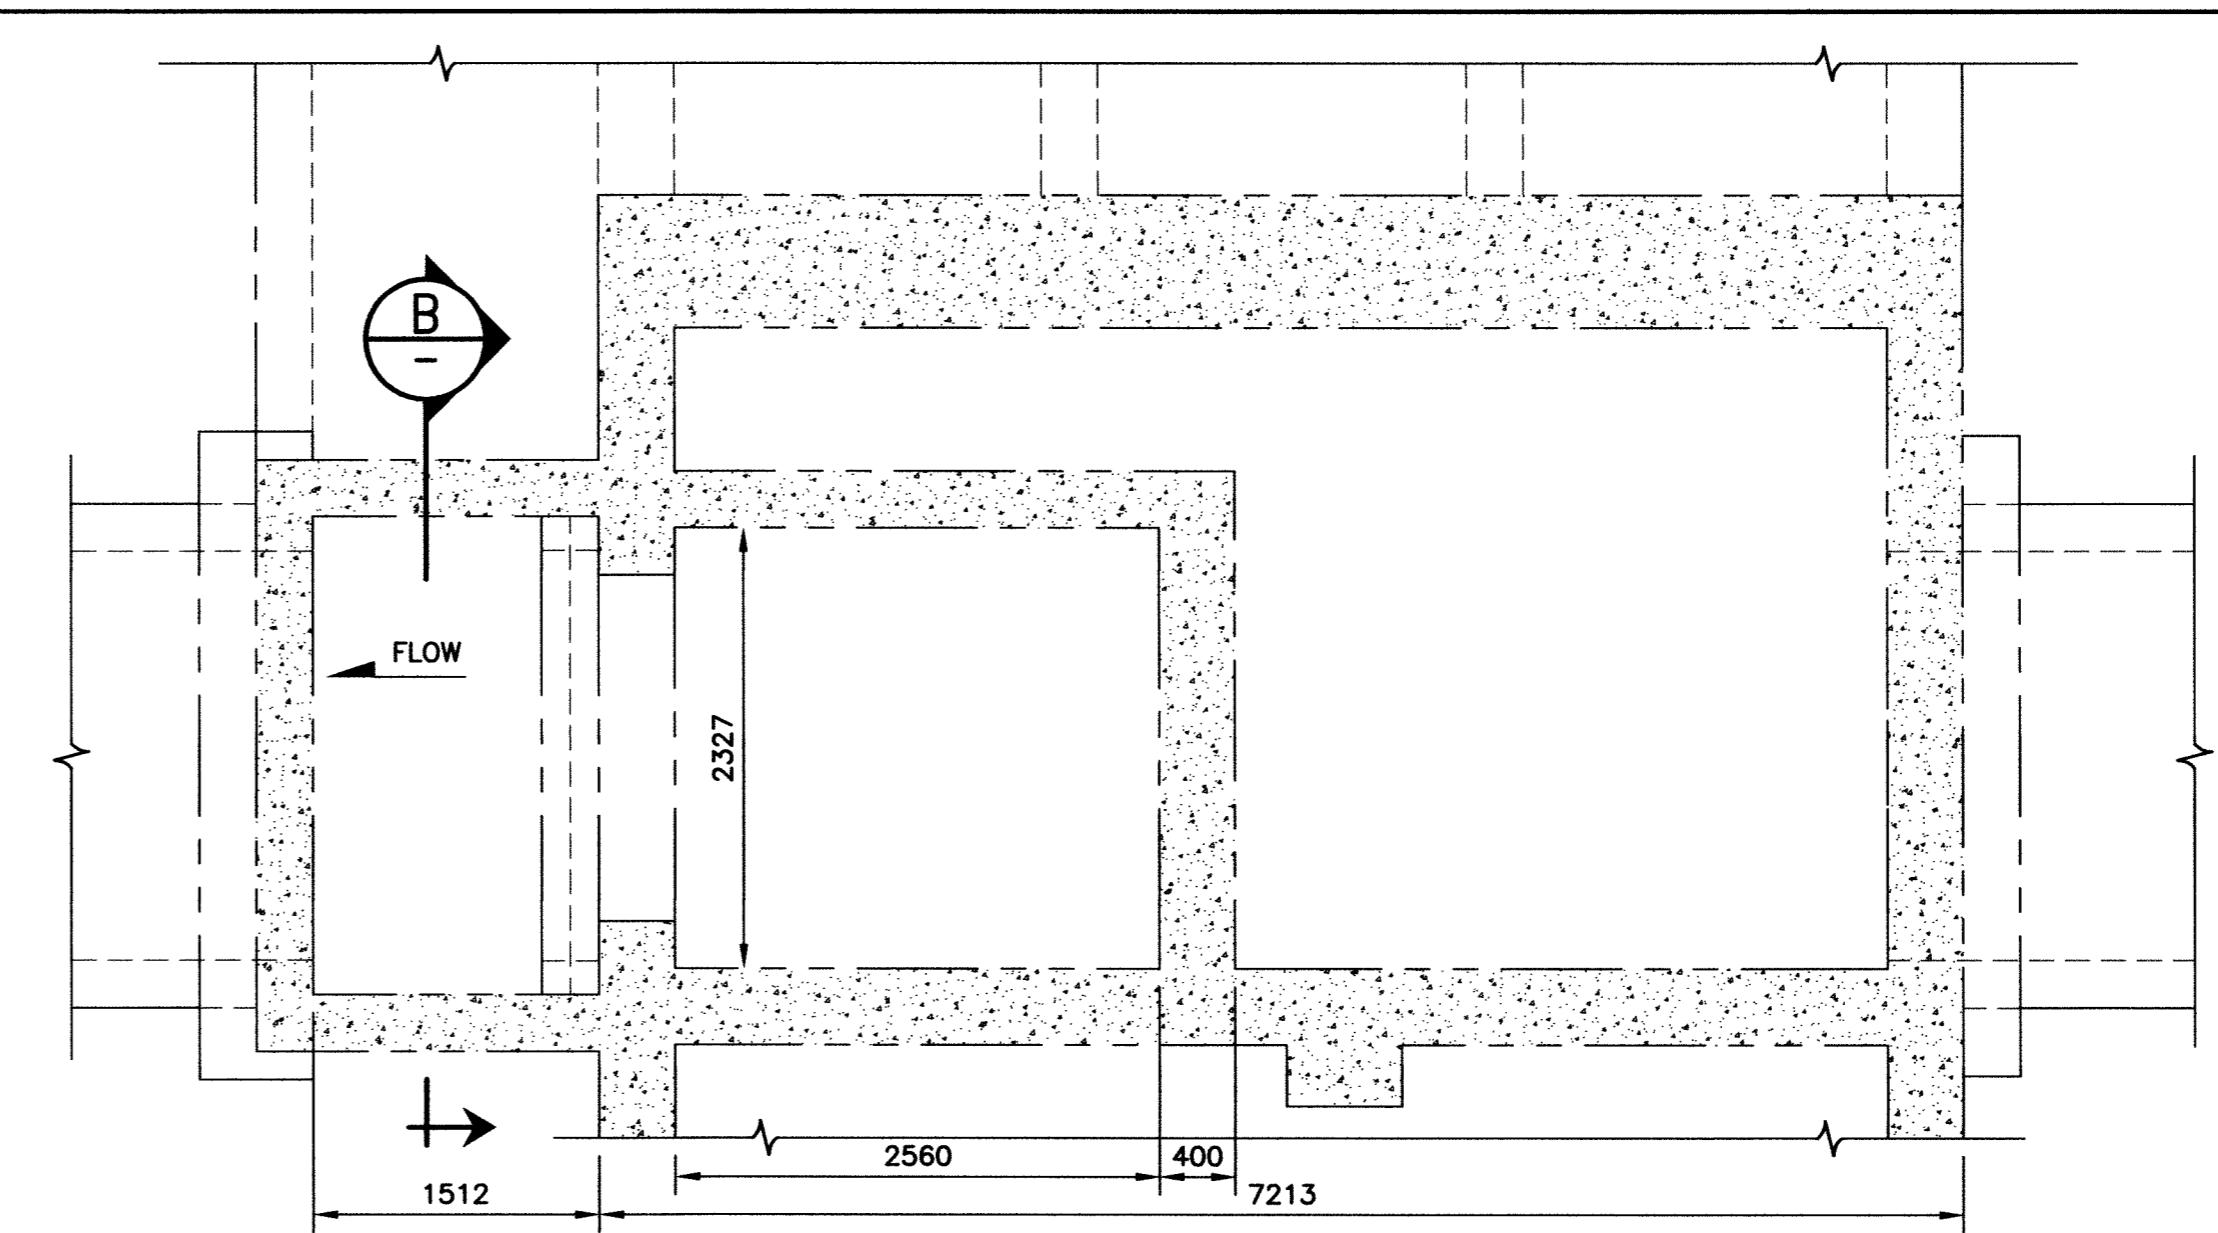


PLAN - EL. 222.76
SCALE: 1:40

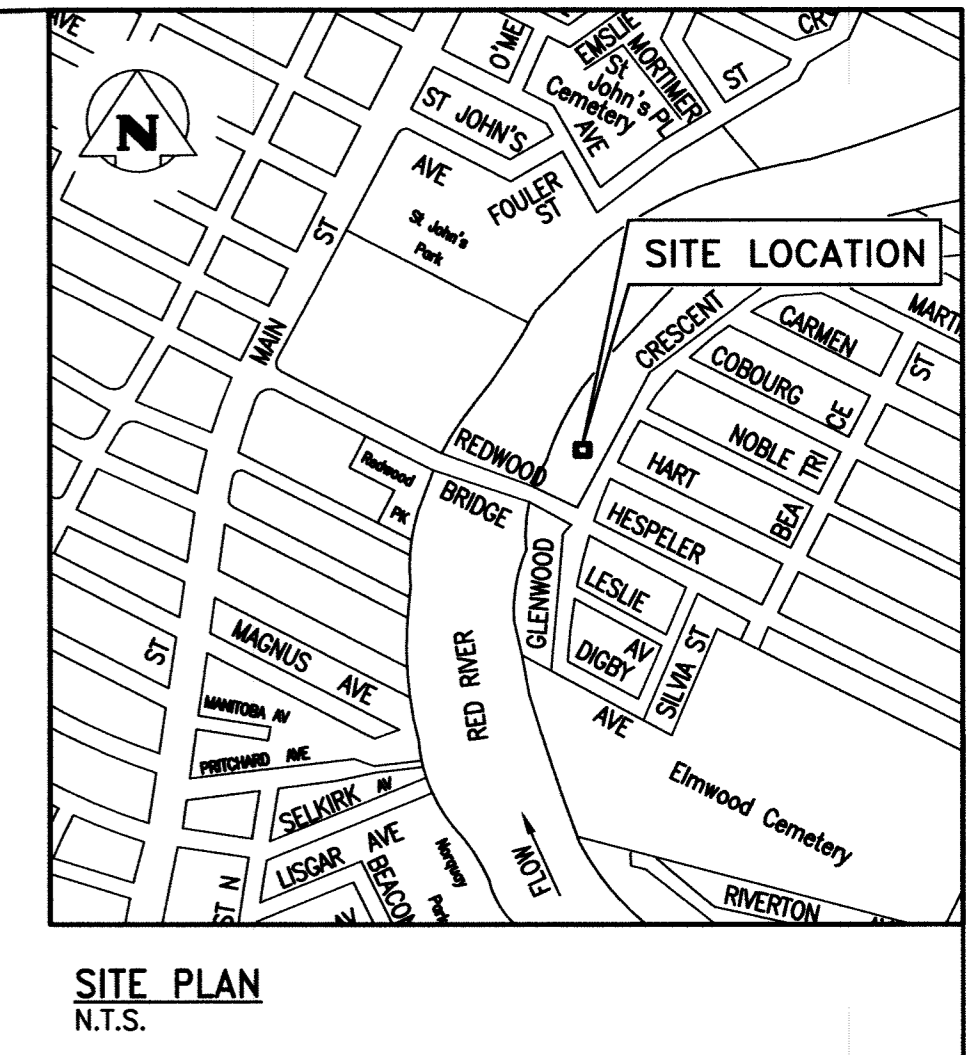

SITE PLAN
N.T.S.

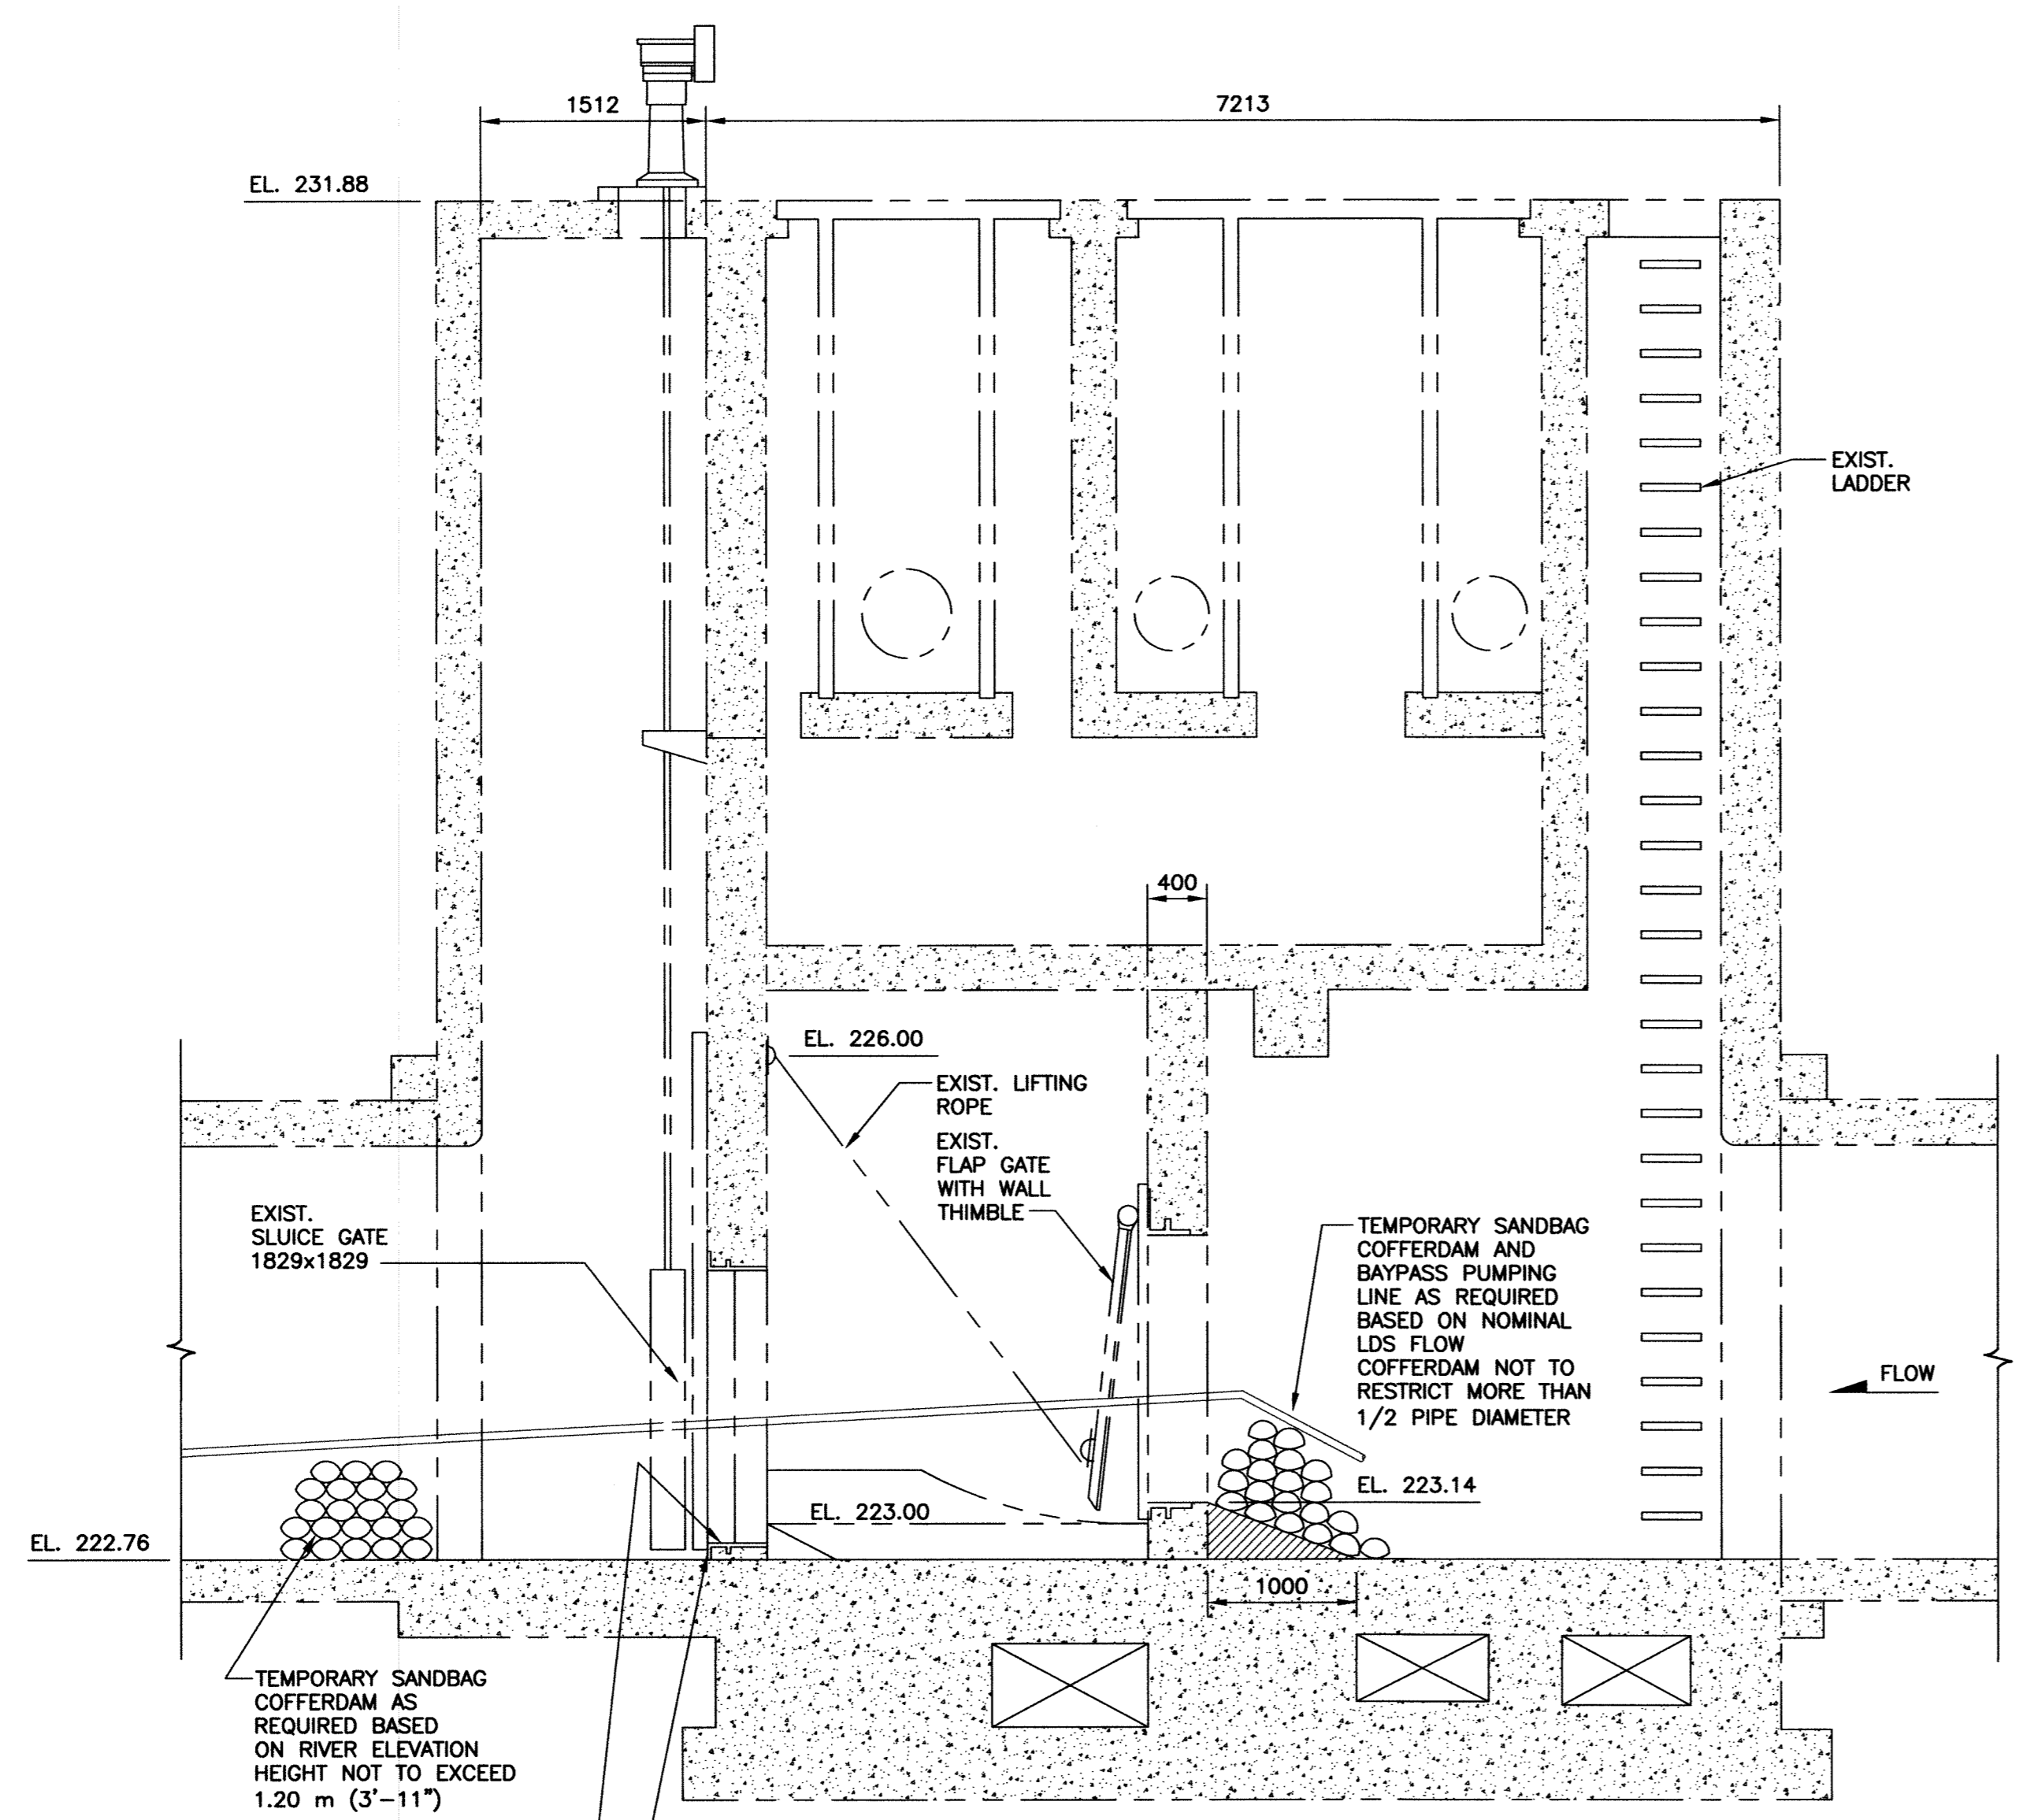


A SECTION
SCALE: 1:40

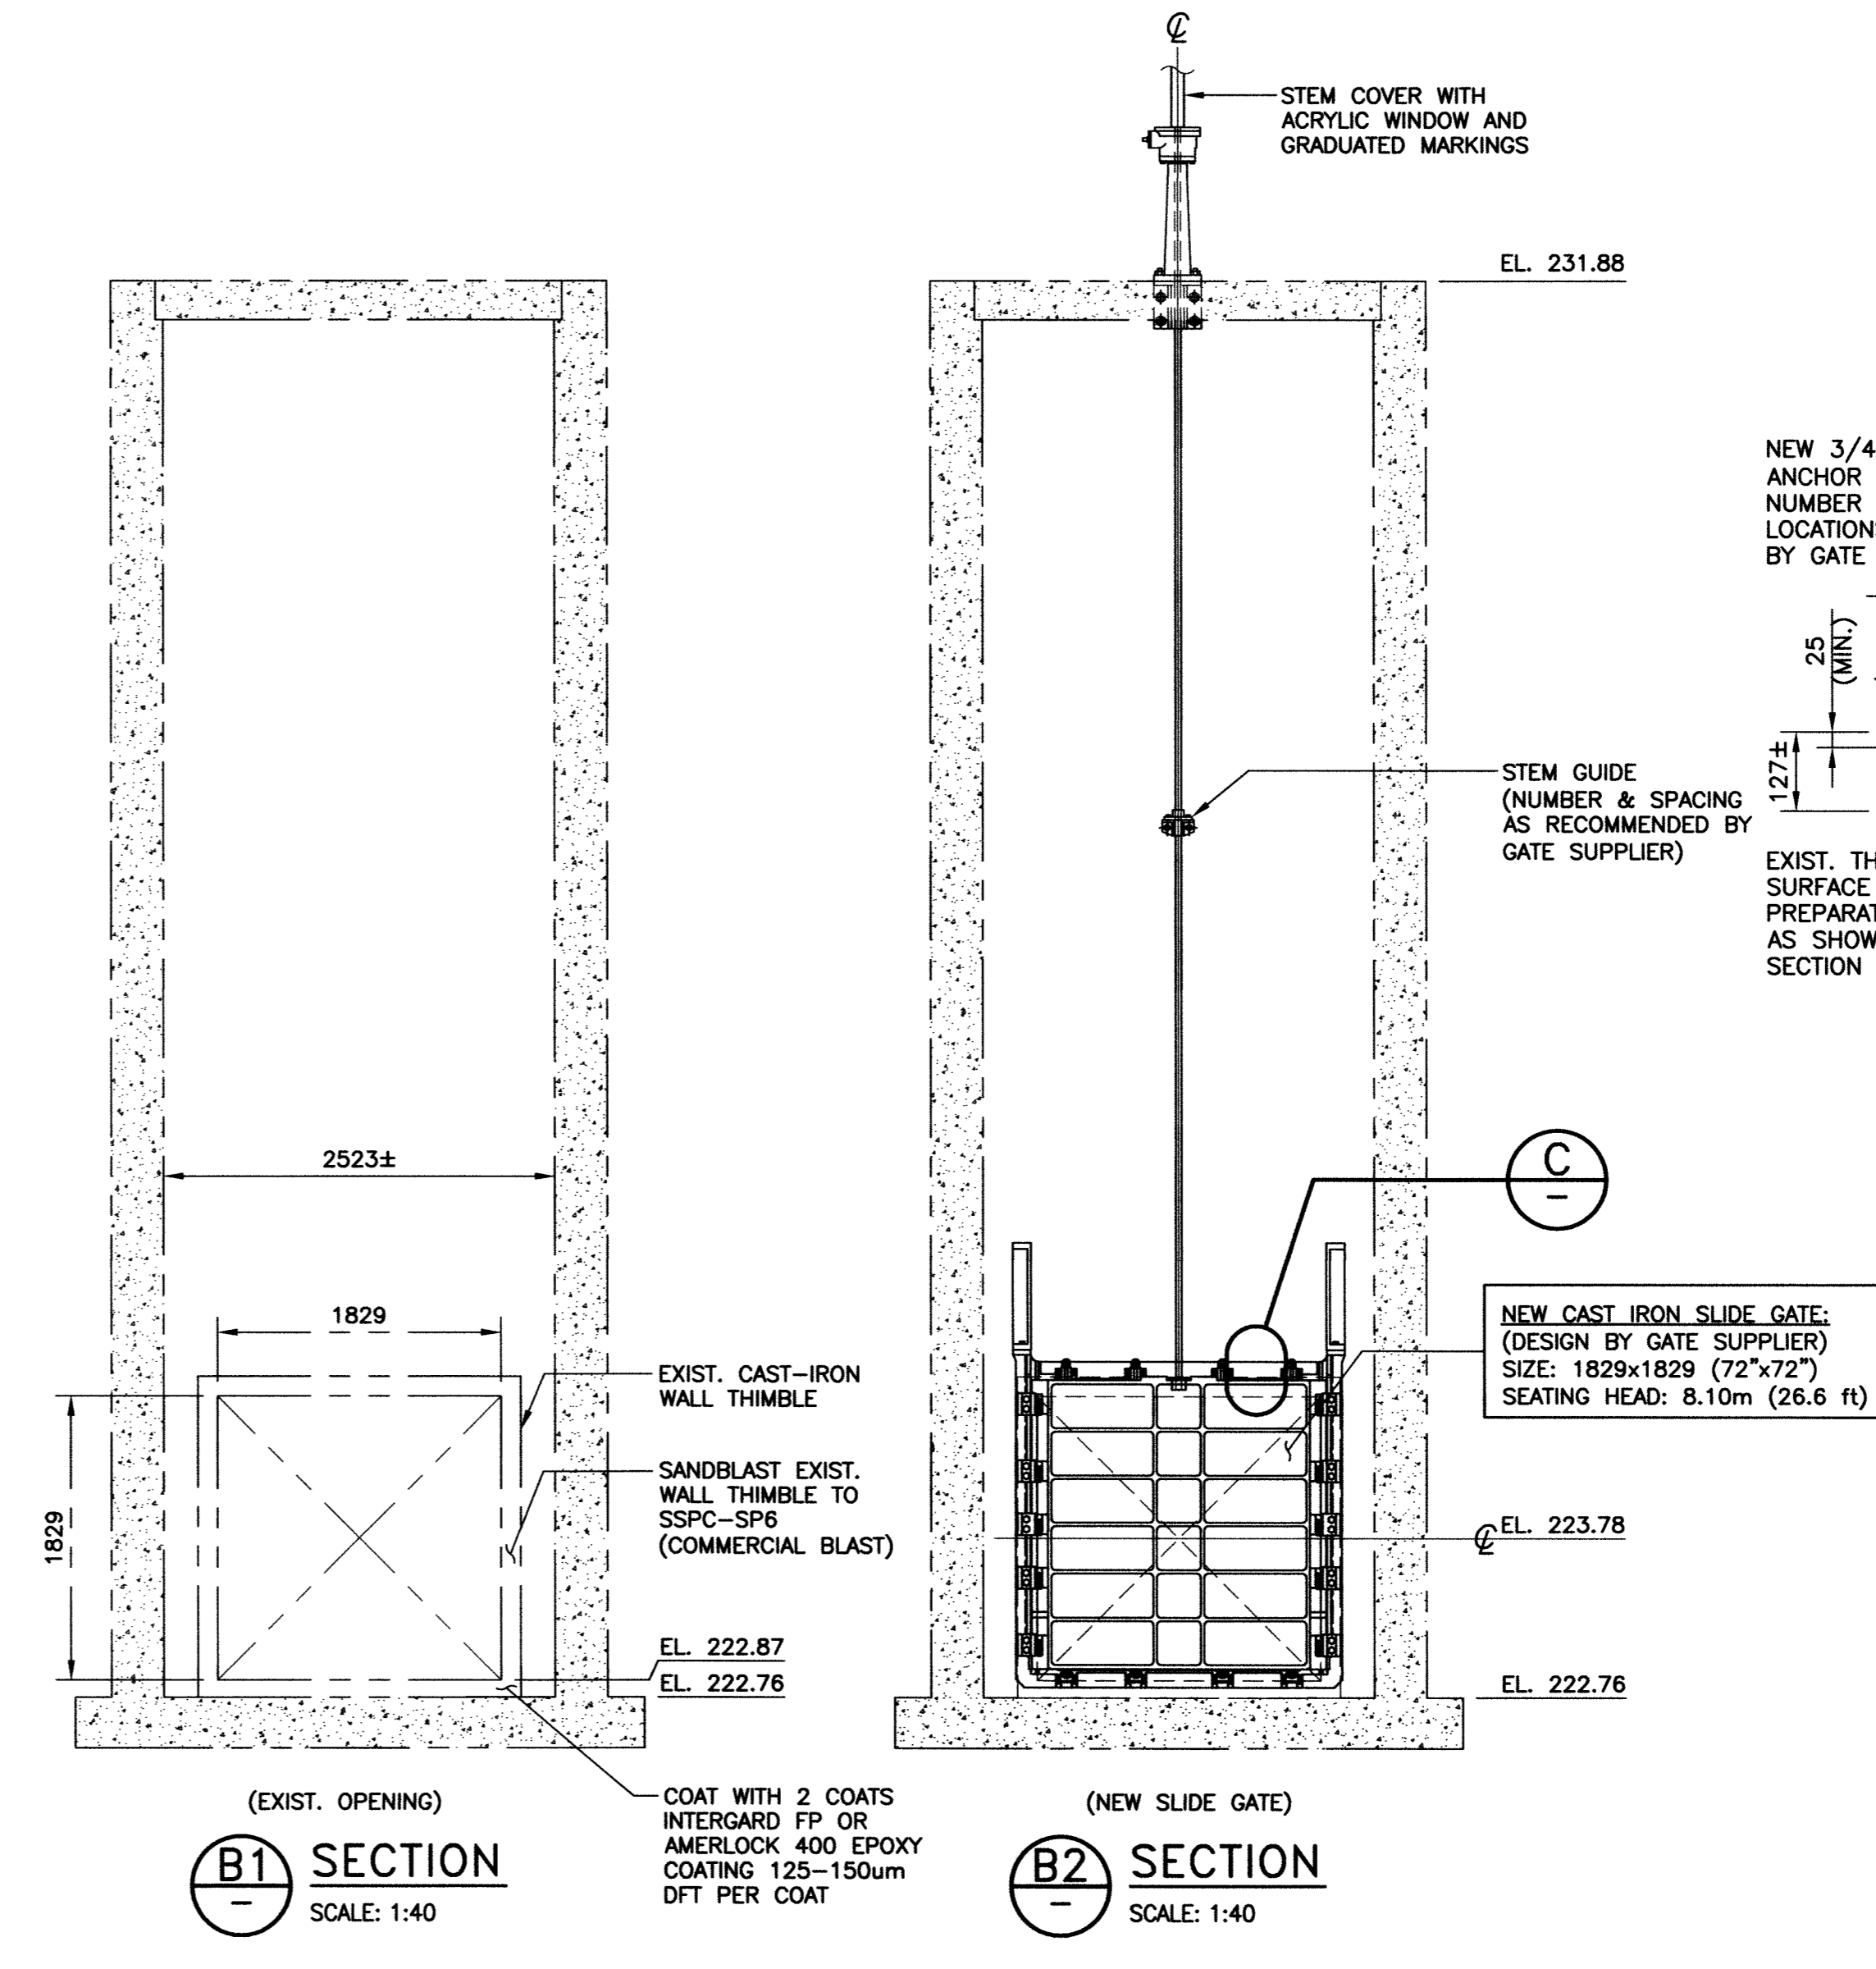


B1 SECTION
SCALE: 1:40


B2 SECTION
SCALE: 1:40

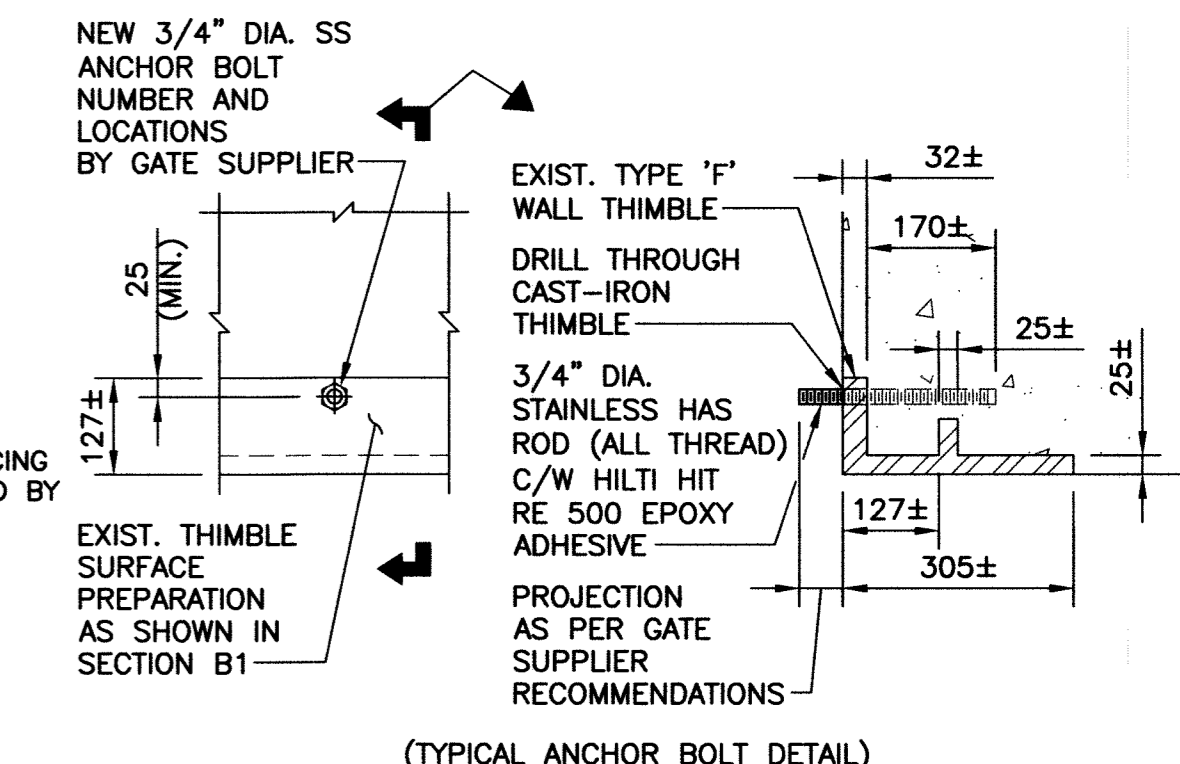

C DETAIL
SCALE: 1:10

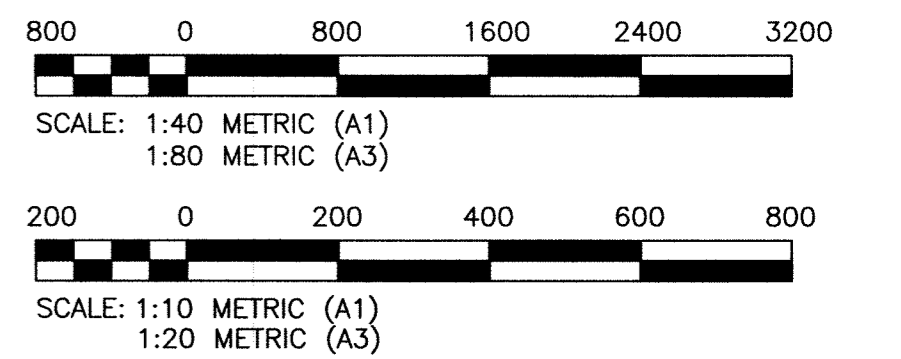

METRIC
WHOLE NUMBERS INDICATE MILLIMETRES
DECIMALIZED NUMBERS INDICATE METRES

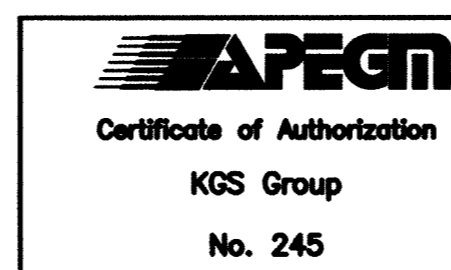

BM. ELEV.	N/A	FIELD BOOK #:	
POSTED TO LBIS			
DESIGNED BY	KRD	CHECKED BY	CMS
DRAWN BY	FBV	APPROVED BY	
HOR. SCALE		RELEASED FOR CONSTRUCTION	
VERTICAL			
ISSUED FOR CONSTRUCTION	2011-08-23	DATE	2011-03-01
NO. REVISIONS		DATE	

KGS GROUP
CONSULTING ENGINEERS

DESIGNED BY: KRD
DRAWN BY: FBV
HOR. SCALE: VERTICAL
ISSUED FOR CONSTRUCTION: 2011-08-23
DATE: 2011-03-01

CHECKED BY: CMS
APPROVED BY: [Signature]
RELEASED FOR CONSTRUCTION: [Signature]
DATE: 2011-03-01

ENGINEER'S SEAL
C.M. SIEPMAN
Member
20813
2011-08-23

TENDER No. FILENAME 1-0144F-S0001-001.dwg
PLOT DATE: 2011/08/24

THE CITY OF WINNIPEG
WATER AND WASTE DEPARTMENT

HART FLOOD PUMPING STATION
SLIDE GATE REFURBISHMENT
STRUCTURAL
PLAN, SECTIONS & DETAILS

SHEET 1 OF 1
CITY DRAWING NUMBER
1-0144F-S0001-001