




PLAN - EL. 232.58
SCALE: 1:40

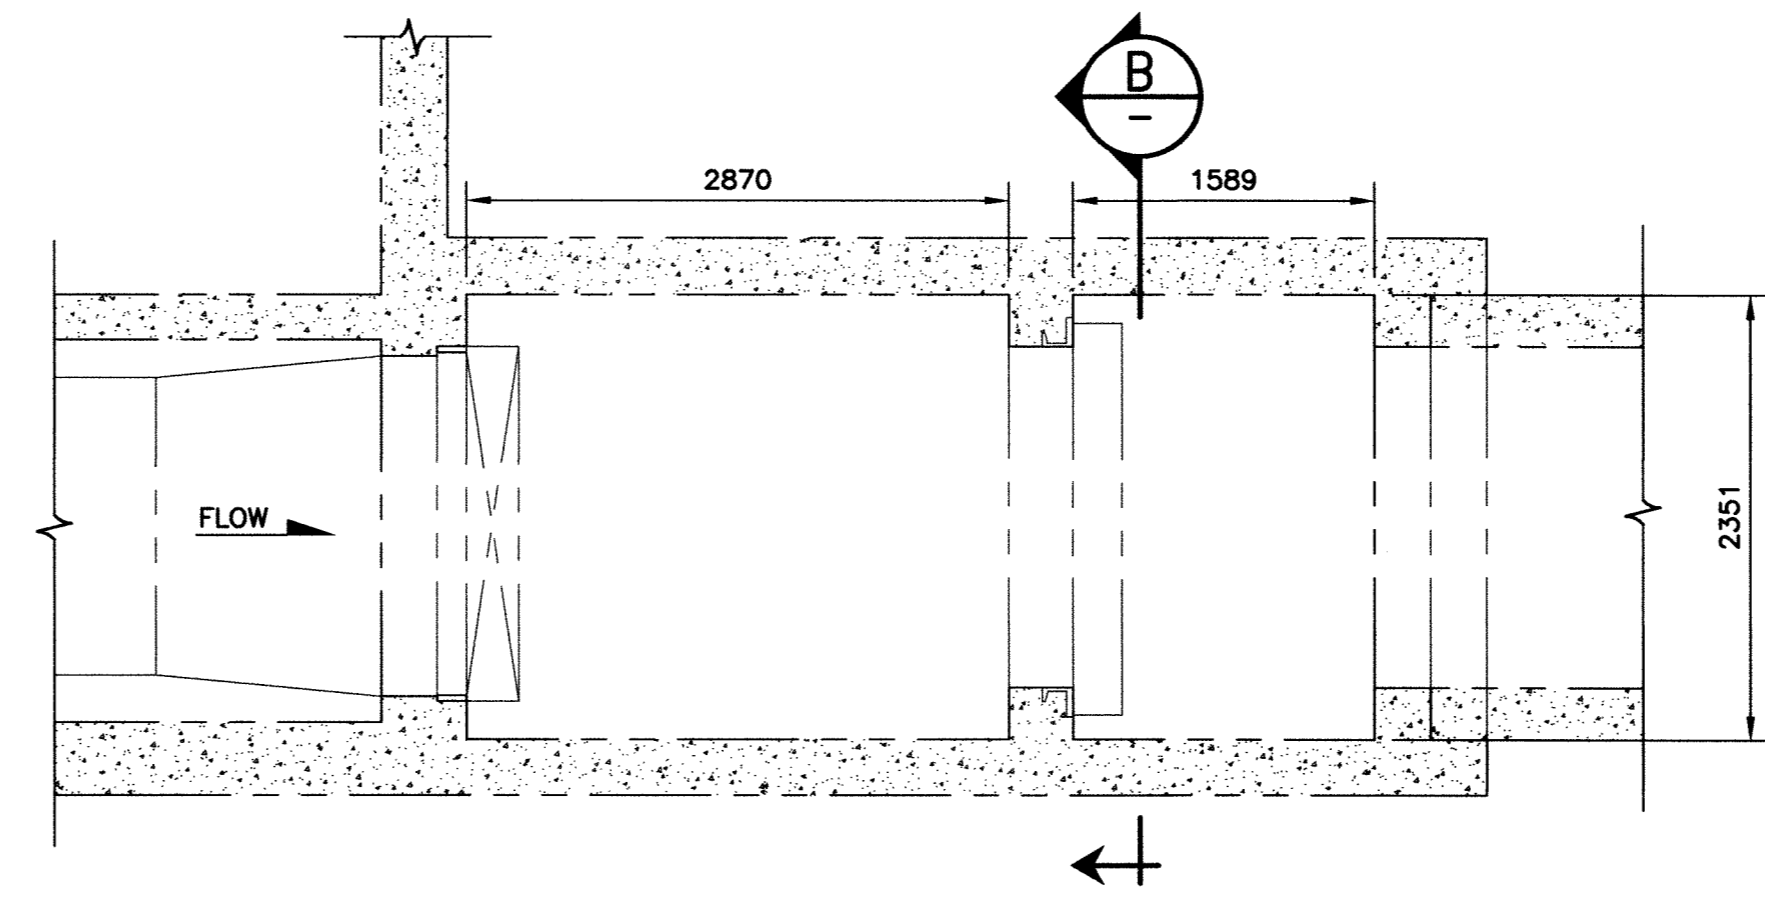


PLAN - EL. 222.55
SCALE: 1:40

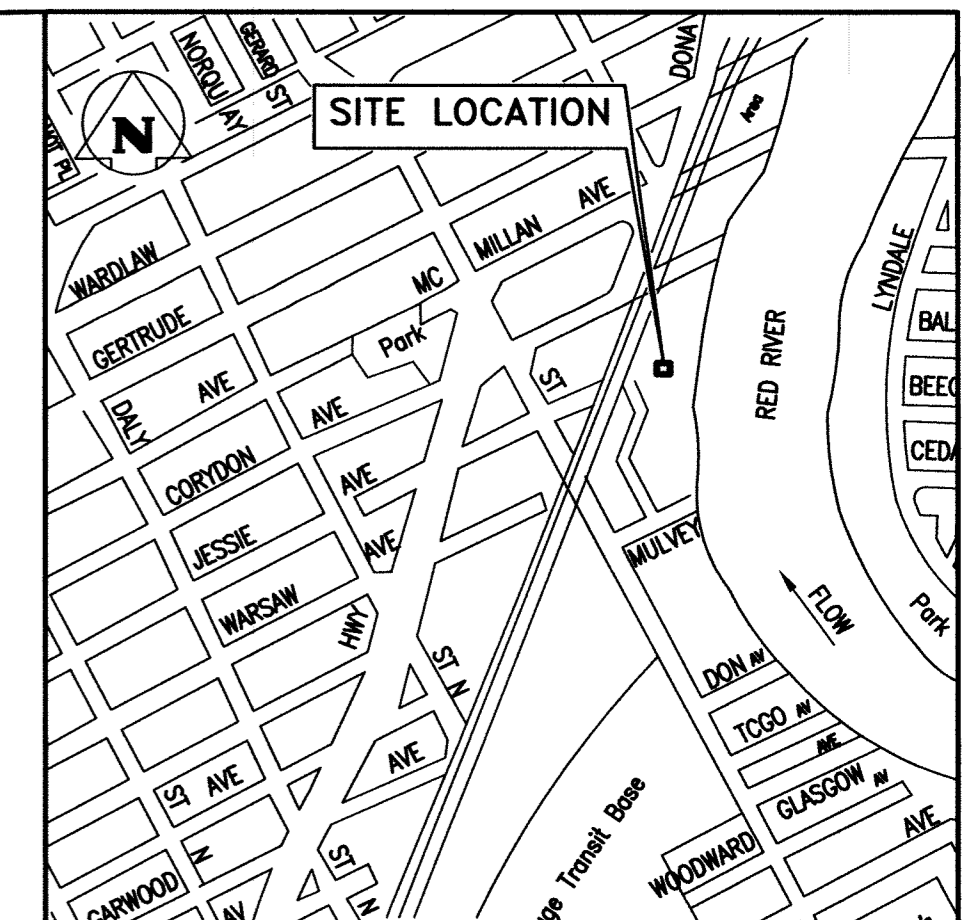


SITE PLAN
N.T.S. NOTE: SITE ACCESS FROM MULVEY AVE.

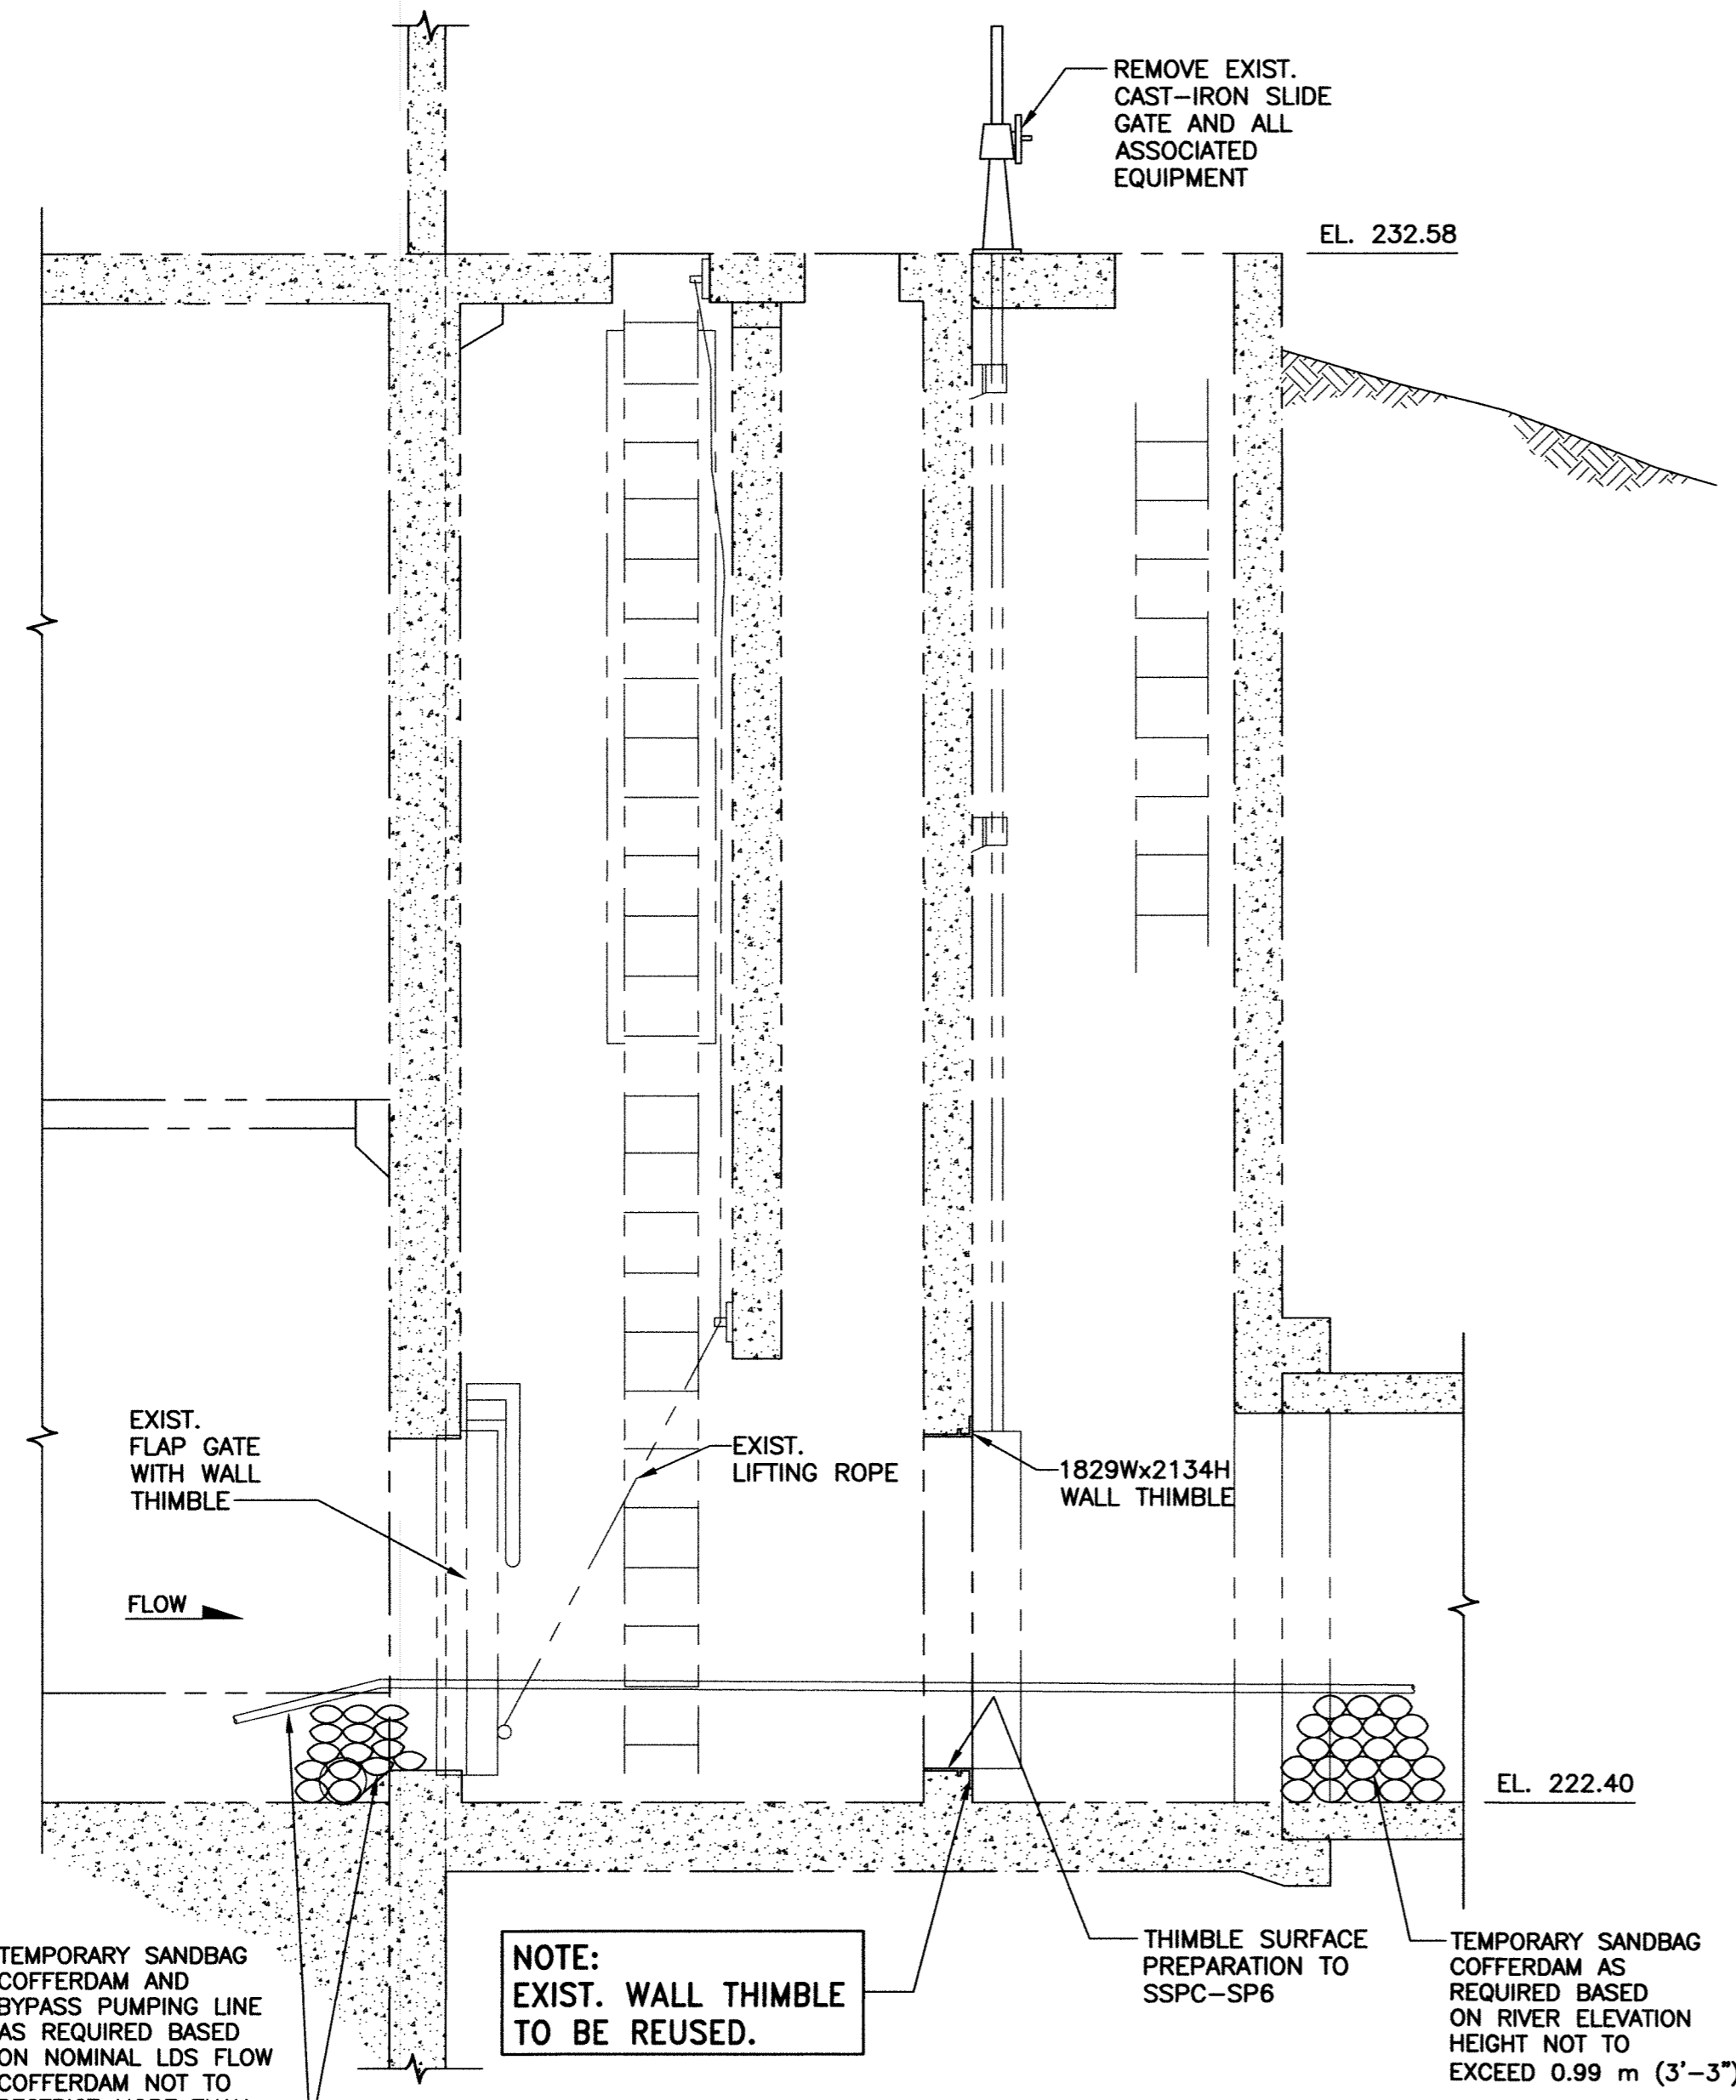


SECTION A SCALE: 1:40

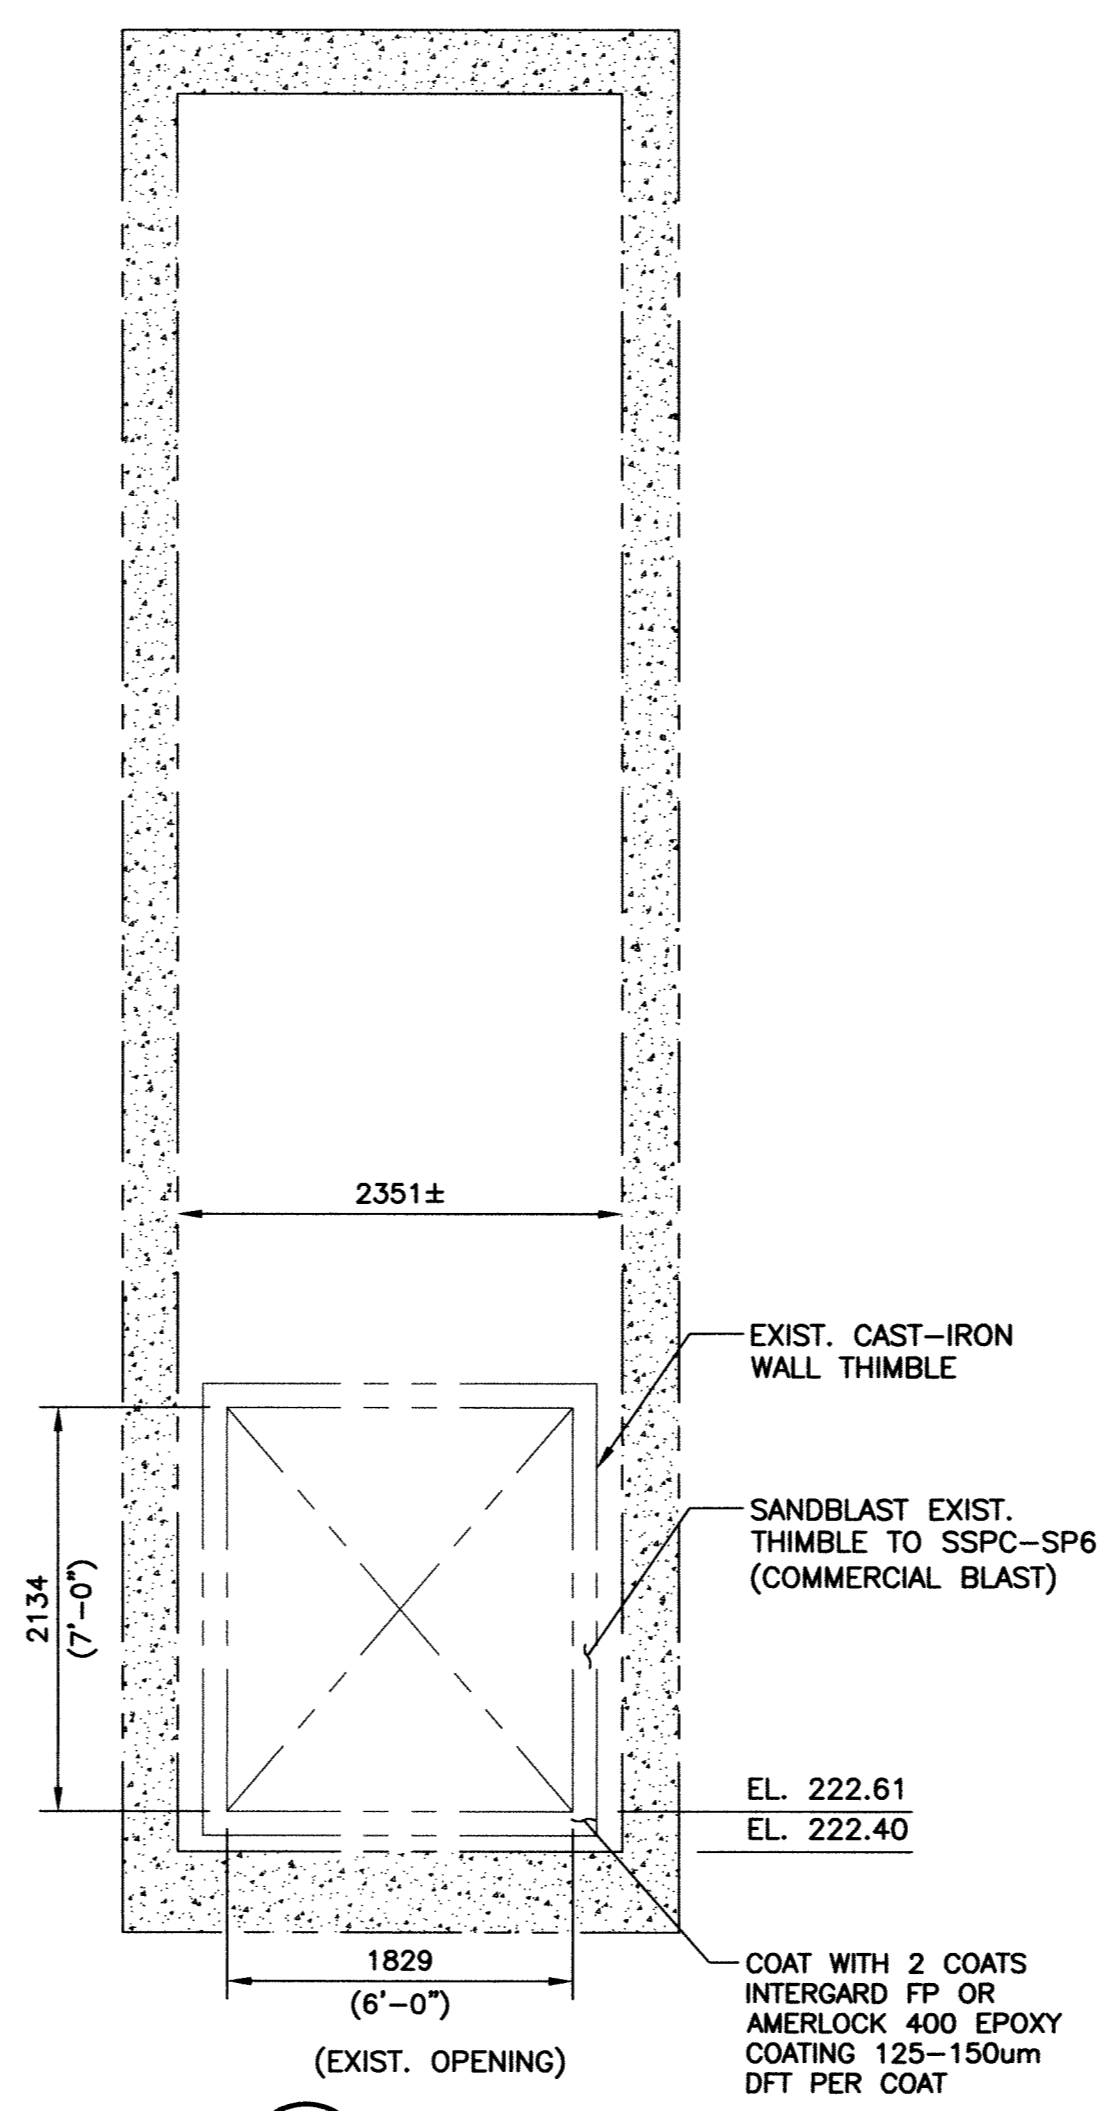


SECTION B1 SCALE: 1:40

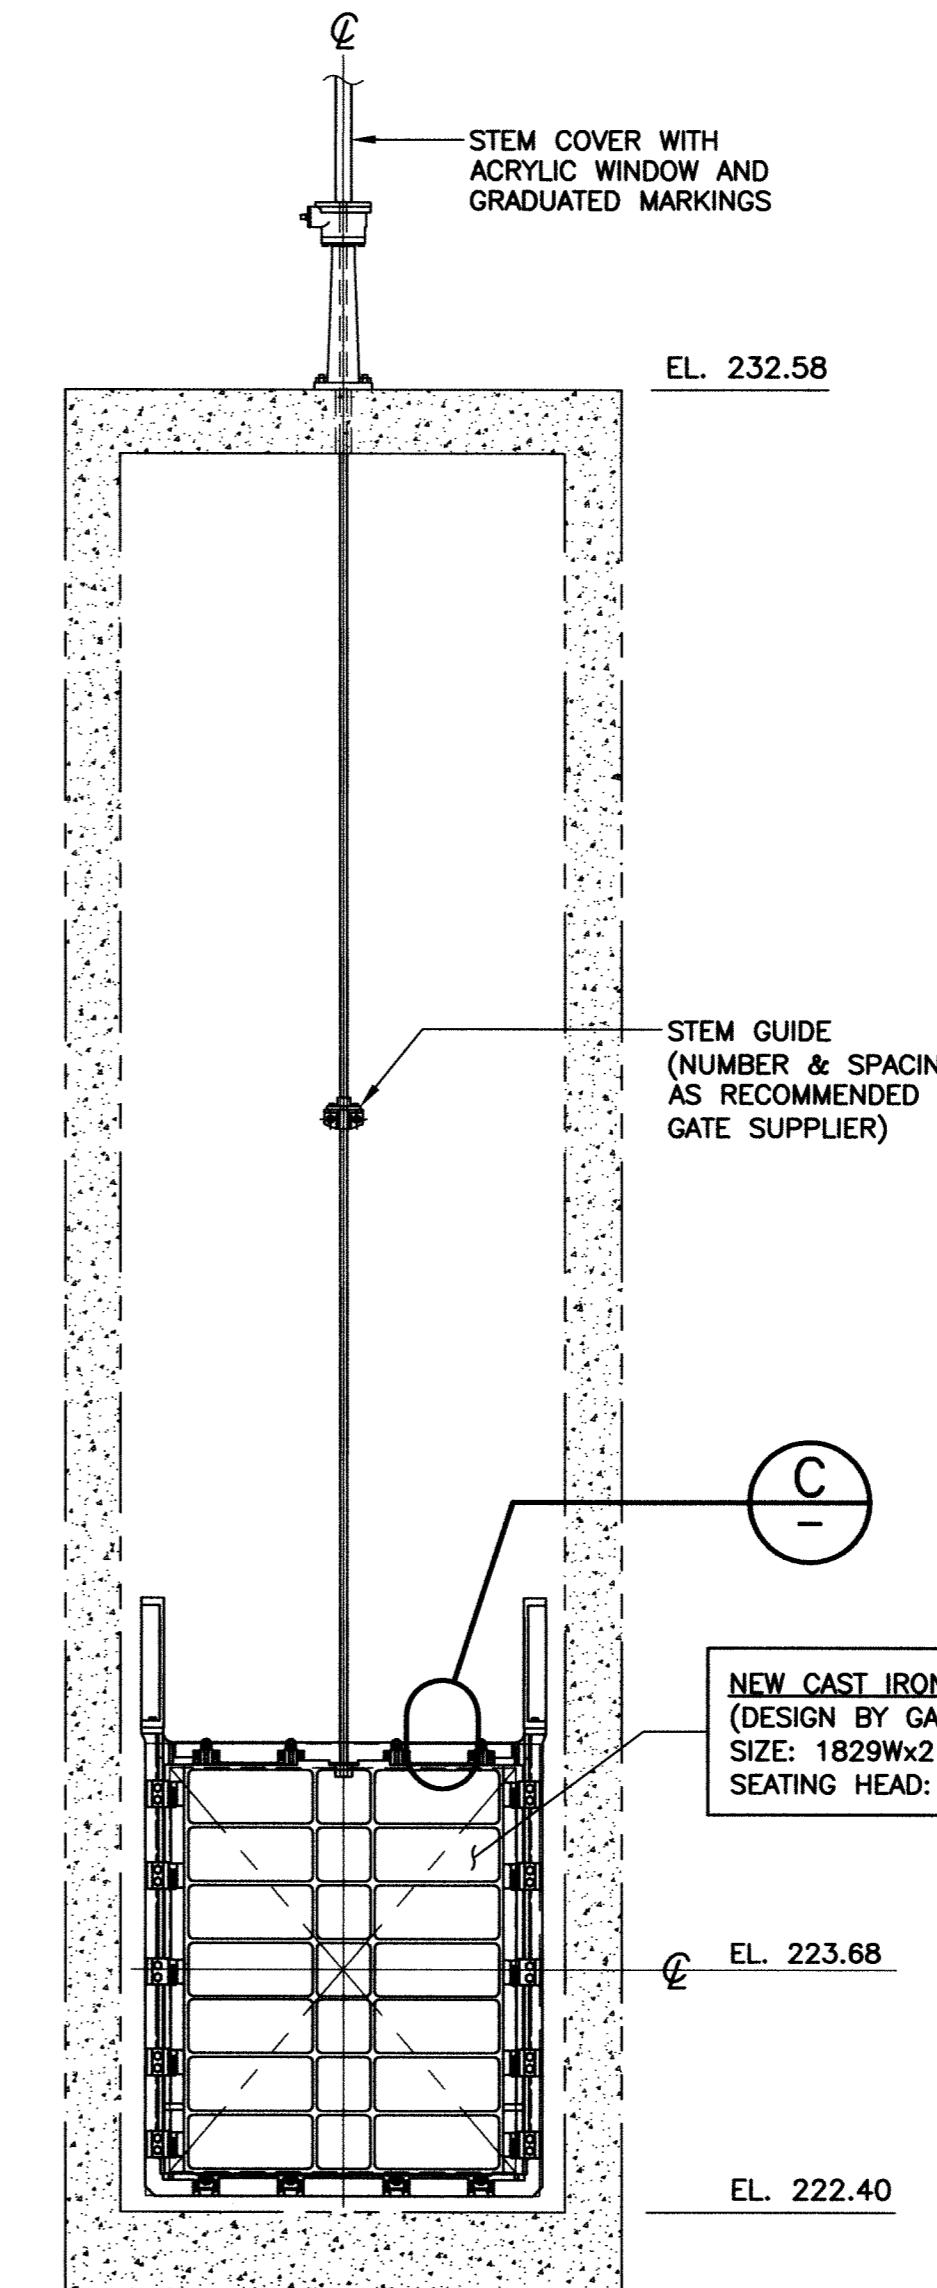

SECTION B2 SCALE: 1:40

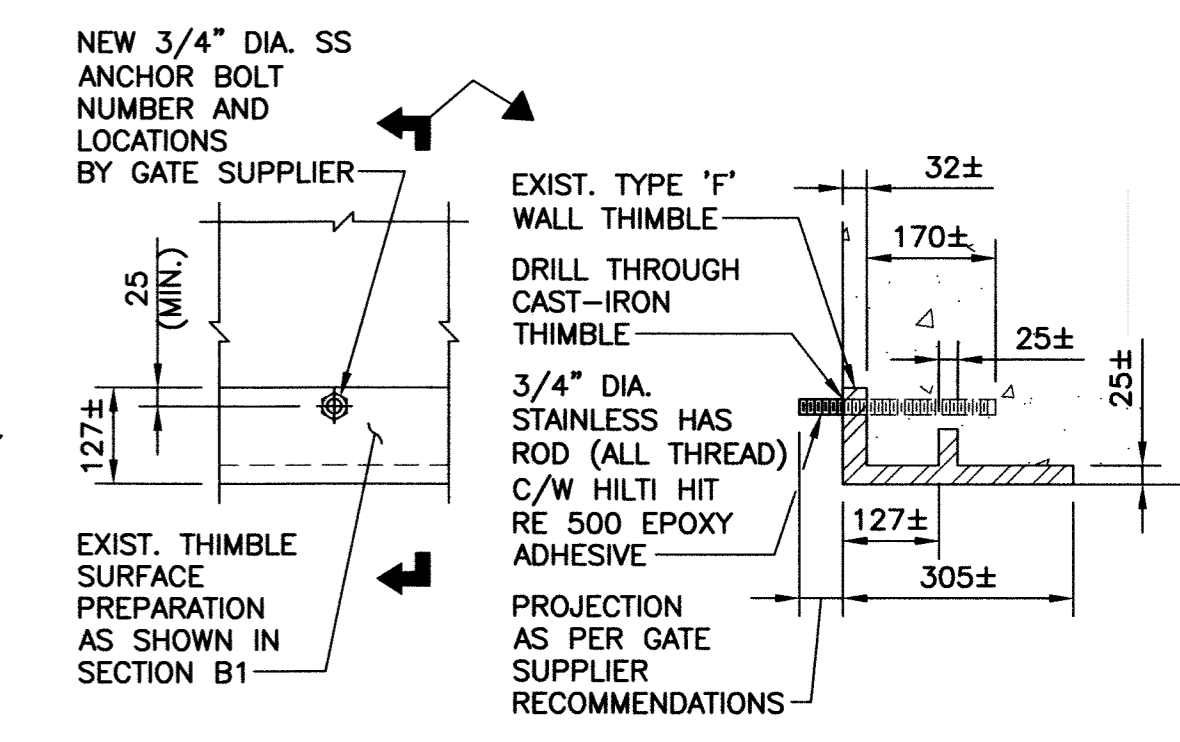


DETAIL C SCALE: 1:10

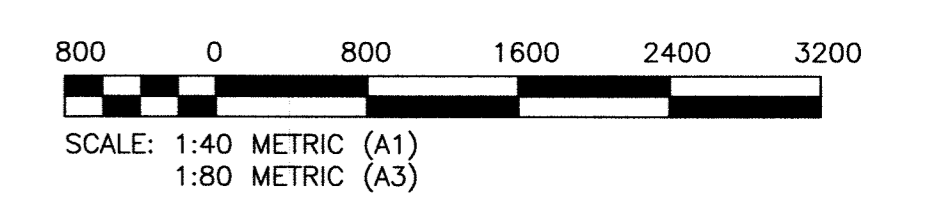

METRIC
WHOLE NUMBERS INDICATE MILLIMETRES
DECIMALIZED NUMBERS INDICATE METRES

File Name: \\k-file-2\p-data\Projects\2010\10-0107-19\Doc.Control\ToRelease\DWG\1-0149F-S0001-001.dwg - Tab: S4 Plotted By: Dberciche 08/24/2011 [Wed 1:22pm]

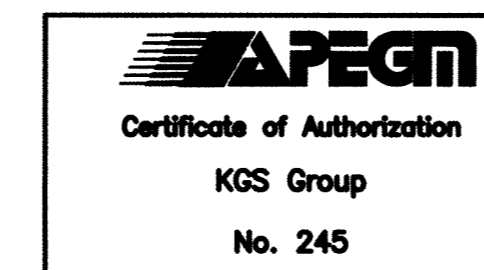

B.M. ELEV.	N/A	FIELD BOOK #	
POSTED TO LBS			
DESIGNED BY	KRD	CHECKED BY	CMS
DRAWN BY	FBV	APPROVED BY	
HOR. SCALE		RELEASED FOR CONSTRUCTION	
VERTICAL			
ISSUED FOR CONSTRUCTION	2011-08-21	CMS	
NO. REVISIONS		DATE	BY
		2011-03-01	

KGS GROUP
CONSULTING ENGINEERS

DESIGNED BY: KRD
DRAWN BY: FBV
HOR. SCALE: VERTICAL
CHECKED BY: CMS
APPROVED BY: [Signature]
RELEASED FOR CONSTRUCTION: 2011-03-01

ENGINEER'S SEAL
C.M. SIEPMAN
Member 20813
2011-08-23

TENDER No. [Blank]
FILENAME: 1-0149F-S0001-001.dwg
PLOT DATE: 2011/08/24

THE CITY OF WINNIPEG
WATER AND WASTE DEPARTMENT

JESSIE FLOOD PUMPING STATION
SLIDE GATE REFURBISHMENT
STRUCTURAL
PLAN, SECTIONS & DETAILS

SHEET 1 OF 1
CITY DRAWING NUMBER
1-0149F-S0001-001