

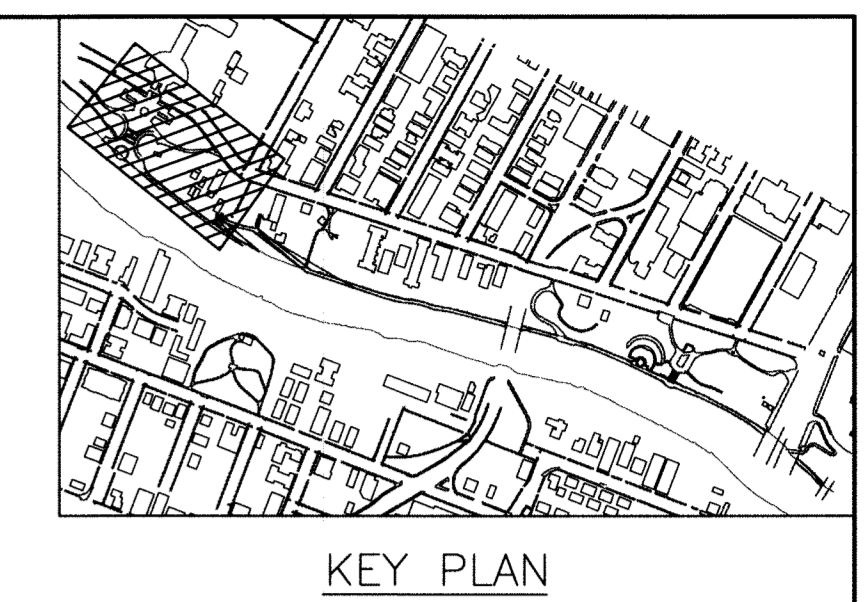


plot scale = 1:1 (metric)  
 sheet size = Super A1 (24 x 36 in)  
 CAD File Name: 10-0105-10\_e03.dwg 1.dwg

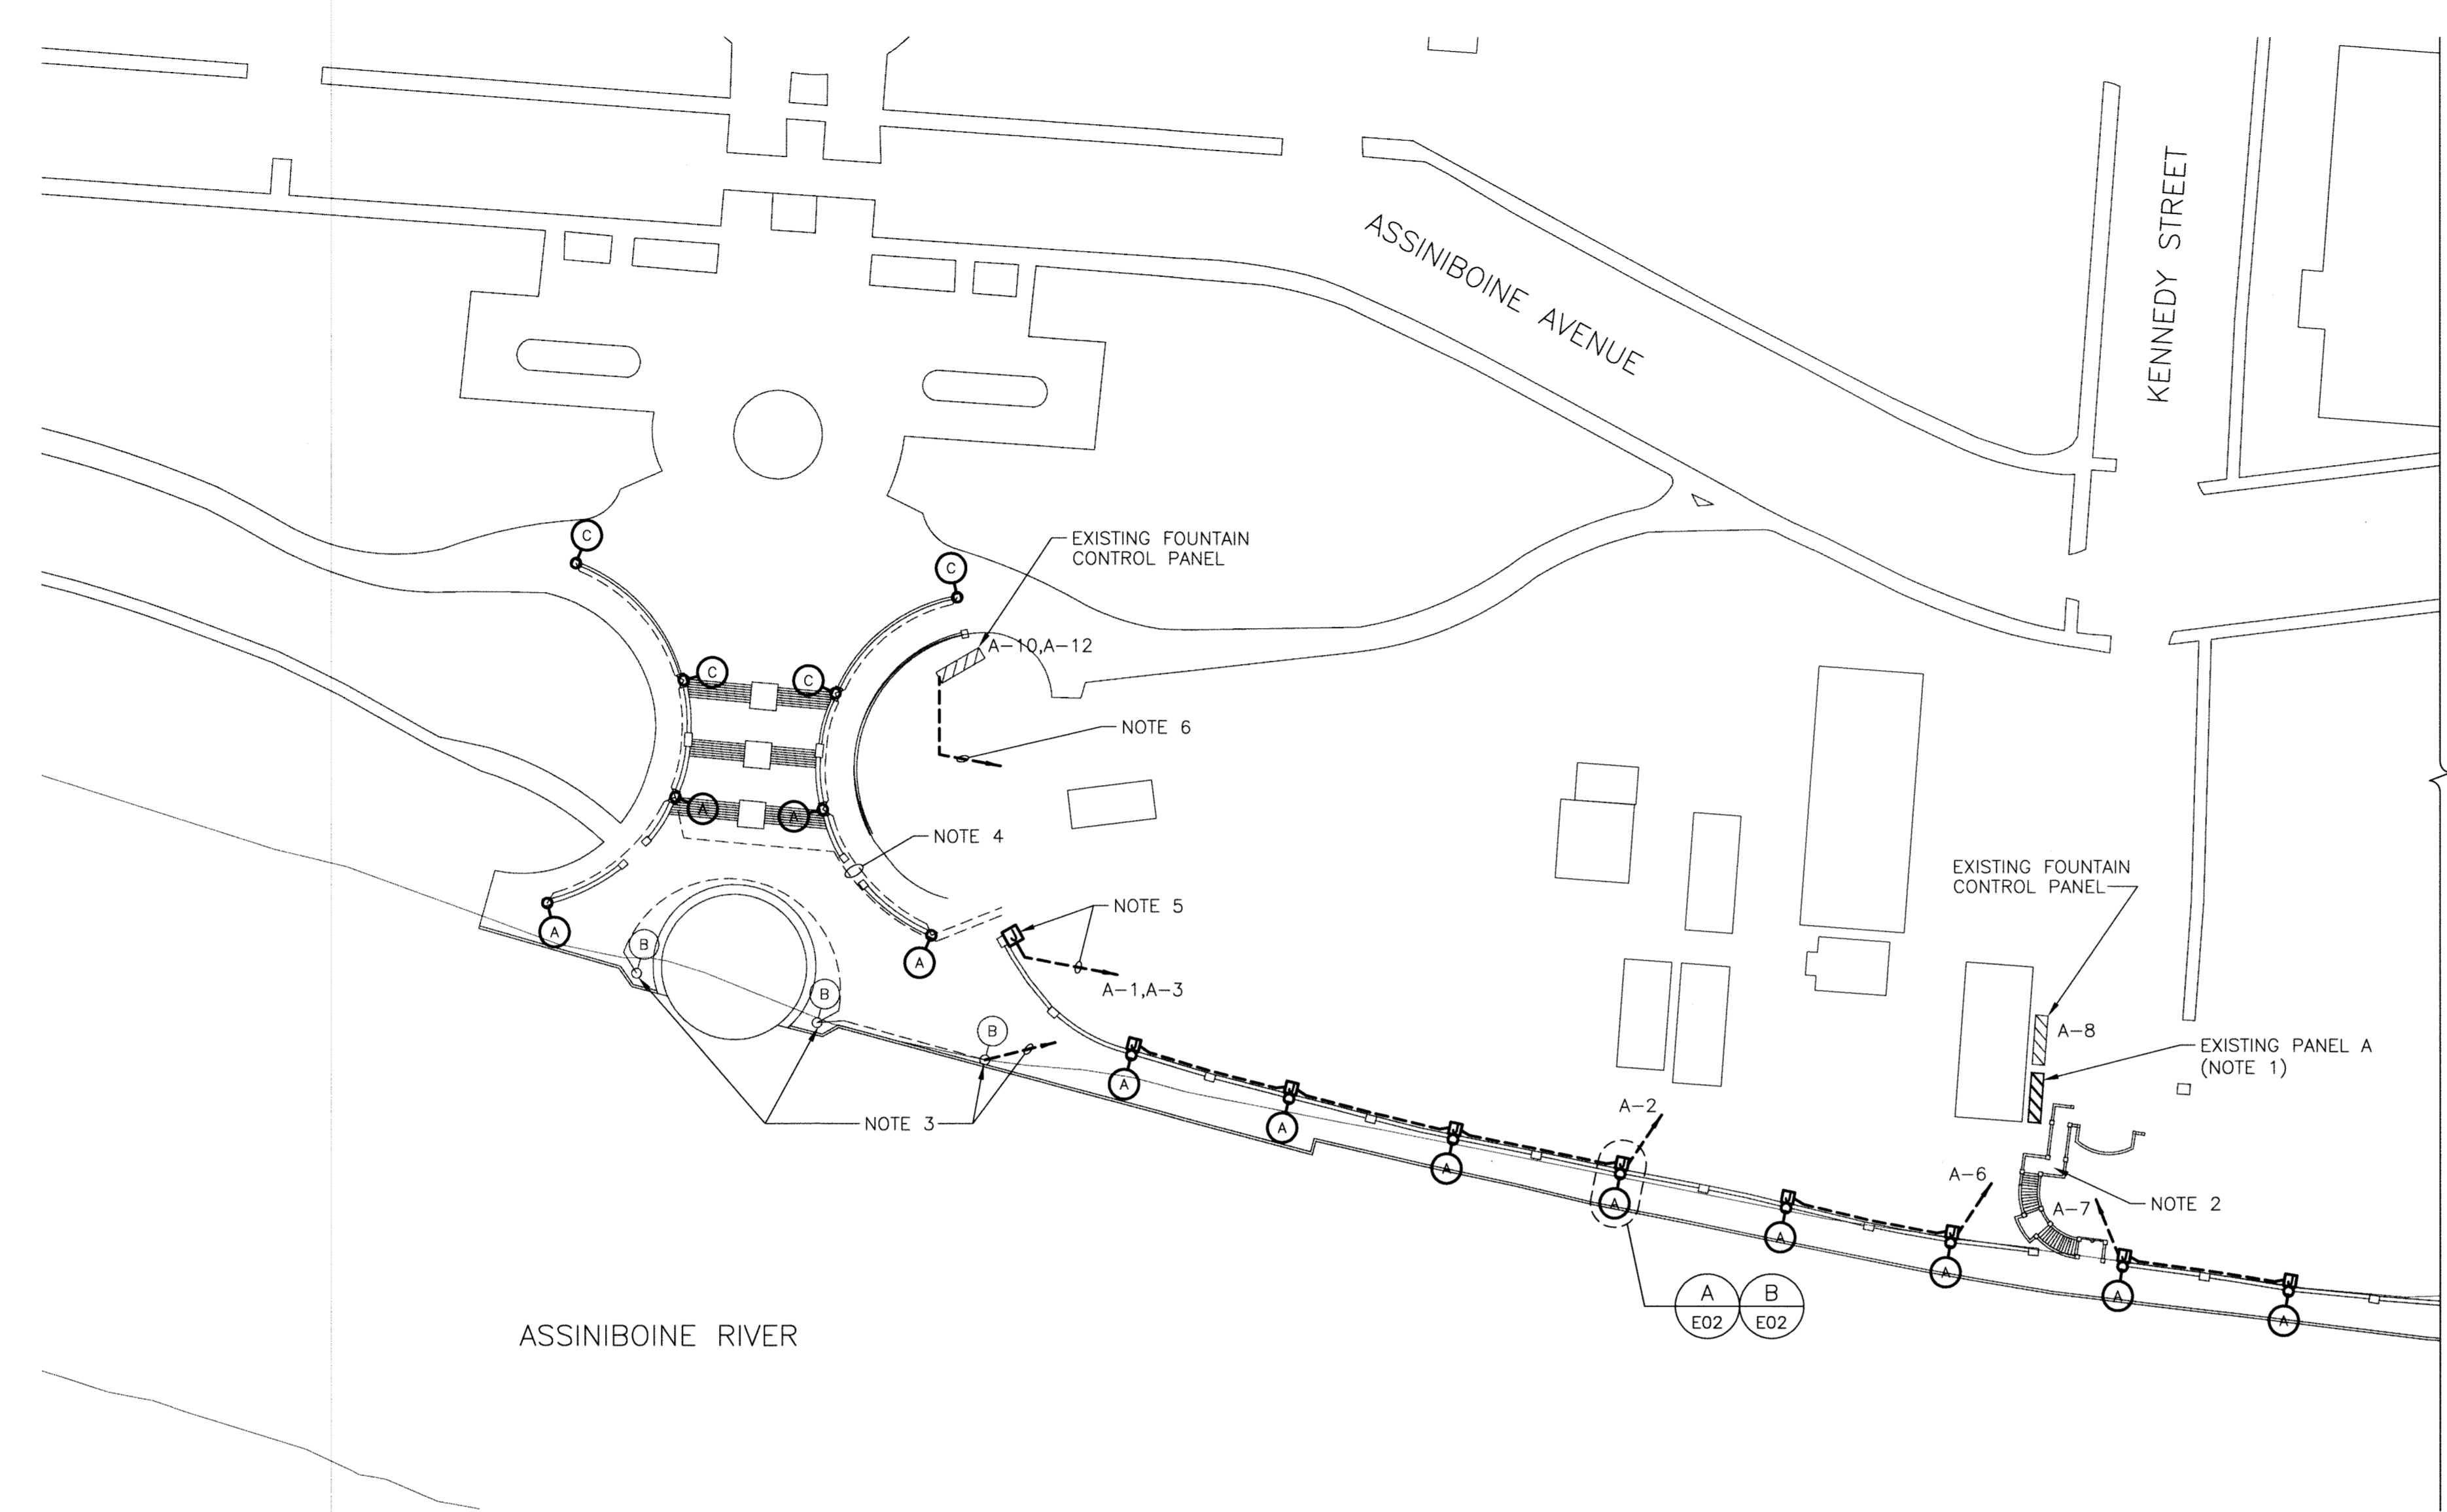

FOR CONTINUATION SEE DWG E04

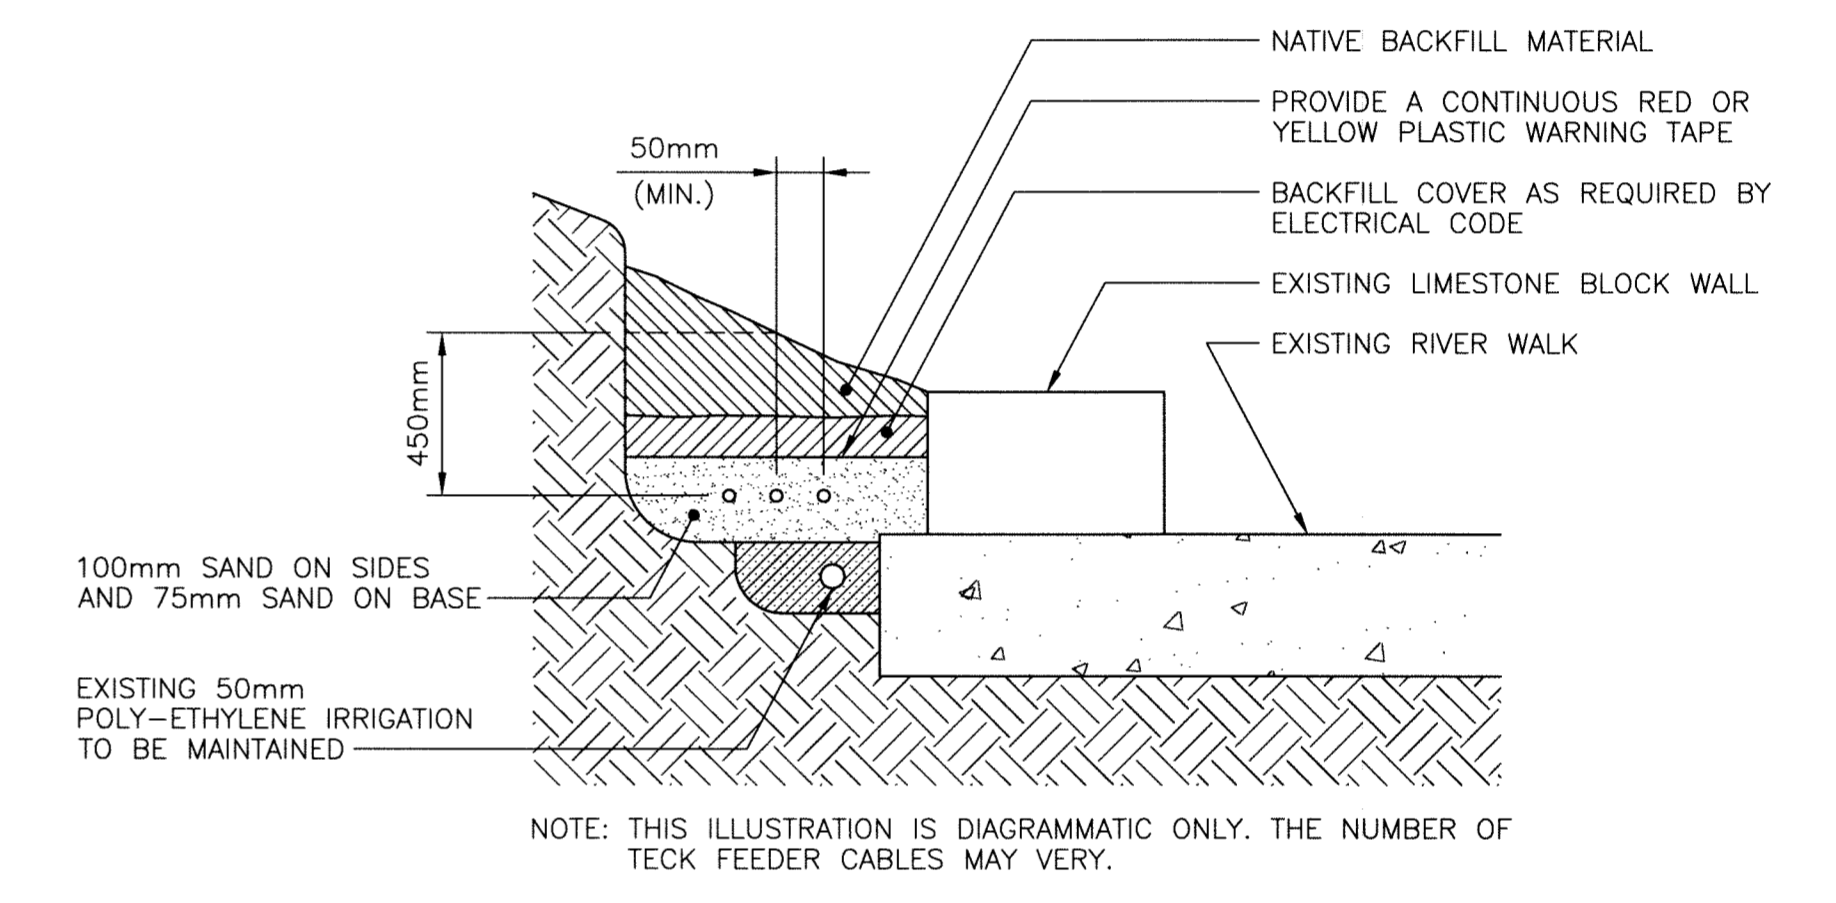

TYPICAL TRENCH DETAIL

**1**  
E03 PARTIAL SITE PLAN - PHASE A  
SCALE = 1 : 600



**NOTES**

1. EXISTING PANEL TO REMAIN. CONTRACTOR TO RE-USE ALL BREAKERS AS REQUIRED TO RE-FEED THE EXISTING AND NEW LIGHT FIXTURES.
2. EXISTING STEP LIGHTS TO REMAIN. STEP LIGHTS FEED OUT OF PANEL A ON CIRCUIT BREAKER #4.
3. EXISTING DOCK LIGHT FIXTURE NO LONGER IN SERVICE. FIXTURES FEED OUT OF PANEL A ON CIRCUIT BREAKER #5. CONTRACTOR TO REMOVE CABLING AND MAKE SAFE. BREAKER TO BE MARKED SPARE.
4. EXISTING CABLING UNDER CONCRETE DOCK TO REMAIN.
5. PROVIDE A NEW WATERTIGHT JUNCTION BOX TO PICKUP EXISTING POWER CIRCUITS. EXTEND NEW FEEDERS TO PANEL A AS REQUIRED. JUNCTION BOX TO BE MOUNTED TO THE BACK OF LIMESTONE BLOCK WALL. EXACT LOCATION TO BE DETERMINED ON SITE WITH ENGINEER.
6. EXISTING CABLING FOR FOUNTAIN CONTROL PANEL TO REMAIN.
7. REFER TO CABLE SPECIFICATION FOR FEEDER DETAILS AND REQUIREMENTS.
8. REFER TO DRAWING E02 FOR JUNCTION BOX SPECIFICATION.
9. REFER TO THE TYPICAL TRENCH DETAIL FOR MINIMUM REQUIREMENTS.

FIXTURE SCHEDULE			
TYPE	DESCRIPTION	WATTAGE	APPROVED MANUFACTURERS
A	EXISTING LIGHT FIXTURES TO BE FIXED WITH A NEW TWIST LOCK CONNECTOR	1-70W MH	EXISTING
B	EXISTING FIXTURES NO LONGER IN SERVICE	1-70W MH	EXISTING
C	EXISTING LIGHT FIXTURES TO REMAIN WITH EXISTING WIRE CONNECTIONS.	1-70W	EXISTING

**LEGEND**

- U/G HYDRO CABLE
- NEW 120V FEEDER CABLES (NOTE 7)
- POLE MOUNTED LIGHTING FIXTURE
- ELECTRICAL PANEL
- JUNCTION BOX (NOTE 8)

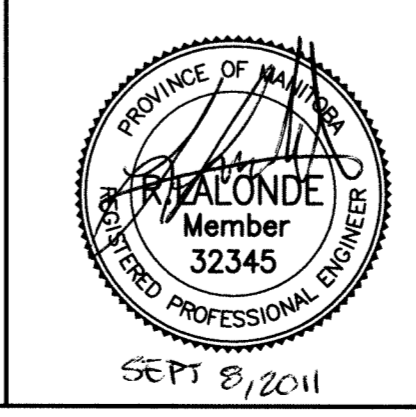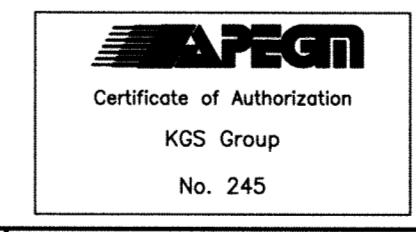

**THE CITY OF WINNIPEG**  
 PLANNING PROPERTY AND DEVELOPMENT  
**SCATLIFF + MILLER + MURRAY Inc.**  
 TEL 204 957-3444  
 FAX 204 957-3443  
 8 - 138 MARKET AVENUE  
 WINNIPEG, MB, CANADA

PROJECT		ASSINIBOINE RIVERWALK ELECTRICAL UPGRADES	
TITLE		PHASE A LIGHTING PLAN	
DESIGN	DRAWN	DATE - Y / M / D	SCALE
JLL	BGO	10/08/31	N.T.S.
CHECKED	APPROVED	PROJECT NO.	DRAWING NO.
CPS	JLL	0000	E03

REV	YY / MM / DD	DESCRIPTION	BY
1	11/09/08	RE-ISSUED FOR BID OPPORTUNITY	
0	10/09/22	ISSUED FOR BID OPPORTUNITY	

NOTES: