



sheet no. Super A124 186 in
 10/01/08-10_044-Rev 1.dwg

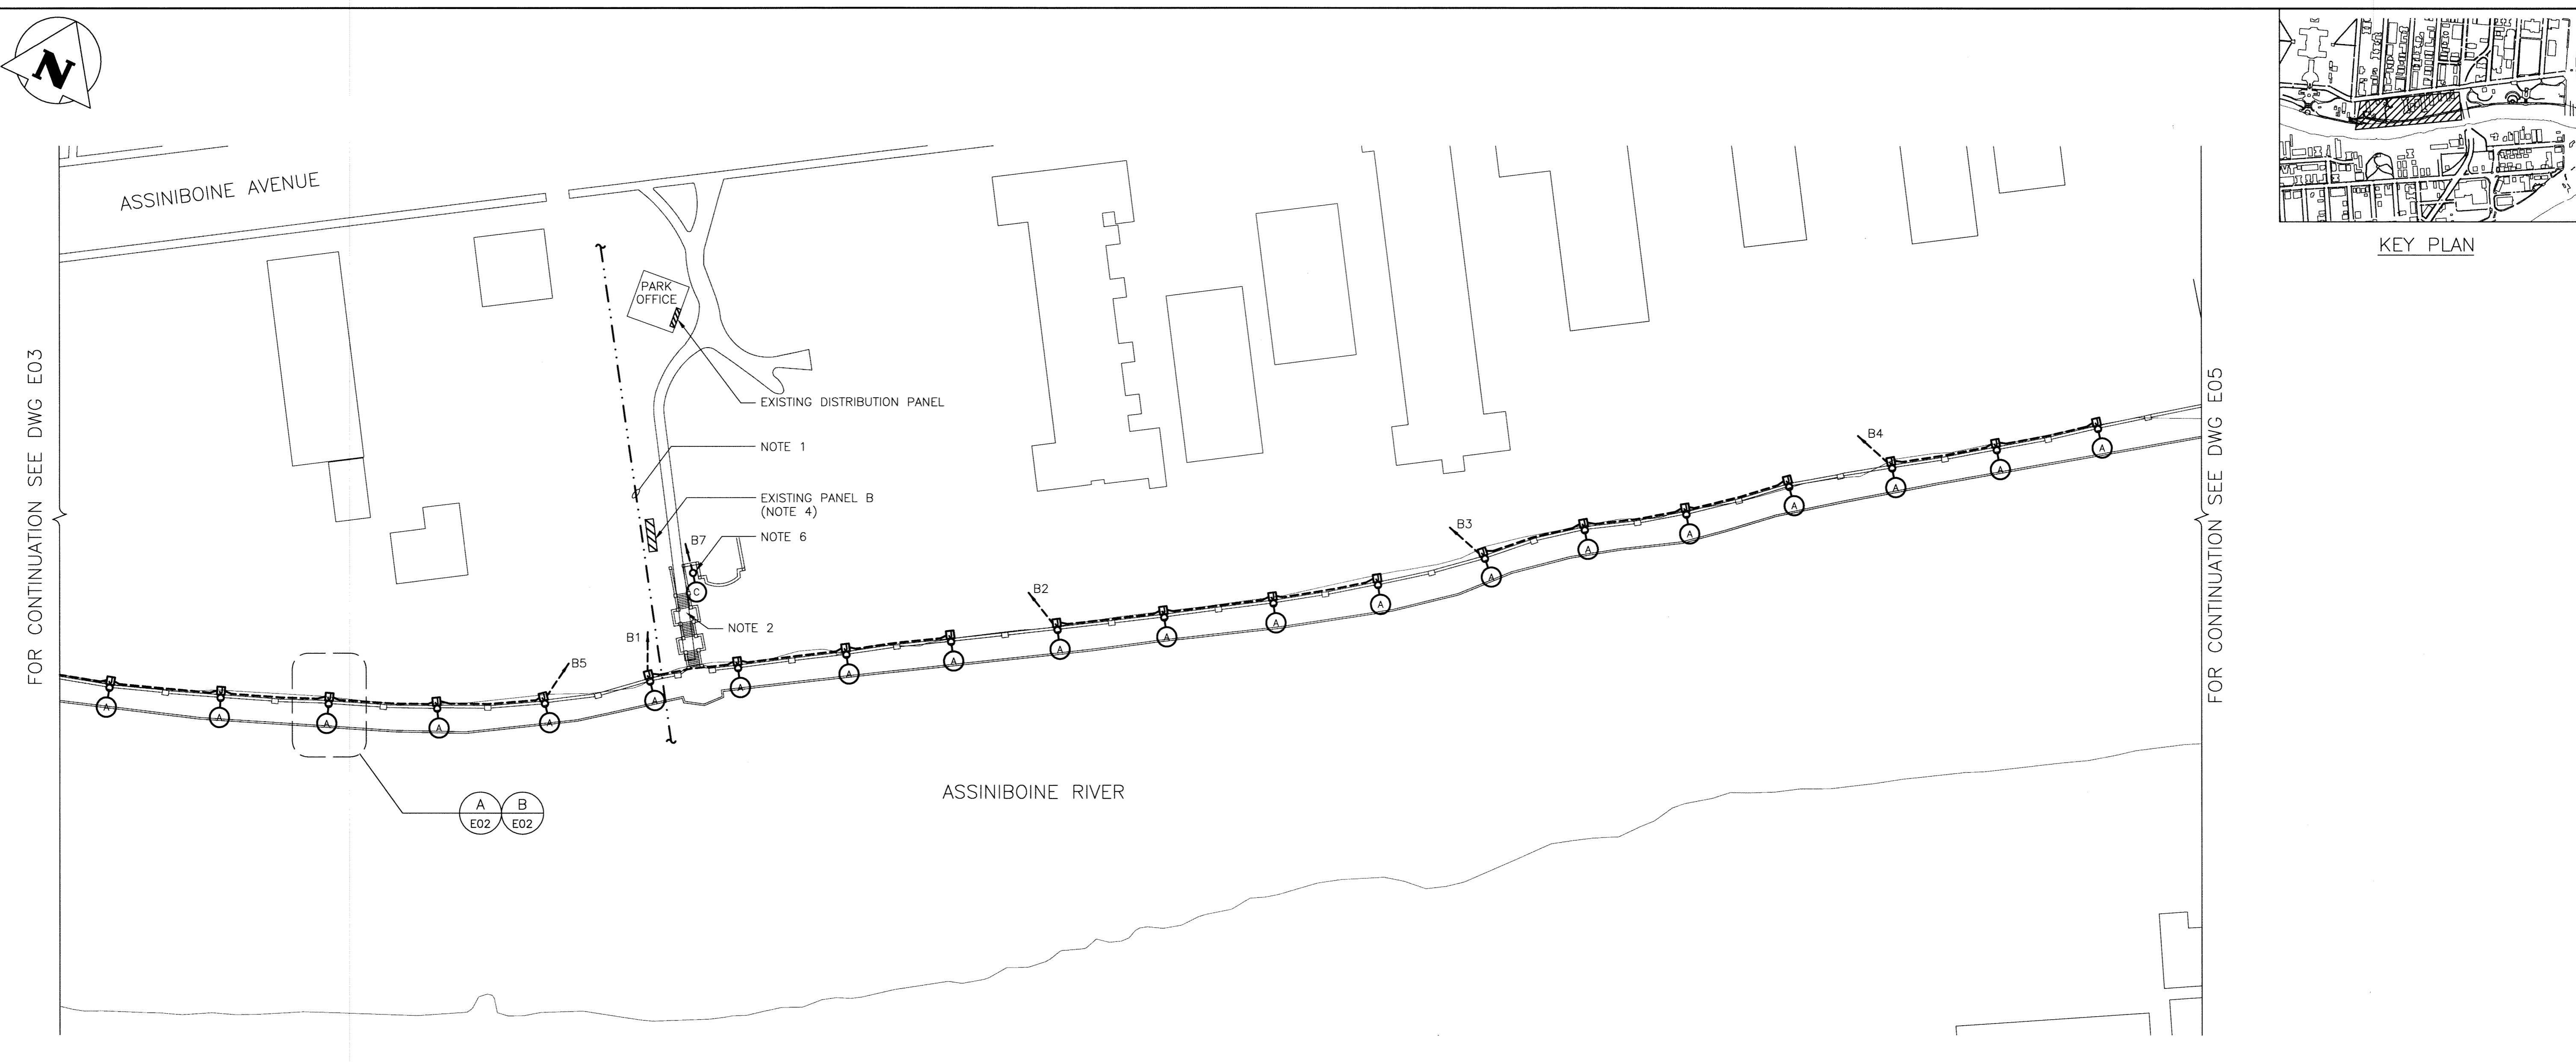

- NOTES:**
- EXISTING HYDRO UNDERGROUND HIGH VOLTAGE CABLE SYSTEM. CONTRACTOR TO COORDINATE EXACT CABLE LOCATION ON SITE WITH MANITOBA HYDRO PRIOR TO ANY TRENCHING.
 - EXISTING STEP LIGHTS TO REMAIN. STEP LIGHTS FEED OUT OF PANEL "B" ON CIRCUIT BREAKER #6.
 - REFER TO CABLE SPECIFICATION FOR FEEDER DETAILS AND REQUIREMENTS.
 - EXISTING PANEL TO REMAIN. CONTRACTOR TO RE-USE ALL BREAKERS AS REQUIRED TO RE-FEED THE EXISTING AND NEW LIGHT FIXTURES.
 - REFER TO DRAWING E02 FOR JUNCTION BOX SPECIFICATION.
 - EXISTING FEEDER CABLE TO REMAIN.
 - REFER TO THE TYPICAL TRENCH DETAIL FOR MINIMUM REQUIREMENTS.

1
E04 PARTIAL SITE PLAN - PHASE B
 SCALE = 1 : 600


- LEGEND**
- U/G HYDRO CABLE
 - NEW 120V FEEDER CABLES (NOTE 3)
 - A POLE MOUNTED LIGHTING FIXTURE
 - ▨ ELECTRICAL PANEL
 - JUNCTION BOX (NOTE 5)

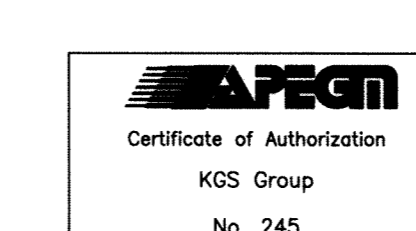

NOTES:

REV	YY / MM / DD	DESCRIPTION	BY
1	11/09/08	RE-ISSUED FOR BID OPPORTUNITY	JLL
0	10/09/22	ISSUED FOR BID OPPORTUNITY	JLL

A	B
SECTION LETTER OR DETAIL NUMBER, DRAWING WHERE SECTION OR DETAIL IS DRAWN.	SECTION LETTER OR DETAIL NUMBER, DRAWING WHERE SECTION OR DETAIL IS INDICATED.
OR	SECTION OR DETAIL SHOWN ON SAME DRAWING.

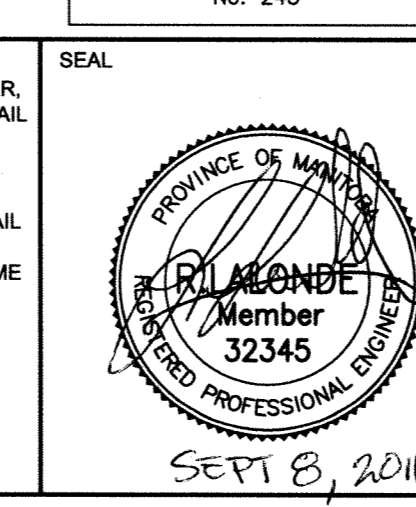

THE CITY OF WINNIPEG
 PLANNING PROPERTY AND DEVELOPMENT
SCATLIFF + MILLER + MURRAY inc.
 TEL 204 927-3444
 8-136 MARKET AVENUE
 WINNIPEG, MB, CANADA

PROJECT ASSINIBOINE RIVERWALK ELECTRICAL UPGRADES			
TITLE PHASE B LIGHTING PLAN			
DESIGN JLL	DRAWN BGO	DATE - Y/M/D 10/08/31	SCALE N.T.S.
CHECKED CPS	APPROVED JLL	PROJECT NO. 0000	DRAWING NO. E04