


1 MAIN FLOOR EQUIPMENT
E1 SCALE 1 : 50

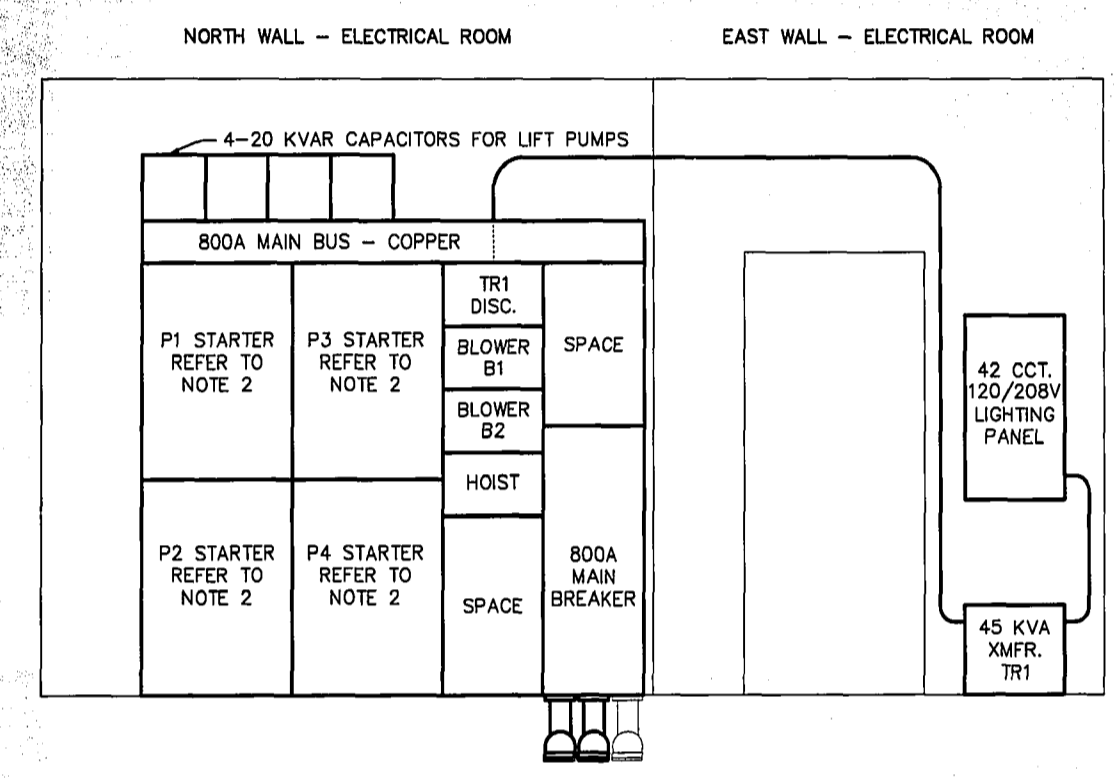

NOTE: 1. REFER TO DRAWING NO. E2-A FOR SINGLE LINE DIAGRAM.
2. SC-#14 FOR EACH PUMP (P1 TO P4) STARTER TO THE CONTROL PANEL LOCATED ON THE "PUMP MOTOR ROOM" LEVEL LOCATED TWO LEVELS BELOW THE ELECTRICAL ROOM.

2 MCC ELEVATION
E1 SCALE 1 : 25

REID, CROWTHER & PARTNERS LIMITED
WINNIPEG
RECORD DRAWING
SIG. DATE DECEMBER 1996

				ENGINEER'S SEAL ORIGINAL SIGNED BY P. STRYK 96-01-31		THE CITY OF WINNIPEG WORKS AND OPERATIONS DIVISION WATER AND WASTE DEPT.	
DESIGNED BY PS CHECKED BY PS DRAWN BY CPG APPROVED BY				REGIONAL OPERATIONS		CITY DRAWING NUMBER 1541 SHEET 1 OF 3	
2 RECORD DRAWING 12/96 PS 1 ISSUED FOR TENDER 02/96 PS NO. REVISIONS DATE BY DATE 96-01-18 DATE 96-10-17				HON. SCALE: AS NOTED RELEASED FOR		CONSULTANT DRAWING NO. 61776 - E1	
MONTCALM SEWAGE PUMPING STATION ELECTRICAL ROOM EQUIPMENT ELEVATIONS, FLOOR PLANS						E1	