



THIS DRAWING MUST NOT BE SCALED.  
 THE GENERAL CONTRACTOR SHALL VERIFY ALL DIMENSIONS, DATINGS, AND LEVELS PRIOR TO COMMENCEMENT OF WORK. ALL ERRORS AND OMISSIONS TO BE REPORTED TO NUMBER TEN ARCHITECTURAL GROUP BEFORE PROCEEDING.  
 VARIATIONS AND MODIFICATIONS TO WORK SHOWN ON THESE DRAWINGS SHALL NOT BE CARRIED OUT WITHOUT WRITTEN PERMISSION OF NUMBER TEN ARCHITECTURAL GROUP.  
 THIS DRAWING IS THE EXCLUSIVE PROPERTY OF NUMBER TEN ARCHITECTURAL GROUP AND THE COPYRIGHT IN THE SAME BEING RESERVED TO THEM. IT MAY BE REPRODUCED ONLY WITH THE PERMISSION OF NUMBER TEN ARCHITECTURAL GROUP, IN WHICH CASE THE REPRODUCTION MUST BEAR THEIR NAME.

REVISED/ ISSUED/ PLOTTED	DATE
Rev. 2 - RE-ISSUED FOR TENDER	MARCH 07/2012
Rev. 1 - ISSUED FOR TENDER	FEBRUARY 03/2012
Rev. 0 - ISSUED FOR TENDER	NOVEMBER 21/2011

**NOTES:**  
 1. LUTRON CABLE GRX-CBL-46L (NON-PLENUM) OR GRX-PCBL-46L (PLENUM RATED). OTHERWISE USE 2 #12AWG (2.5MM<sup>2</sup>), 1 BELDEN #9461 (OR EQUIVALENT), AND BETWEEN PANELS ADD 1 #18AWG (1.0MM<sup>2</sup>) FOR EMERGENCY SENSING.

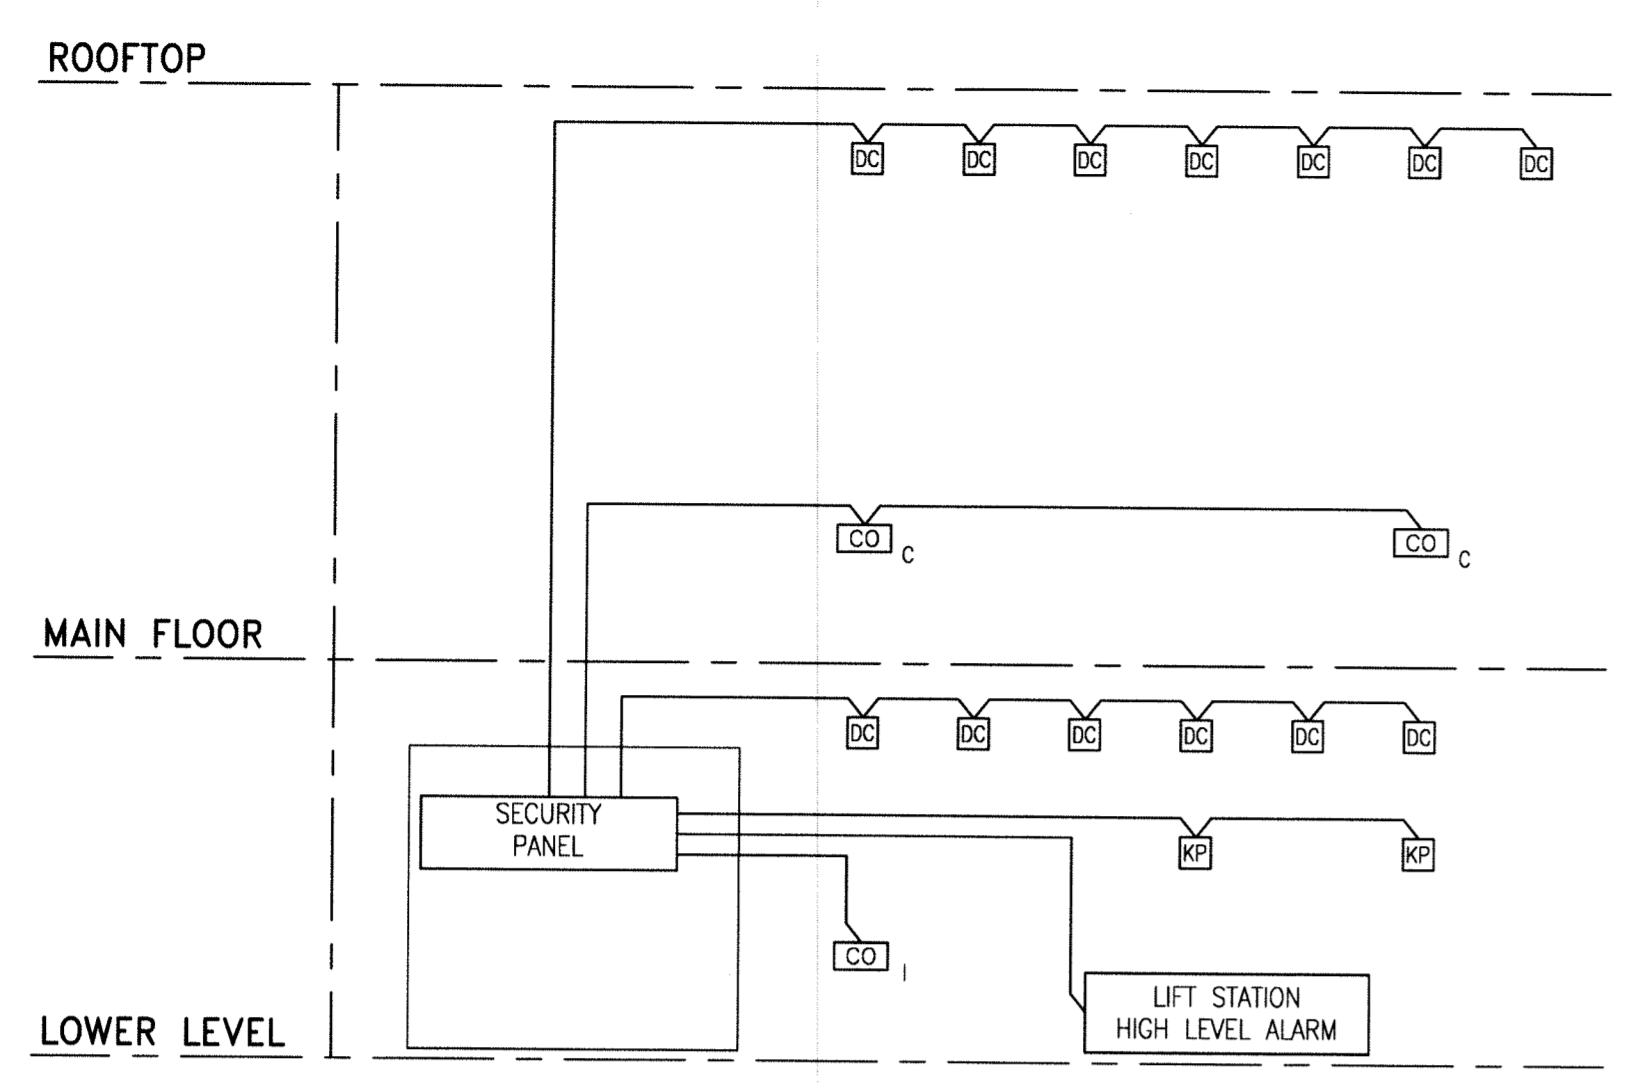


**A SECURITY RISER DIAGRAM**  
 SCALE: N.T.S.

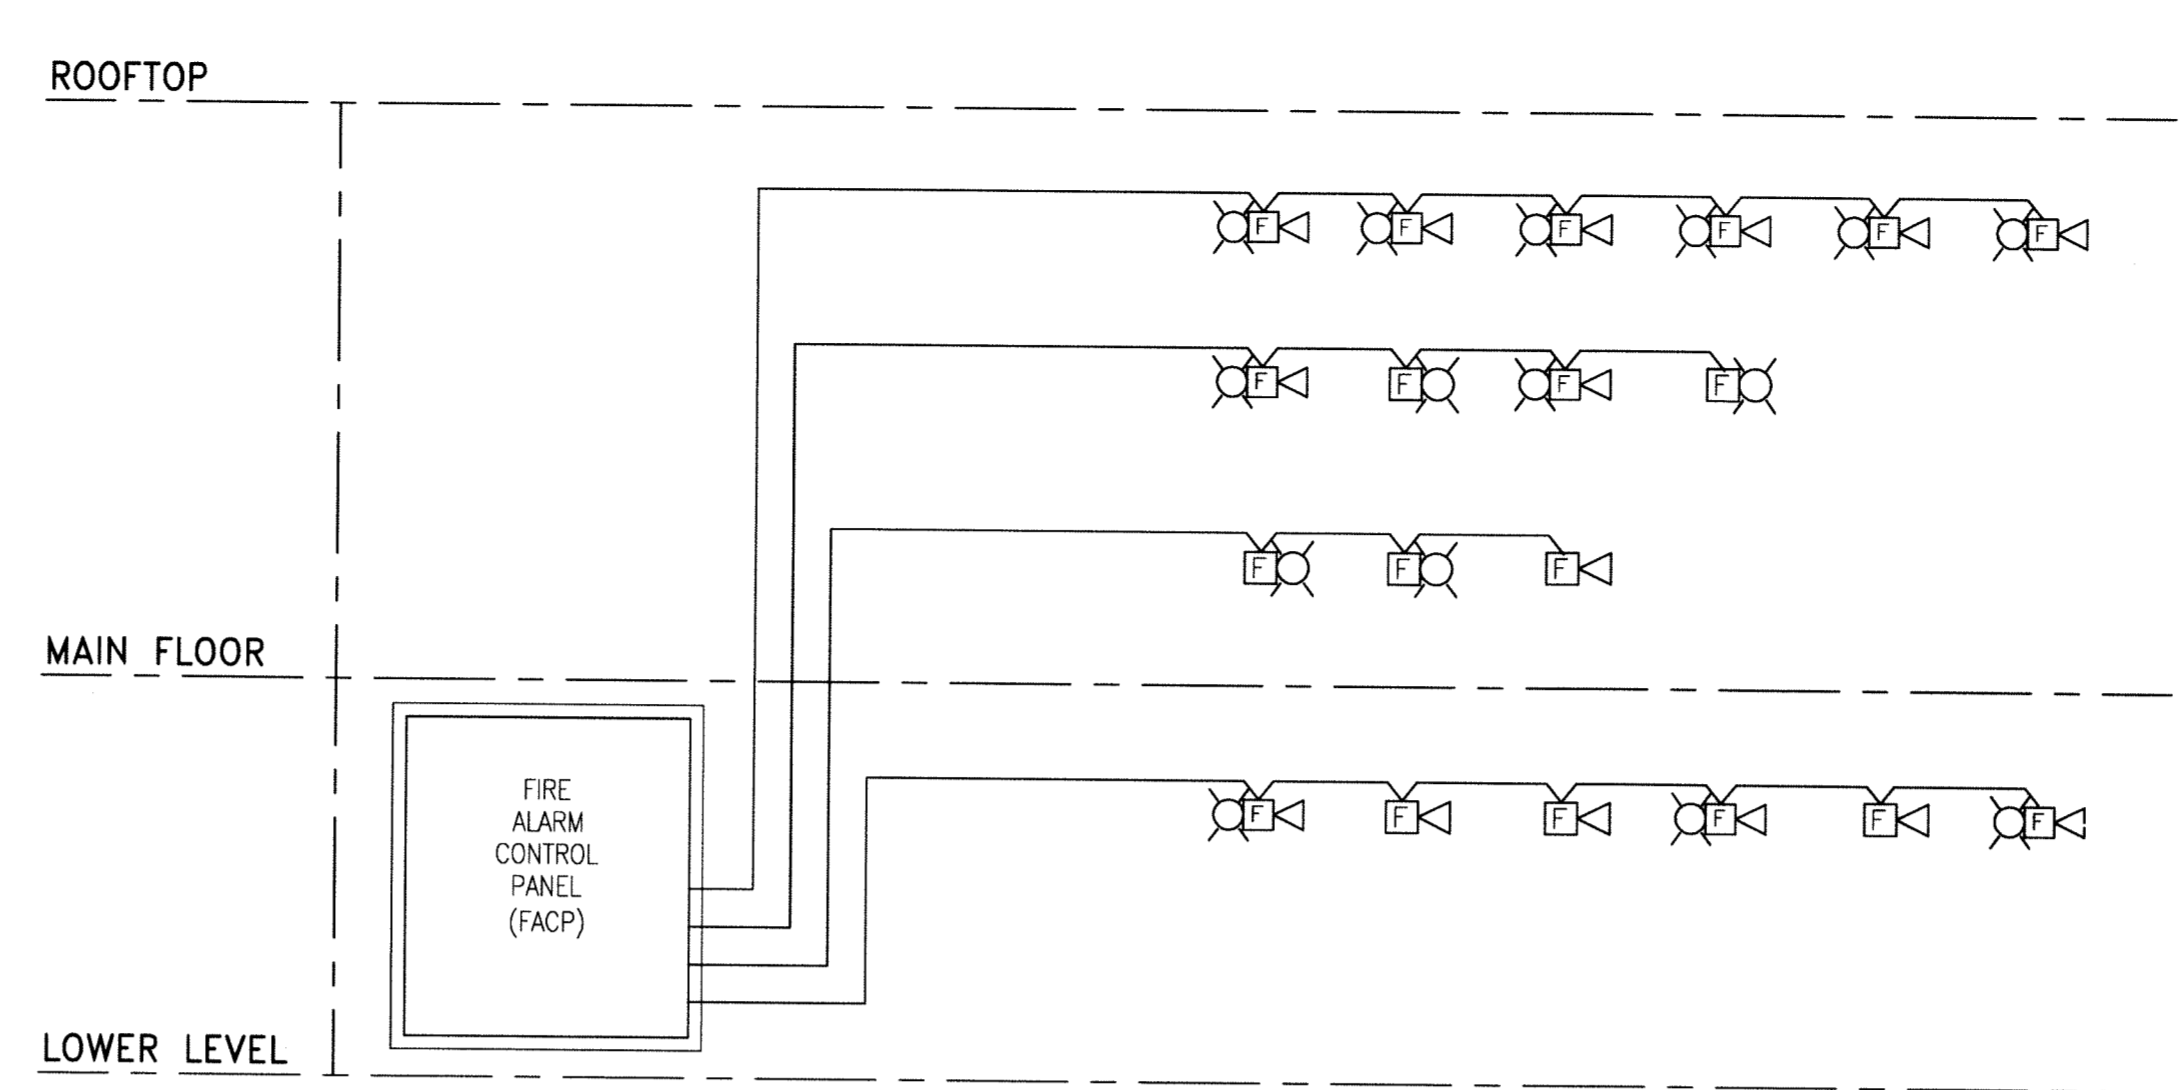


**B FIRE ALARM AUDIBLE & VISIBLE DEVICE LOOPS**  
 SCALE: N.T.S.

**DETAIL B NOTES:**  
 1. ALL LOOPS SHALL BE CLASS 'B'.

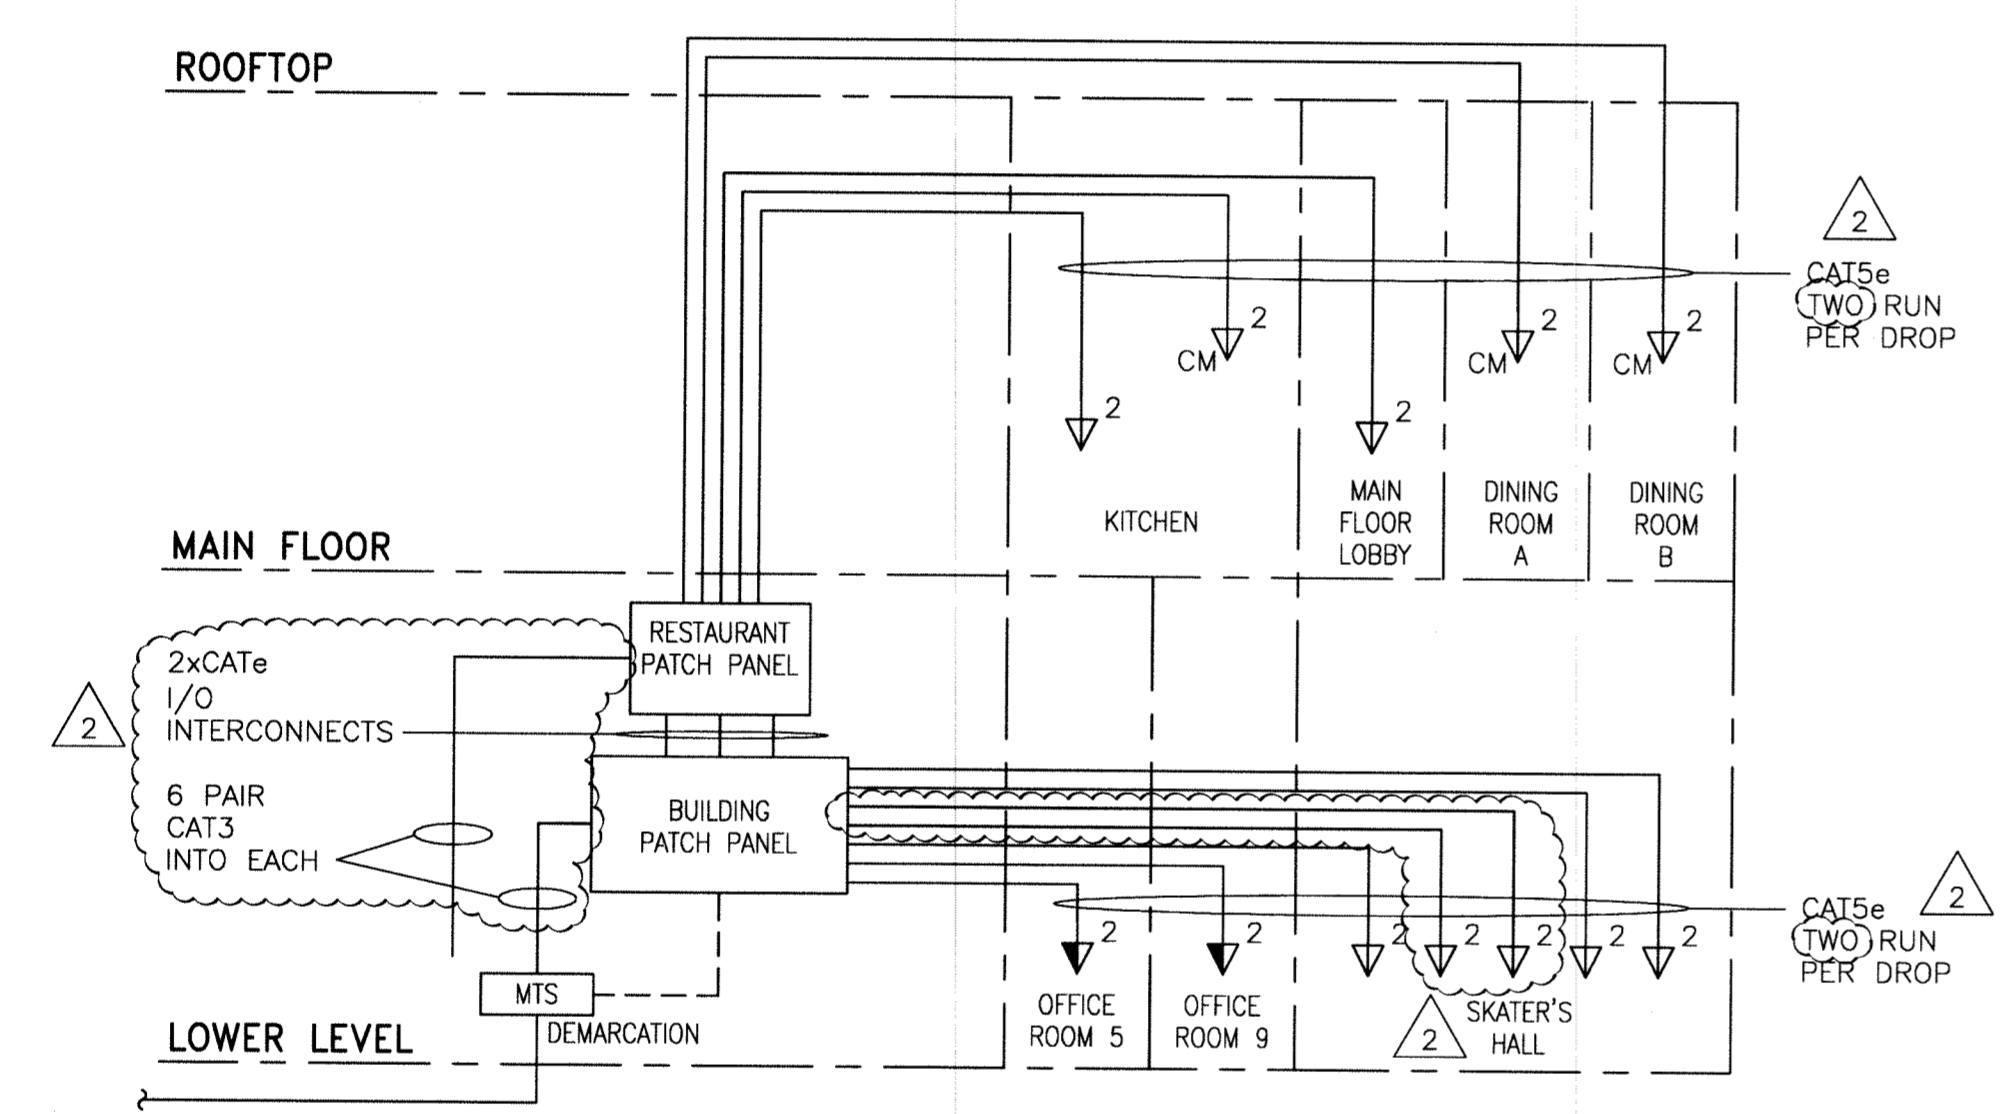


**C VOICE/DATA STRUCTURED CABLE RISER DIAGRAM**  
 SCALE: N.T.S.

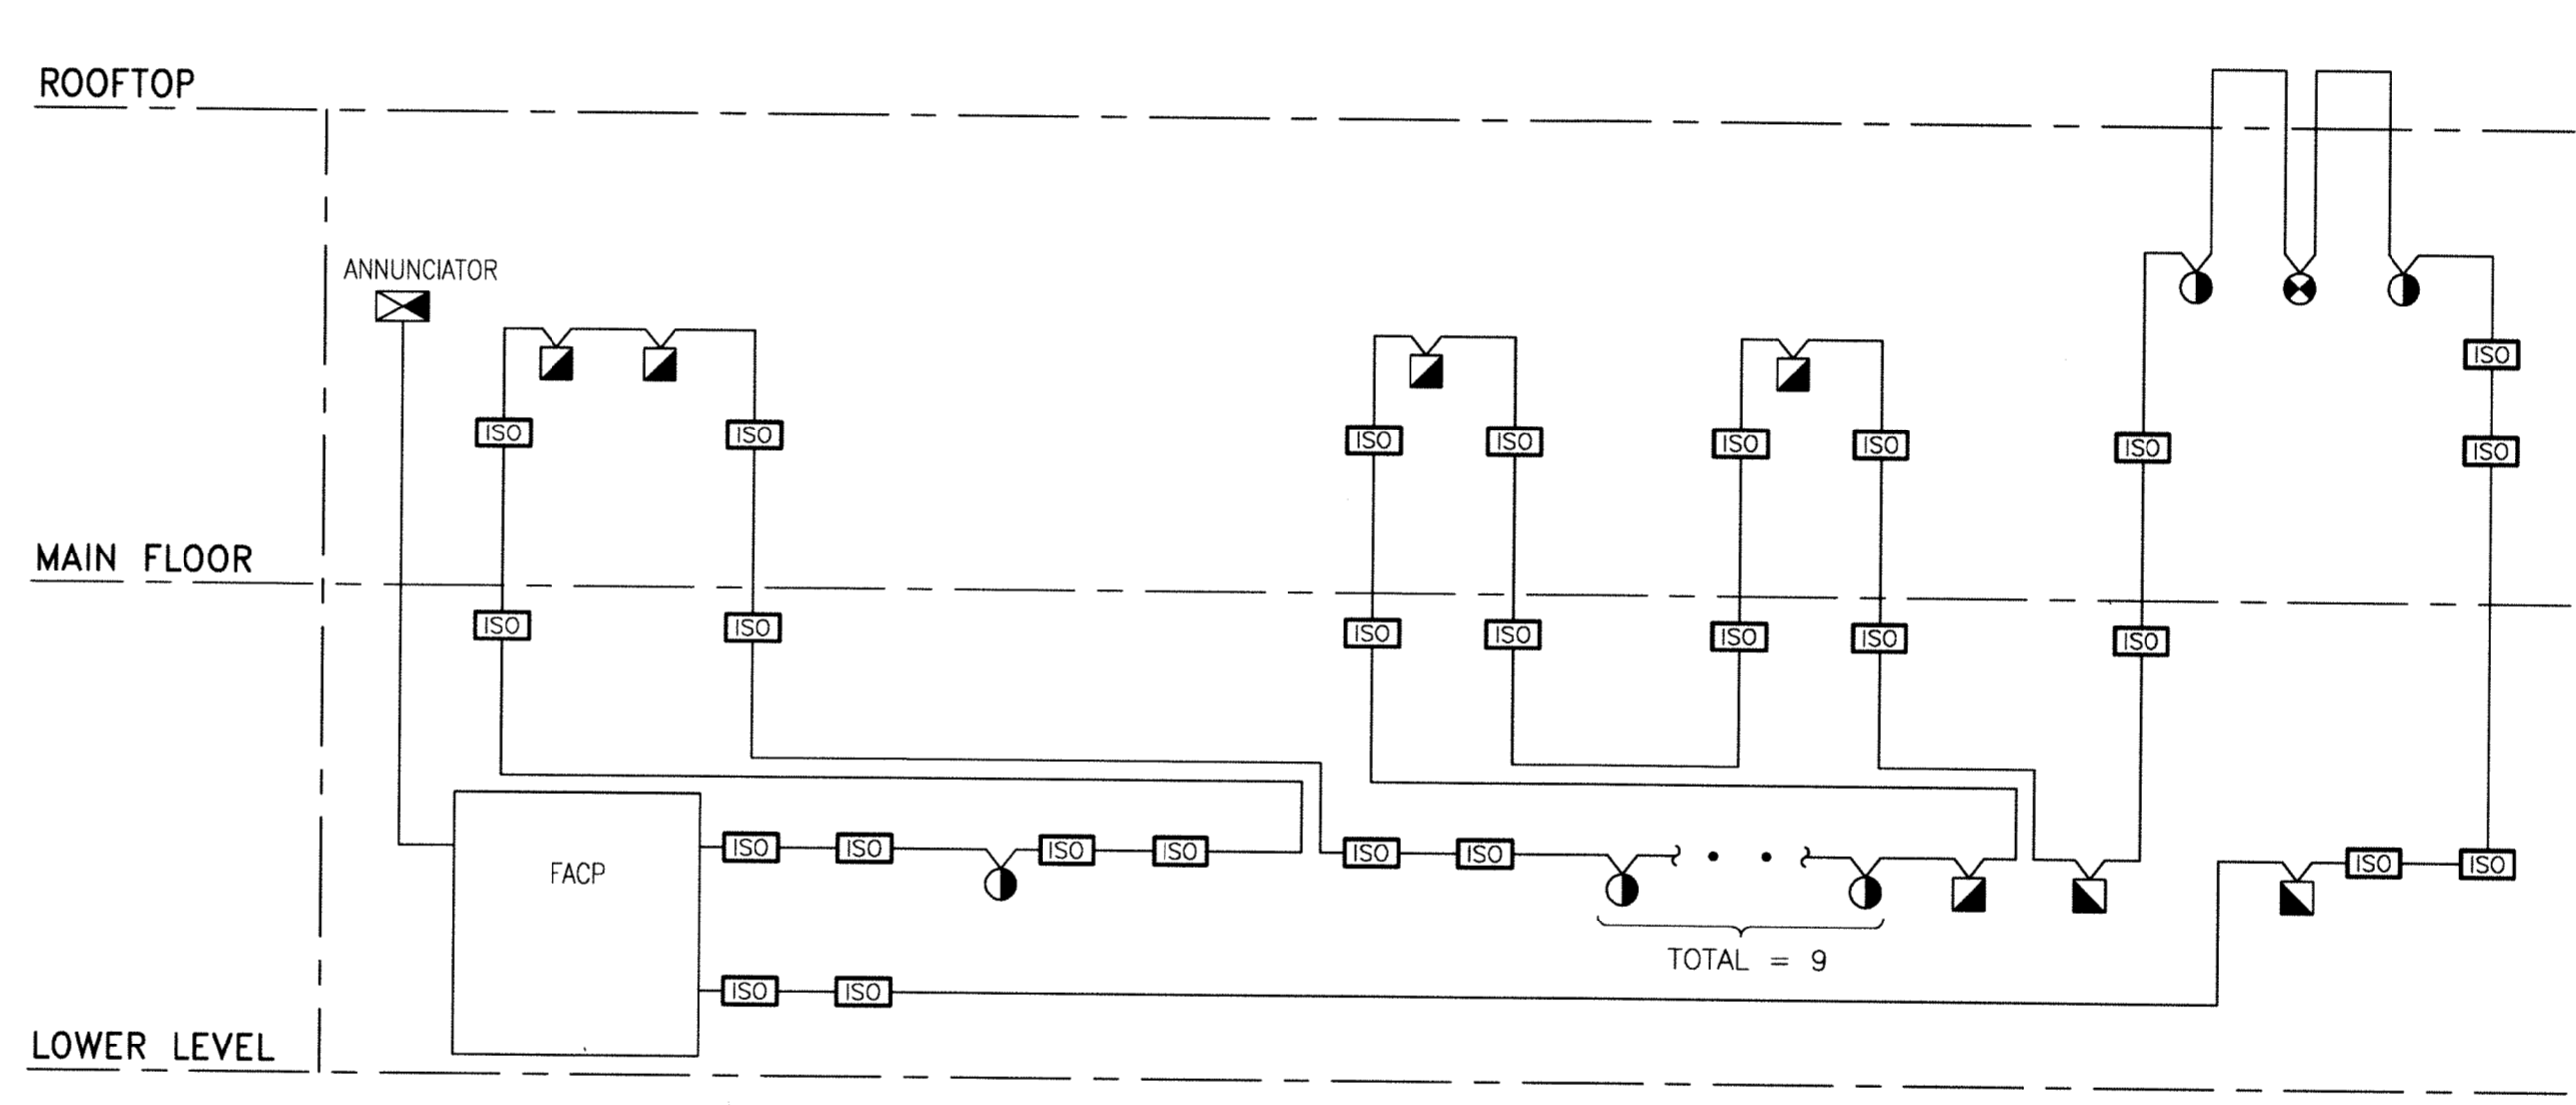


**D FIRE ALARM ADDRESSABLE DEVICE LOOPS**  
 SCALE: N.T.S.

**DETAIL D NOTES:**  
 1. ALL ADDRESSABLE DEVICES SHALL BE CLASS 'A'.

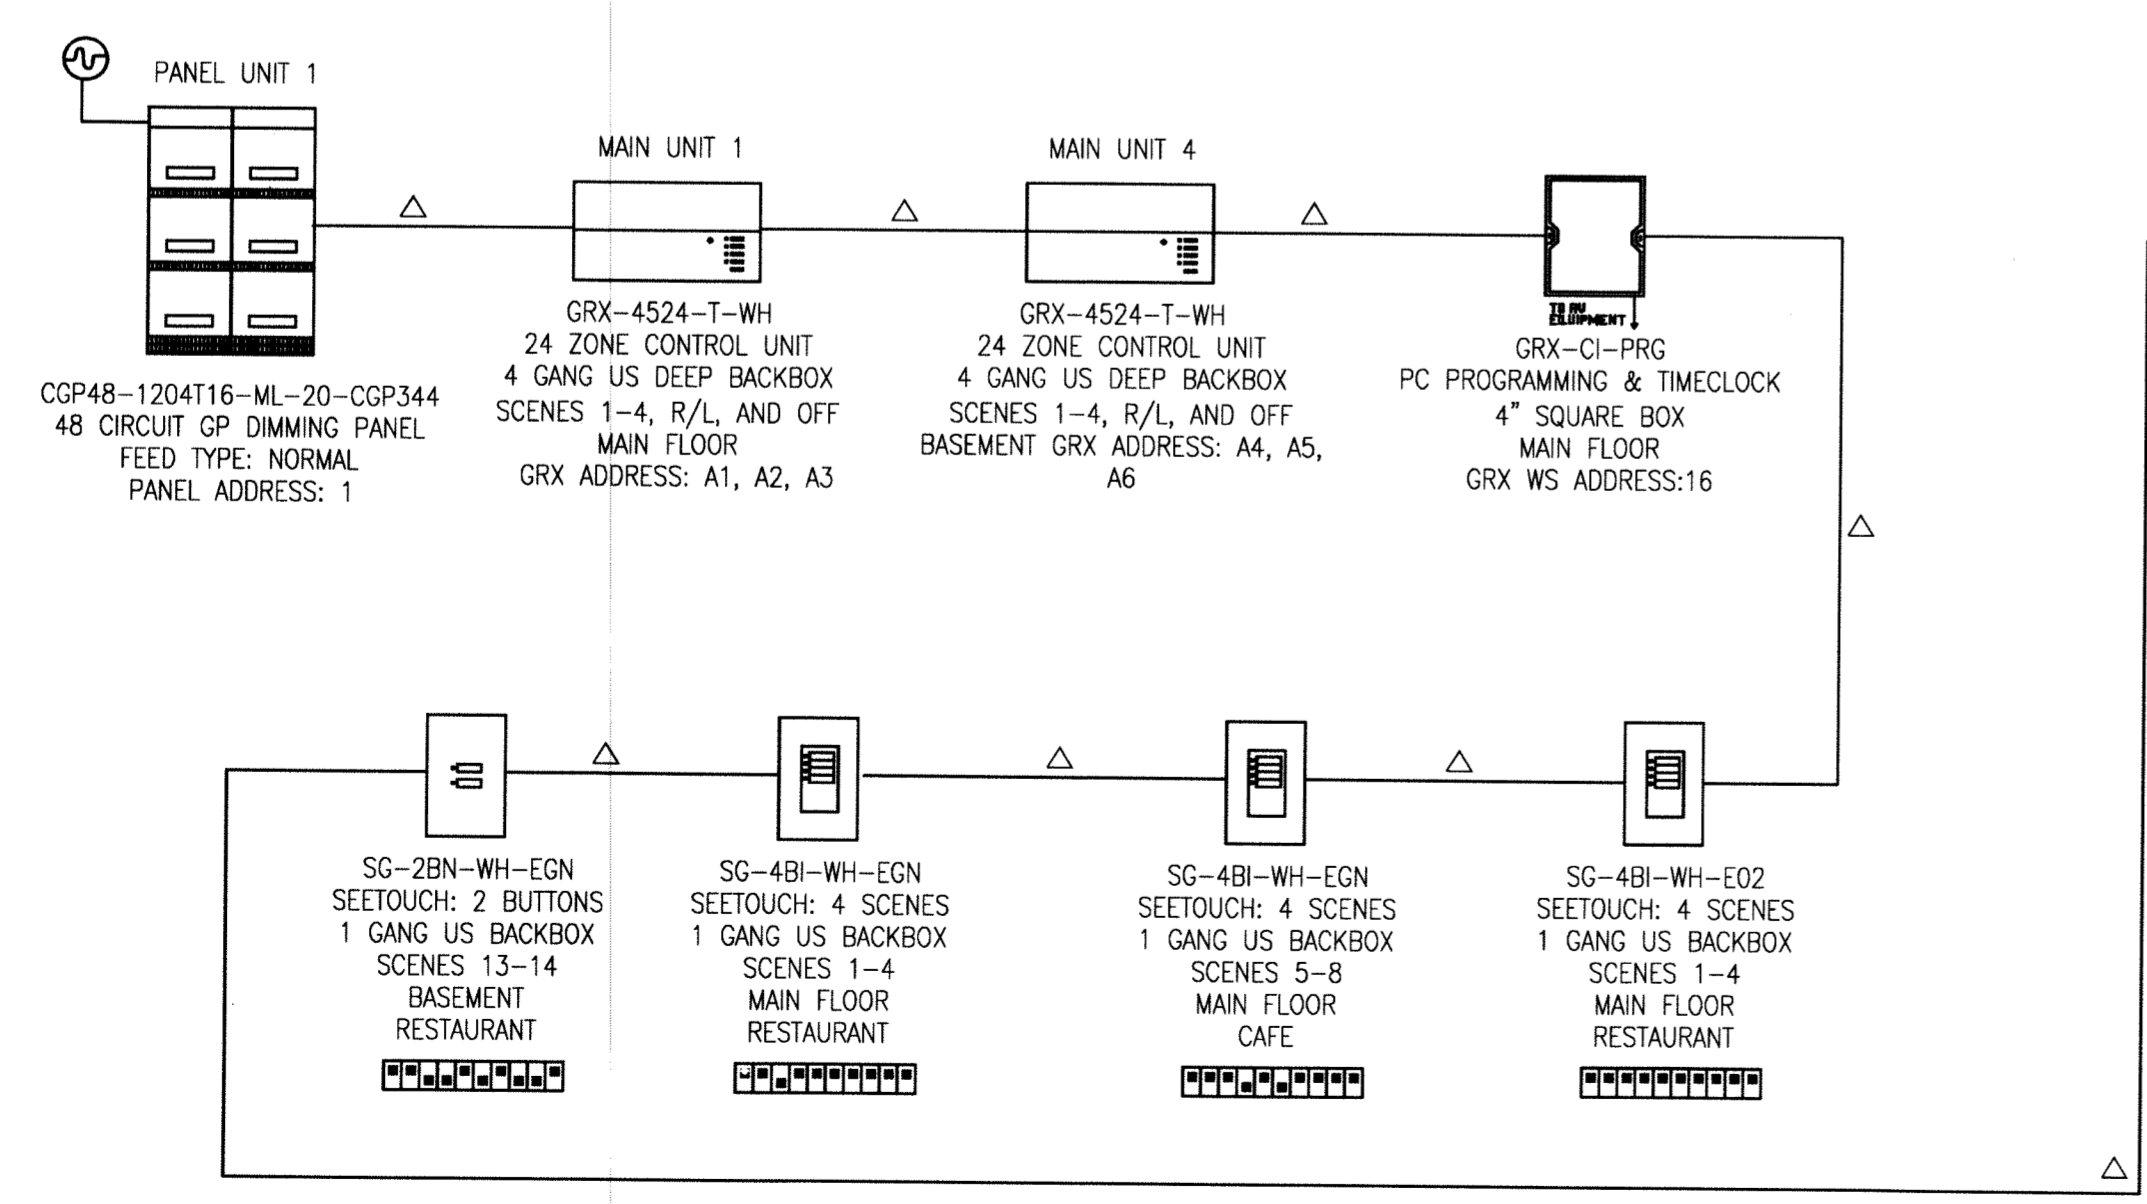

**E LIGHTING CONTROLLER RISER DIAGRAM**  
 SCALE: N.T.S.

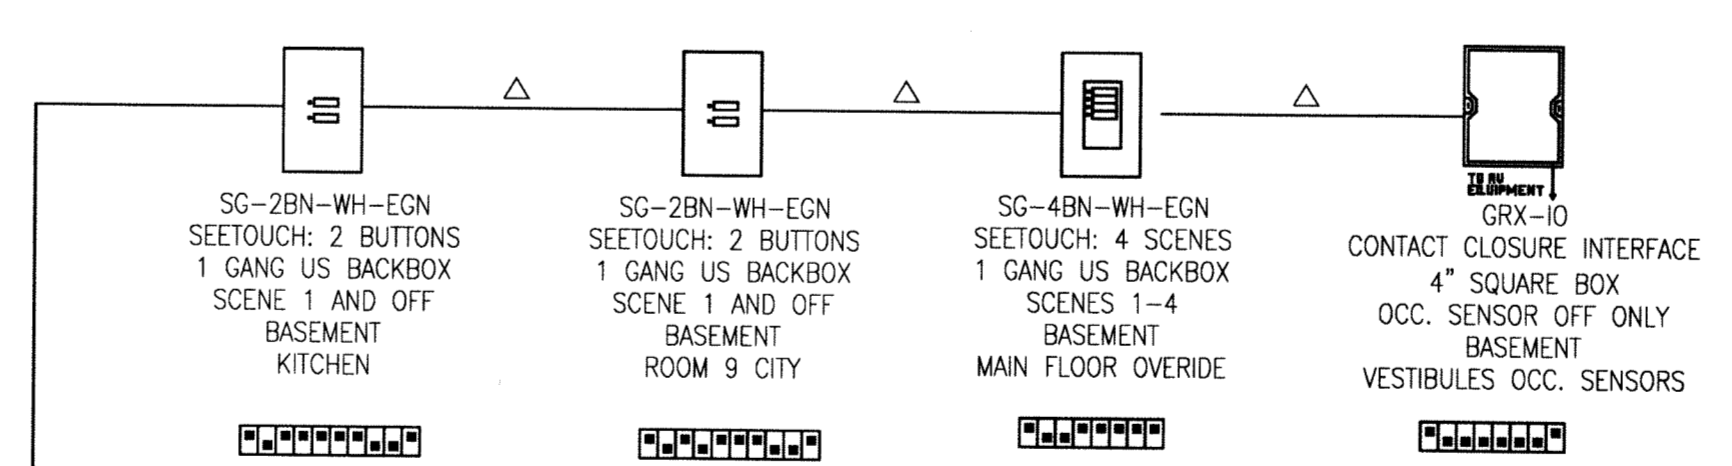

**LEGEND (DETAIL E):**  
 △ LUTRON CABLE GRX-CBL-46L (NOTE 1)  
 ⊕ MAIN FEED

**numberTEN**  
 architectural group  
 winnipeg MB regina SK victoria BC  
 204 942.0981 306 721.1501 250 360.2106

**PEGUIS PAVILION**  
 UPGRADES AND ENTRY ADDITION  
 BIDDING #913-2011

project  
 LIFE SYSTEMS & COMMUNICATION  
 DETAILS AND RISER DIAGRAMS

sheet title

**KGS GROUP** | CONSULTING ENGINEERS

consultant

**APEGM**  
 Certificate of Authorization  
 KGS Group  
 No. 245



scale: N.T.S.  
 date: November 03 2011

checked by:  
 project no. 2011026 sheet no. E11.0

File Name: P:\Projects\2011\11-0802-04\Doc.Control\ToBeIssued\DWG\11-0802-04\_E11.0-Rev.2.dwg - Tab: E11.0 Plotted By: GNelson 12/03/07 [Wed 4:59pm] 24:36/PLT SCALE: 1:1