


File Name: P:\Projects\2011\11-0107-02\Doc\Control\ToBasis\DWG\11-0107-02_P2-E03-Rev 0.dwg - Tab: P2-E03-Rev 0.dwg - Tab: P2-E03-Rev 0.dwg - Tue 3:33pm
 11-0107-02_P2-E03-Rev 0.dwg - Tue 3:33pm

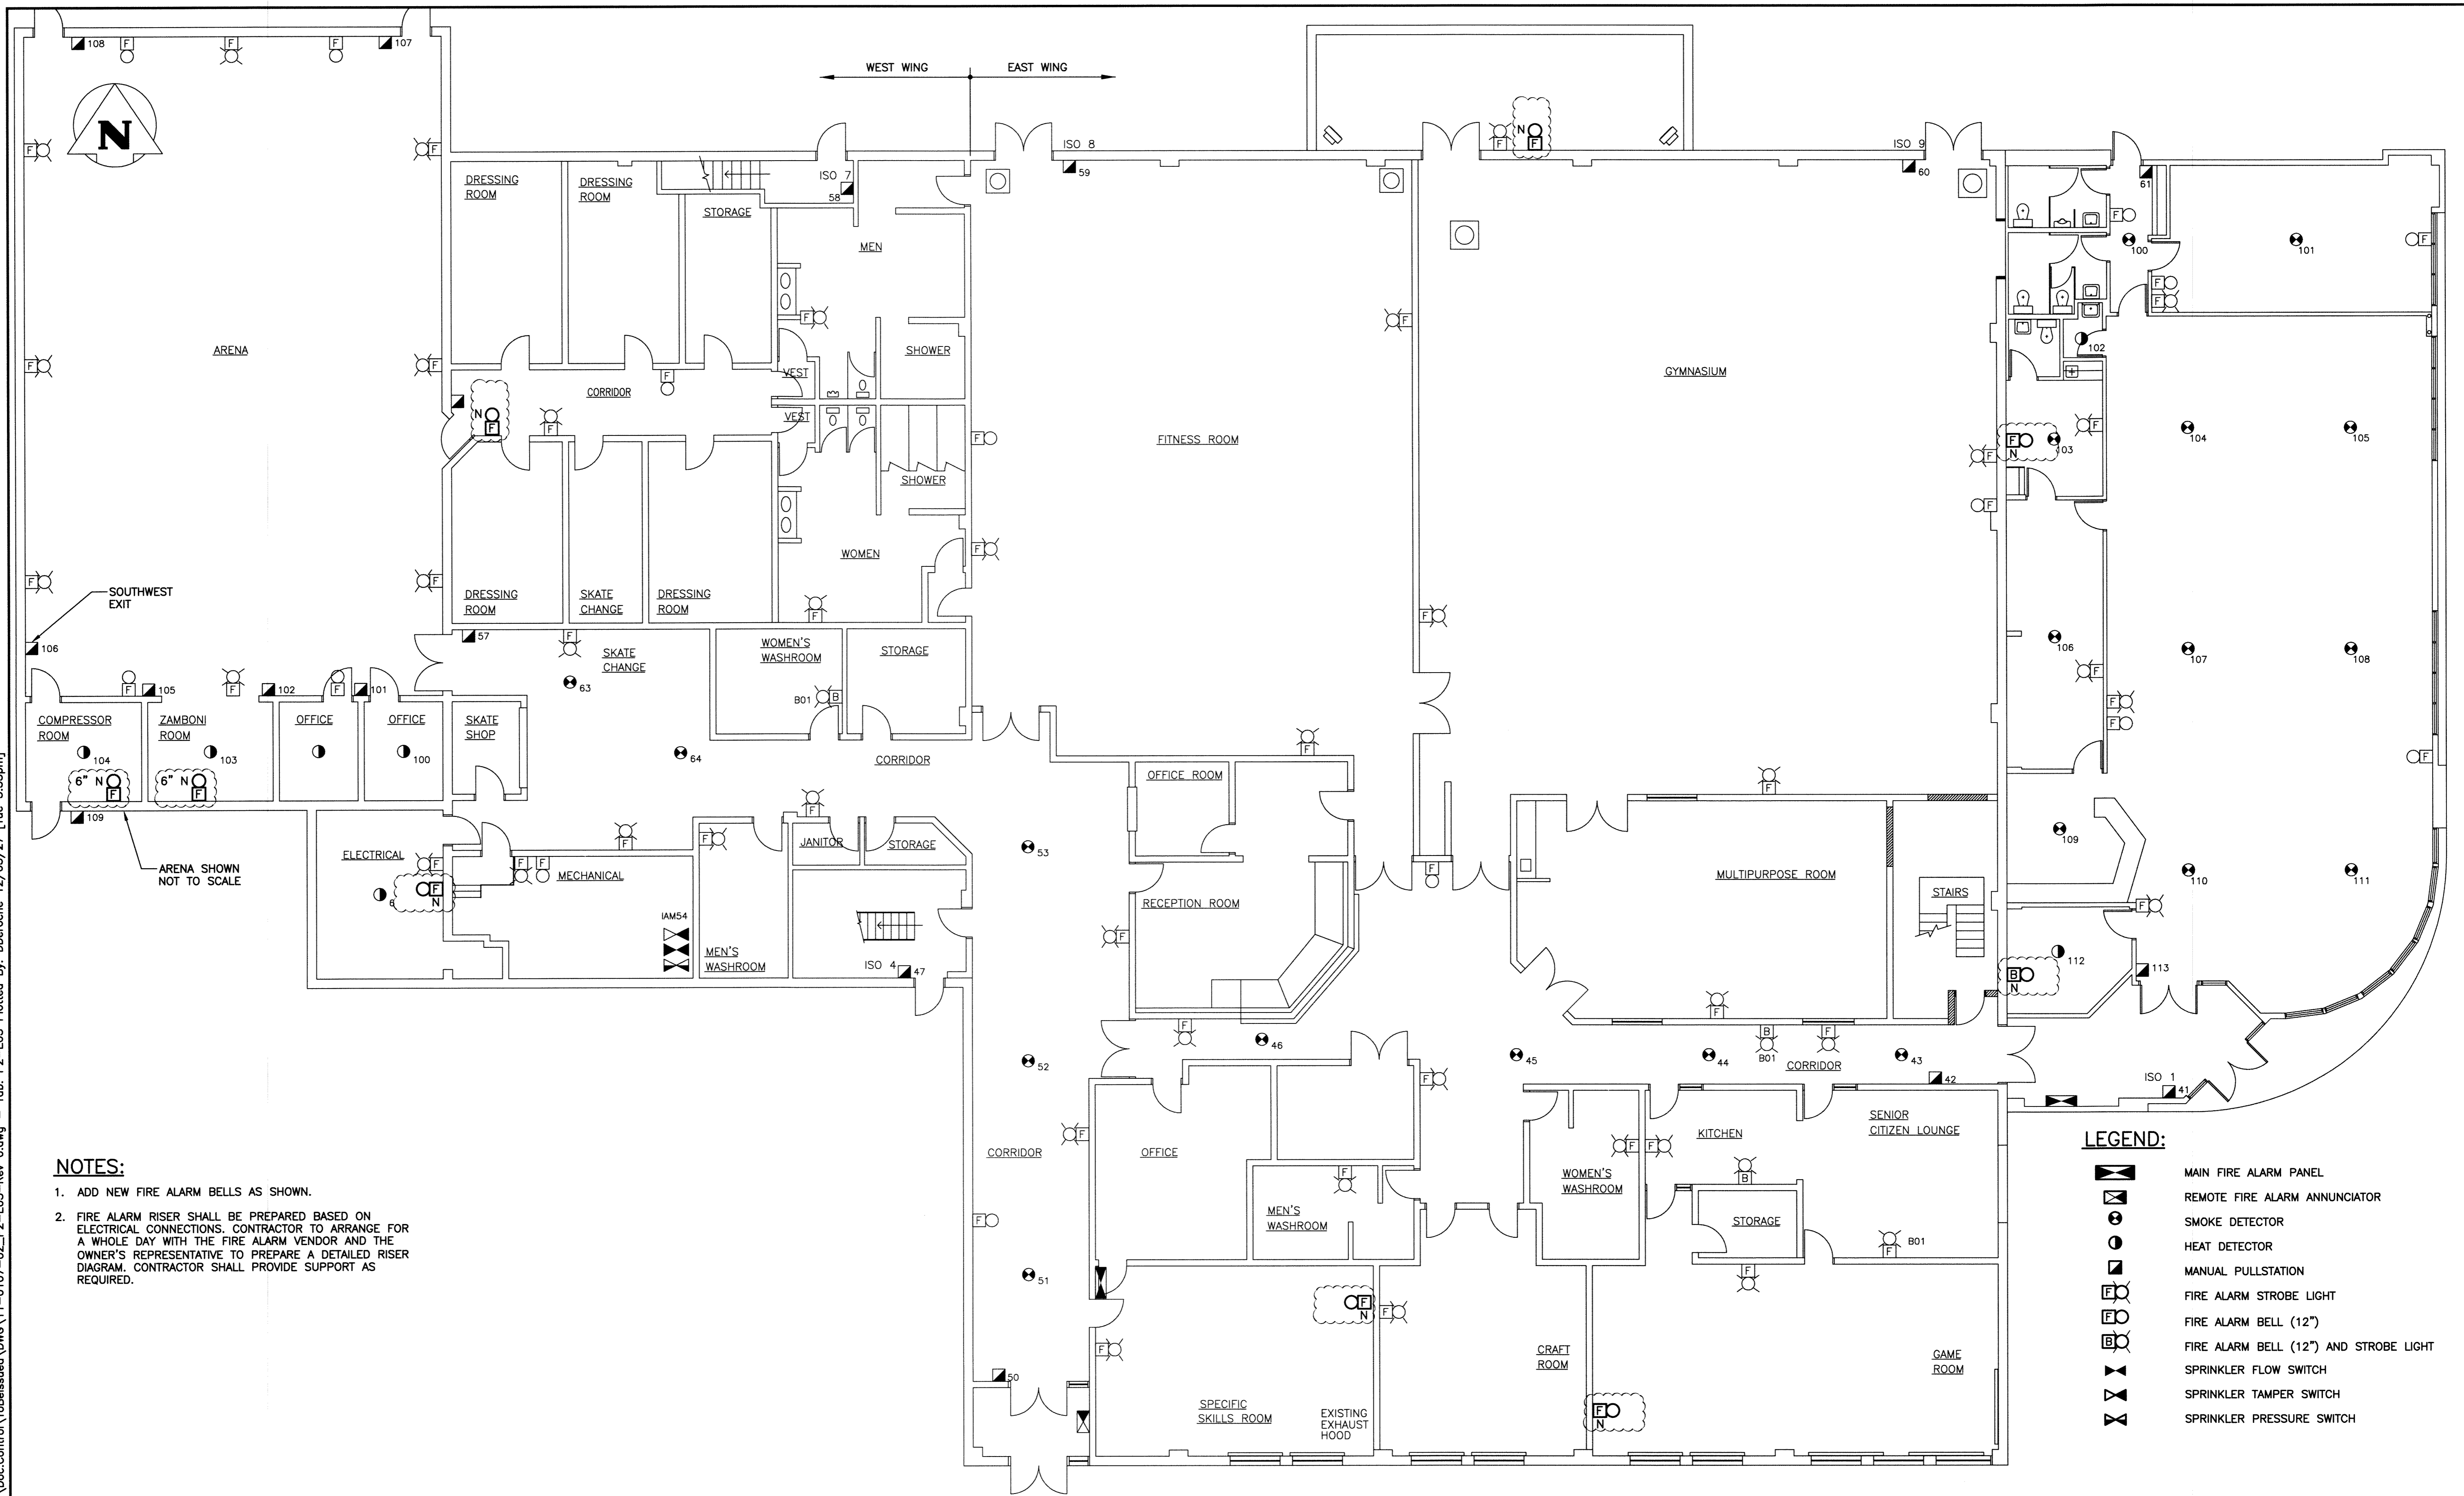


NOTES:

1. ADD NEW FIRE ALARM BELLS AS SHOWN.
2. FIRE ALARM RISER SHALL BE PREPARED BASED ON ELECTRICAL CONNECTIONS. CONTRACTOR TO ARRANGE FOR A WHOLE DAY WITH THE FIRE ALARM VENDOR AND THE OWNER'S REPRESENTATIVE TO PREPARE A DETAILED RISER DIAGRAM. CONTRACTOR SHALL PROVIDE SUPPORT AS REQUIRED.

LEGEND:

	MAIN FIRE ALARM PANEL
	REMOTE FIRE ALARM ANNUCIATOR
	SMOKE DETECTOR
	HEAT DETECTOR
	MANUAL PULLSTATION
	FIRE ALARM STROBE LIGHT
	FIRE ALARM BELL (12")
	FIRE ALARM BELL (12") AND STROBE LIGHT
	SPRINKLER FLOW SWITCH
	SPRINKLER TAMPER SWITCH
	SPRINKLER PRESSURE SWITCH

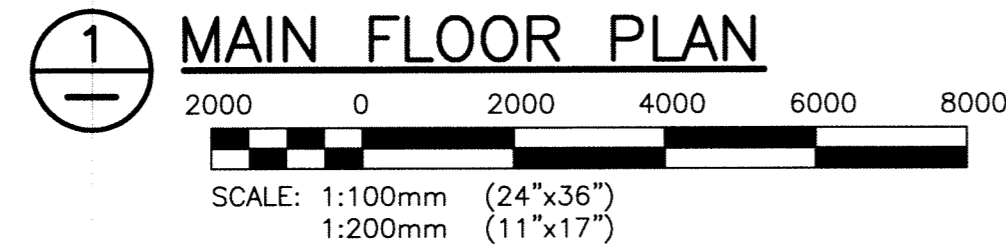

B.M.	KGS GROUP	CONSULTING ENGINEERS & PROJECT MANAGERS	WINNIPEG (204) 896-1209 THUNDER BAY (807) 345-2233
ELEV.			
DESIGNED BY: AP	CHECKED BY: <i>[Signature]</i>		
DRAWN BY: GCN	APPROVED BY:		
HOR. SCALE: AS SHOWN	RELEASED FOR CONSTRUCTION:	CONSULTANT DRAWING NO. P2-E03	
VERTICAL:	DATE:		
0 ISSUED FOR TENDER 12/03/27	DATE:	PROJECT TITLE FORT ROUGE LEISURE CENTRE HVAC UPGRADES - PHASE 2	
NO. REVISIONS	DATE	SHEET OF 001 001	
		COMPUTER FILE NAME 11-0107-02-P2-E03	
		CITY DRAWING NUMBER	

THE CITY OF WINNIPEG PUBLIC WORKS DEPARTMENT

Winnipeg

PROJECT TITLE
FORT ROUGE LEISURE CENTRE HVAC UPGRADES - PHASE 2

MAIN FLOOR PLAN FIRE ALARM UPGRADES ARRANGEMENT