

**GENERAL NOTES:**


1. PERFORM WORK IN ACCORDANCE WITH ALL APPLICABLE CODES AND REGULATIONS.
2. REVIEW EQUIPMENT LOCATIONS WITH CONTRACT ADMINISTRATOR PRIOR TO INSTALLATION.
3. PIPE ROUTING INDICATED ON DRAWINGS ARE APPROXIMATE ONLY, CONFIRM IN FIELD. REROUTE PIPING TO ELIMINATE FIELD INTERFERENCES WITH BUILDING STRUCTURES, ELECTRICAL ETC. CONFIRM CHANGES WITH CONTRACT ADMINISTRATOR.
4. FIRE SEAL ALL PIPE PENETRATIONS TO MAINTAIN EXISTING FIRE SEPARATIONS.
5. REFER TO PIPING SCHEMATICS FOR DETAILS.
6. PROVIDE ACCESS DOORS FOR ALL EQUIPMENT AND DAMPERS LOCATED ABOVE DRYWALL CEILINGS.

**KEY NOTES:**

- 1. INSTALL NEW PIPING AS INDICATED. CONFIRM PIPE ROUTING IN FIELD.
- 2. RUN SUPPLY AND RETURN PIPING UP TO MEZZANINE LEVEL (TYP).

**LEGEND:**

- NEW EQUIPMENT OR PIPING
- - - EXISTING EQUIPMENT/DUCTWORK/PIPING
- RHC RE-HEAT COIL
- GS GLYCOL SUPPLY
- GR GLYCOL RETURN
- CUH CABINET UNIT HEATER

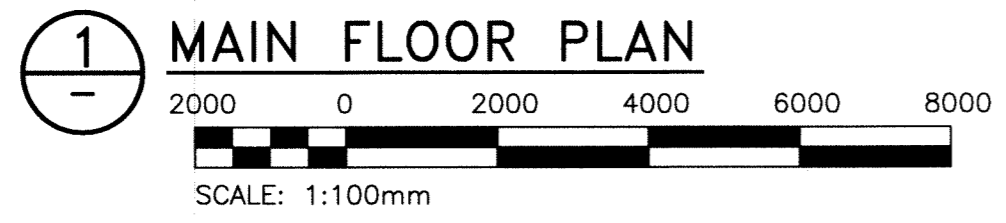

KGS FILE NO.: P:\PROJECTS\2011\11-0107-02\DWG\MECH\11-0107-02\_M3.dwg



B.M. ELEV.	
DESIGNED BY	PSS
CHECKED BY	RJS
DRAWN BY	VJH
APPROVED BY	
HOR. SCALE:	AS SHOWN
VERTICAL:	
0 ISSUED FOR TENDER	12/04/11
NO. REVISIONS	DATE BY DATE

**KGS GROUP**  
**CONSULTING ENGINEERS & PROJECT MANAGERS**  
 WINNIPEG (204) 896-1209  
 THUNDER BAY (807) 345-2233

DESIGNED BY PSS  
 CHECKED BY RJS  
 DRAWN BY VJH  
 APPROVED BY  
 HOR. SCALE: AS SHOWN  
 VERTICAL:  
 RELEASED FOR CONSTRUCTION:  
 DATE

ENGINEER'S SEAL  
  
 CONSULTANT DRAWING NO.  
**P2-M03**

**THE CITY OF WINNIPEG**  
**PUBLIC WORKS DEPARTMENT**

PROJECT TITLE  
**FORT ROUGE LEISURE CENTRE  
 HVAC UPGRADE - PHASE 2**

SHEET OF  
**001 001**

COMPUTER FILE NAME  
**11-0107-02-P2-M03**

CITY DRAWING NUMBER

**MAIN FLOOR PLAN  
 NEW PIPING**