


**1** KITCHEN PLUMBING PLAN – DEMOLITION

1000 0 1000 2000 3000 4000

SCALE: 1:50mm

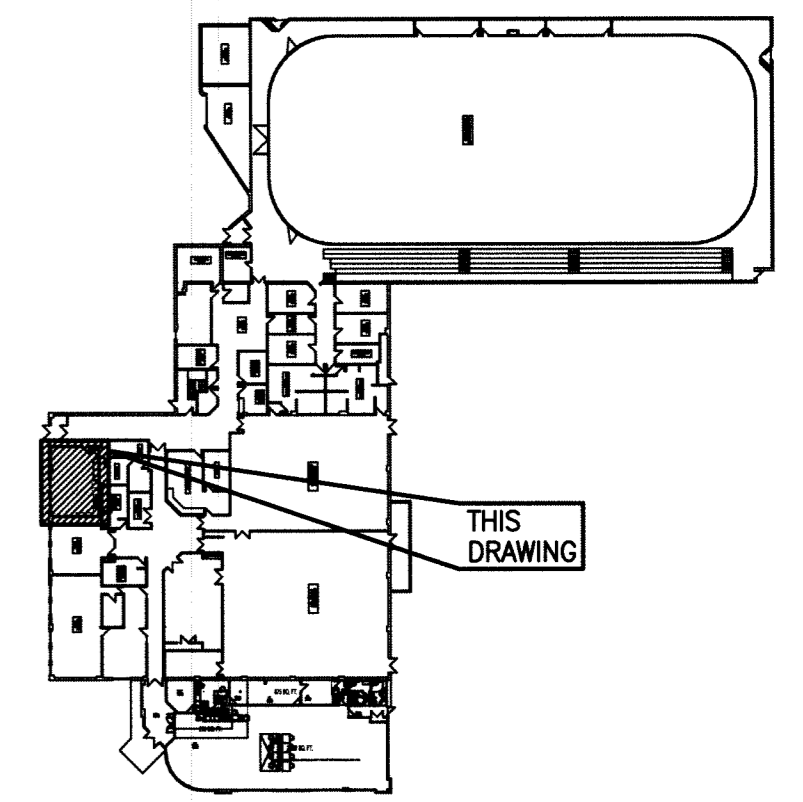

KEYPLAN

**GENERAL NOTES:**

1. CONFORM TO CANADIAN PLUMBING CODE AND ALL LOCAL CODES AND AUTHORITY HAVING JURISDICTION FOR DESIGN, SUPPLY AND INSTALLATION OF PLUMBING AND VENT SYSTEM. VENT CONCEALED INSIDE WALLS ACCORDING TO CODE.
2. PROVIDE ALL CUTTING AND PATCHING REQUIRED FOR PIPING.
3. CONTRACTOR SHALL CONFIRM EXACT PIPE ROUTING IN FIELD.

**KEYNOTES:**

- 1** EXISTING SINGLE SINK AND TRIPLE SINK TO BE REMOVED AND DISPOSED OF OFF SITE. CAP EXISTING SUPPLY AND DRAINAGE LINES. SUPPLY LINES TO BE RE-ROUTED TO NEW SINK LOCATIONS. PATCH WALL TO MATCH EXISTING.

**LEGEND:**

- EXISTING PIPING TO REMAIN
- EXISTING PIPING TO BE REMOVED

File Name: P:\Projects\2012\12-2326-001\Doc.Control\Tablesused\DWG\12-2326-001\_M01-Rev 1.dwg - Tab: M01 Plotted By: D.Deroche 12/05/10 [Thu 10:26am]



B.M.			
ELEV.			
1	RE-ISSUED FOR TENDER	12/05/10	✓
0	ISSUED FOR TENDER	12/04/23	PSS
NO.	REVISIONS	DATE	BY

<b>KGS GROUP</b> CONSULTING ENGINEERS	
DESIGNED BY: TJC	CHECKED BY: <i>β</i>
DRAWN BY: TJC	APPROVED BY:
HOR. SCALE: AS SHOWN	RELEASED FOR CONSTRUCTION:
VERTICAL:	DATE:

ENGINEER'S SEAL

CONSULTANT DRAWING NO.  
**M01**

**THE CITY OF WINNIPEG**  
PLANNING, PROPERTY AND DEVELOPMENT DEPARTMENT

PROJECT TITLE  
**KITCHEN UPGRADES AND RENOVATIONS FOR FORT ROUGE LEISURE CENTRE - 625 OSBORNE STREET  
BID OPPORTUNITY NO.: 300-2012**

SHEET OF  
**001 001**

COMPUTER FILE NAME  
**12-2326-001\_M01**

CITY DRAWING NUMBER

**PLUMBING DEMOLITION**