


SPECIFIC ELECTRICAL NOTES


1 LOCATION OF FOREMANS DESK C/W COMPUTER FOR CONTROL OF BUILDING SECURITY SYSTEMS

HAZARDOUS LOCATION ELECTRICAL NOTES


1 ALL WIRING IN THESE AREAS TO COMPLY WITH C.E.C. 20-102. AREA FROM FINISHED FLOOR TO 50mm ABOVE FINISHED FLOOR TO BE HAZARDOUS AREA CLASS 1 ZONE 2. AREA BELOW FLOOR TO BE HAZARDOUS AREA CLASS 1 ZONE 1.

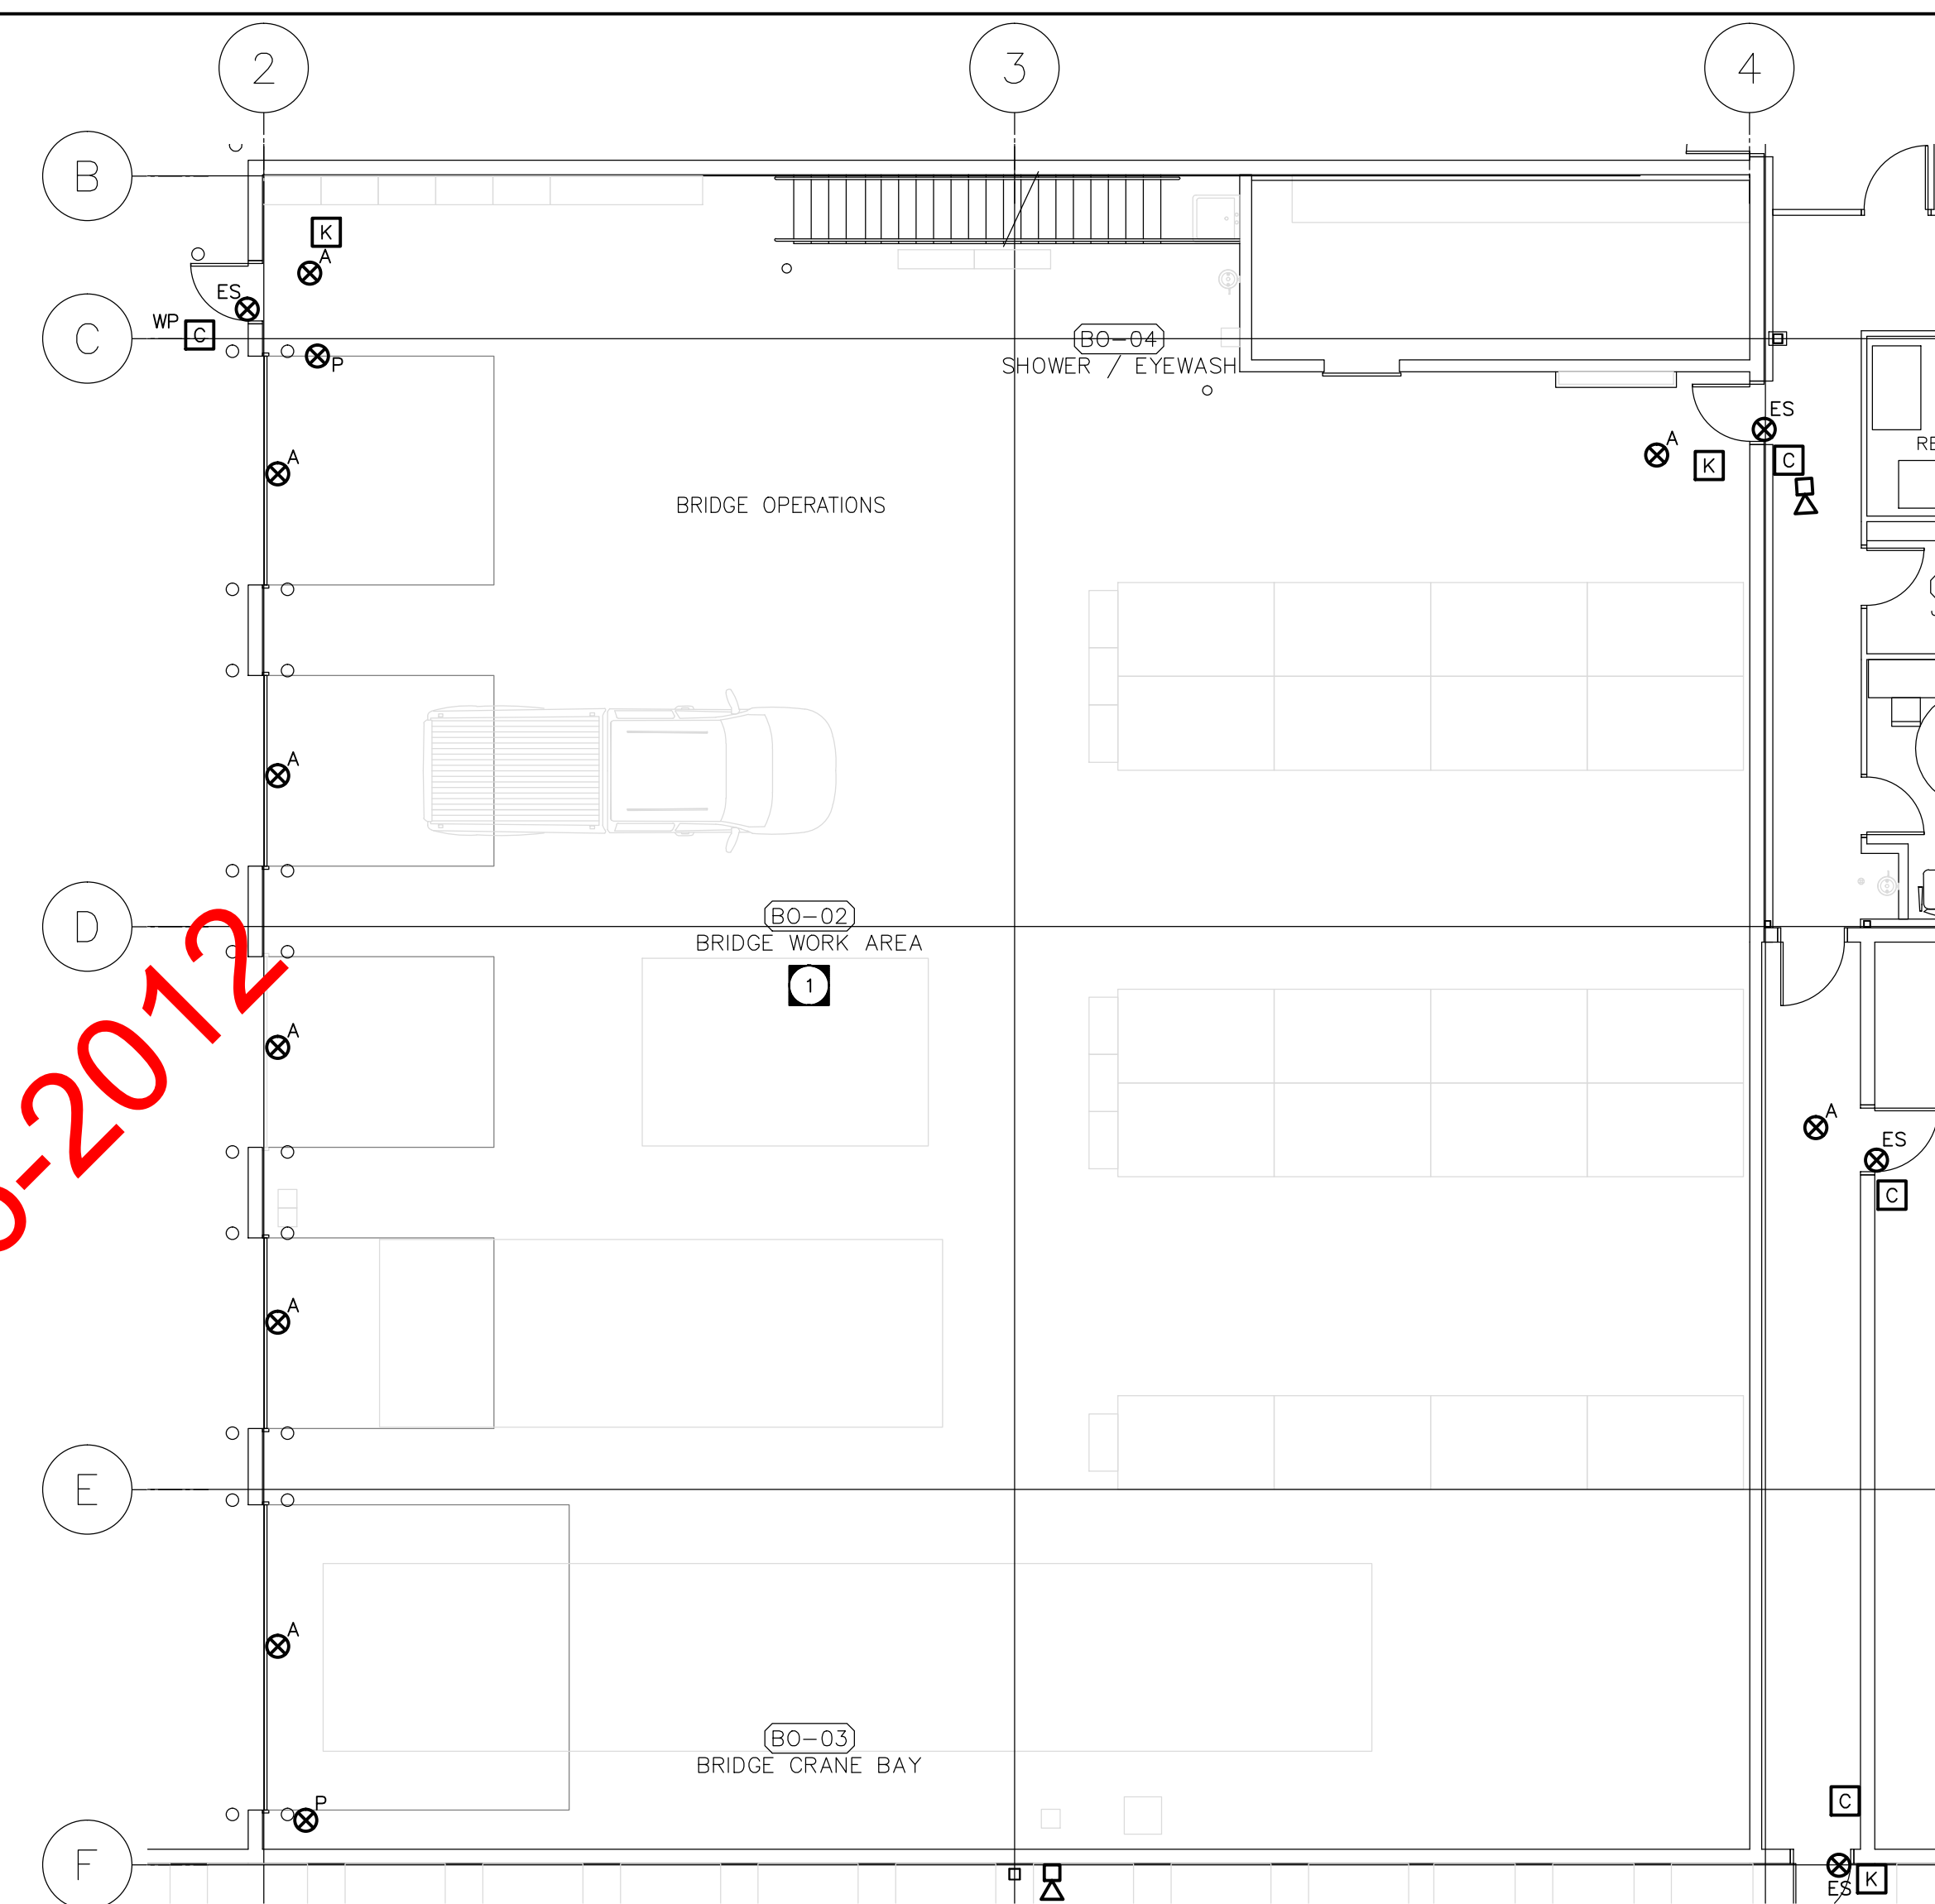

2 E3.1 BRIDGE OPERATIONS FLOOR PLAN - POWER AND SYSTEMS LAYOUT
SCALE: 1100

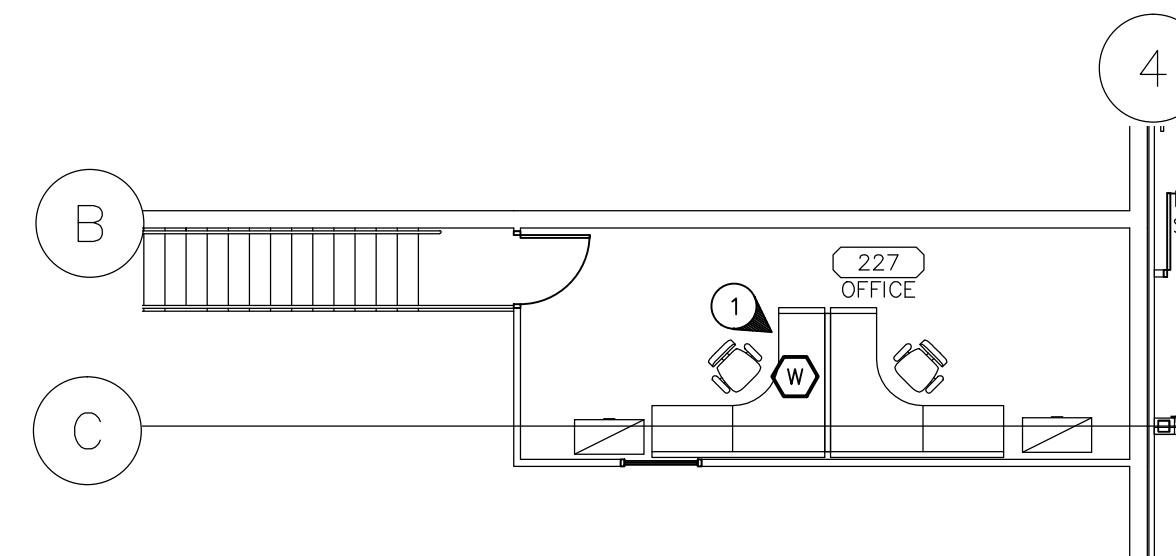

3 E3.12 MEZZANINE FLOOR PLAN
BRIDGE OPERATIONS - SECURITY LAYOUT
SCALE: 1100

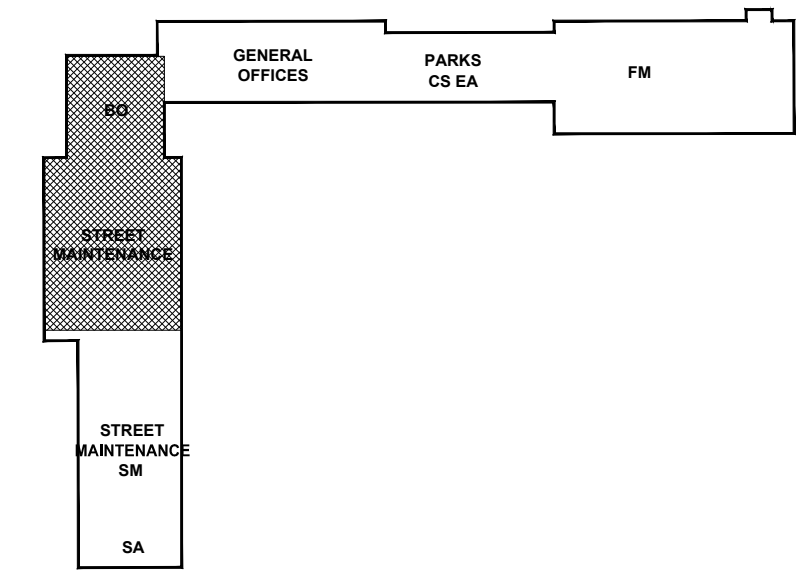


4 E3.12 KEY PLAN
SCALE: 12000

1 E3.12 STREET MAINTENANCE FLOOR PLAN - SECURITY LAYOUT
SCALE: 1100

NOT FOR CONSTRUCTION

REV	DESCRIPTION	DATE	BY
3	ISSUED FOR 99% REVIEW	2012.06.04	MZ
2	ISSUED FOR 66% REVIEW	2012.03.06	MZ
1	ISSUED FOR 33% REVIEW	2012.01.06	MZ

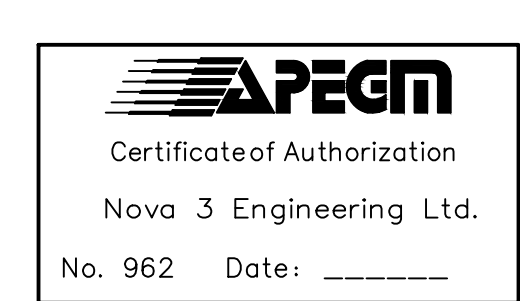

NOVA 3 ENGINEERING LTD.
CONSULTING ENGINEERS
201-120 FORT STREET WINNIPEG, MANITOBA R3C 1C7
TEL: (204) 943-8142 FAX: (204) 942-1276 JN: 31-173
THIS DRAWING IS THE EXCLUSIVE PROPERTY OF NOVA 3 ENGINEERING LTD. AND MAY ONLY BE REPRODUCED WITH THE WRITTEN PERMISSION OF NOVA 3 ENGINEERING LTD.
THE CONCEPT AND DESIGN INCORPORATED INTO THIS DRAWING ARE BASED ON INFORMATION PROVIDED BY THE CLIENT AND OTHER RELATED SOURCES. PROFESSIONAL ENGINEER ACCEPTS NO RESPONSIBILITY FOR DRAWING AND DESIGN UNLESS DRAWING IS ACCOMPANIED BY ORIGINAL SEALED AND SIGNED LETTER OF INTENT AND CERTIFICATE OF INSPECTION. REFER TO WWW.NOVA3.CA FOR CAUTIONARY NOTES.



3 TERRACON PLACE WINNIPEG, CANADA R2J 4B3
TEL. (204) 233 7881 FAX (204) 233 4733
general@ehansch.com www.ehansch.com

CLIENT: CITY OF WINNIPEG PUBLIC WORKS DEPARTMENT
PROJECT NUMBER: 31-178E
DRAWN BY: KC
DATE: MARCH 06, 2012
SCALE: AS SHOWN

PROJECT TITLE:
CITY OF WINNIPEG PUBLIC WORKS EAST YARD COMPLEX
MAIN OFFICE & GARAGES
SHEET TITLE:
MAIN FLOOR SECURITY LAYOUT

SHEET NUMBER:

E3.1.2

REVISION NUMBER:

0