


ISSUED FOR CITY REVIEW 11-06-2012

**1**  
E3.3.1 **ADMINISTRATIVE BLOCK 2ND LEVEL FLOOR PLAN - FIRE LAYOUT**  
SCALE: 1/100

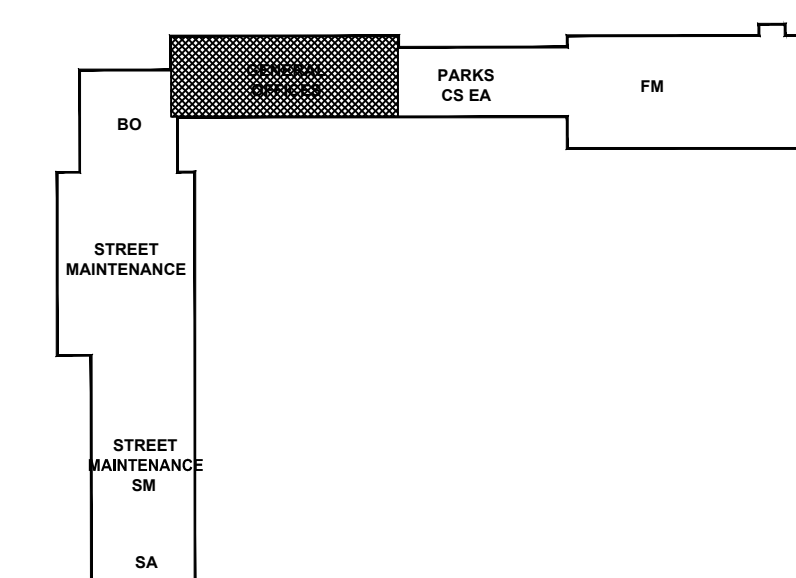

**2**  
E3.3.1 **KEY PLAN**  
SCALE: 1/2000

NOT FOR  
CONSTRUCTION

REV	DESCRIPTION	DATE	BY
3	ISSUED FOR 99% REVIEW	2012.06.04	MZ
2	ISSUED FOR 66% REVIEW	2012.03.06	MZ
1	ISSUED FOR 33% REVIEW	2012.01.06	MZ

**APEGM**  
Certificate of Authorization  
Nova 3 Engineering Ltd.  
No. 962 Date: \_\_\_\_\_

**NOVA 3 ENGINEERING LTD.**  
CONSULTING ENGINEERS  
201-120 FORT STREET WINNIPEG, R3C 1C7  
TEL: (204) 943-8142 FAX: (204) 942-1276  
TEL: (204) 943-8142 FAX: (204) 942-1276 JN: 31-173

THIS DRAWING IS THE EXCLUSIVE PROPERTY OF NOVA 3 ENGINEERING LTD. AND MAY ONLY BE REPRODUCED WITH THE WRITTEN PERMISSION OF NOVA 3 ENGINEERING LTD. THE CONCEPT AND DESIGN INCORPORATED INTO THIS DRAWING ARE BASED ON INFORMATION PROVIDED BY THE CLIENT AND OTHER RELATED SOURCES. PROFESSIONAL ENGINEER ACCEPTS NO RESPONSIBILITY FOR DRAWING AND DESIGN UNLESS DRAWING IS ACCOMPANIED BY ORIGINAL SEALED AND SIGNED LETTER OF INTENT AND CERTIFICATE OF INSPECTION. REFER TO WWW.NOVA3.CA FOR CAUTIONARY NOTES.

**ERNST  
HANSCH  
CONSTRUCTION LTD.**

CLIENT: CITY OF WINNIPEG  
PUBLIC WORKS DEPARTMENT  
PROJECT NUMBER: 31-178E  
DRAWN BY: KC  
DATE: MARCH 06, 2012  
SCALE: AS SHOWN

PROJECT TITLE:  
CITY OF WINNIPEG  
PUBLIC WORKS EAST YARD COMPLEX  
MAIN OFFICE & GARAGES  
SHEET TITLE:  
**SECOND FLOOR FIRE LAYOUT**

SHEET NUMBER:  
**E3.3.1**  
REVISION NUMBER:  
0