


MAIN FLOOR PLAN - METHANE EXTRACTION
SCALE 1:100
NOTE: REFER TO INSTALLATION DETAILS ON MECHANICAL DRAWING M4.1

GENERAL NOTE
INCLUDE IN MECHANICAL WORK AND PRICING SUBMISSION ALL THE MECHANICAL REQUIREMENTS OF THE CITY OF WINNIPEG REQUEST FOR PROPOSAL FOR THIS PROJECT (DESIGN AND CONSTRUCTION OF THE PUBLIC WORKS EAST YARD COMPLEX AT THE FORMER ELMWOOD/NAIRN LANDFILL SITE) INCLUDING ALL SPECIFICATIONS, SUBSEQUENT ADDENDA, CLARIFICATIONS, AND APPROVED CHANGE DIRECTIVES AS INTERPRETED BY THE CITY OF WINNIPEG AND THEIR ADVOCATE PROFESSIONAL ENGINEERS AND CONSULTANTS. THE MECHANICAL PLANS OUTLINED HEREIN ARE PROVIDED AS A GUIDE TO THE INTENT OF THE REQUEST FOR PROPOSAL REQUIREMENTS. IN THE CASE OF A CONFLICT OR OMISSION BETWEEN THE DRAWINGS AND SPECIFICATIONS AND THE INTERPRETED CITY OF WINNIPEG REQUEST FOR PROPOSAL, THE INSTALLATION SHALL BE COMPLETED IN CONFORMANCE WITH THE CITY OF WINNIPEG STATEMENT OF REQUIREMENTS AS INTERPRETED BY THE CITY OF WINNIPEG OR THEIR PROJECT PROFESSIONAL ENGINEERING REPRESENTATIVE.

ISSUED FOR CITY REVIEW 17-06-2012

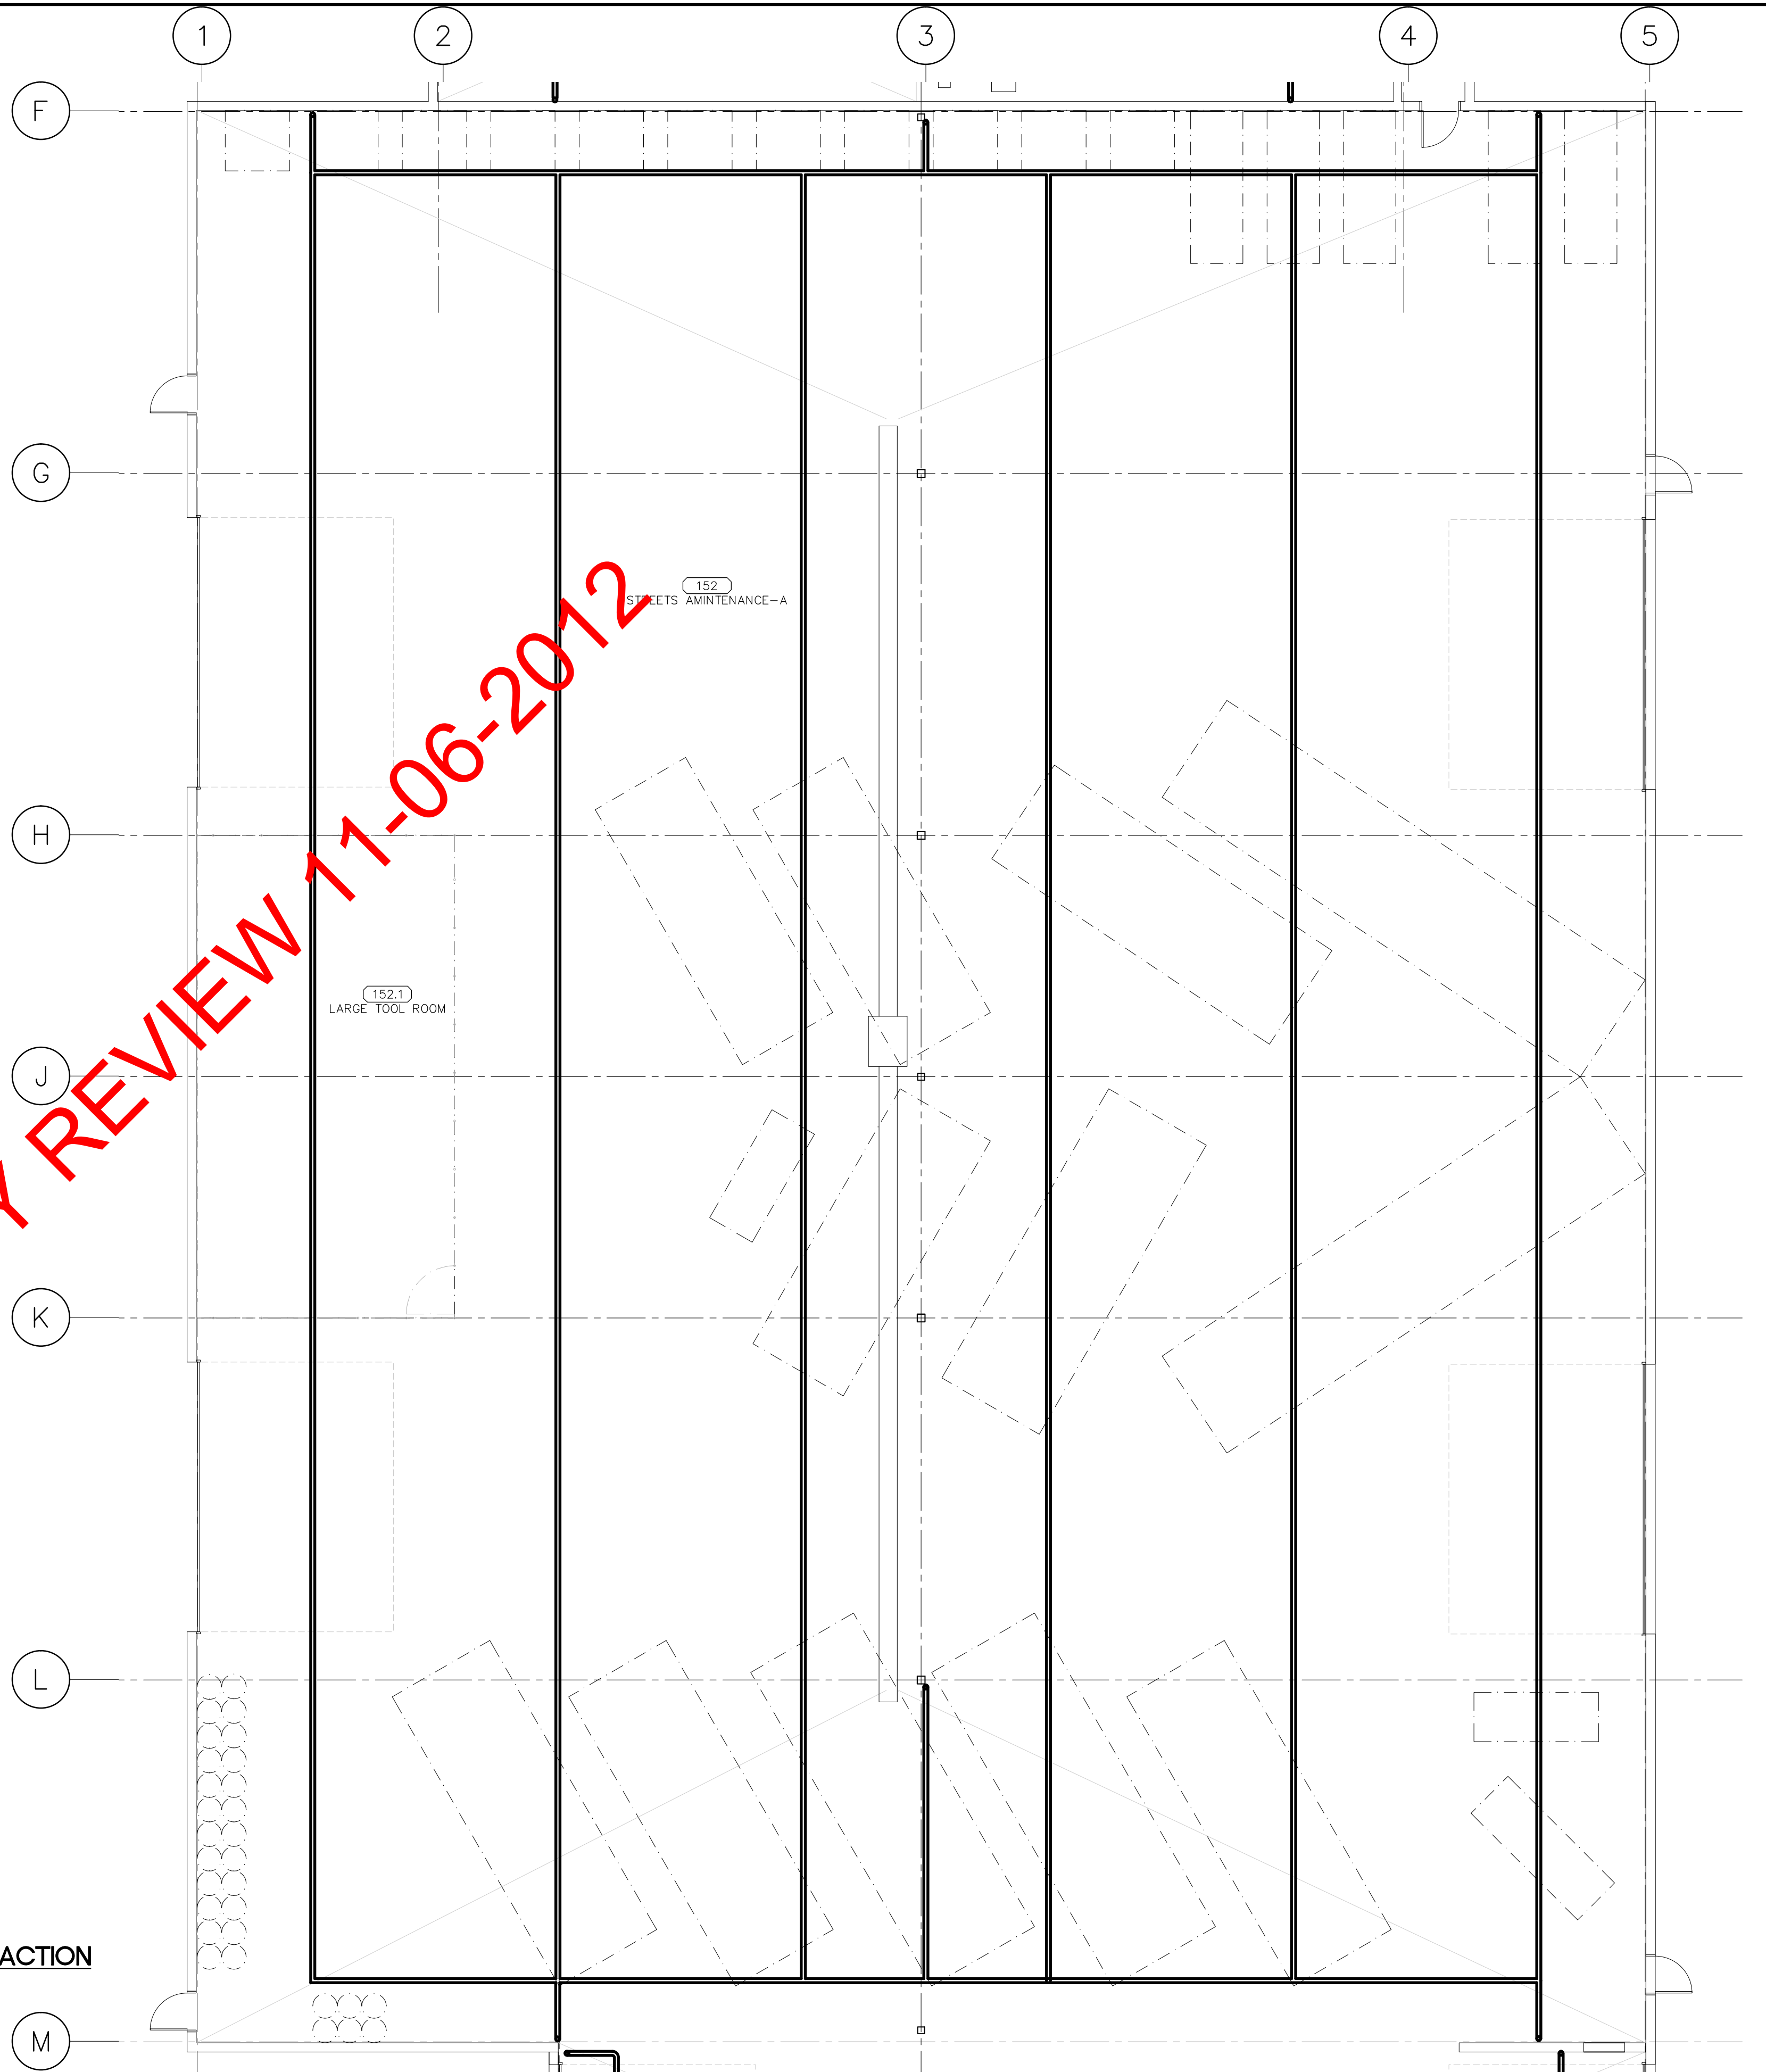

MAIN FLOOR PLAN - METHANE EXTRACTION
SCALE 1:100

REV	DESCRIPTION	DATE	BY
3	ISSUED FOR CONSTRUCTION	11 MAY 2012	PSG
2	ISSUED FOR 66% REVIEW	06 MAR 2012	PSG
1	ISSUED FOR 33% REVIEW	06 JAN 2012	PSG

NOVA 3 ENGINEERING LTD.
CONSULTING ENGINEERS
201-120 FORT STREET
WINNIPEG, MANITOBA
R3C 1C7
TEL.: (204) 943-6142
FAX: (204) 942-1276
CN: 31-178
THIS DRAWING IS THE EXCLUSIVE PROPERTY OF NOVA 3 ENGINEERING LTD. AND MAY ONLY BE REPRODUCED WITH THE WRITTEN PERMISSION OF NOVA 3 ENGINEERING LTD.
THE CONCEPT AND DESIGN INCORPORATED INTO THIS DRAWING ARE BASED ON INFORMATION PROVIDED BY THE CLIENT AND OTHER RELATED SOURCES. PROFESSIONAL ENGINEER ACCEPTS NO RESPONSIBILITY FOR DRAWING AND DESIGN UNLESS DRAWING IS ACCOMPANIED BY ORIGINAL SEALED AND SIGNED LETTER OF INTENT AND CERTIFICATE OF INSPECTION. REFER TO WWW.NOVA3.CA FOR CAUTIONARY NOTES.

APEGM
Certificate of Authorization
Nova 3 Engineering Ltd.
No.962 Date: _____



ERNST HANSCH
CONSTRUCTION LTD.

3 TERRACON PLACE
WINNIPEG, CANADA R2J 4B3
TEL. (204) 233 7881
FAX (204) 233 4733
general@ehansch.com
www.ehansch.com

CLIENT: **CITY OF WINNIPEG PUBLIC WORKS DEPARTMENT**
PROJECT NUMBER: 1511
DRAWN BY: **BSD**
DATE: **MAR 6, 2012**
SCALE: **1: 100**

PROJECT TITLE:
CITY OF WINNIPEG PUBLIC WORKS EAST YARD COMPLEX MAIN OFFICE & GARAGES
SHEET TITLE:
MAIN FLOOR PLAN - METHANE EXTRACTION

SHEET NUMBER:
M4.3
REVISION NUMBER:
0