


1 PARTIAL MAIN FLOOR PLAN - HVAC DEMOLITION
 SCALE: 1:25mm



SECTION A-A - NORTH FACE OF BLDG.
 SCALE: 1:50mm


SCALE VERIFIED BY: _____

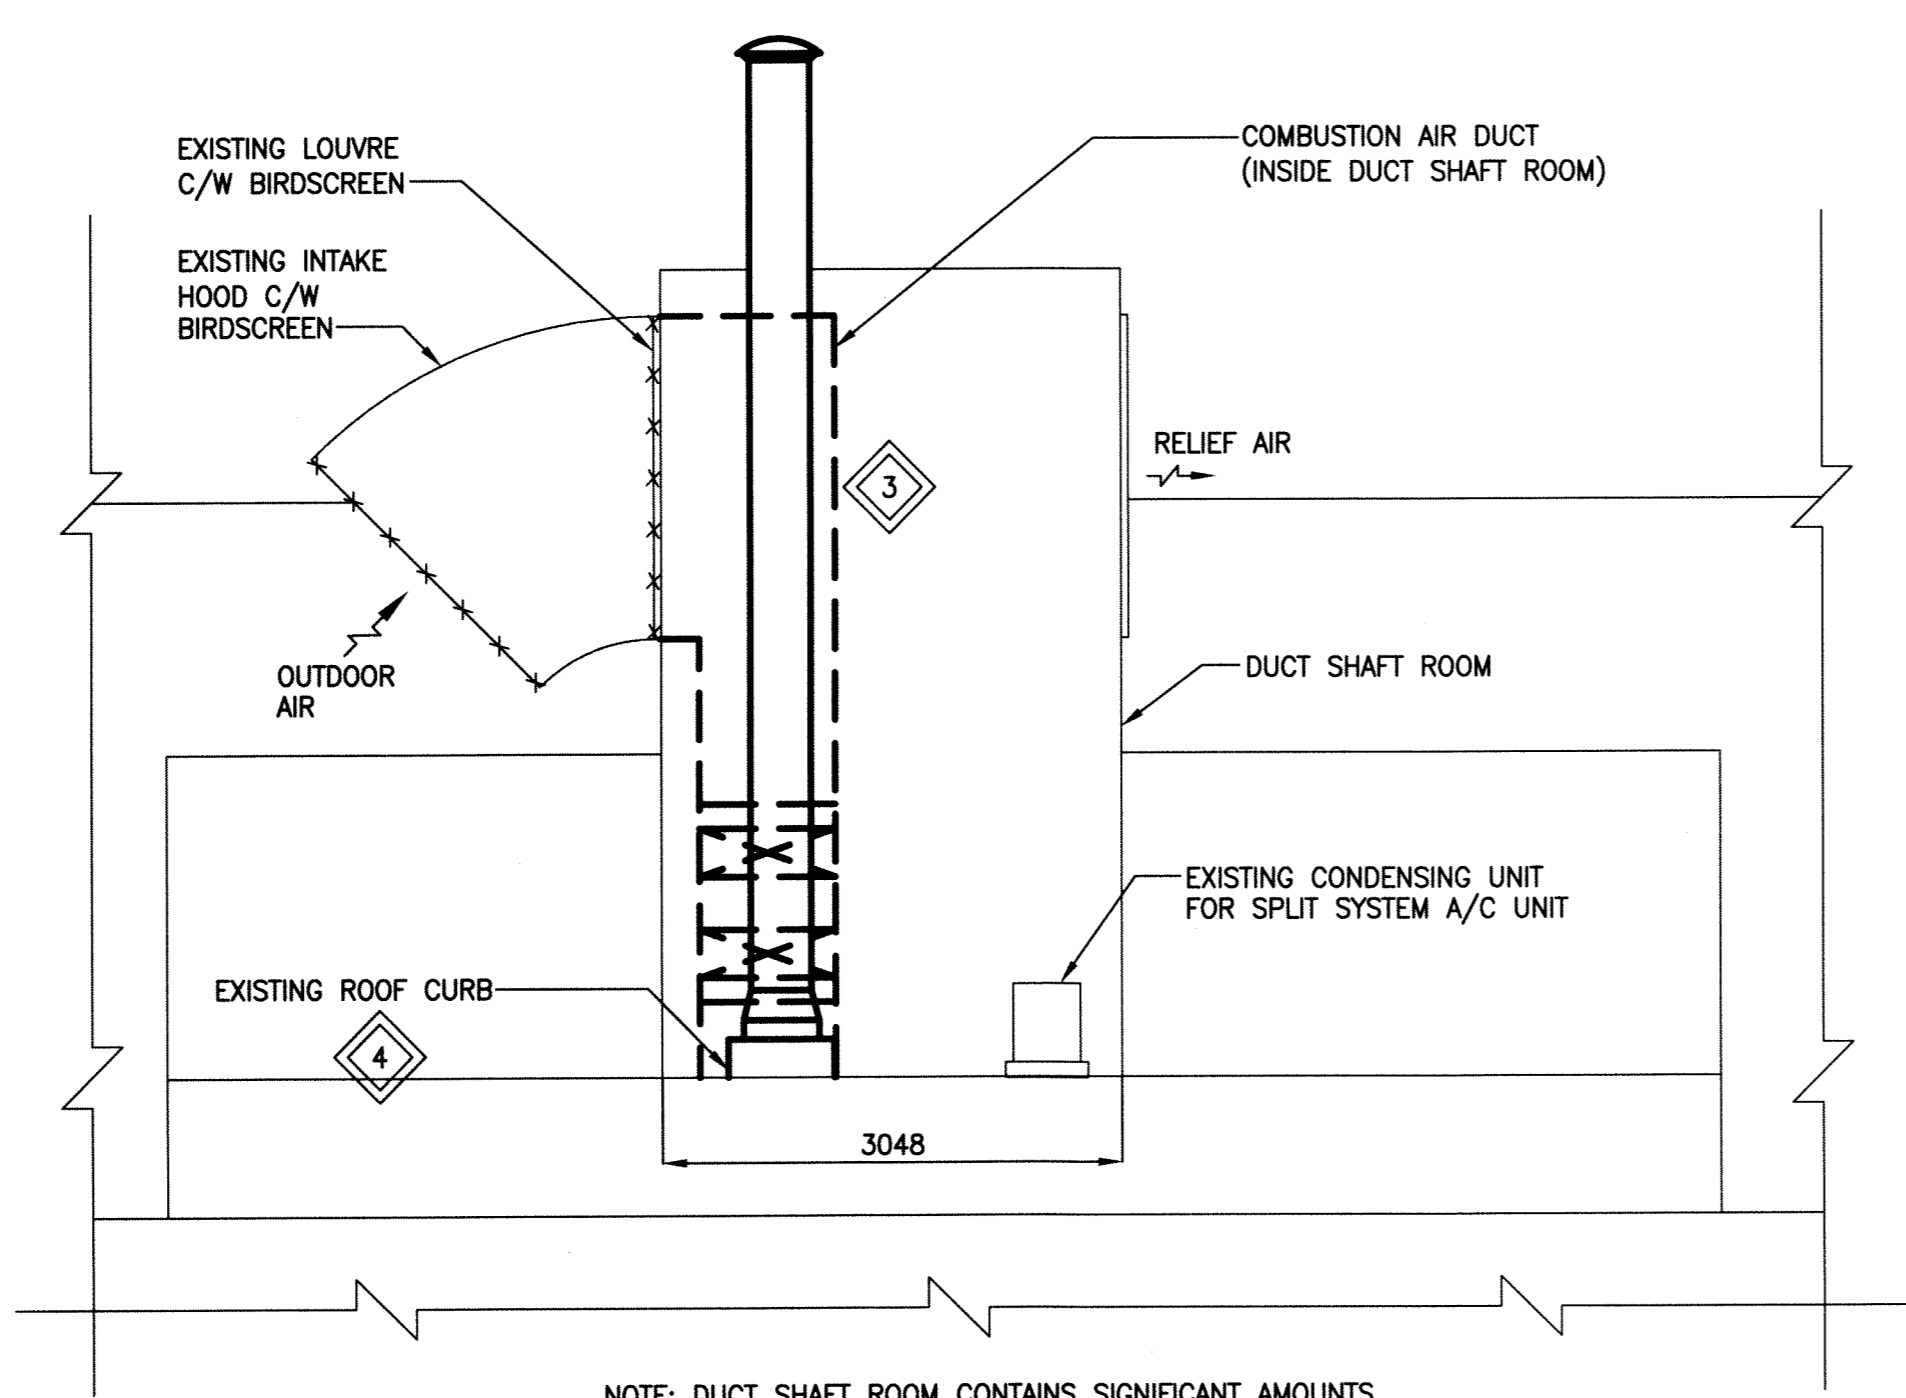

- LEGEND:**
- DUCTWORK/PIPING TO BE REMOVED
 - DUCTWORK/PIPING TO REMAIN
 - CIRCULATION PUMP
 - FLANGE
 - PRESSURE GAUGE
 - BUTTERFLY VALVE
 - BALL VALVE

- GENERAL NOTES:**
1. PERFORM WORK IN ACCORDANCE WITH ALL APPLICABLE CODES AND REGULATIONS.
 2. DISPOSE OF ALL REMOVED EQUIPMENT, DUCTWORK AND PIPING OFF SITE. CONFIRM WITH CONTRACT ADMINISTRATOR IF ANY EQUIPMENT IS TO BE TURNED OVER TO THE CITY.
 3. ASBESTOS ABATEMENT IS NOT PART OF THIS CONTRACT. COORDINATE WITH CONTRACT ADMINISTRATOR FOR START DATE.
 4. PATCH AND MAKE GOOD ALL FLOOR, WALL AND ROOF PENETRATIONS REMAINING AFTER EQUIPMENT, PIPING, ETC. IS REMOVED. FIRE SEAL WHERE APPROPRIATE.

- KEYNOTES:**
- REMOVE EXISTING BOILER CHIMNEY AND RELATED FASTENERS FROM SHAFT. REFER TO SECTION A-A ON THIS DRAWING TO SEE CHIMNEY ON ROOF.
 - REMOVE EXISTING COMBUSTION AIR DUCT FROM SHAFT. REFER TO SECTION A-A ON THIS DRAWING FOR FURTHER DETAILS.
 - EXISTING COMBUSTION AIR DUCT TO BE REMOVED FROM EXISTING INTAKE LOUVRE/HOOD COMBINATION. REPAIR INSULATION TO SURROUNDING DUCTWORK RESULTING FROM COMBUSTION AIR DUCT REMOVAL. BLANK OFF LOUVRE SECTION PREVIOUSLY OCCUPIED BY COMBUSTION AIR DUCT AND INSULATE.
 - REMOVE EXISTING ROOF CURB. REFER TO NEW DESIGN FOR NEW ROOF CURB.

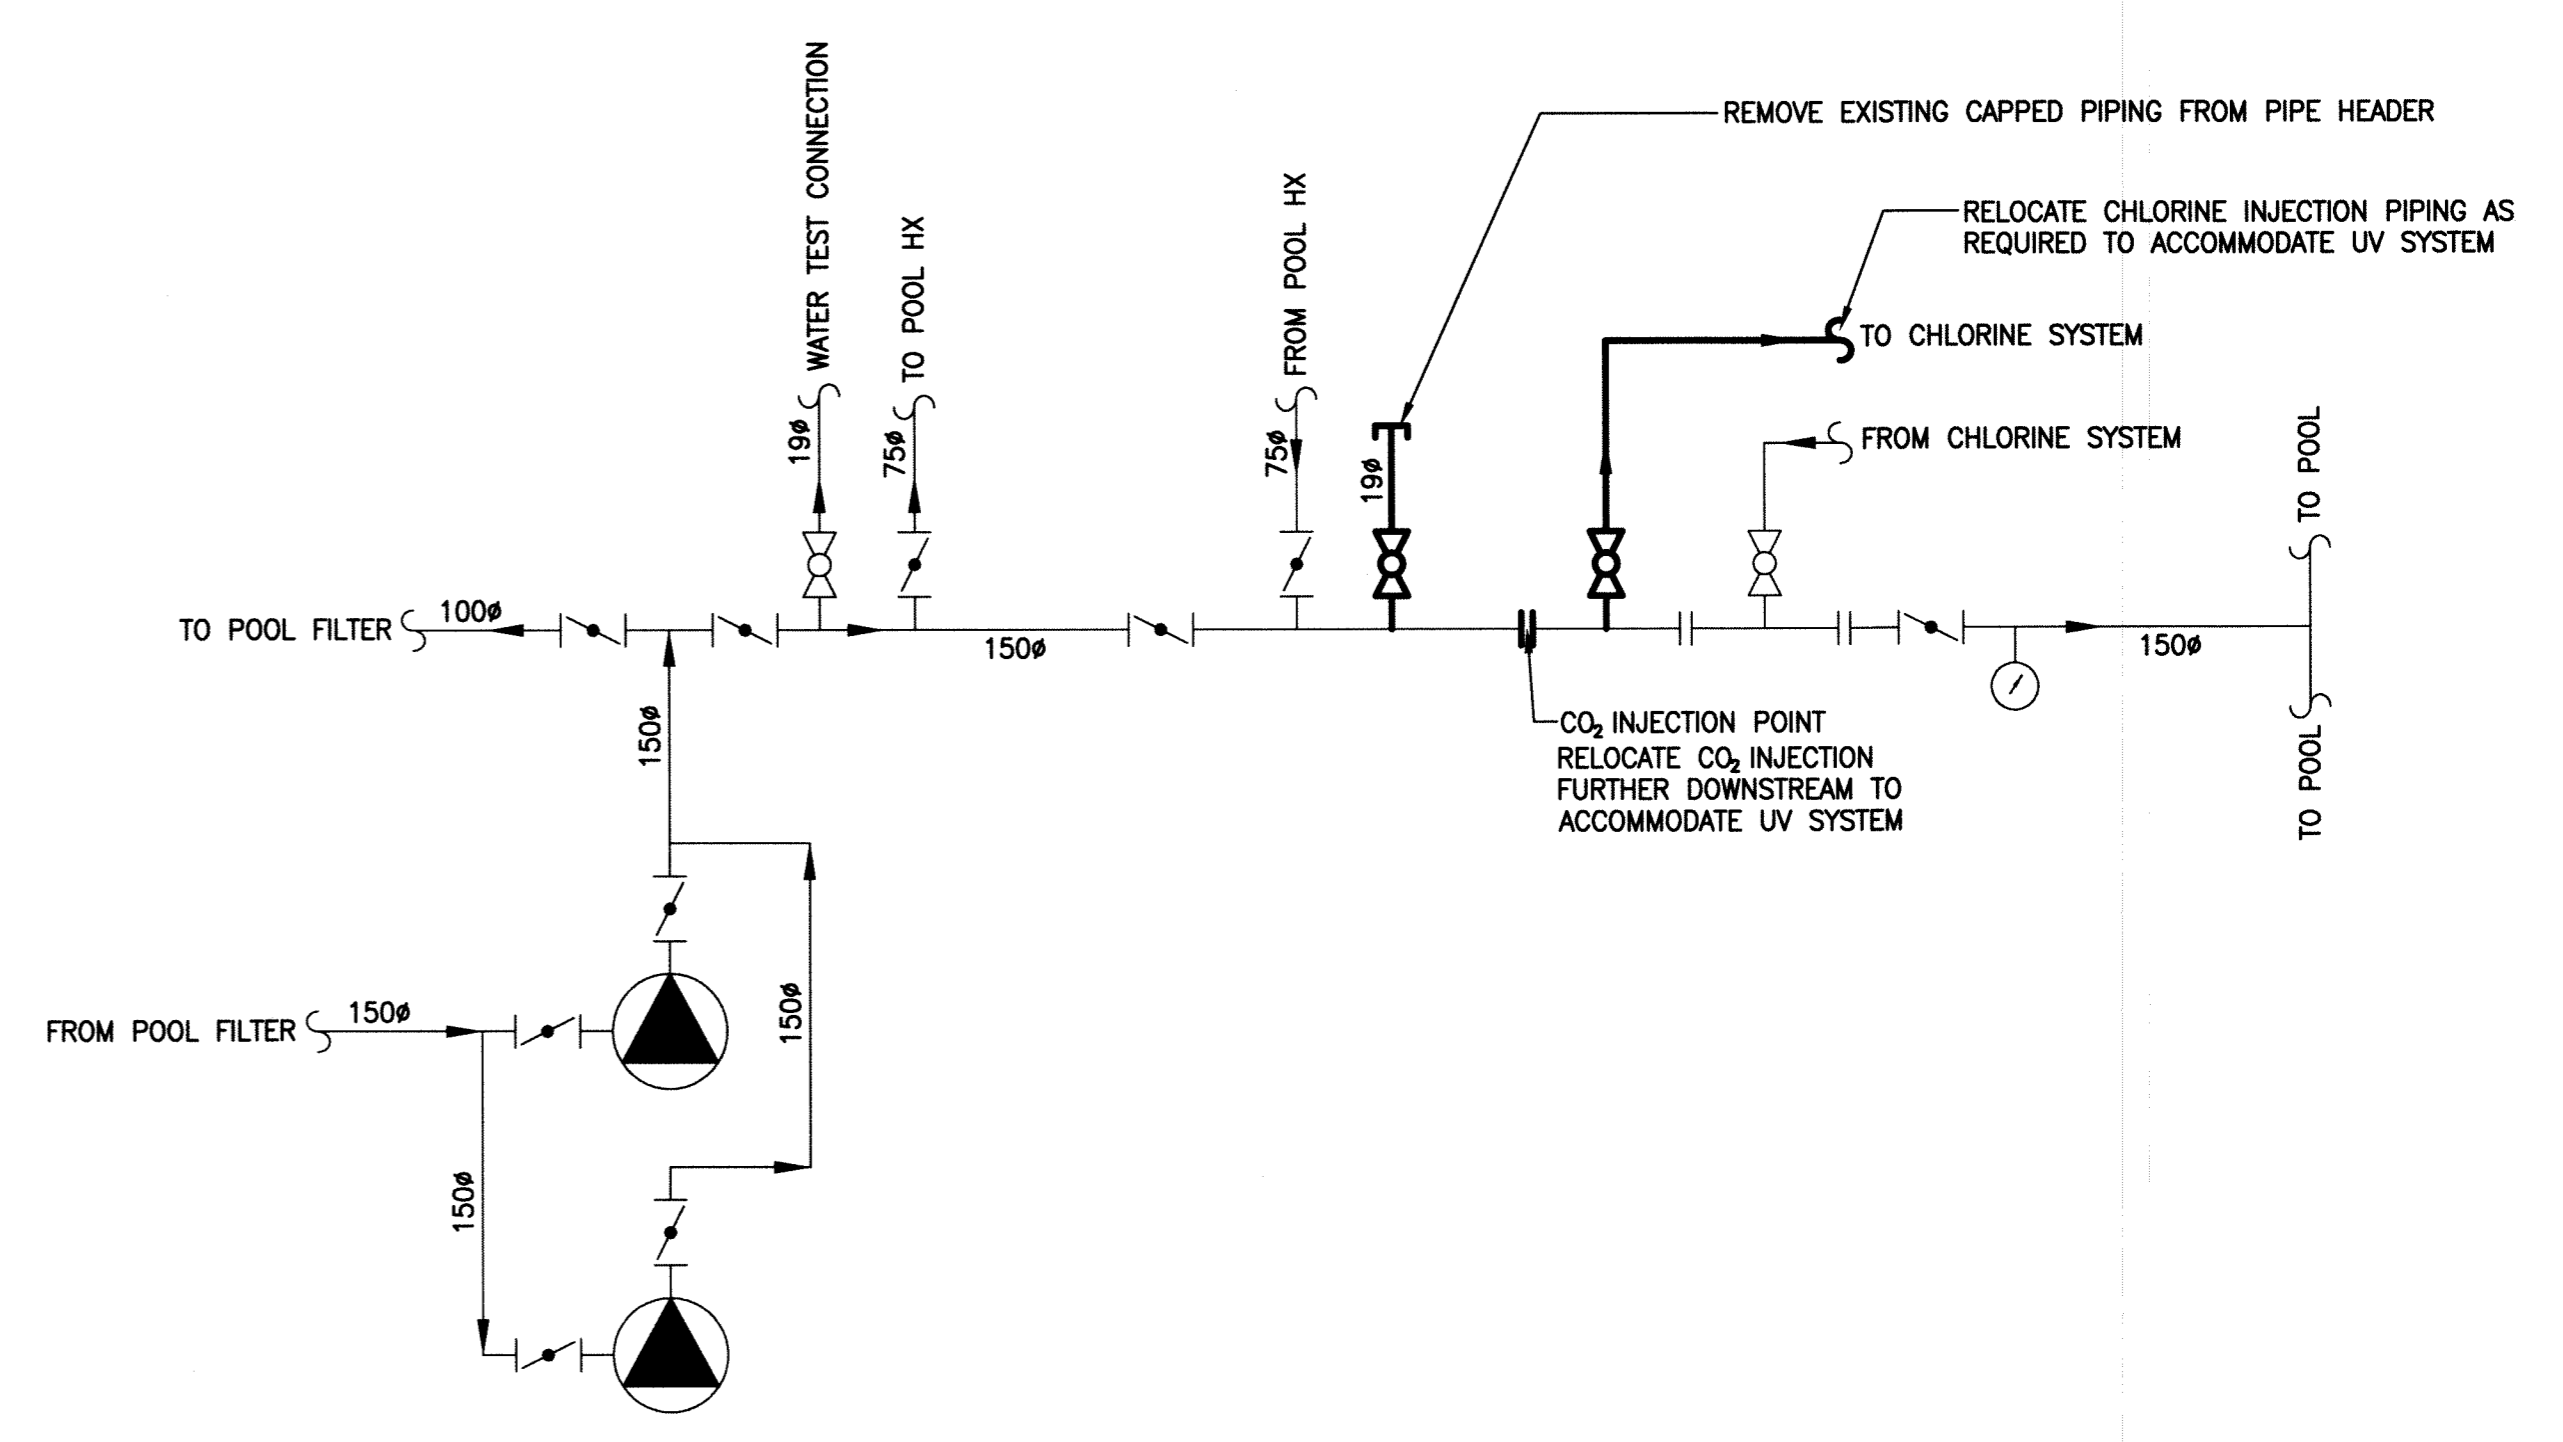


2 POOL WATER PIPING SCHEMATIC - DEMOLITION AND RELOCATION
 SCALE: N.T.S.

B.M. ELEV.	
DESIGNED BY	SHC
DRAWN BY	TJC
HOR. SCALE:	AS SHOWN
VERTICAL:	
ISSUED FOR TENDER	12/02/24
NO. REVISIONS	DATE BY DATE

KGS GROUP CONSULTING ENGINEERS & PROJECT MANAGERS
 WINNIPEG (204) 896-1209
 THUNDER BAY (807) 345-2233

DESIGNED BY: SHC
 CHECKED BY: _____
 DRAWN BY: TJC
 APPROVED BY: _____
 HOR. SCALE: AS SHOWN
 VERTICAL: _____
 RELEASED FOR CONSTRUCTION: _____
 DATE: _____

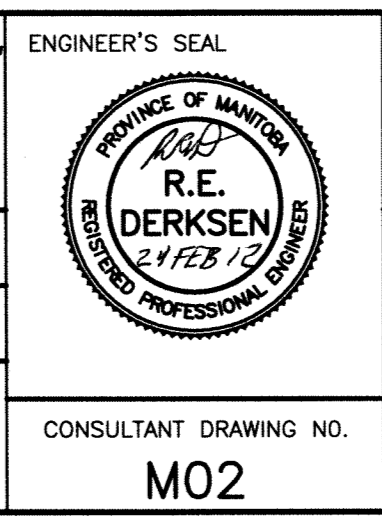

THE CITY OF WINNIPEG
 PLANNING, PROPERTY & DEVELOPMENT

PROJECT TITLE: **ST. JAMES CENTENNIAL POOL**
 644 PARKDALE STREET
 BID OPPORTUNITY: 45-2012
 UPGRADE HYDRONIC HEATING SYSTEM

PARTIAL MAIN FLOOR PLAN, SECTIONS AND SCHEMATICS - DEMOLITION

SHEET OF: 002 OF 006
 COMPUTER FILE NAME: 11-0107-32-M02
 CITY DRAWING NUMBER: _____

CONSULTANT DRAWING NO. MO2