



LEGEND:

— EXISTING
— NEW WORK

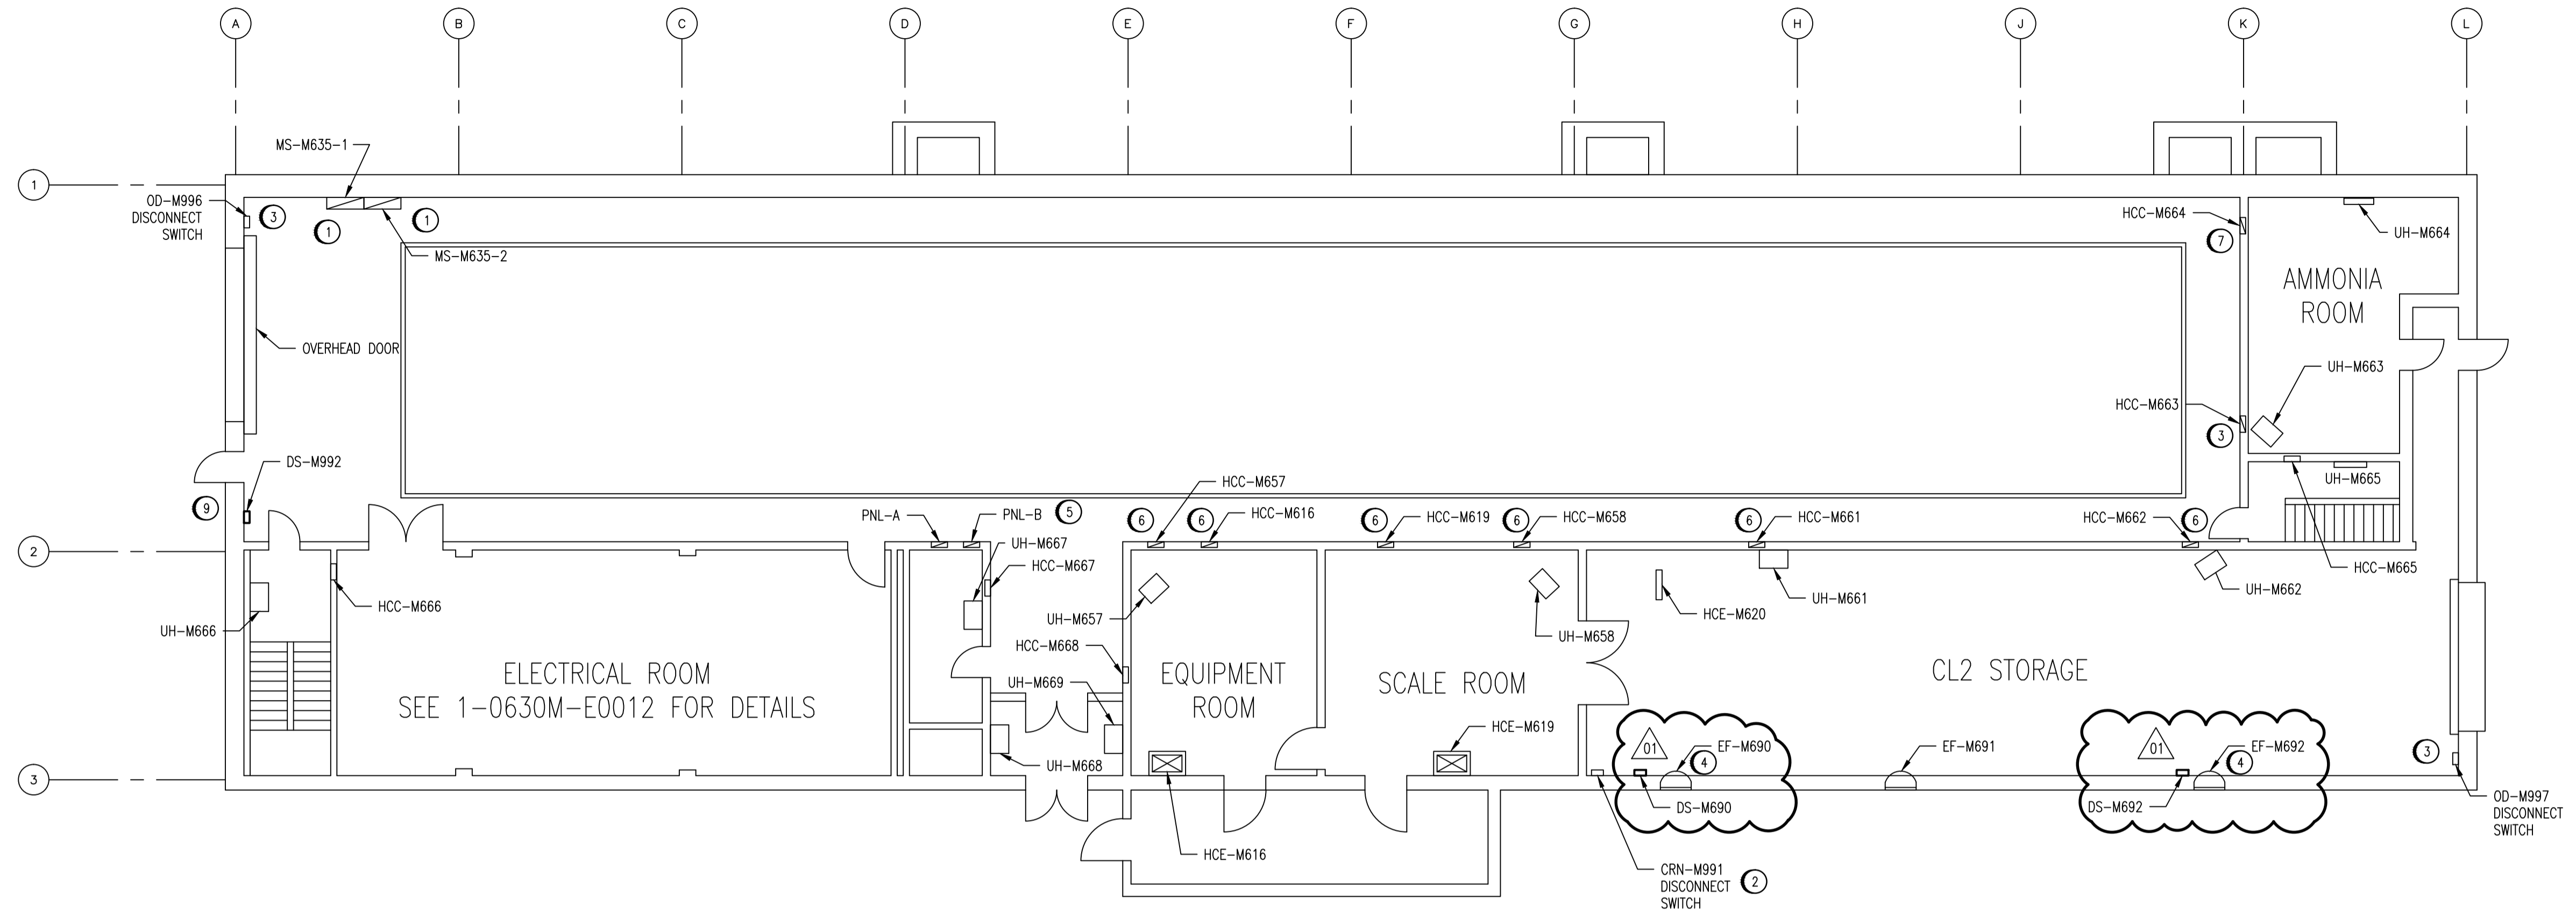

MAIN FLOOR - ELEV. 232.260
SCALE: 1 : 100

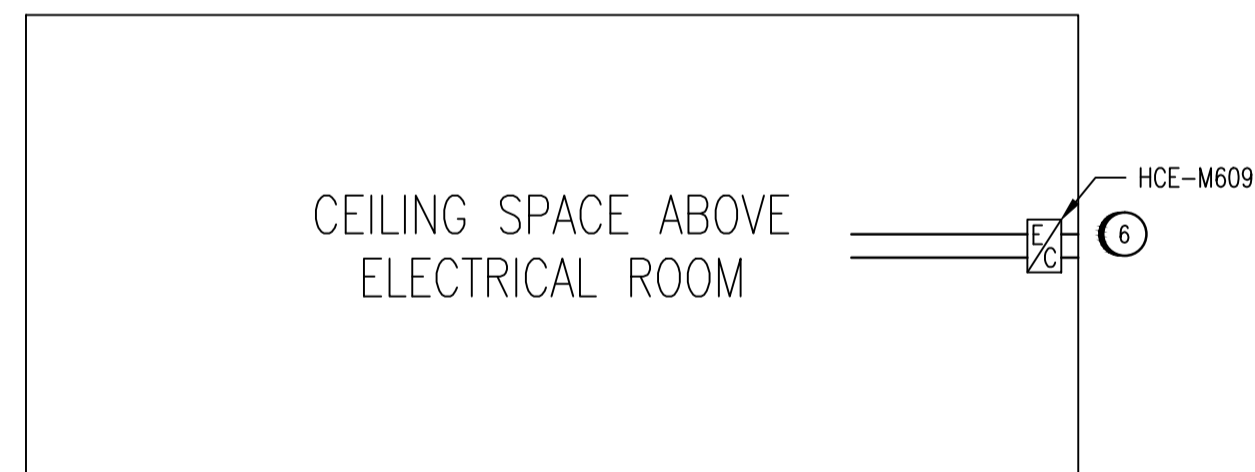

ELECTRICAL ROOM CEILING SPACE - ELEV. 235.967
SCALE: 1 : 100

SPECIFIC NOTES:

- ① REUTILIZE AND EXTEND EXISTING CONDUIT.
- ② CONNECT EXISTING WIRING TO JB-M1 AT MEZZANINE LEVEL. RE-FEED LOAD VIA JB-M1.
- ③ CONNECT EXISTING WIRING TO JB-M2 AT MEZZANINE LEVEL. RE-FEED LOAD VIA JB-M2.
- ④ REWIRE UTILIZING TECK CABLE TO NEW CABLE TRAY ON MEZZANINE LEVEL. REPLACE EXISTING DISCONNECT SWITCH. PROVIDE NEW FLOOR PENETRATION TO FACILITATE ROUTING OF CABLE. FIRESTOP FLOOR PENETRATION.
- ⑤ REPLACE PNL-B INTERIOR. LABEL AND RETERMINATE ALL LOADS.
- ⑥ REWIRE UTILIZING NEW TRAY CABLE IN EXISTING CONDUIT DOWN TO CABLE TRAY.
- ⑦ UNIT HEATER DISCONTINUED. CONNECT EXISTING WIRING TO JB-M1.
- ⑧ ROUTE TECK CABLE TO MCC VIA SURFACE MOUNTED UNISTRUT AND CABLE TRAY.
- ⑨ REPLACE DISCONNECT SWITCH AND WIRE VIA TECK CABLE FROM TRAY BELOW.

1-0630M-E0029	PANEL SCHEDULE AND DETAILS, DP-M2
1-0630M-E0028	MCC SCHEDULES, MCC-M1 AND MCC-M3E
DRAWING NUMBER	REFERENCE DRAWINGS



NO.	REVISIONS	DATE	DESIGN	CHECK
01	ADDENDUM 1, BID OPP. 490-2012	2012/08/14	BJC	CJR
00	ISSUED FOR TENDER, BID OPP. 490-2012	2012/07/23	VE	CJR

SNC-LAVALIN INC.
148 Nature Park Way
Winnipeg, MB, Canada R3P 0X7
204-786-8080

DESIGNED BY: V. ELIMBAN
CHECKED BY: C. REIMER
DRAWN BY: S. FUNK/M. TUGADE
APPROVED BY: C. REIMER
SCALE: 1:100
DATE: 2010/10/06
CONSULTANT NO.: 508955-0000-47DD-0032

ENGINEER'S SEAL
PRELIMINARY
NOT TO BE
USED FOR
CONSTRUCTION

THE CITY OF WINNIPEG
Winnipeg
WATER AND WASTE DEPARTMENT

MACLEAN WATER PUMPING STATION
ELECTRICAL EQUIPMENT PLAN
MAIN FLOOR

CITY DRAWING NUMBER: 1-0630M-E0032
SHEET: 001
REV.: 01
SIZE: A1