


**LEGEND:**

————— EXISTING  
 ————— NEW WORK

ARC FLASH VALUES ARE PRELIMINARY AND WILL BE FINALIZED DURING CONSTRUCTION.

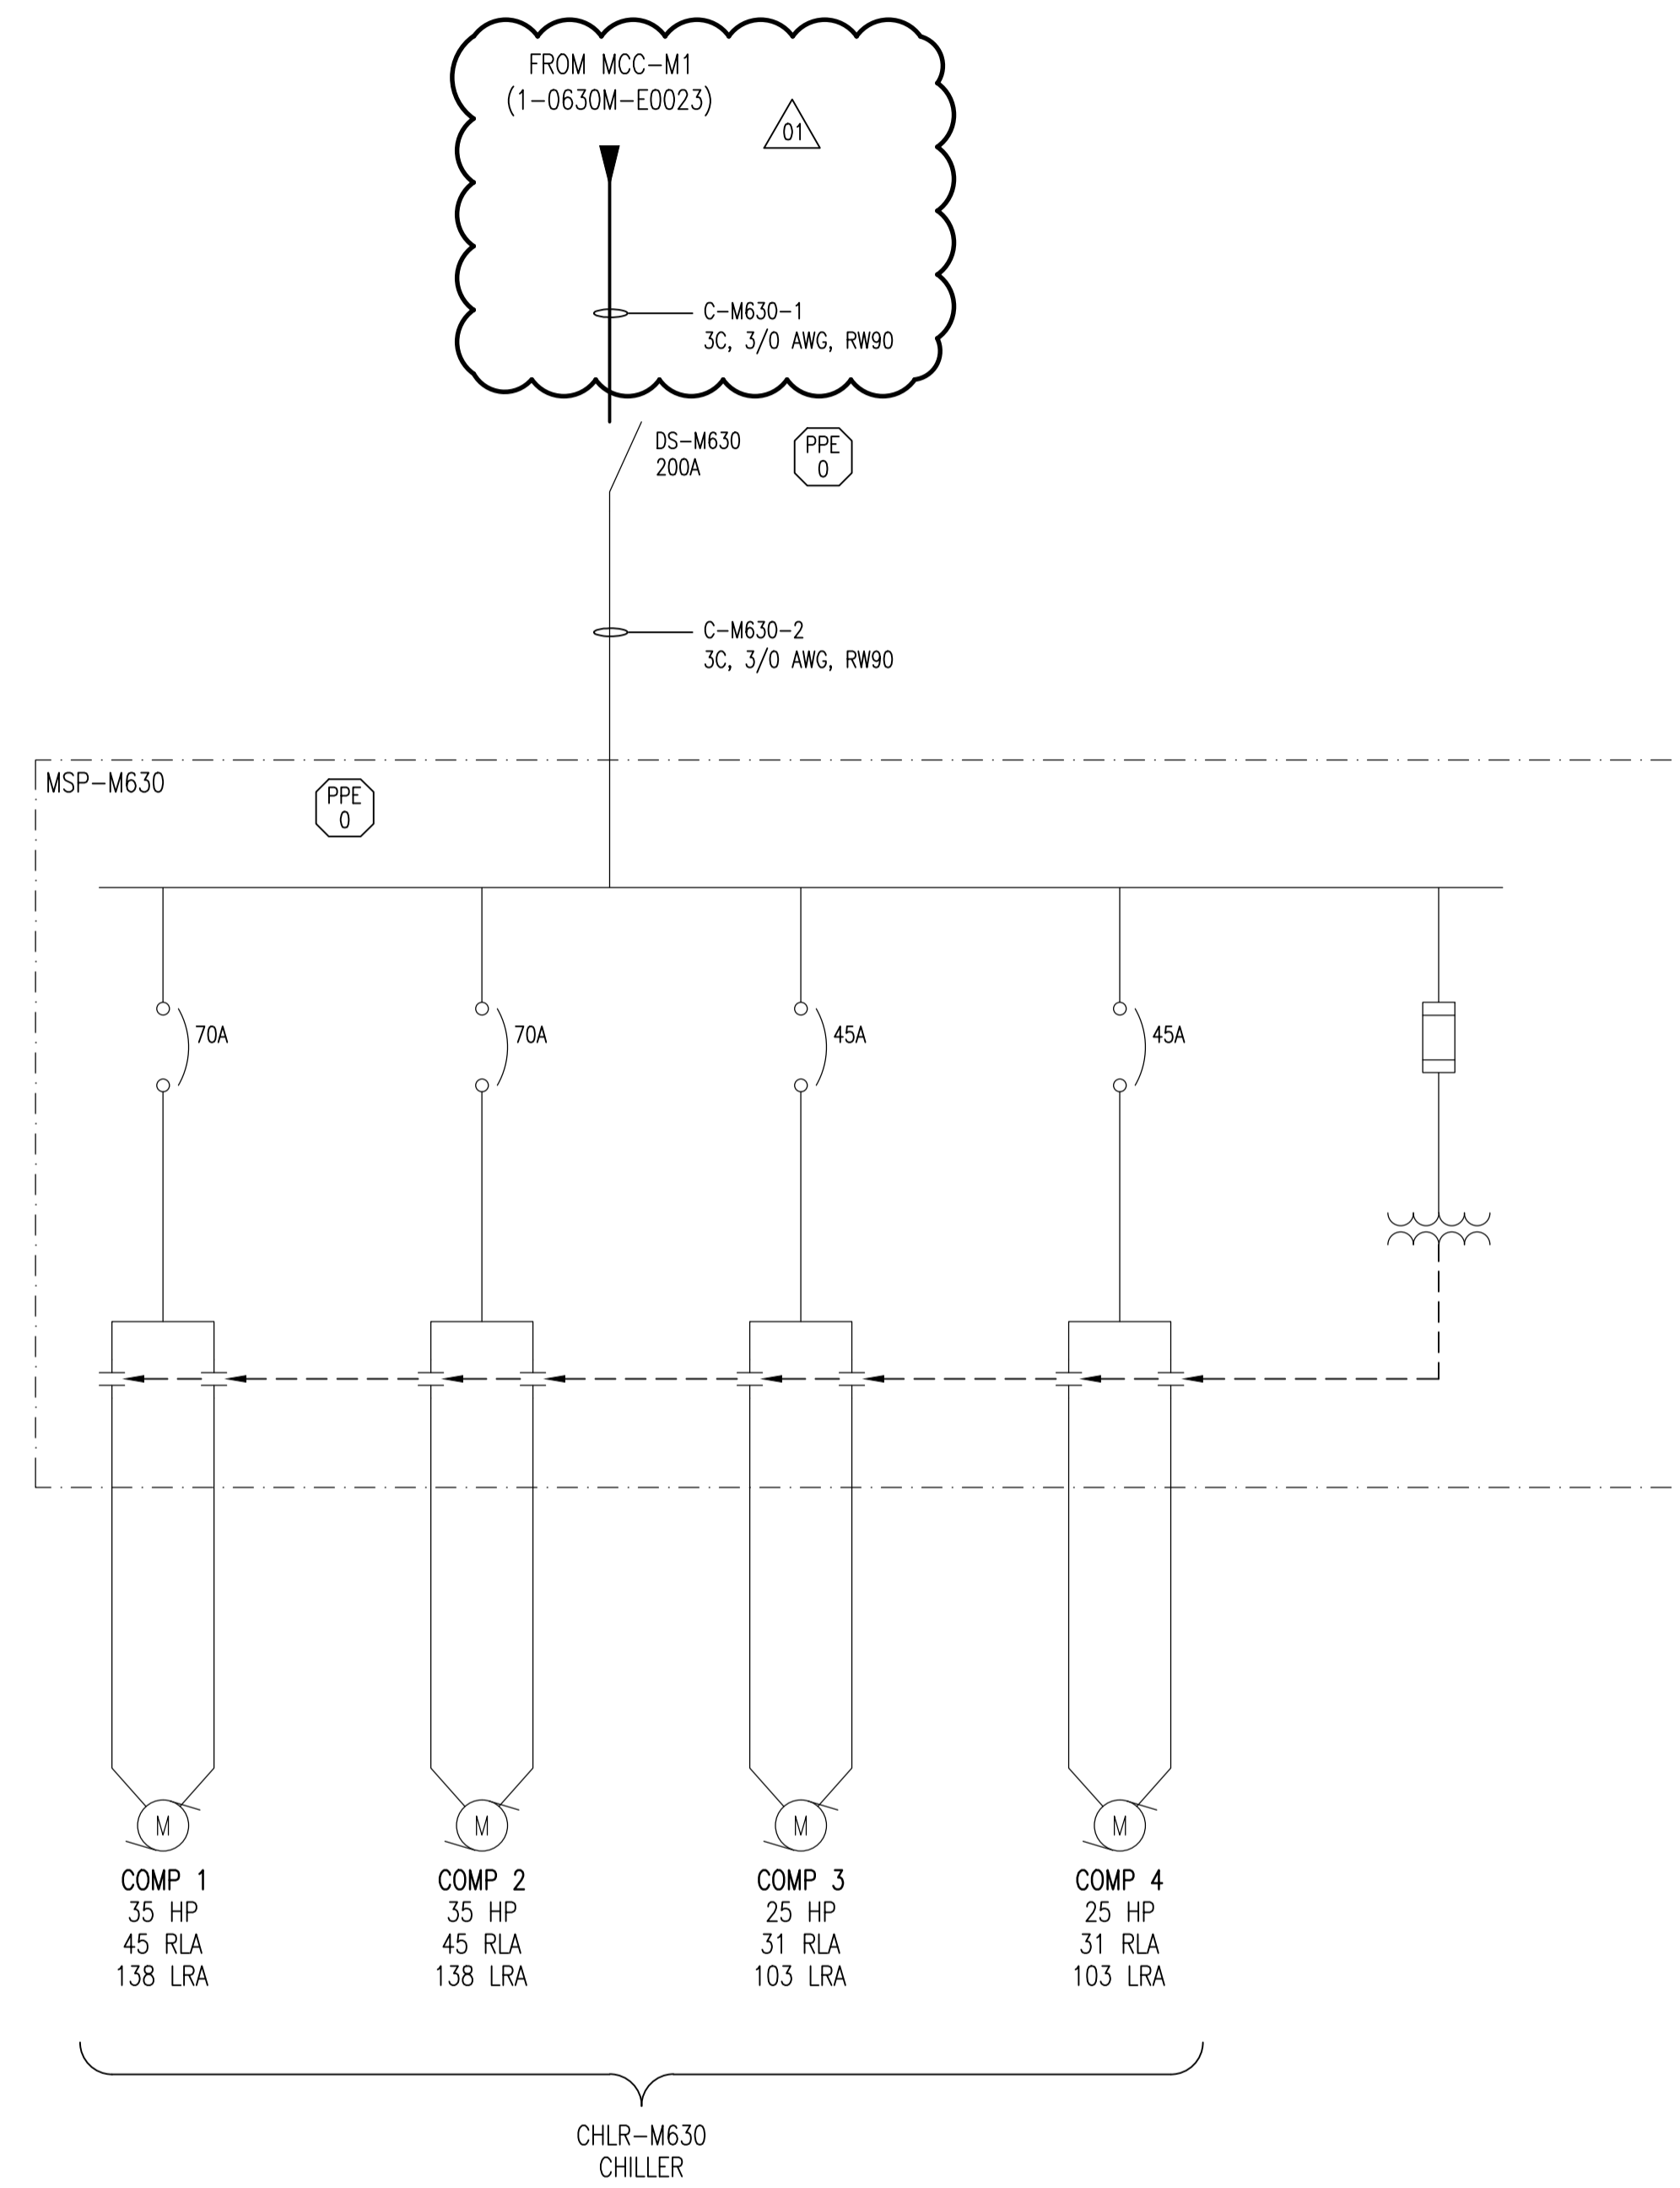

1-0630M-E0001	ELECTRICAL SINGLE LINE DIAGRAM LEGEND & DETAILS
DRAWING NUMBER	REFERENCE DRAWINGS



NO.	REVISIONS	DATE	DESIGN	CHECK
01	ISSUED FOR TENDER, BID OPP. 490-2012	2012/07/23	BJC	CJR
00	ISSUED FOR CITY USE	2011/05/30	BC	CJR

SNC-LAVALIN INC. 148 Nature Park Way Winnipeg, MB, Canada R3P 0X7 204-786-8080	
DESIGNED BY: B. CLEVEN	CHECKED BY: C. REIMER
DRAWN BY: S. FUNK	APPROVED BY: C. REIMER
SCALE: NTS	RELEASED FOR CONSTRUCTION BY: DATE: 2011/03/23
CONSULTANT NO.: 508955-0000-47DD-0021	

ENGINEER'S SEAL  
**PRELIMINARY**  
 NOT TO BE  
 USED FOR  
 CONSTRUCTION

THE CITY OF WINNIPEG WATER AND WASTE DEPARTMENT			
MACLEAN WATER PUMPING STATION			
ELECTRICAL SINGLE LINE DIAGRAM MISCELLANEOUS DISTRIBUTION			
CITY DRAWING NUMBER 1-0630M-E0021	SHEET 001	REV. 01	SIZE A1